

GUAM COMMUNITY COLLEGE FORENSIC DNA LAB


TANIGUCHI RUTH MAKIO ARCHITECTS
ARCHITECTS

DUENAS CAMACHO AND ASSOCIATES
CIVIL / STRUCTURAL CONSULTANT


EMC2 MECHANICAL, INC.
MECHANICAL CONSULTANT

EMCE CONSULTING ENGINEERS
ELECTRICAL CONSULTANT

LOCATION MAP

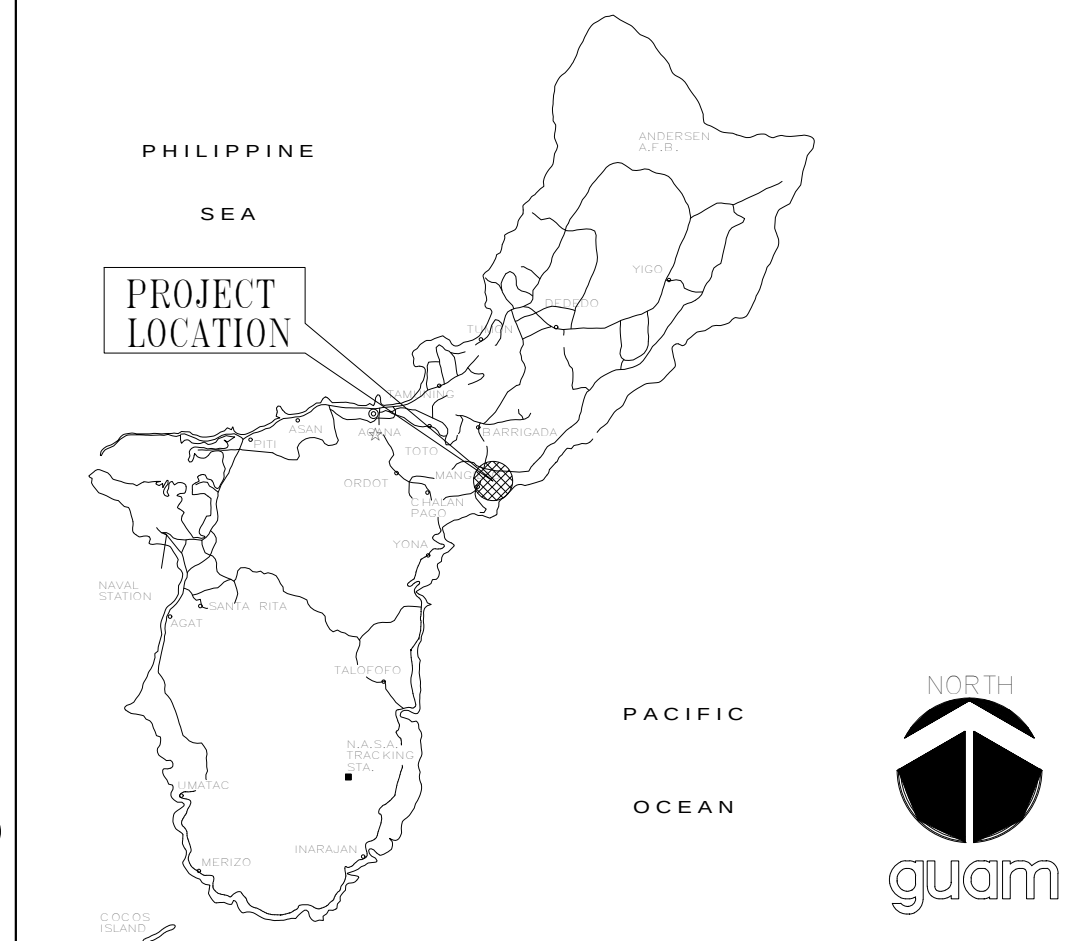

VICINITY MAP

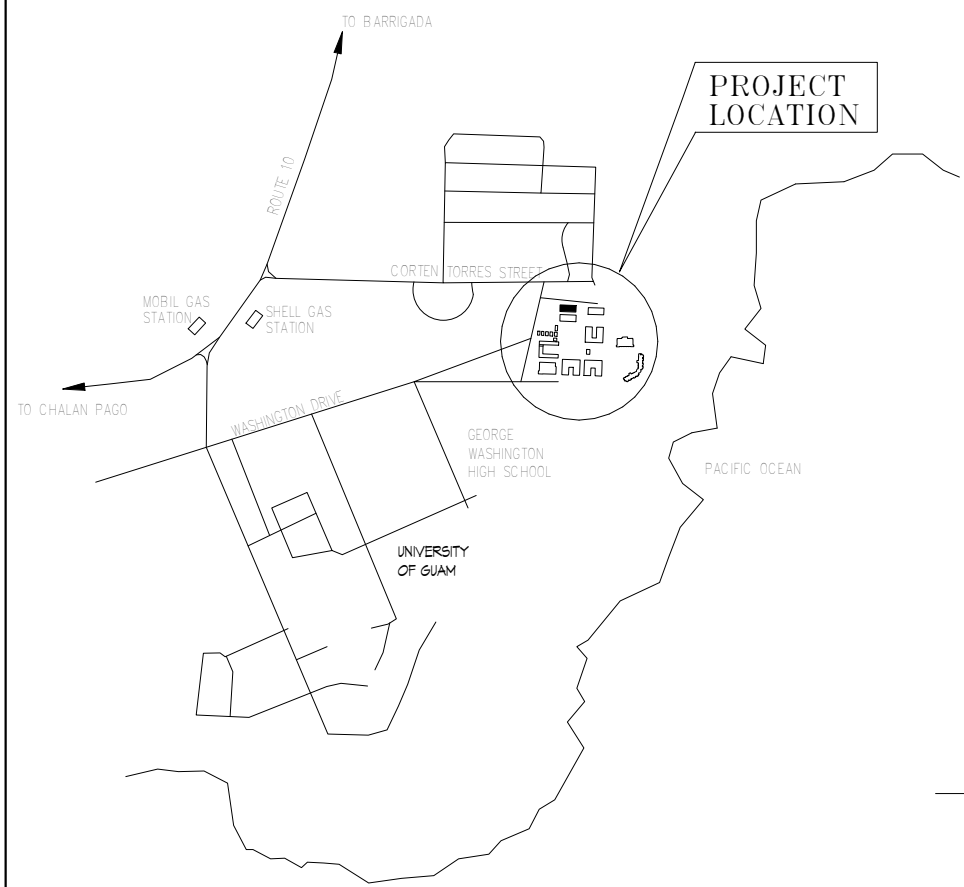

REVISIONS

No.	Description	Date

TRMA
Taniguchi Ruth Makio Architects
100 Cliff Business Center, P.O. Box EA, Agaña, GU 96910
Tel.: (671) 475-8772 • Fax: (671) 472-3381

Architecture
Planning
Interior Design

BID DOCUMENTS



I HEREBY CERTIFY THAT THIS PLAN WAS PREPARED
BY ME OR UNDER MY DIRECT SUPERVISION
DATE: _____

Project:
**GUAM COMMUNITY
COLLEGE
FORENSIC DNA LAB**

Title:
**TITLE SHEET,
LOCATION MAP, &
VICINITY PLAN**

Designed: **TRMA**
Drawn: **RM/TP**
Checked: **CTC**
Supv: **MM**
Scale:
Date: **02/23/12**
Project No. **1026** File
Drawing No.

T-1

Sheet No. _____ of _____

INDEX OF DRAWINGS

ARCHITECT		STRUCTURAL		ELECTRICAL	
T-1	TITLE SHEET, INDEX OF DRAWINGS, LOCATION MAP, VICINITY MAP	A1.1	SITE PLAN	S0.1	STRUCTURAL DESIGN CRITERIA, GENERAL NOTES AND DETAILS
T-2	ZONING AND CODE ANALYSIS	A2.1	FIRST FLOOR PLAN	S0.2	TYPICAL DETAILS
LEED 1	LEED PROJECT BOUNDARY	A3.1	FIRST FLOOR REFLECTED CEILING PLAN	S1.1	FOUNDATION PLAN
LEED 2	EXTRIOR RENDERING	A4.1	ROOF PLAN	S1.2	ROOF FRAMING PLAN
LEED 3	INTERIOR RENDERING	A5.1	BUILDING ELEVATIONS	S1.3	MAIN ROOF FRAM
CIVIL		A5.2	BUILDING SECTIONS	S2.1	SECTIONS
C-0	ENVIRONMENTAL PROTECTION SPECIFICATIONS, GENERAL NOTES, SURVEY NOTES, SYMBOLS AND ABBREVIATIONS	A5.3	BUILDING SECTIONS	S2.2	SECTIONS
C-1	EXISTING CONDITION AND REMOVAL PLAN	A5.4	BUILDING SECTIONS	S2.3	SECTIONS
C-2	GEOMETRIC SITE PLAN	A5.5	WALL SECTIONS	S2.4	SECTIONS
C-3	GRADING AND DRAINAGE PLAN	A5.6	WALL SECTIONS	S2.5	SECTIONS
C-4	UTILITY (WATER & SEWER) PLAN	A6.1	GCC CLASSROOM DETAIL PLAN	S2.6	SECTIONS
C-5	SECTION, SEWERLINE PROFILE, WATERLINE PROFILE & DRAINAGE LINE PROFILE	A6.2	CLASSROOM INTERIOR ELEVATIONS	S2.7	SECTIONS
C-6	DRIVEWAY PROFILES	A6.3	LAB DETAIL PLAN	S2.8	SECTIONS
C-7	SEWERLINE PROFILE & DRAINAGE LINE PROFILES	A6.4	LAB. INTERIOR ELEVATIONS	S2.9	SECTIONS
MD-1	MISCELLANEOUS DETAILS	A6.5	LAB. INTERIOR ELEVATIONS	S2.10	SECTIONS
MD-2	MISCELLANEOUS DETAILS	A6.6	LAB. INTERIOR ELEVATIONS	S3.1	COLUMN FOOTING DETAIL AND SCHEDULE TYPICAL COLUMN DETAILS
MD-3	MISCELLANEOUS DETAILS	A6.7	ADMIN/LIBRARY DETAIL PLAN AND INTERIOR ELEVATIONS	S4.1	WALL SCHEDULE, WALL FOOTING SCHEDULE AND
MD-4	MISCELLANEOUS DETAILS	A6.8	ADMIN. INTERIOR ELEVATIONS	S5.1	BEAM SCHEDULE AND DETAILS
MD-5	MISCELLANEOUS DETAILS	A6.9	RESTROOM DETAIL PLAN AND ELEVATIONS	S5.2	TYPICAL BEAM ELEVATIONS
MD-6	MISCELLANEOUS DETAILS	A6.10	CASEWORK DETAIL PLAN AND ELEVATIONS	M1.0	EQUIPMENT SCHEDULE, NOTES, LEGENDS
		A7.1	STAIR PLAN AND SECTIONS	M1.1	GROUND FLOOR COMMUNATION AND VENTILATION PLAN
		A7.2	GENERATOR DETAIL PLAN AND SECTIONS	M1.2	ROOF PLAN
		A7.3	COVERED WALKWAY DETAIL PLAN AND SECTIONS	M1.3	LONGITUDINAL SECTION, CROSS SECTION
		A8.1	ROOM FINISH SCHEDULE	M2.1	GROUND FLOOR AIR CONDITIONING AND VENTILATION PLAN
		A8.2	DOOR AND WINDOW SCHEDULE AND TYPES	M2.2	DDC CONTROL SYSTEM DIAGRAM
		A9.1	RAILING DETAILS	M2.3	PCU CONTROL/MONITOR SYSTEM DIAGRAM
		A9.2	ROOF DETAILS	M3.1	LABORATORY AC & VENTILATION SCHEMATIC
		A10.1	DOOR DETAILS	M3.2	LABORATORY ENVIRONMENTAL CONTROL SYSTEM DIAGRAM, CONTROL SYSTEM DIAGRAM
		A10.2	WINDOW DETAILS	M3.3	PCU 3A & 3B CONTROL / MONITOR SYSTEM DIAGRAM
		A10.3	CEILING DETAILS	M4.1	DETAILS
		A11.1	WALL DETAILS	M4.2	DETAILS
		A12.1	CASEWORK DETAILS		
		A13.1	SIGNAGE DETAILS		

TRMA
Taniguchi Ruth Makio Architects

Taniguchi Ruth Makio Architects
P.O. Box EA
Hagåtña, Guam 96932
Tel (671) 475-8772 Fax (671) 472-3381

DCA
DUEÑAS • CAMACHO
ASSOCIATES INC.

Dueñas Camacho & Associates, Inc.
238 E. Marine Corps Drive, Ste. 201, Diamond
Plaza, Hagatna, Guam 96910
Tel: (671) 477-7991 Fax: (671) 479-6315

EMC2
MECHANICAL, INC.

EMC2
565-A North marine Corps Drive,
Tamuning, Guam 96913
Tel: (671) 646-1558/5363 Fax: (671) 646-8606

emce
EMCE • Consulting Engineers

EMCE
Suite 208 Baltej Pavilion
Tamuning Guam 96931
Tel: (671) 649-0166/7 Fax: (671) 646-3623

IF SHEET IS LESS THAN 24" X 36"
REDUCED PRINT - USE GRAPHIC SCALES

[illegible]

BUILDING CLASSIFICATION - BASED ON INTERNATIONAL BUILDING CODE 2009

Section 1021

DESIGN WIND:

SYMBOLS


COLUMNLINE LETTER (IN ONE DIRECTION NUMBER IN OTHER DIRECTION)	SECTION SECTION IDENTIFICATION SHEET WHERE SECTION IS DRAWN	LOWER TYPE SKIP LETTERS	ROOM NUMBER
DOOR SYMBOL DOORMARK	DETAIL DETAIL IDENTIFICATION SHEET WHERE DETAIL IS DRAWN	INTERIOR ELEVATION INDICATOR	NEW FINISH GRADE DRAW AT 685 EXISTING GRADE SHOWN HORIZONTALLY (F.F.L. ELEV. = 241.00, TYP.)
WINDOW TYPE	STORAGE ROOM IDENTIFICATION KEY: ROOM NAME	MATCH LINE SHADED PORTION IS SITE CONSIDERED	WALL TYPE IDENTIFICATION
		REVISION CLOUD AROUND REVISION OPTIONAL	

ABBREVIATIONS


A.B.	ANCHOR BOLT	EQPT.	EQUIPMENT	MET.	METAL	SCHED.	SCHEDULE
A.C.	AIR CONDITION	E.W.C.	ELEC. WATER COOLER	MFR.	MANUFACTURER	SCR.	SCREEN
ACOUST.	ACOUSTICAL	EXP.	EXPANSION	MH.	MANHOLE	S.D.	SOAP DISPENSER
A.D.	AREA DRAIN	EXPO.	EXPOSED	MIN.	MINIMUM	SECT.	SECTION
ADJ.	ADJUSTABLE	EXST.	EXISTING	MIR.	MIRROR	SH.	SHELF
ADJA.	ADJACENT	EXT.	EXTERIOR	MISC.	MISCELLANEOUS	SHR.	SHOWER
AGGR.	AGGREGATE			M.O.	MASONRY OPENING	SHT.	SHEET
AL.	ALUMINUM	F.A.	FIRE ALARM	MTD.	MOUNTED	SIM.	SIMILAR
ALT.	ALTERNATE	F.B.	FLAT BAR	MTG.	MOUNTING	SL.	SLOPE
APPROX.	APPROXIMATE	F.D.	FLOOR DRAIN	MUL.	MULLION	SLDG.	SLIDING
ARCH.	ARCHITECTURAL	FDN.	FOUNDATION			S.N.D.	SANITARY NAPKIN DISPENSERY
ASPH.	ASPHALT	F.E.	FIRE EXTINGUISHER	N.	NORTH	S.N.R.	SANITARY NAPKIN RECEPTACLE
		F.E.C.	FIRE EXTING. CAB.	N.I.C.	NOT IN CONTRACT	SPEC.	SPECIFICATION
BD.	BOARD	F.H.C.	FIRE HOSE CABINET	NO. OR #	NUMBER	SQ.	SQUARE
BLDG.	BUILDING	FIN.	FINISH	NOM.	NOMINAL	S.STL.	STAINLESS STEEL
BLK.	BLOCK	FL.	FLOOR	N.T.S.	NOT TO SCALE	S.SK.	SERVICE SINK
BLKG.	BLOCKING	FLASH.	FLASHING			STA.	STATION
BM.	BEAM	FLDG.	FOLDING	OA.	OVERALL	STD.	STANDARD
BOT.	BOTTOM	FLUOR.	FLUORESCENT	OBS.	OBSOURE	STL.	STEEL
BRKT.	BRACKET	F.O.C.	FACE OF CONCRETE	O.C.	ON CENTER	STOR.	STORAGE
		F.O.F.	FACE OF FINISH	O.D.	OUTSIDE DIAMETER (DIM.)	STR.	STRUCTURAL
CAB.	CABINET	F.O.S.	FACE OF STUDS	O.F.C.I.	OWNER FURNISHED	SURR.	SURROUND
CA.TV.	CABLE TELEVISION	FFRF.	FIREPROOF		CONTRACTOR INSTALLED	SUSP.	SUSPENDED
C.B.	CATCH BASIN	FR.	FRAME	OFF.	OFFICE	SYM.	SYMMETRICAL
CEM.	CEMENT	F.S.	FULL SIZE	OPNG.	OPENING		
CER.	CERAMIC	FT.	FOOT OR FEET	OPP.	OPPOSITE		
C.I.	CAST IRON	FTG.	FOOTING			T.B.	TOWEL BAR
CLG.	CEILING	FURR.	FURRING			T.C.	TOP OF CURB
CLKG.	CAULKING	FURR.CHAN.	FURRING CHANNEL	PG.	PIECE	TEL.	TELEPHONE
CLO.	CLOSET	FUT.	FUTURE	PL.	PLATE	TEMP.	TEMPERED
CLR.	CLEAR			P.LAM.	PLASTIC LAMINATE	THK.	THICK
C.M.U.	CONCRETE MASONRY UNITS	GA.	GAUGE	PLAS.	PLASTER	THR.	THRESHOLD
CNTR.	COUNTER	GALV.	GALVANIZED	PLBG.	PLUMBING	T.P.	TOP OF PAVEMENT
C.O.	CLEAN OUT	G.B.	GRAB BAR	PLYWD.	PLYWOOD	T.P.D.	TOILET PAPER DISPENSER
COL.	COLUMN	G.I.	GALVANIZED IRON	PNL.	PANEL	T.P.H.	TOILET PAPER HOLDER
CONC.	CONCRETE	GL.	GLASS	PR.	PAIR	TRD.	TREAD
COND.	CONDITION	GND.	GROUND	PRCST.	PRECAST	T.W.	TOP OF WALL
CONN.	CONNECTION	GR.	GRADE	PT.	POINT	TYP.	TYPICAL
CONSTR.	CONSTRUCTION	GYP.	GYP SUM	P.T.D.	PAPER TOWEL DISPENSER		
CONT.	CONTINUOUS	GYP.BD.	GYP SUM BOARD	P.T.D./R.	COMBINATION PAPER TOWEL DISPENSER & RECEPTACLE	UNF.	UNFINISHED
CONTR.	CONTRACTOR			PTN.	PARTITION	U.O.N.	UNLESS OTHERWISE NOTED
CORR.	CORRIDOR	H.	HIGH	P.T.R.	PAPER TOWEL RECEPTACLE		
C.R.M.	CONCRETE RUBBLE MASONRY	H.C.	HOLLOW CORE			UR.	URINAL
CTR.	CENTER	HDWD.	HARDWOOD			VCT.	VINYL COMPOSITION TILE
CTSK.	COUNTERSINK	HDWE.	HARDWARE	Q.T.	QUARRY TILE	VERT.	VERTICAL
		H.M.	HOLLOW METAL			VEST.	VESTIBULE
D.	DEEP OR DEPTH	HORIZ.	HORIZONTAL				
D.A.	DOUBLE ACTING	HR.	HOUR	R.	RISER		
DBL.	DOUBLE	HGT.	HEIGHT	RAD.	RADIUS		
DEPT.	DEPARTMENT			R.D.	ROOF DRAIN		
DET.	DETAIL			REF.	REFERENCE		
D.F.	DRINKING FOUNTAIN	I.D.	INSIDE DIAMETER (DIM.)	REFR.	REFRIGERATOR		
DIA.	DIAMETER	INCL.	INCLUSIVE, INCLUDED OR INCLUDING	REINF.	REINFORCED OR REINFORCING		
DIM.	DIMENSION	INSUL.	INSULATION	REQ.	REQUIRED	W.	WEST
DISP.	DISPENSER	INT.	INTERIOR	RESIL.	RESILIENT	W.C.	WITH WATER CLOSET
DN.	DOWN			R.GTR.	REGISTER	WD.	WOOD
DR.	DOOR	JAN.	JANITOR	RM.	ROOM	WDW.	WINDOW
DS.	DOWNSPOUT	JST.	JOIST	R.O.	ROUGH OPENING	WH.	WATER HEATER
DWG.	DRAWING	JT.	JOINT	R.W.L.	RAIN WATER LEADER	W/O	WITH OUT
DWR.	DRAWER	KIT.	KITCHEN			WP.	WATERPROOFING
		K.O.	KNOCK-OUT			WR.	WATER RESISTANT
E.	EAST			SCF	SKIM COAT FINISH	WSCOT.	WAINSCOT
EA.	EACH	LAM.	LAMINATE	SFF	SMOOTH FORM FINISH	W.S.P.	WET STAND PIPE
E.J.	EXPANSION JOINT	LAV.	LAVATORY	S.	SOUTH	WT.	WEIGHT
EL.	ELEVATION	LT.	LIGHT	S.A.	SINGLE ACTING	W.W.M.	WELDED WIRE MESH
ELEC.	ELECTRICAL			S.C.	SOLID CORE		
EMER.	EMERGENCY	MAX.	MAXIMUM	S.C.D.	SEAT COVER DISPENSER		
ENCL.	ENCLOSURE	M.C.	MEDICINE CABINET				
E.P.B.	ELECTRICAL PANEL BOARD	MECH.	MECHANICAL				
EQ.	EQUAL	MEMB.	MEMBRANE				

IF SHEET IS LESS THAN 24" X 36"
REDUCED PRINT - USE GRAPHIC SCALES

Sheet No. _____ of _____

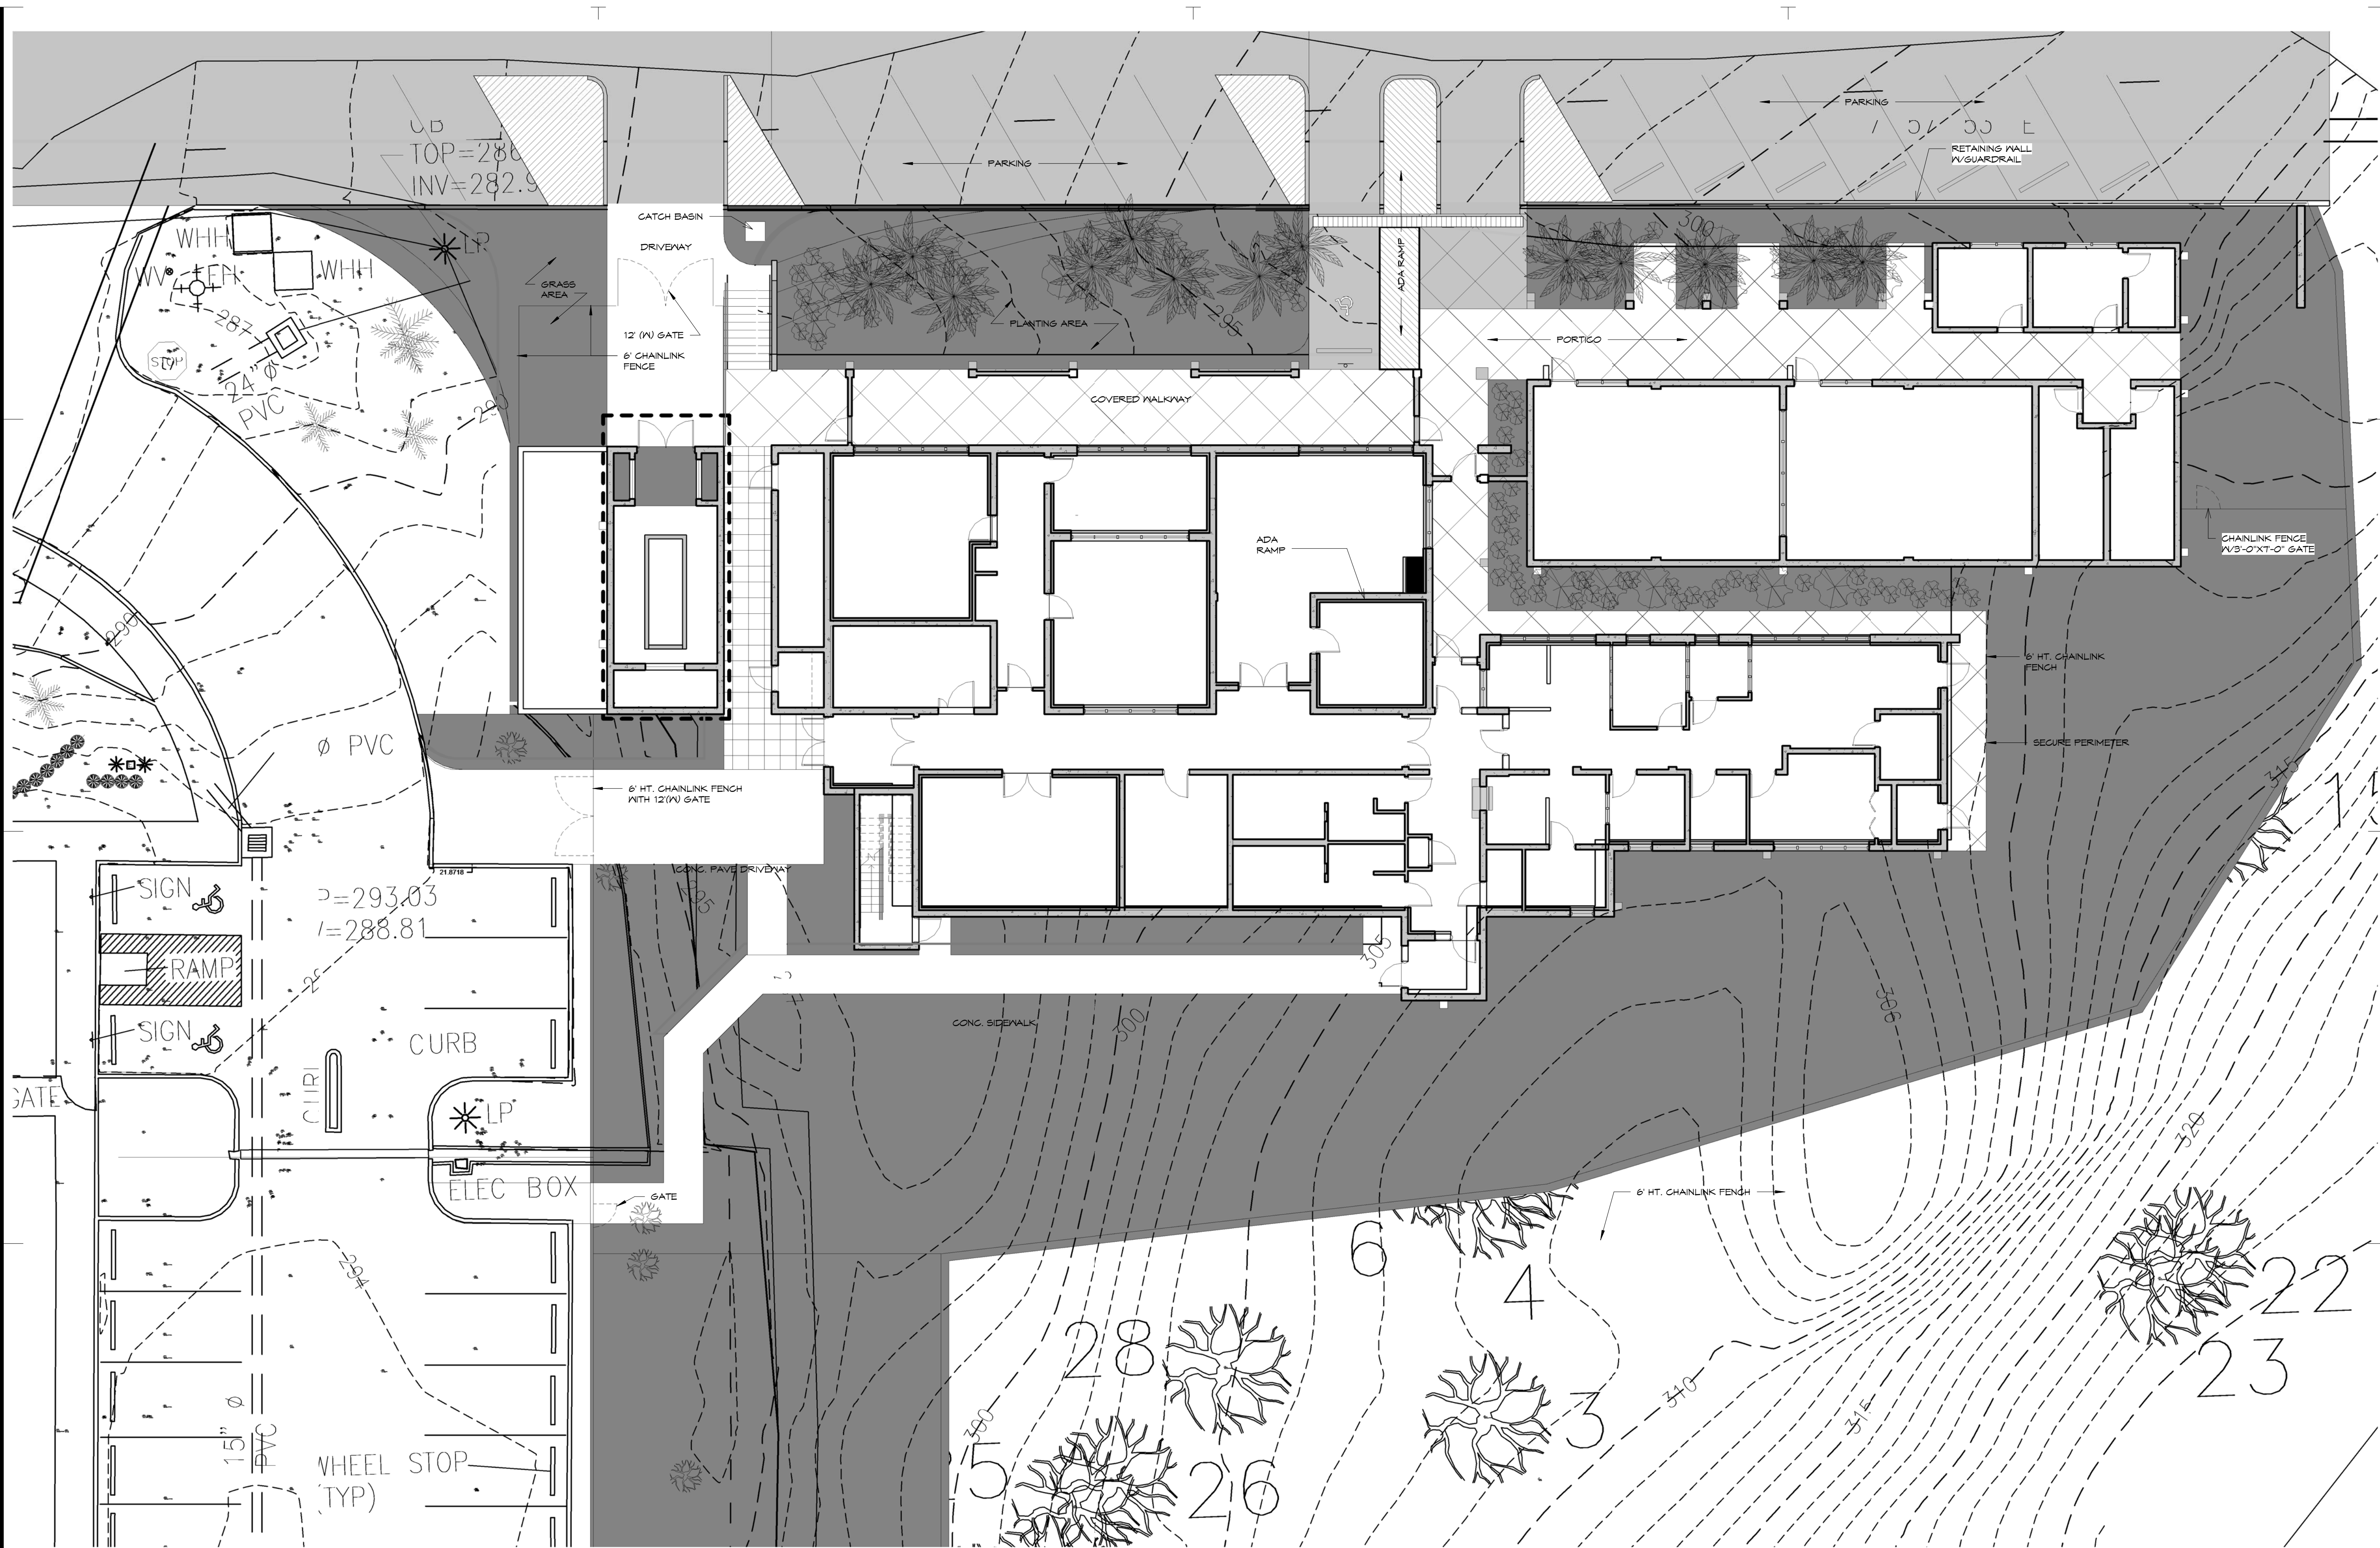

1 SITE PLAN
SCALE: 1" = 10'-0"

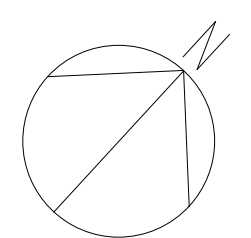

0 10' 20' 40'
SCALE: 1" = 20'
IF SHEET IS LESS THAN 24" X 36"
REDUCED PRINT - USE GRAPHIC SCALES

REVISIONS		
No.	Description	Date

TRMA
Taniguchi Ruth Makio Architects
100 Cliff Business Center, P.O. Box EA, Agaña, GU 96910
Tel.: (671) 475-8772 • Fax: (671) 472-3381

Architecture
Planning
Interior Design

BID
DOCUMENTS



I HEREBY CERTIFY THAT THIS PLAN WAS PREPARED
BY ME OR UNDER MY DIRECT SUPERVISION
DATE: _____

Project:
GUAM COMMUNITY
COLLEGE
FORENSIC DNA LAB

Title:
SITE PLAN

Designed: TRMA
Drawn: RM/TP
Checked: CTC
Supv: MM
Scale: 1" = 10'-0"
Date: 12/17/12
Project No. 1026
Drawing No.

A1.1
Sheet No. _____ of _____

LABORATORY REQUIREMENTS

1. PROVIDE FLOOR DRAINS AT ALL LAB SPACES, EMERGENCY EYEWASH LOCATIONS, AND STORAGE ROOMS.
2. PROVIDE EMERGENCY EYEWASH AT CORRIDORS.
3. PROVIDE BACKUP GENERATOR WITH UPS AND LINE CONDITIONER FOR POWER SUPPLY TO LABS.
4. PROVIDE REVERSE OSMOSIS FILTERED WATER SUPPLY TO LAB SINKS.
5. PROVIDE 36-IN HIGH X30-IN DEEP LAB COUNTERTOP SURFACES.
6. INSTALL POWER AND DATA OUTLETS AT EACH LABORATORY WALL 6-FT ON CENTER, ABOVE COUNTER TOP SURFACE.
7. PROVIDE 2 SETS OF POWER OUTLETS AT EACH EXTERIOR WALL OF THE LABORATORY BUILDING, MINIMUM.

REVISIONS		
No.	Description	Date

TRMA
Taniguchi Ruth Makio Architects
100 Cliff Business Center, P.O. Box EA, Agaña, GU 96910
Tel.: (671) 475-8772 • Fax: (671) 472-3381

Architecture
Planning
Interior Design

BID
DOCUMENTS



I HEREBY CERTIFY THAT THIS PLAN WAS PREPARED BY ME OR UNDER MY DIRECT SUPERVISION.


Project:
GUAM COMMUNITY
COLLEGE
FORENSIC DNA LAB

Title:
FIRST FLOOR PLAN


Designed: TRMA
Drawn: RM/TP
Checked: CTC
Supv: MAM
Scale: 1/8" = 1'-0"
Date: 12/17/12
Project No. 1026
Drawing No.

A2.1

Sheet No. of

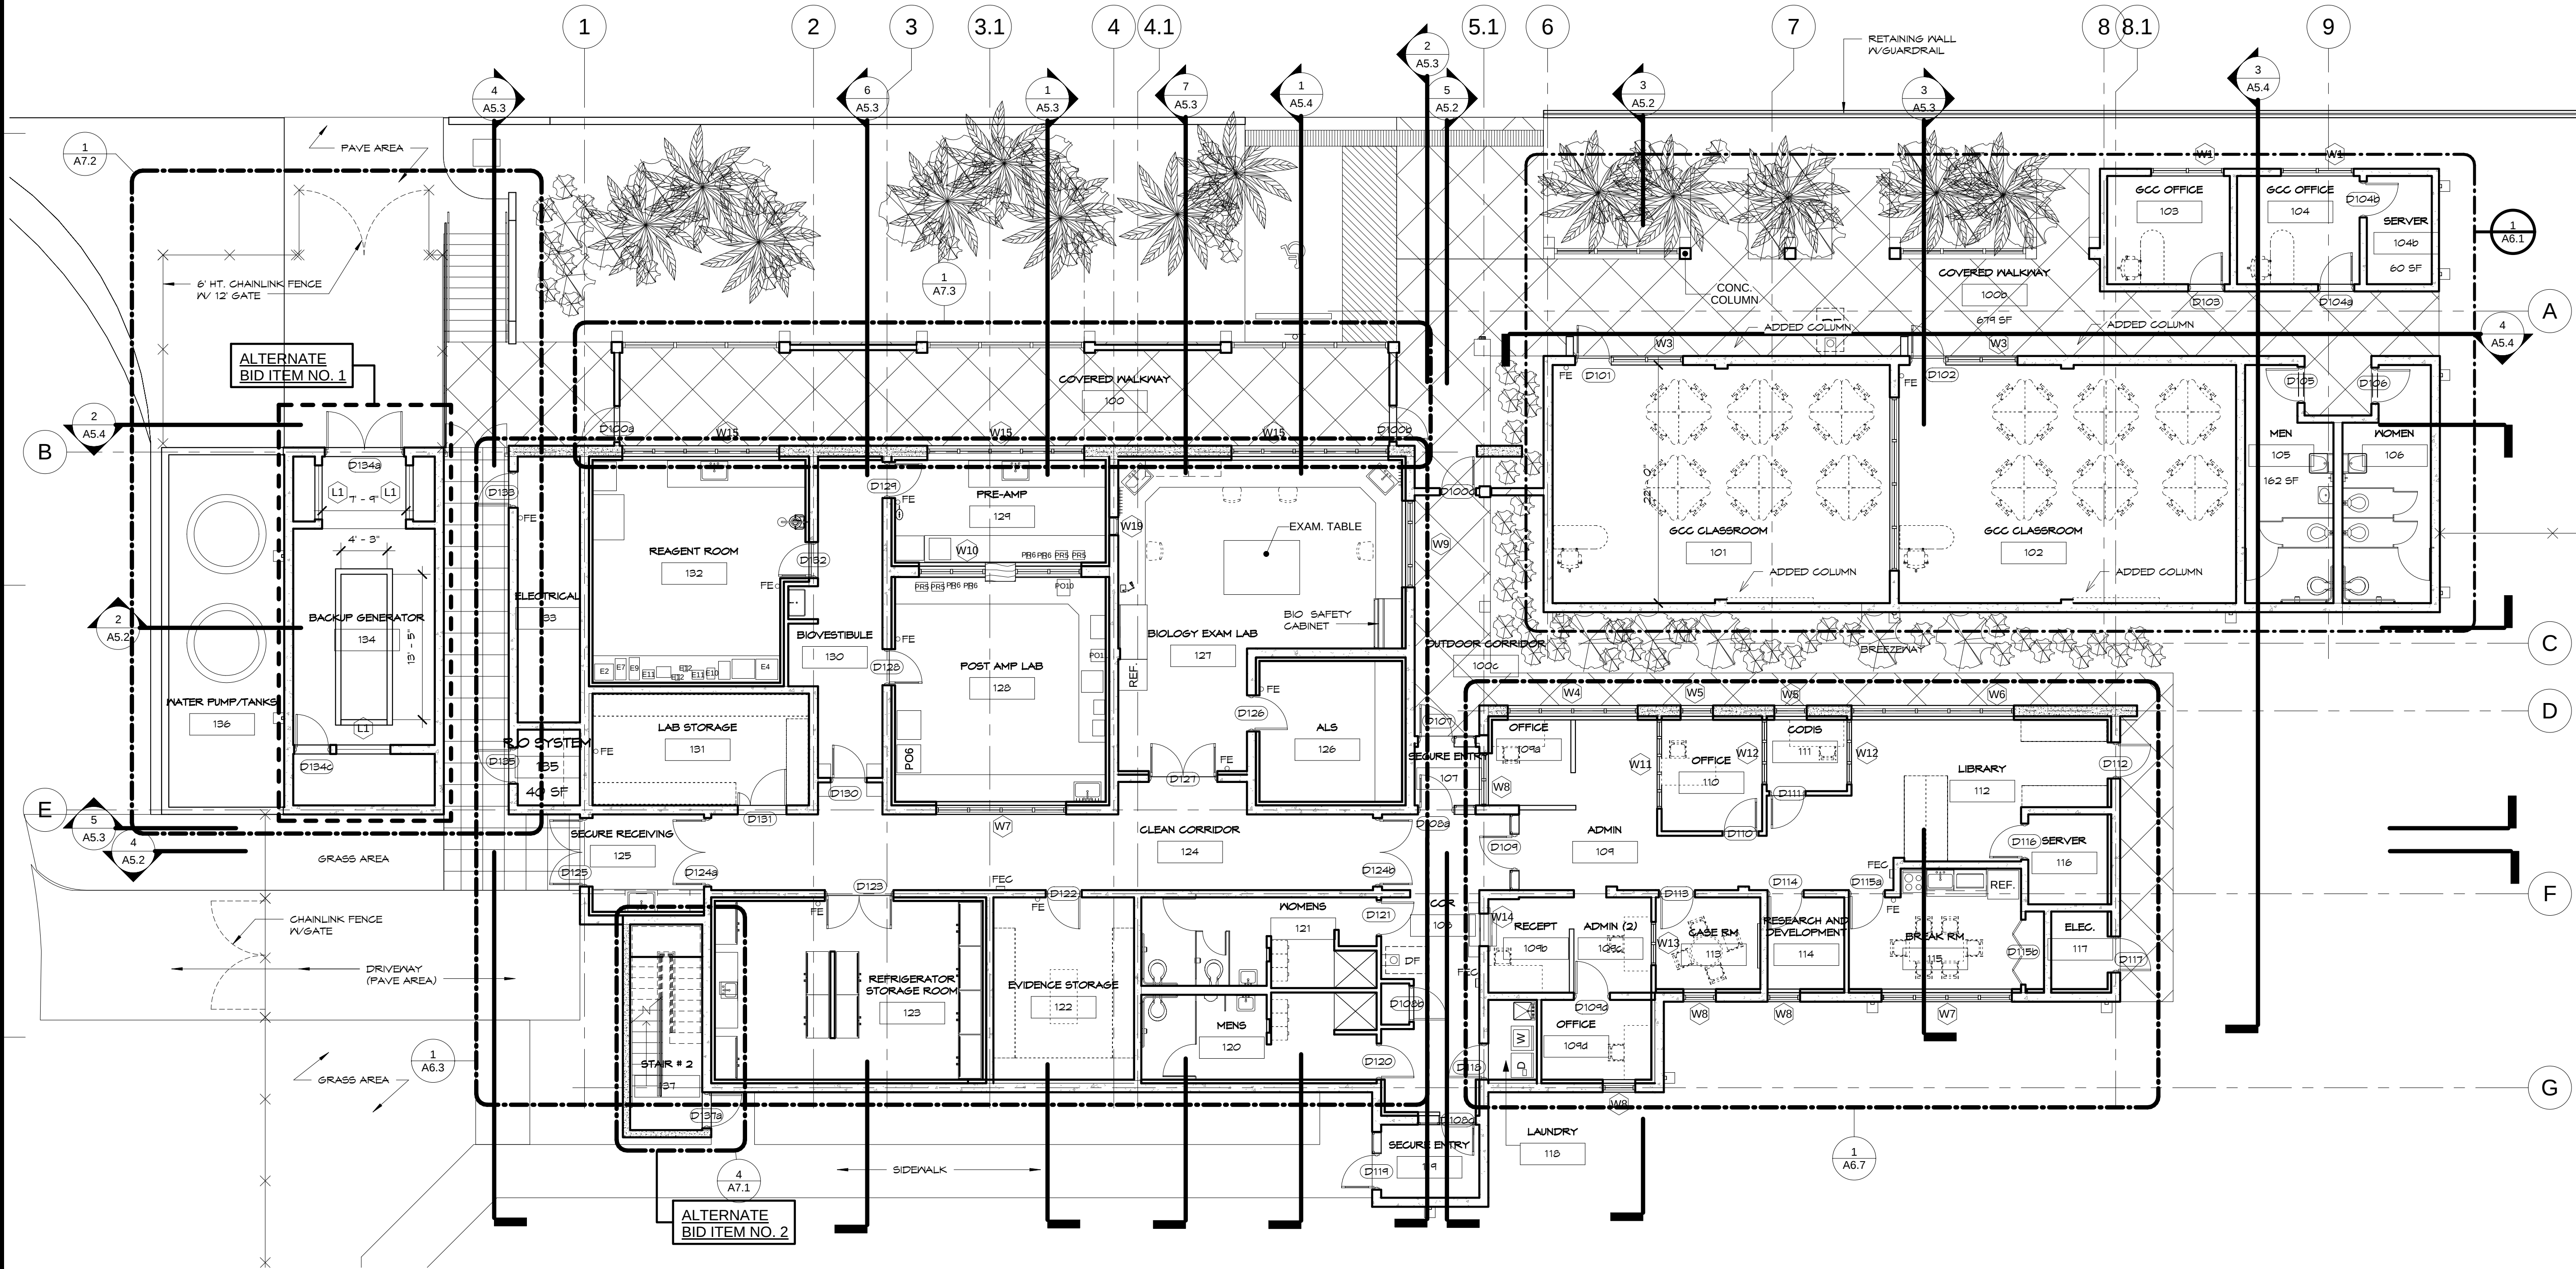


1 FIRST FLOOR PLAN
SCALE: 1/8" = 1'-0"

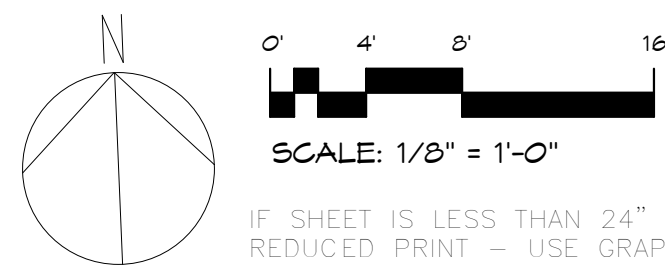


SYMBOL LIST

	LIGHT, FLUORESCENT RECESSED MOUNTED, SHADE INDICATES INTEGRAL EMERGENCY BATTERY PACK.
	FLUORESCENT CEILING SURFACE OR PENDANT MOUNTED
	DOWNLIGHT, CEILING RECESSED MOUNTED
	LIGHT, CEILING SURFACE MOUNTED
	LIGHT, WALL MOUNTED
	LIGHT, FLUORESCENT, WALL MOUNTED
	LIGHT, FLUORESCENT, STRIP TYPE
	EXIT SIGN LIGHT, SHADED QUADRANT INDICATES SIGN LETTERED FACE, CHEVRON TYPE DIRECTIONAL ARROWS, CEILING/WALL MOUNTED
	SUPPLY CEILING DIFFUSER (SEE M1.1)
	RETURN AIR REGISTER / EXHAUST AIR REGISTER (SEE M1.1)

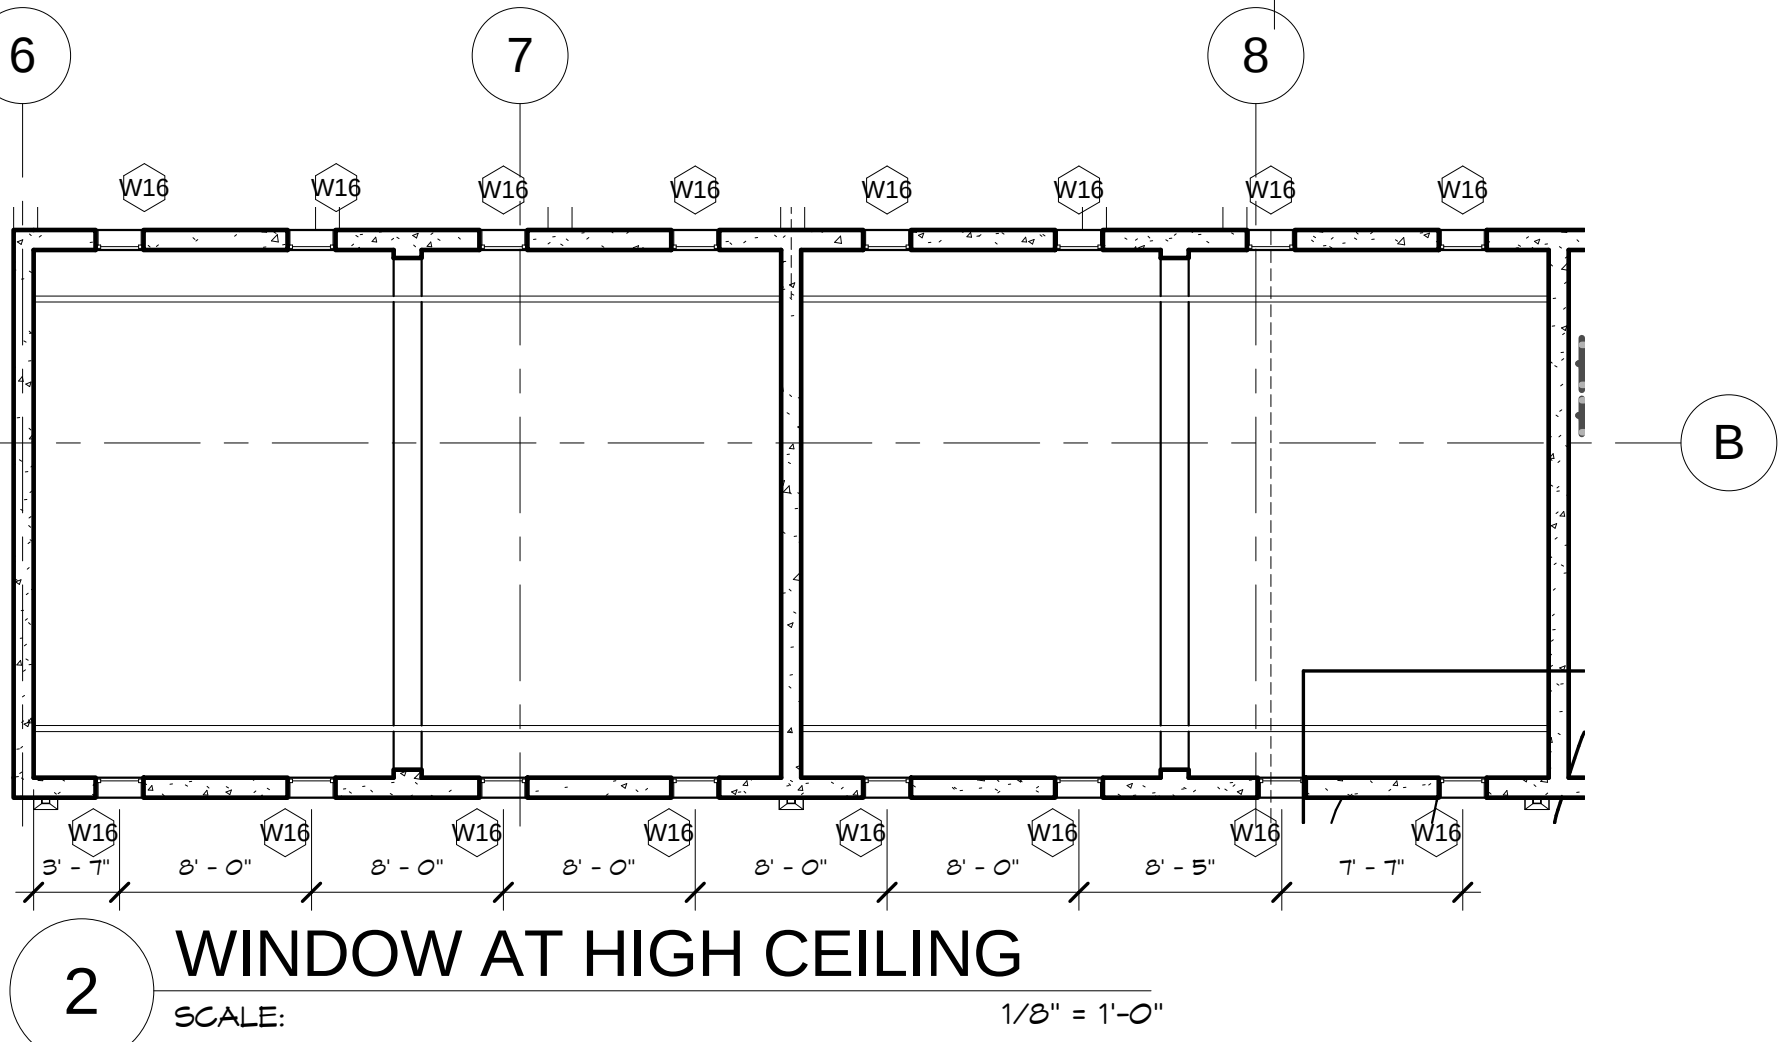


NOTES:
1. GYP. BD. CEILING @ 8'-0" AFF AT RESTROOMS.
2. ACT (FLAT) @ 8'-0" AFF.

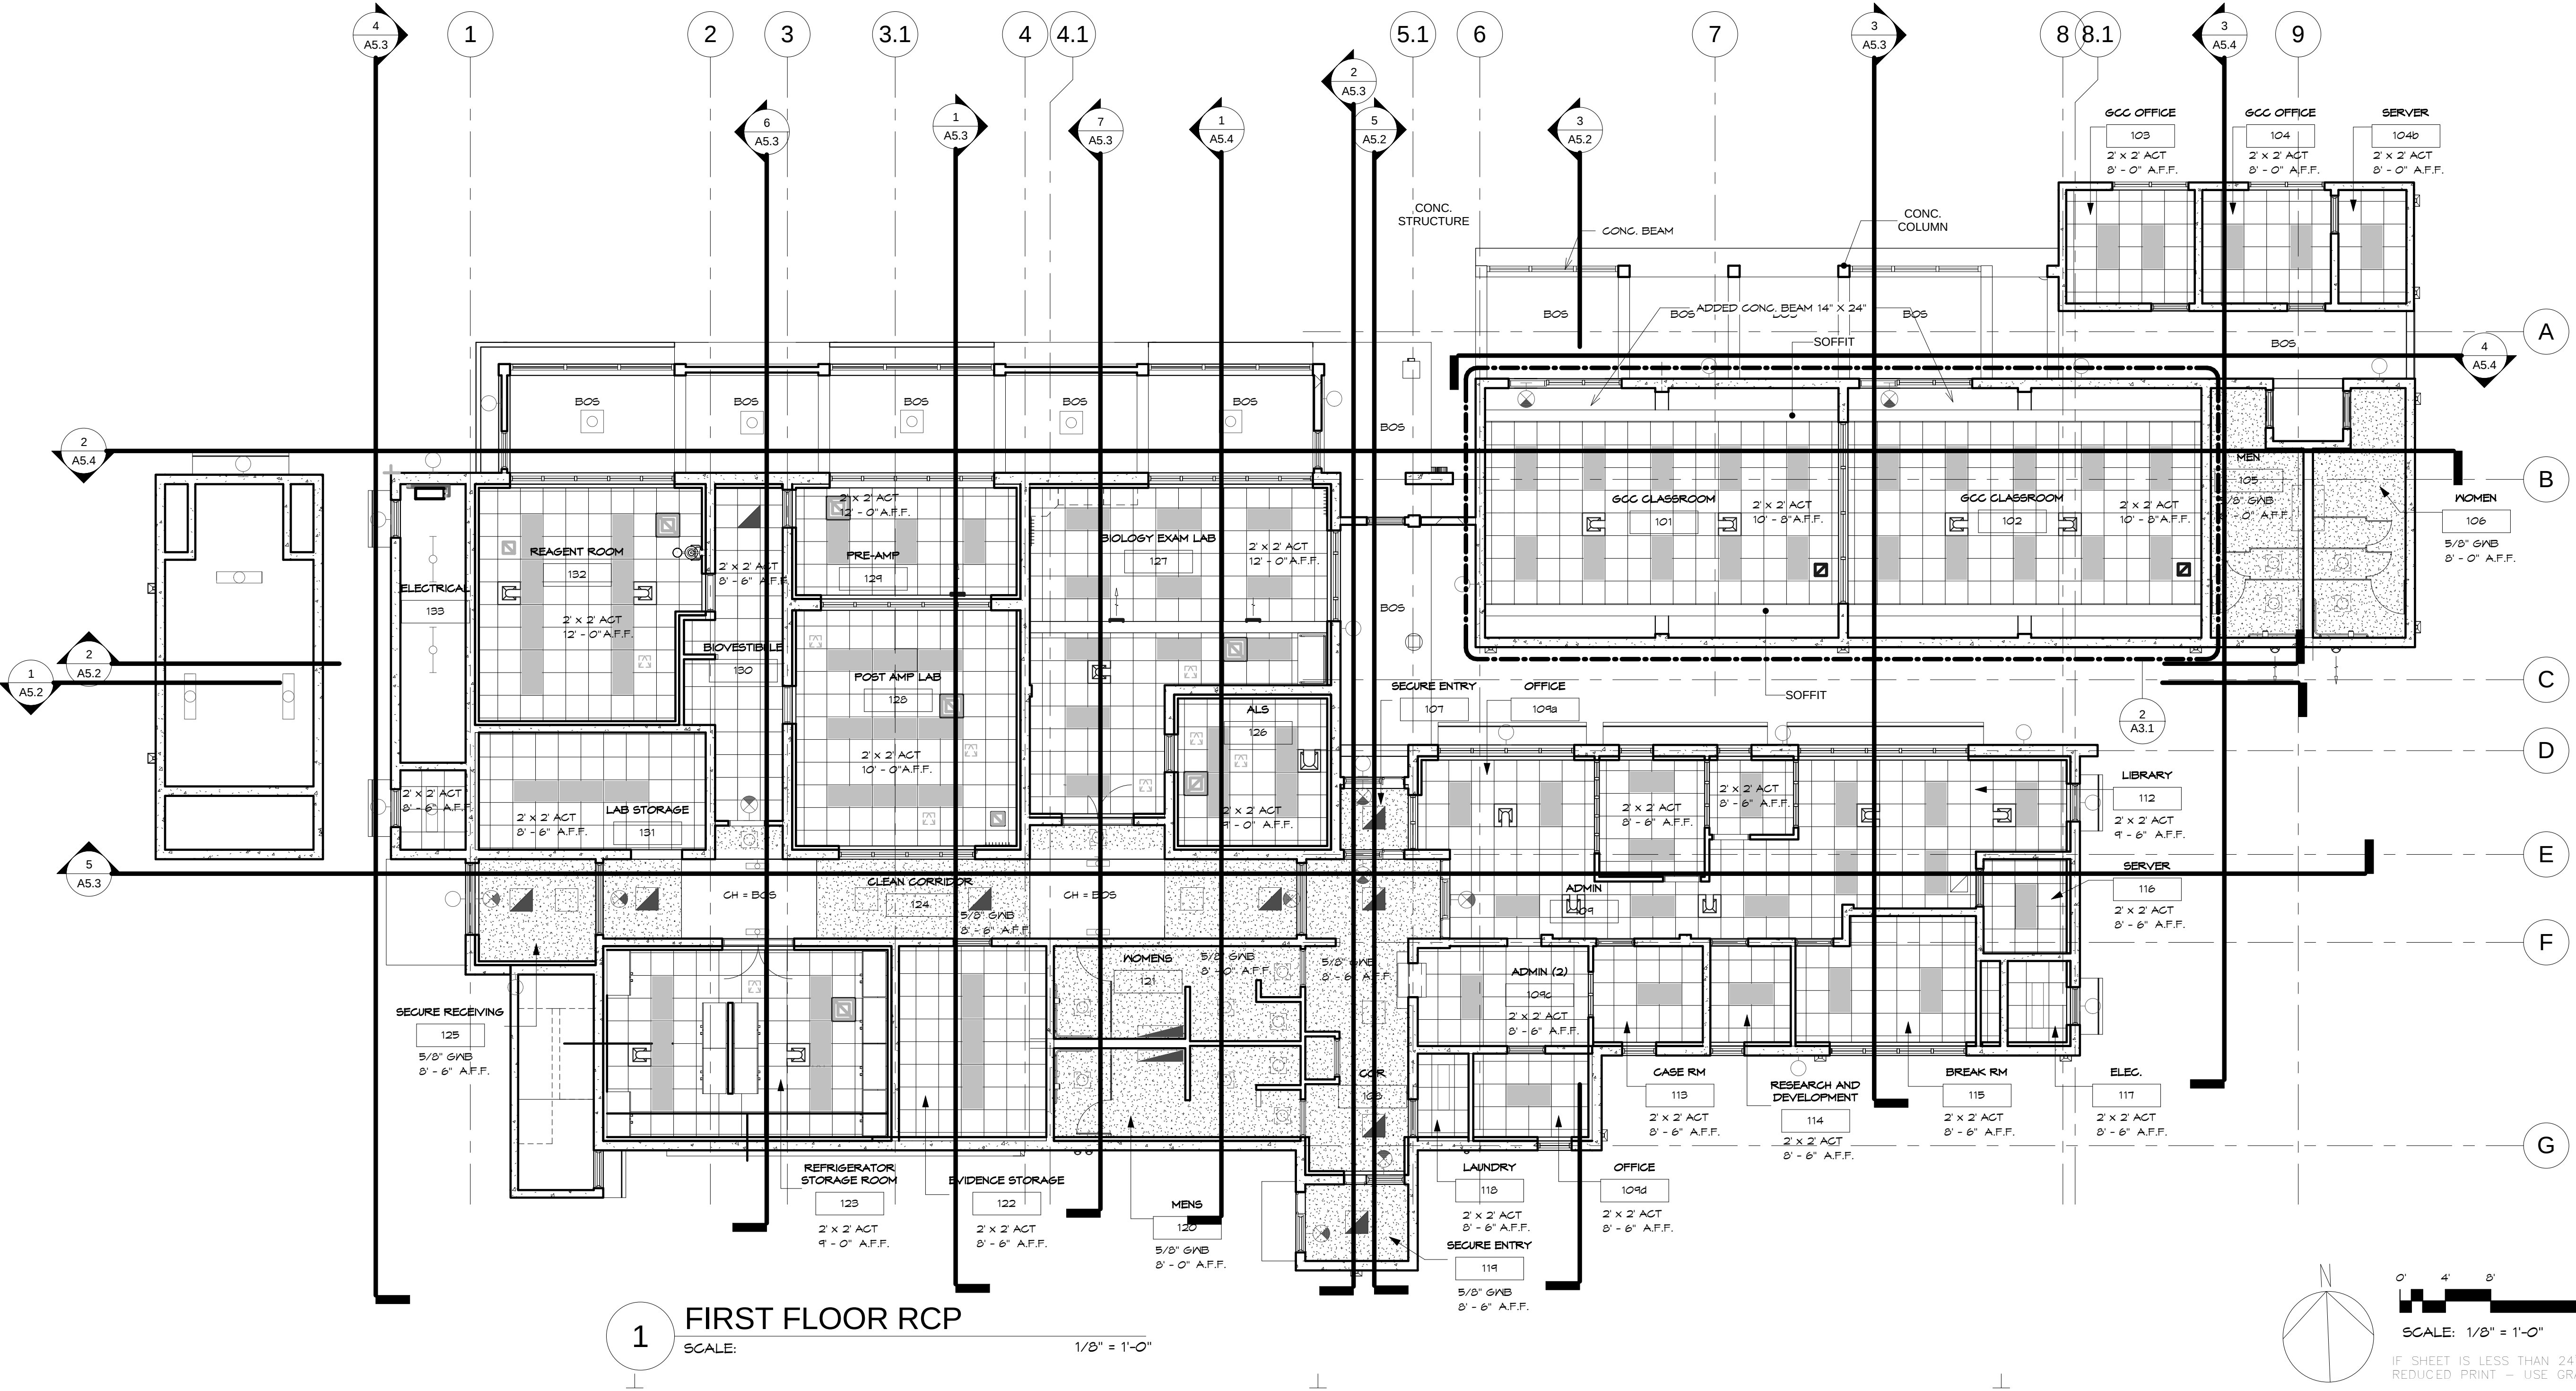

1 FIRST FLOOR RCP

SCALE: 1/8" = 1'-0"

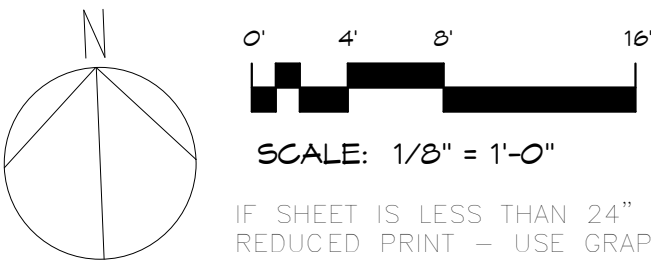

REVISIONS		
No.	Description	Date

TRMA

Taniguchi Ruth Makio Architects

100 Cliff Business Center, P.O. Box EA, Agaña, GU 96910
Tel.: (671) 475-8772 • Fax: (671) 472-3381

Architecture
Planning
Interior Design

BID DOCUMENTS

I HEREBY CERTIFY THAT THIS PLAN WAS PREPARED BY ME OR UNDER MY DIRECT SUPERVISION.

DATE: _____


Project:
GUAM COMMUNITY COLLEGE
FORENSIC DNA LAB

Title:
FIRST FLOOR REFLECTED CEILING PLAN


Designed: TRMA
Drawn: RM/TP
Checked: CTC
Supv: MAM
Scale: As indicated
Date: 12/17/12
Project No. 1026
Drawing No.

A3.1


Sheet No. _____ of _____

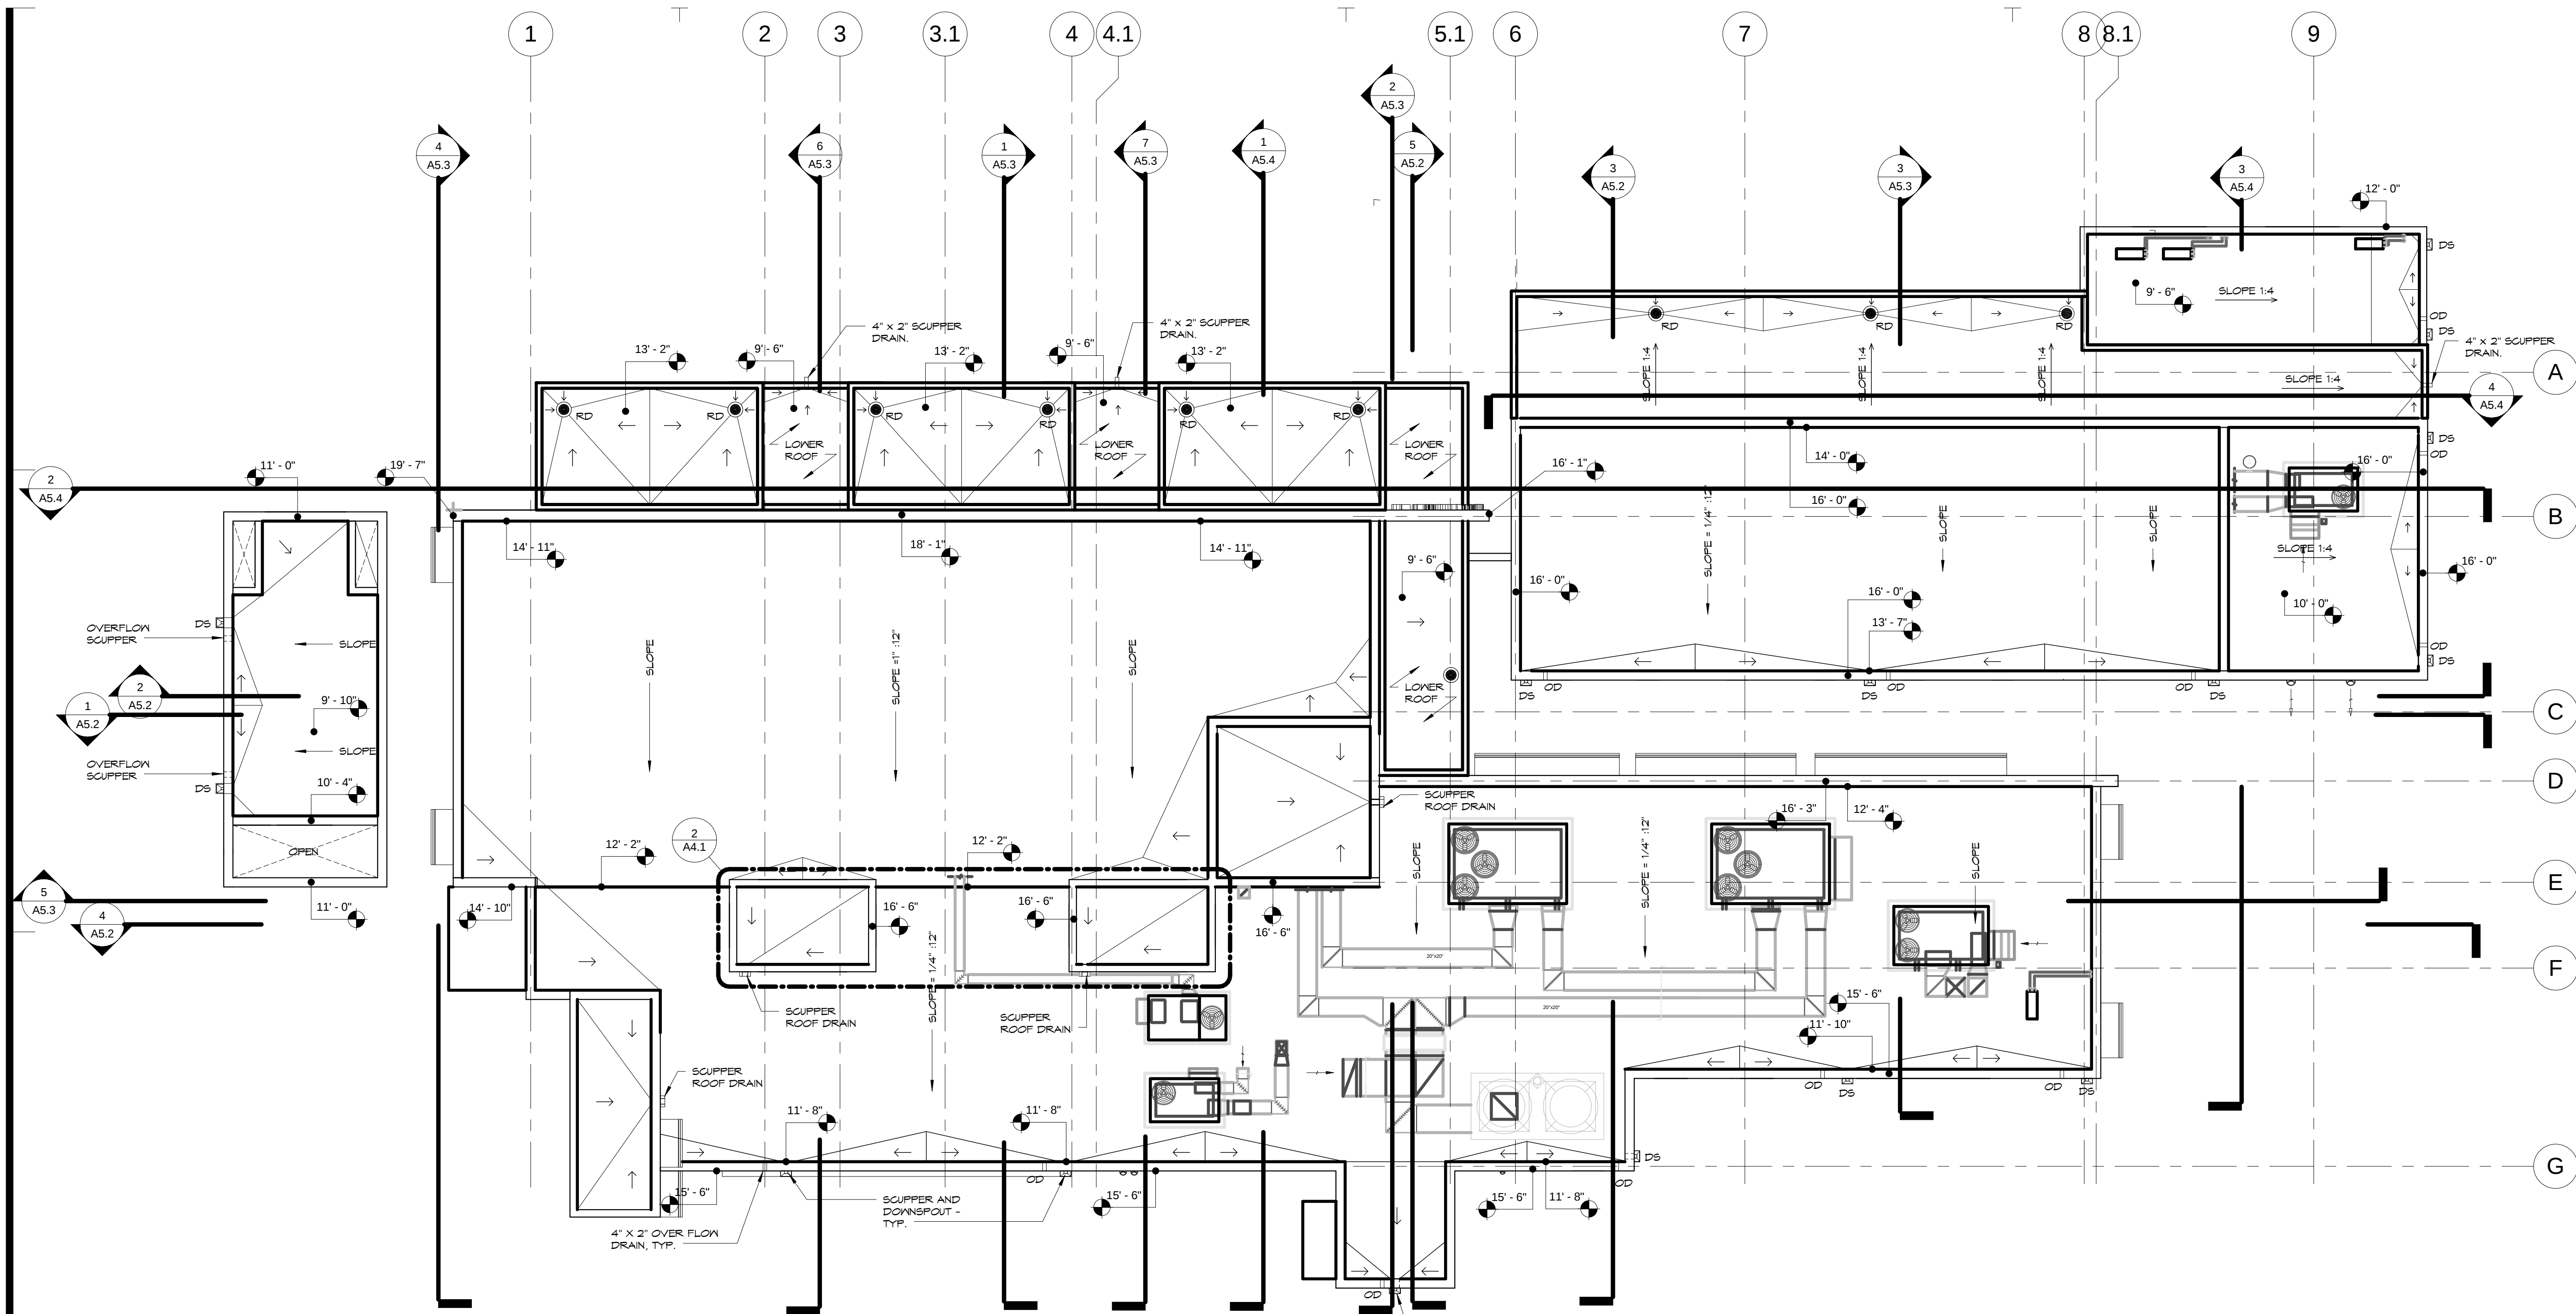

1 ROOF PLAN
SCALE: 1/8" = 1'-0"

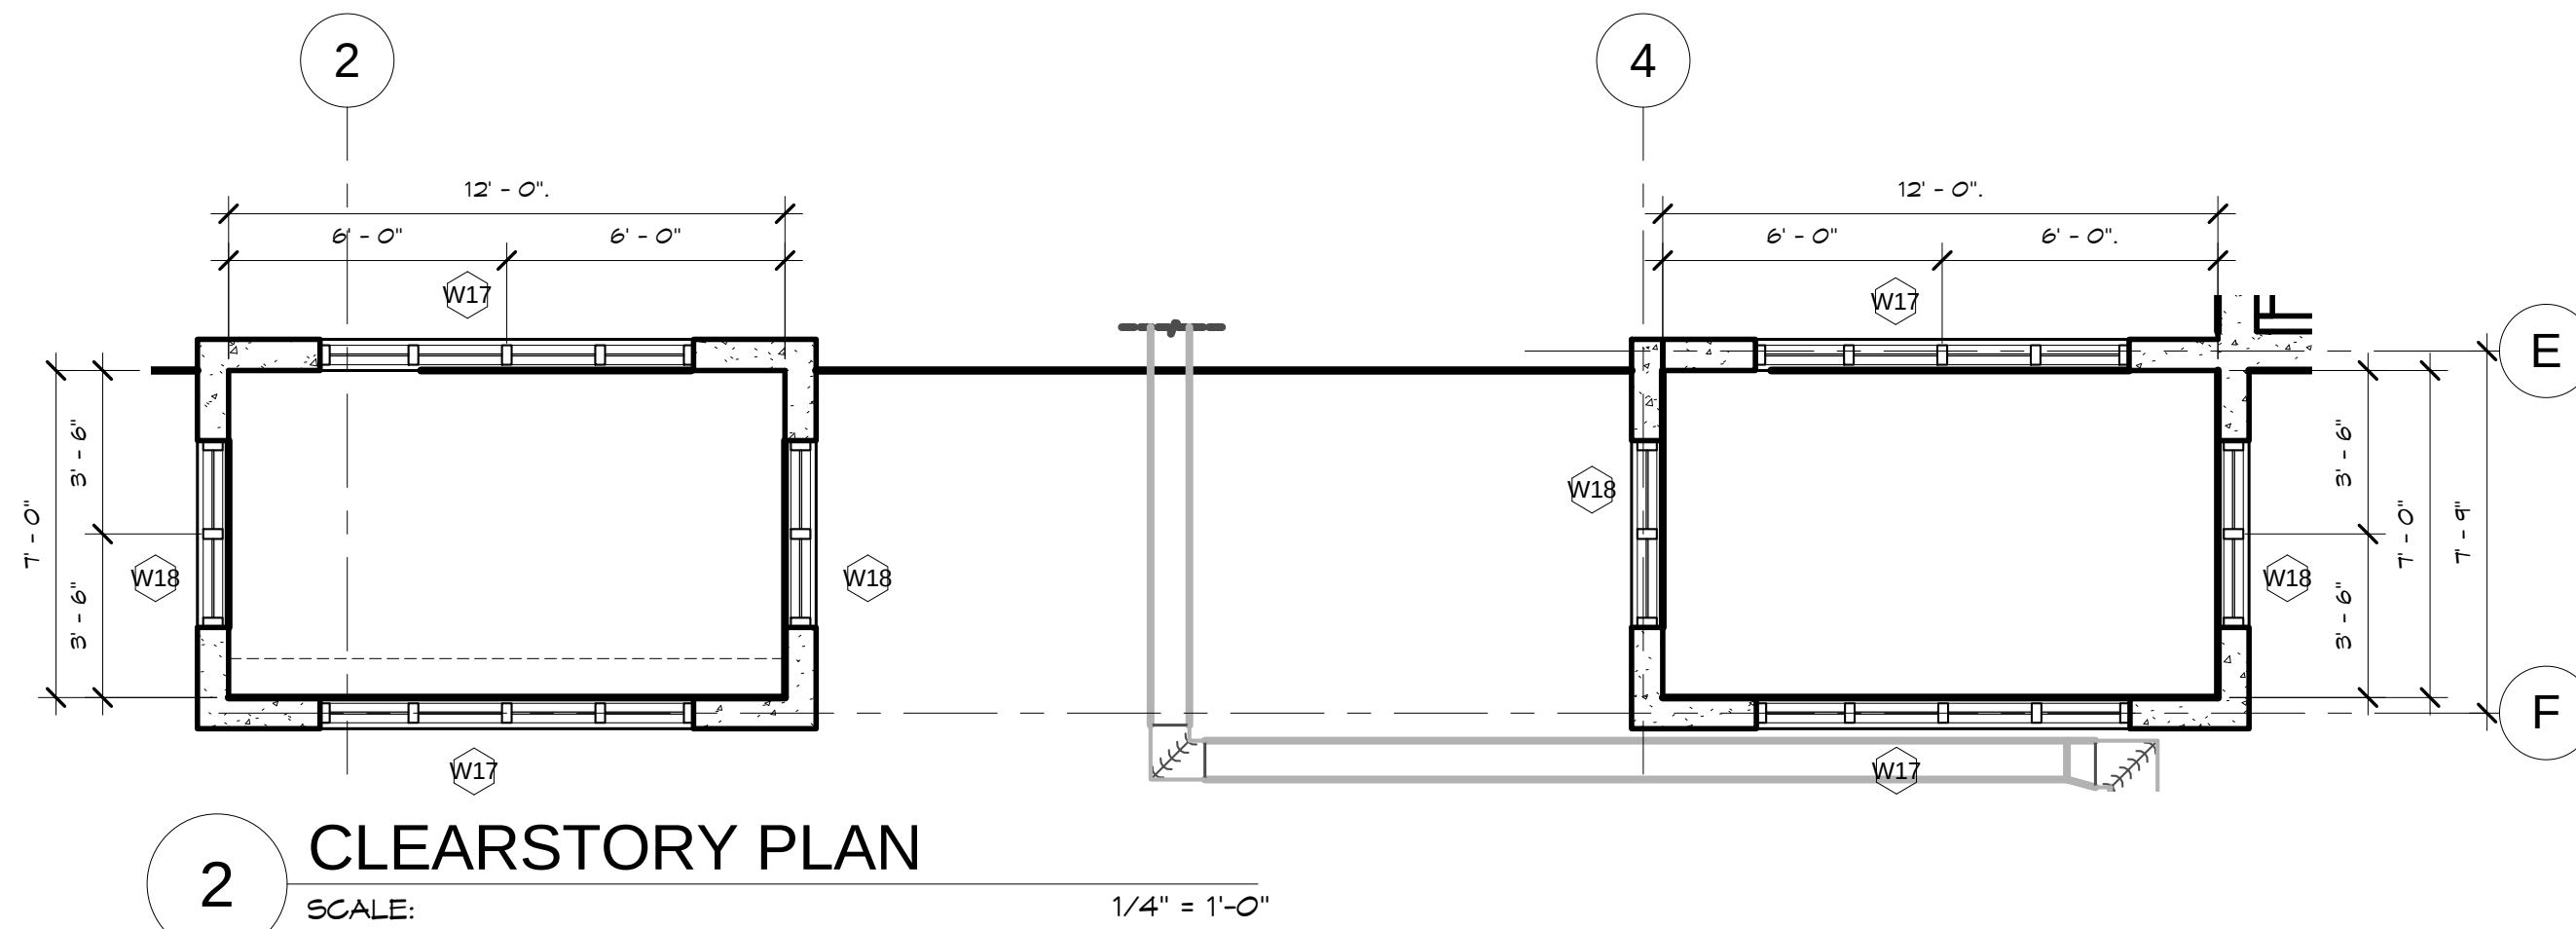

2 CLEARSTORY PLAN
SCALE: 1/4" = 1'-0"

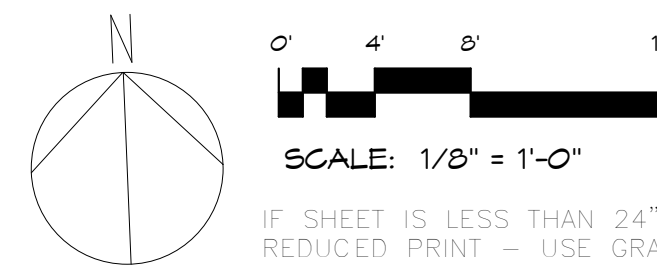

IF SHEET IS LESS THAN 24" X 36"
REDUCED PRINT - USE GRAPHIC SCALES

REVISIONS		
No.	Description	Date

TRMA
Taniguchi Ruth Makio Architects
100 Cliff Business Center, P.O. Box EA, Agaña, GU 96910
Tel.: (671) 475-8772 • Fax: (671) 472-3381

Architecture
Planning
Interior Design

BID
DOCUMENTS



I HEREBY CERTIFY THAT THIS PLAN WAS PREPARED
BY ME OR UNDER MY DIRECT SUPERVISION
DATE: _____


Project:
GUAM COMMUNITY
COLLEGE
FORENSIC DNA LAB

Title:
ROOF PLAN


Designed: TRMA
Drawn: RM/TP
Checked: CTC
Supv: MWM
Scale: As indicated
Date: 12/17/12
Project No. 1026
File
Drawing No.

A4.1


Sheet No. _____ of _____

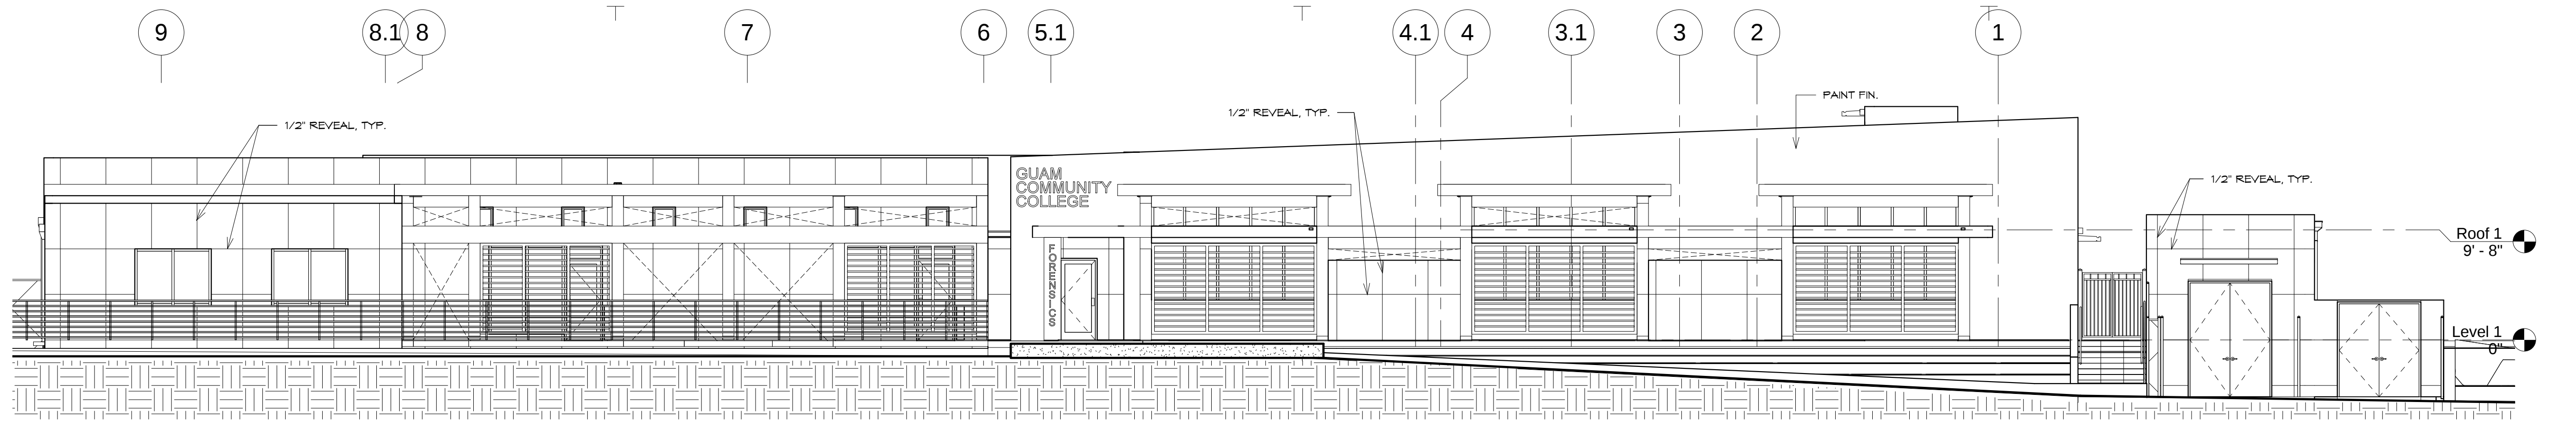


1 NORTH ELEVATION
SCALE: 1/8" = 1'-0"

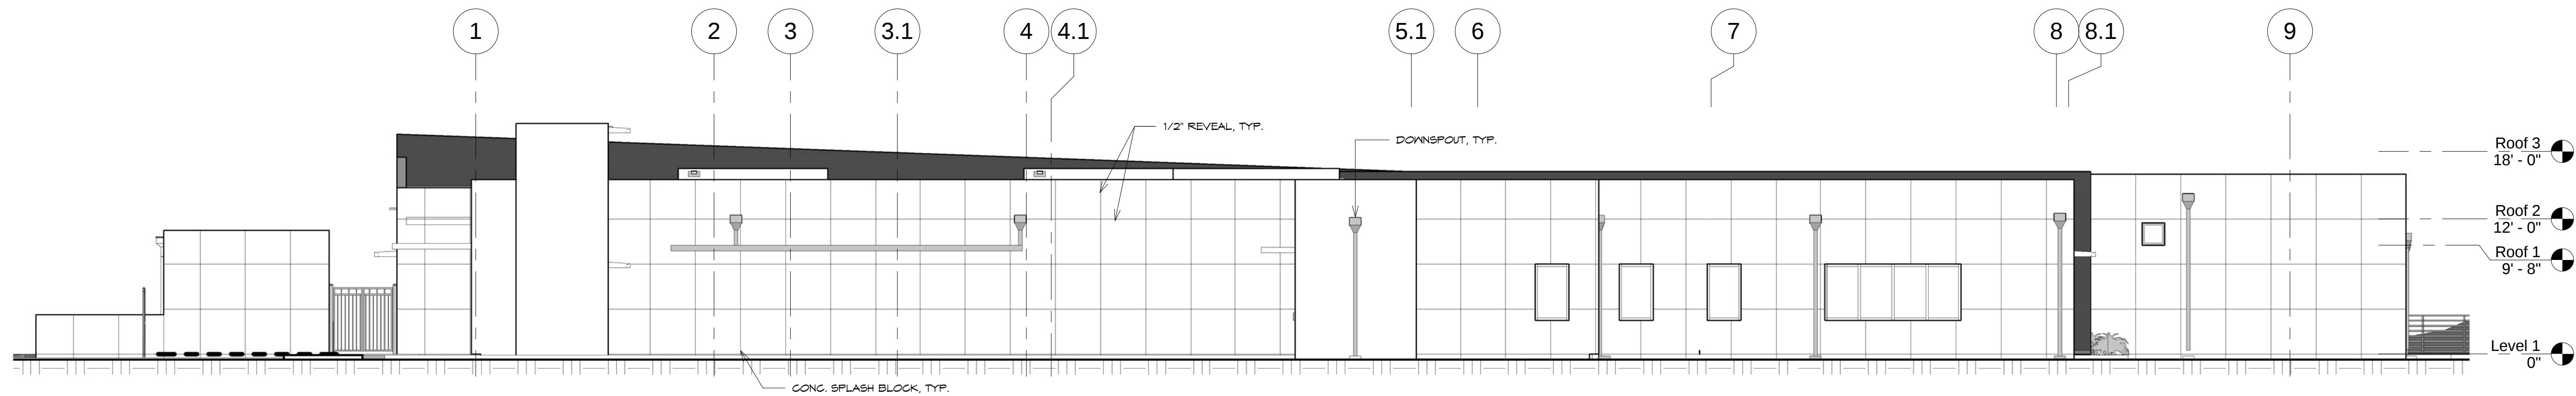

2 SOUTH ELEVATION
SCALE: 1/8" = 1'-0"

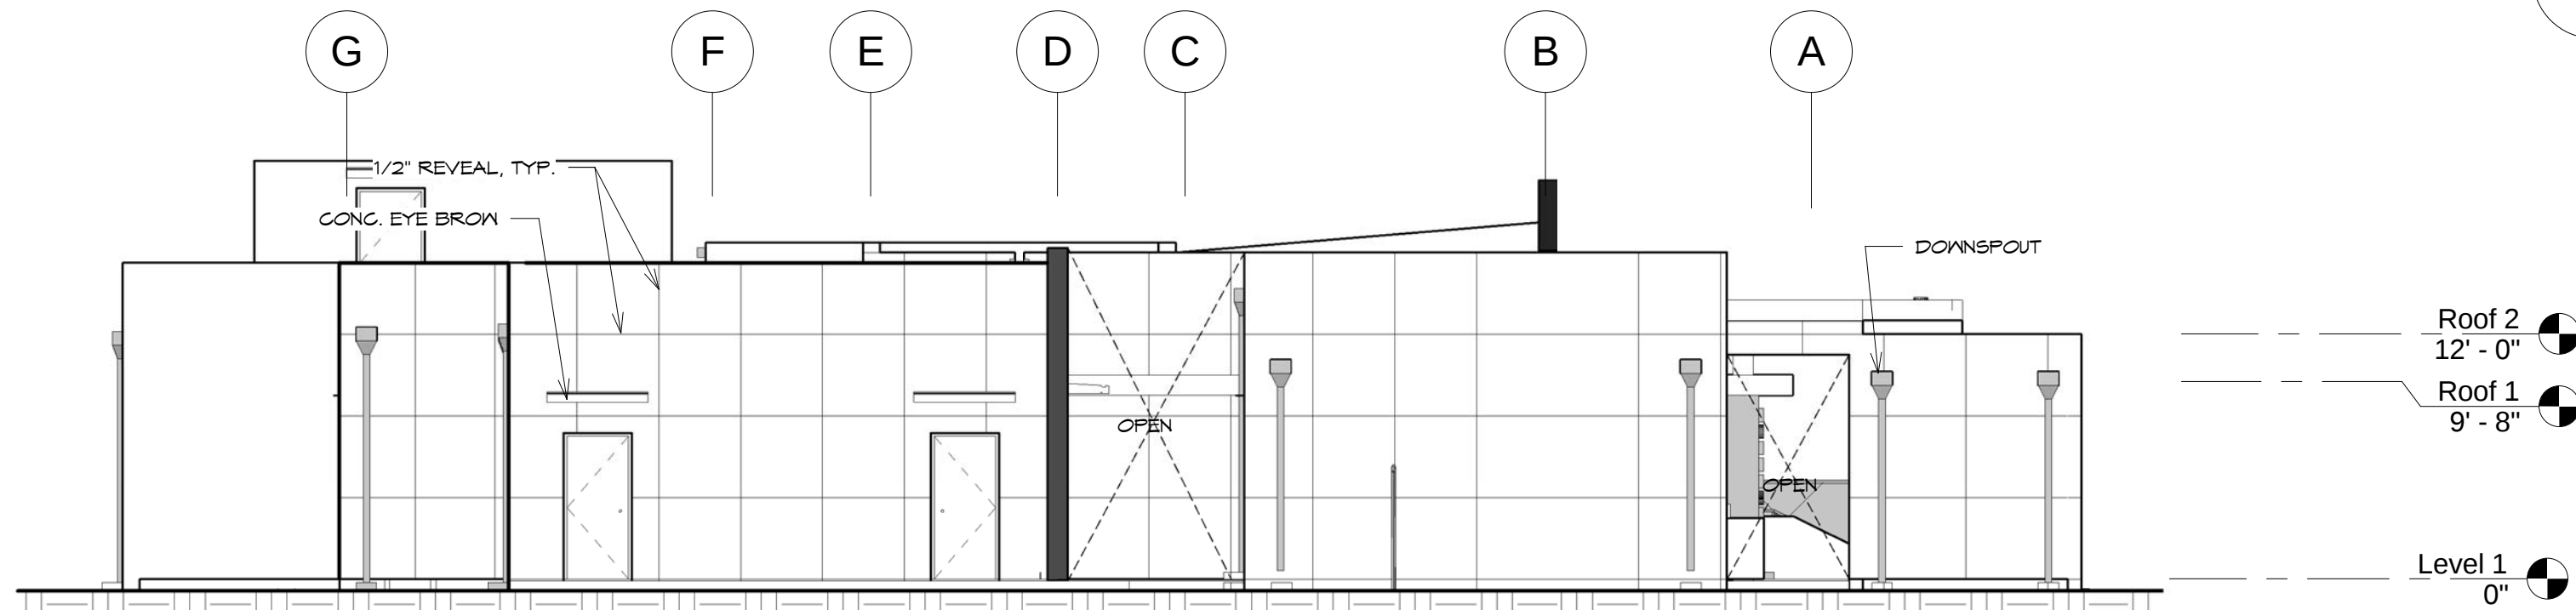

3 EAST ELEVATION
SCALE: 1/8" = 1'-0"

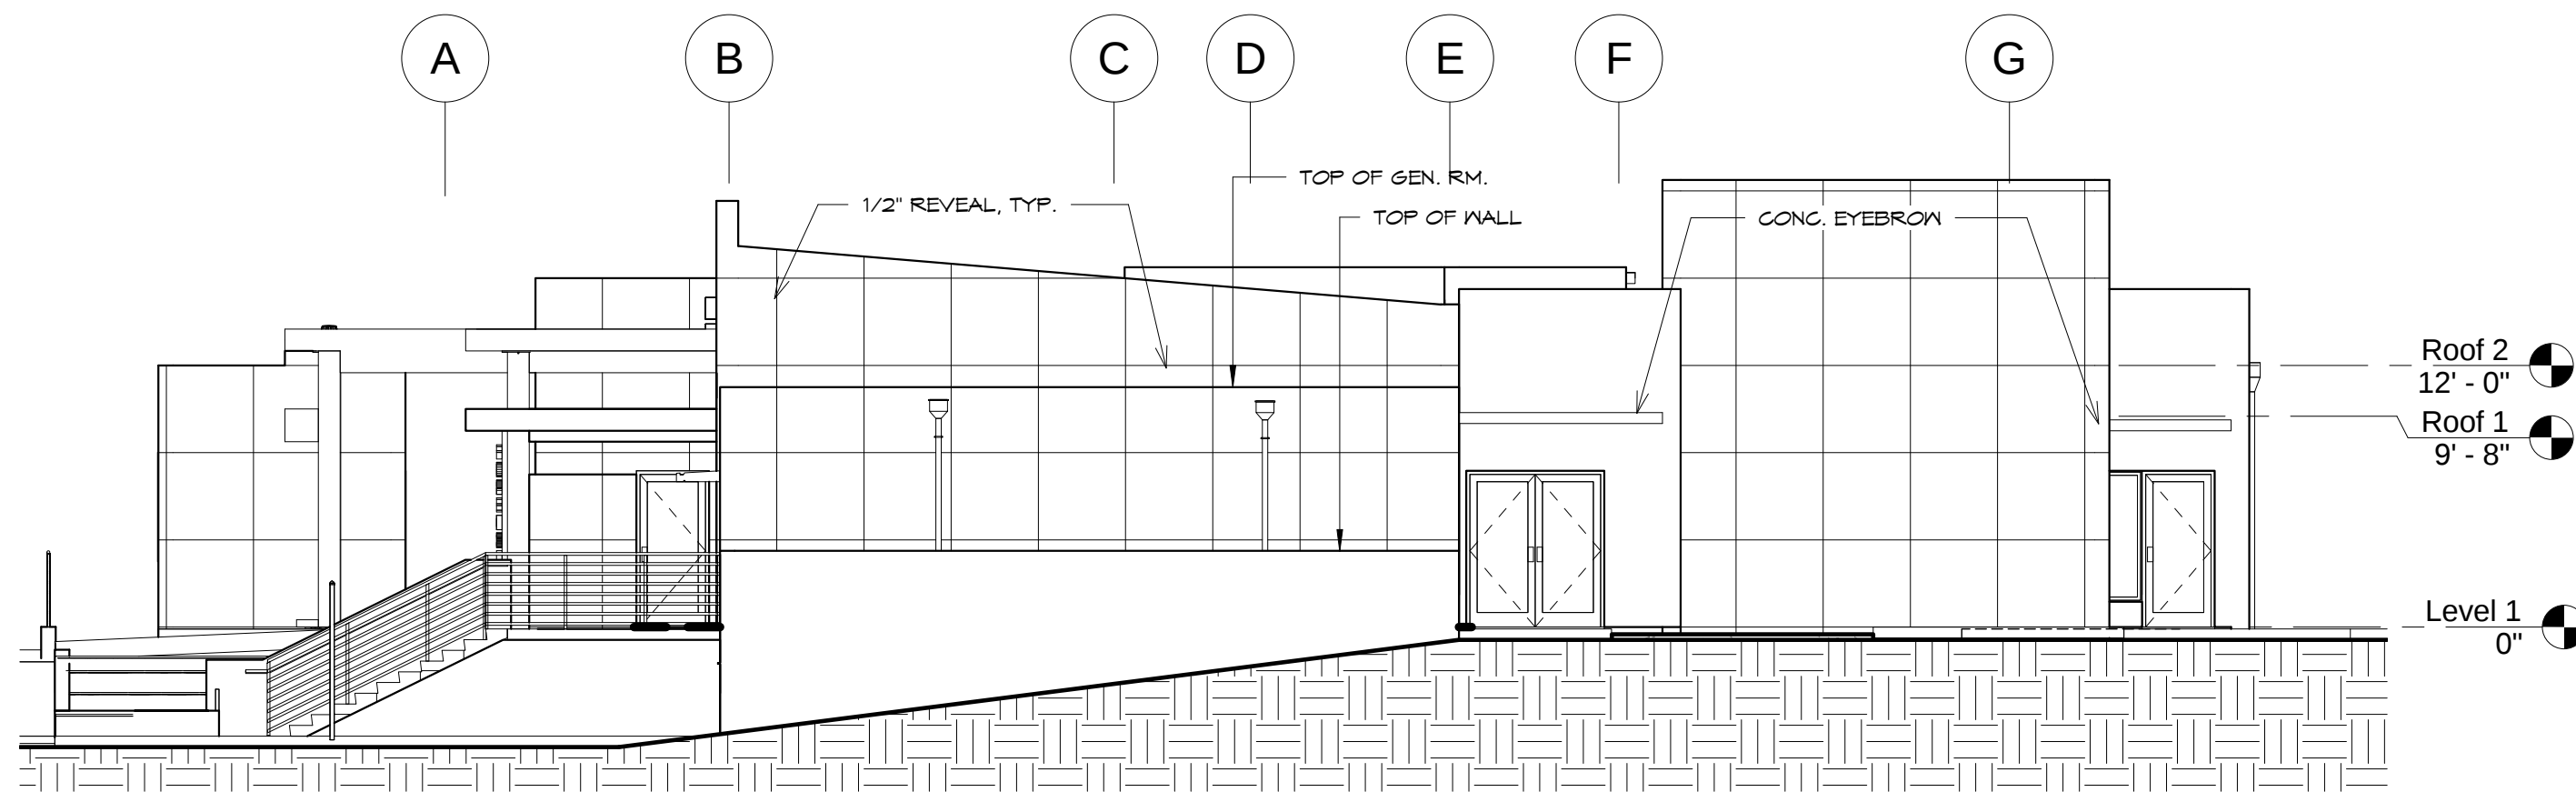


4 WEST ELEVATION
SCALE: 1/8" = 1'-0"




IF SHEET IS LESS THAN 24" X 36"
REDUCED PRINT - USE GRAPHIC SCALES

REVISIONS		
No.	Description	Date
TRMA Taniguchi Ruth Makio Architects 100 Cliff Business Center, P.O. Box EA, Agaña, GU 96910 Tel.: (671) 475-8772 • Fax: (671) 472-3381 Architecture Planning Interior Design		
BID DOCUMENTS		
MICHAEL W. MAKIO CERTIFICATE No. 246 ★ EXP. 4/30/11 GUAM REGISTERED ARCHITECT I HEREBY CERTIFY THAT THIS PLAN WAS PREPARED BY ME OR UNDER MY DIRECT SUPERVISION DATE: _____		
Project: GUAM COMMUNITY COLLEGE FORENSIC DNA LAB		
Title: BUILDING ELEVATIONS		
Designed: TRMA		
Drawn: RM/TP		
Checked: CTC		
Supv: MWM		
Scale: 1/8" = 1'-0"		
Date: 12/17/12		
Project No. 1026		
Drawing No.		
A5.1		
Sheet No. _____ of _____		

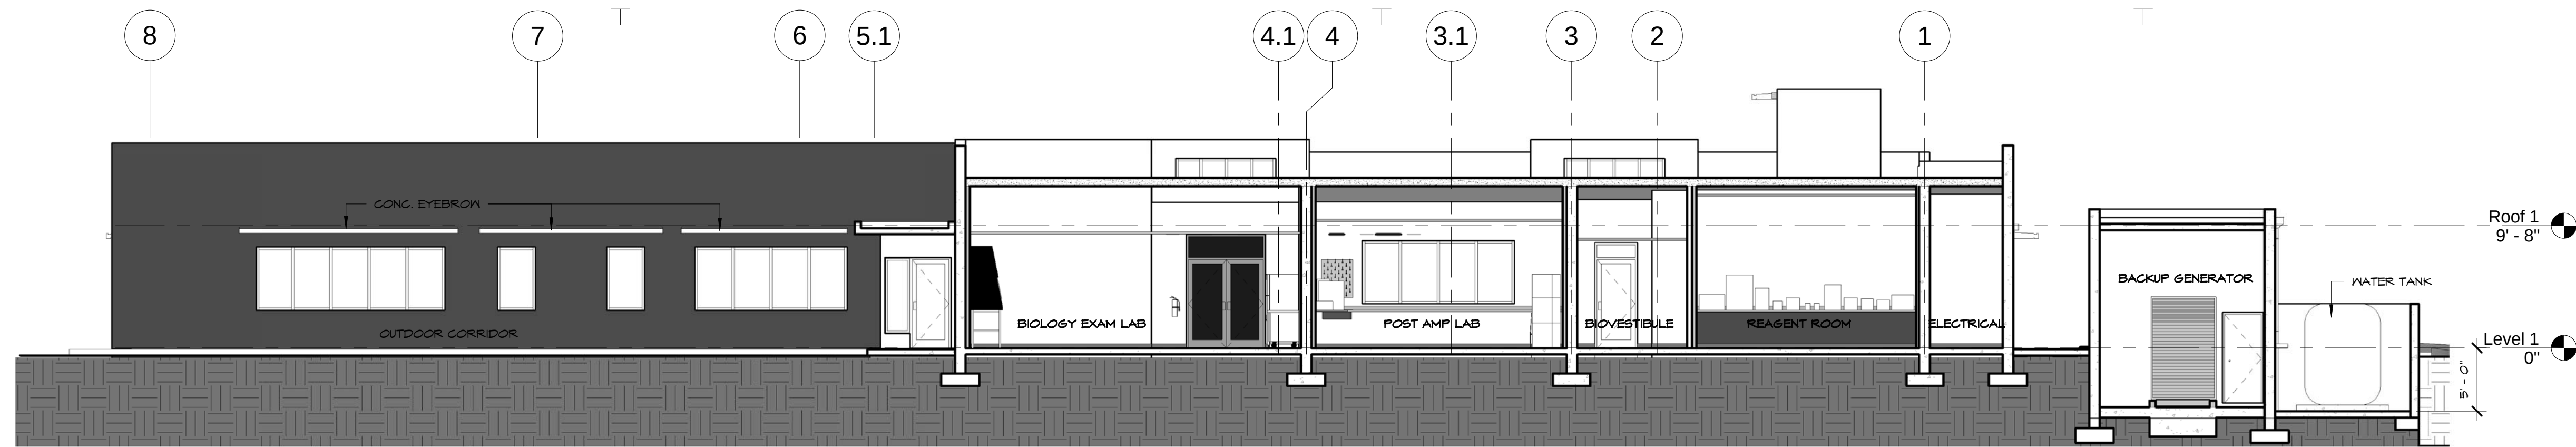


1 SECTION

SCALE: 1/8" = 1'-0"

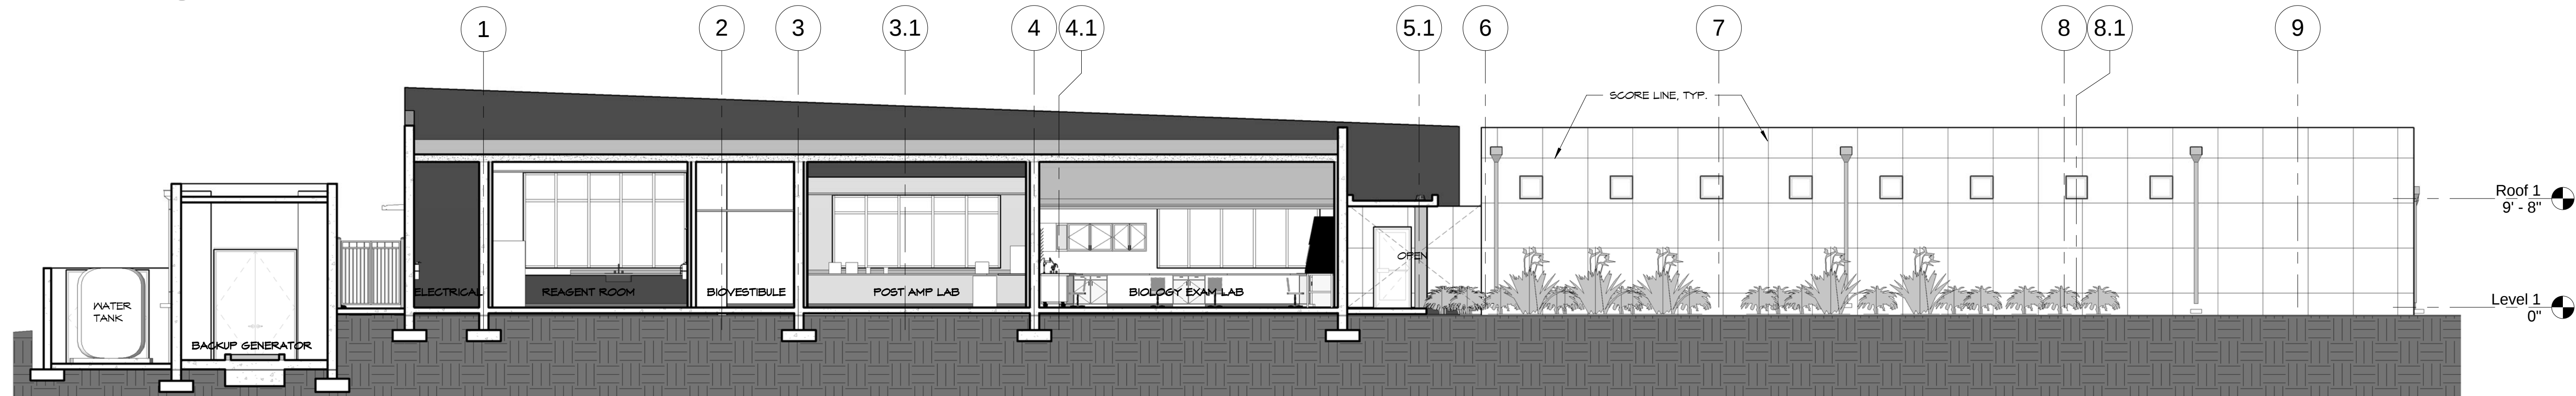


2 SECTION

SCALE: 1/8" = 1'-0"

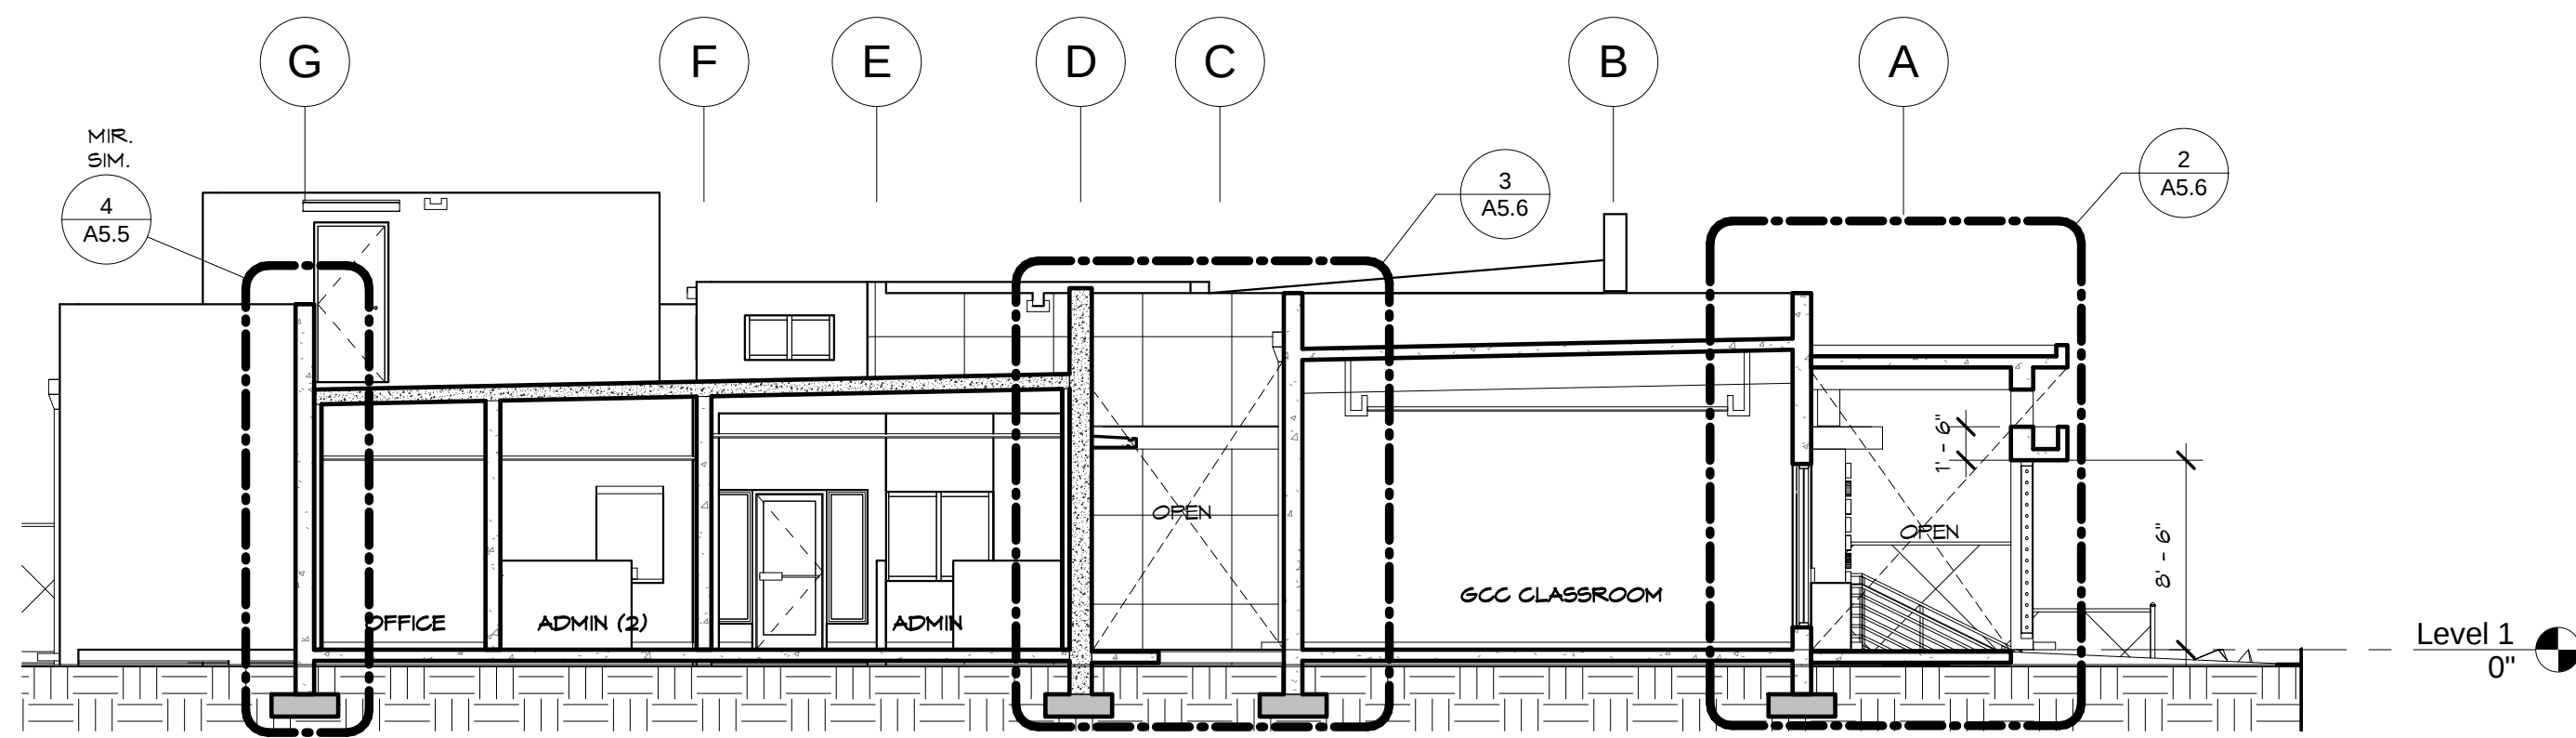


3 SECTION

SCALE: 1/8" = 1'-0"

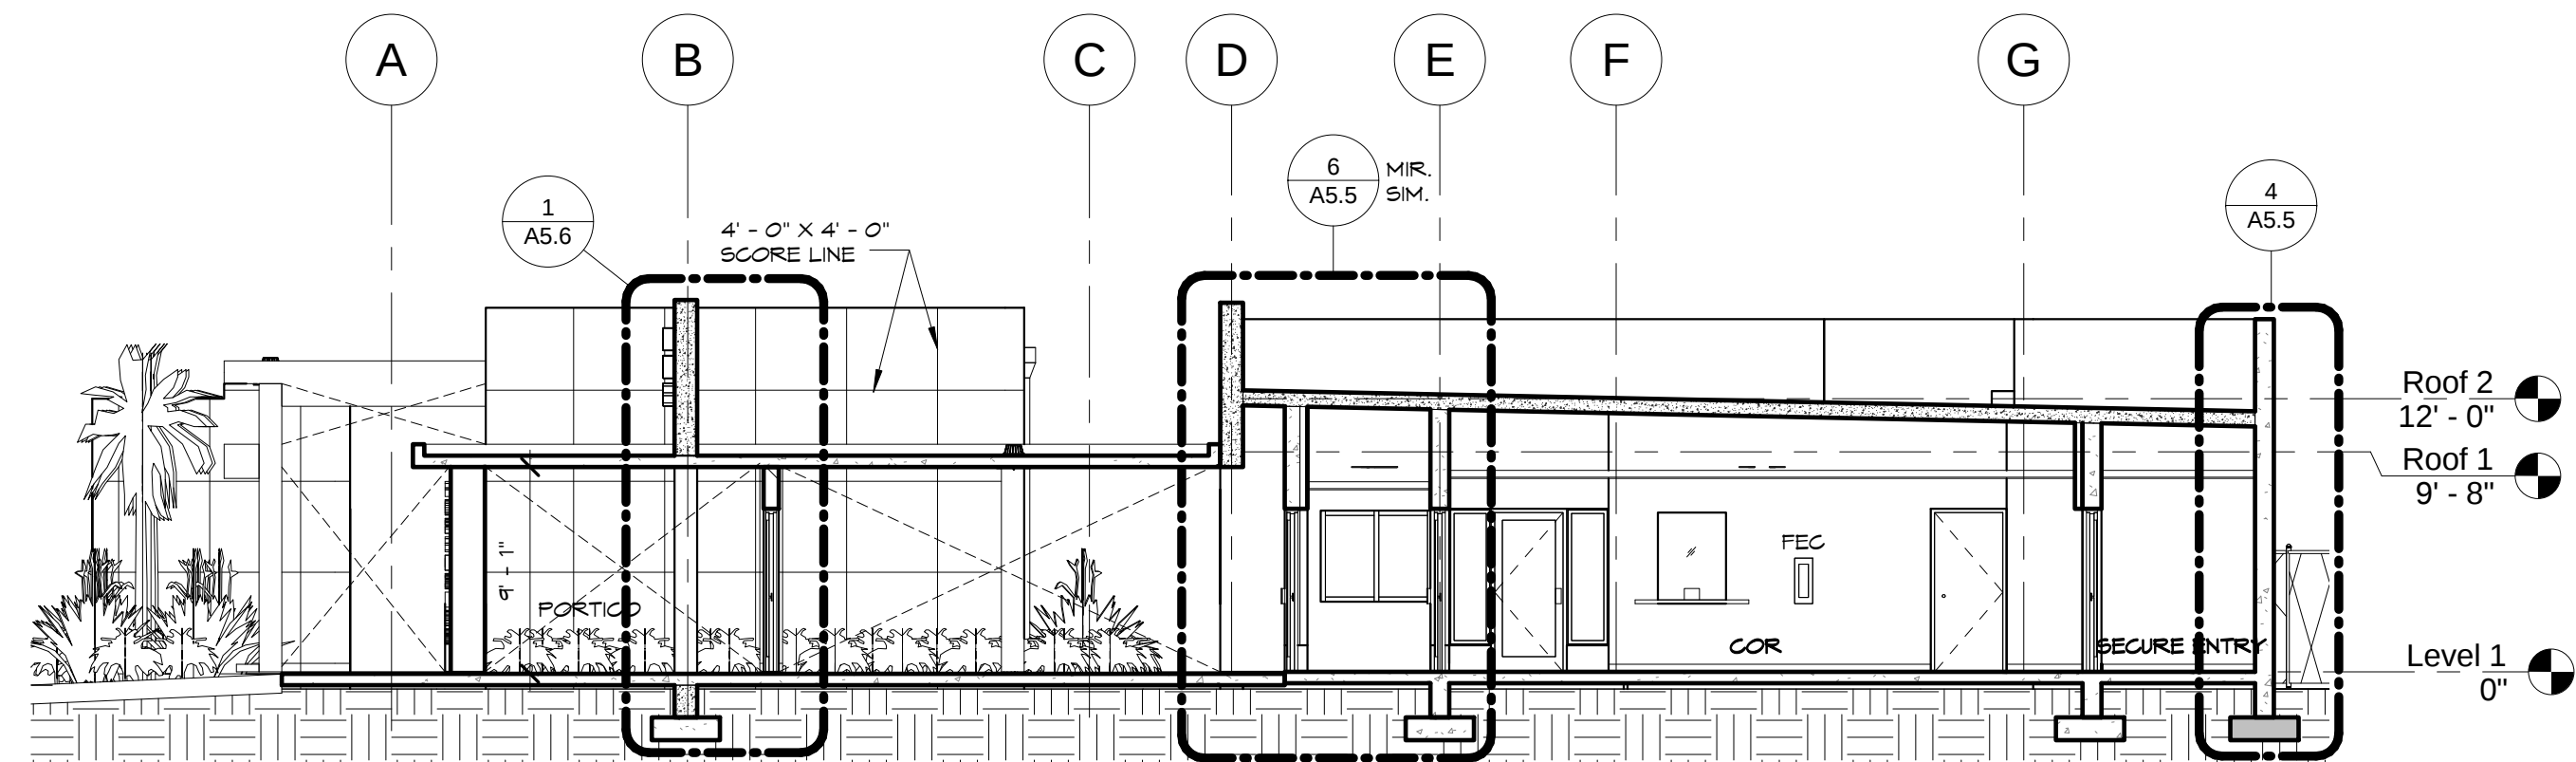


5 SECTION

SCALE: 1/8" = 1'-0"

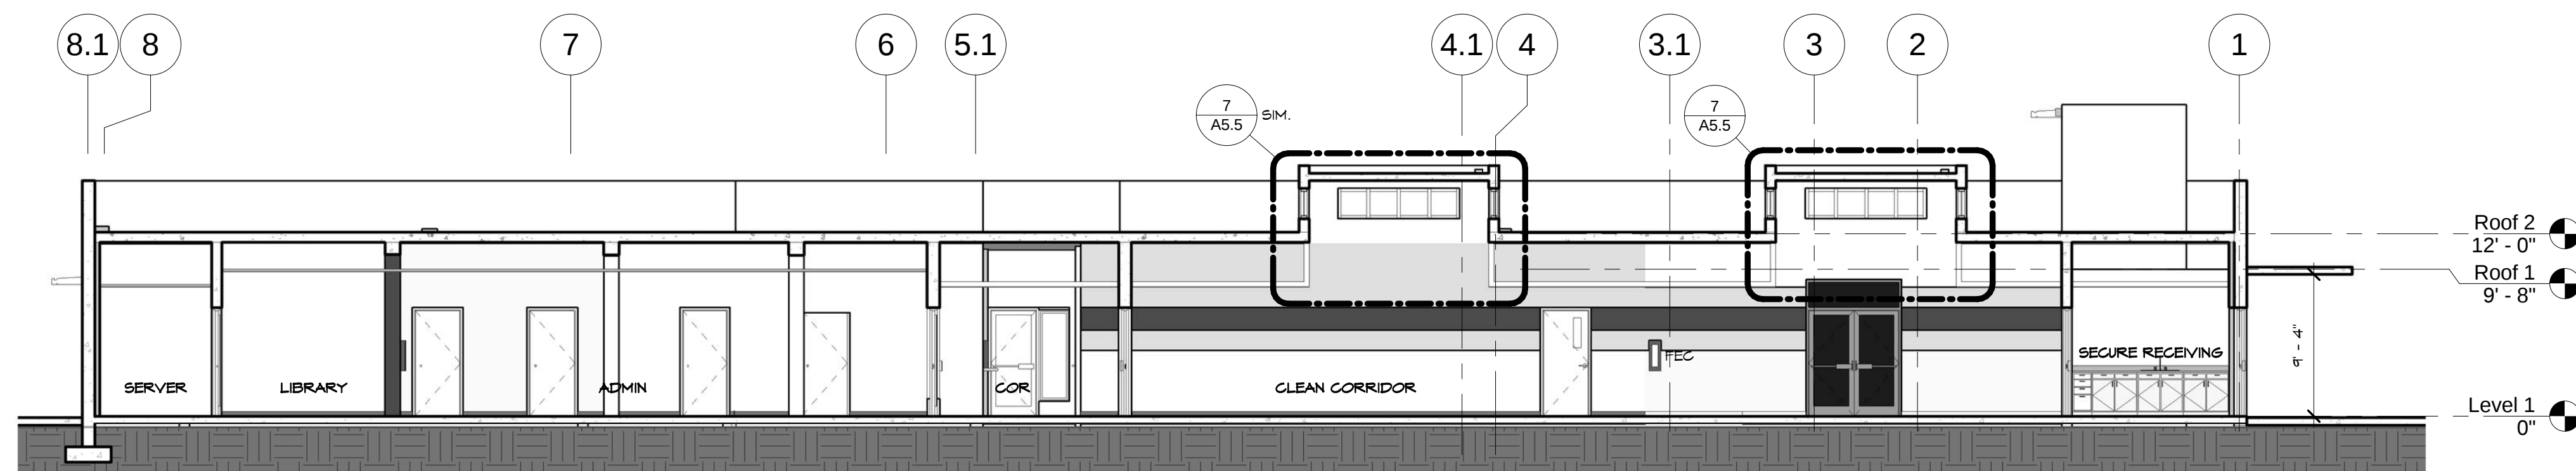


4 SECTION

 SCALE: 1/8" = 1'-0"




IF SHEET IS LESS THAN 24" X 36"
REDUCED PRINT - USE GRAPHIC SCALES


REVISIONS		
No.	Description	Date
TRMA Taniguchi Ruth Makio Architects 100 Cliff Business Center, P.O. Box EA, Agaña, GU 96910 Tel.: (671) 475-8772 • Fax: (671) 472-3381		
Architecture Planning Interior Design		
BID DOCUMENTS		
 I HEREBY CERTIFY THAT THIS PLAN WAS PREPARED BY ME OR UNDER MY DIRECT SUPERVISION DATE:		
Project: GUAM COMMUNITY COLLEGE FORENSIC DNA LAB		
Title: BUILDING SECTIONS		
Designed: TRMA Drawn: RM/TP Checked: CTC Supv: MAM Scale: 1/8" = 1'-0" Date: 12/17/12 Project No. 1026 Drawing No.		
A5.2 Sheet No. of		

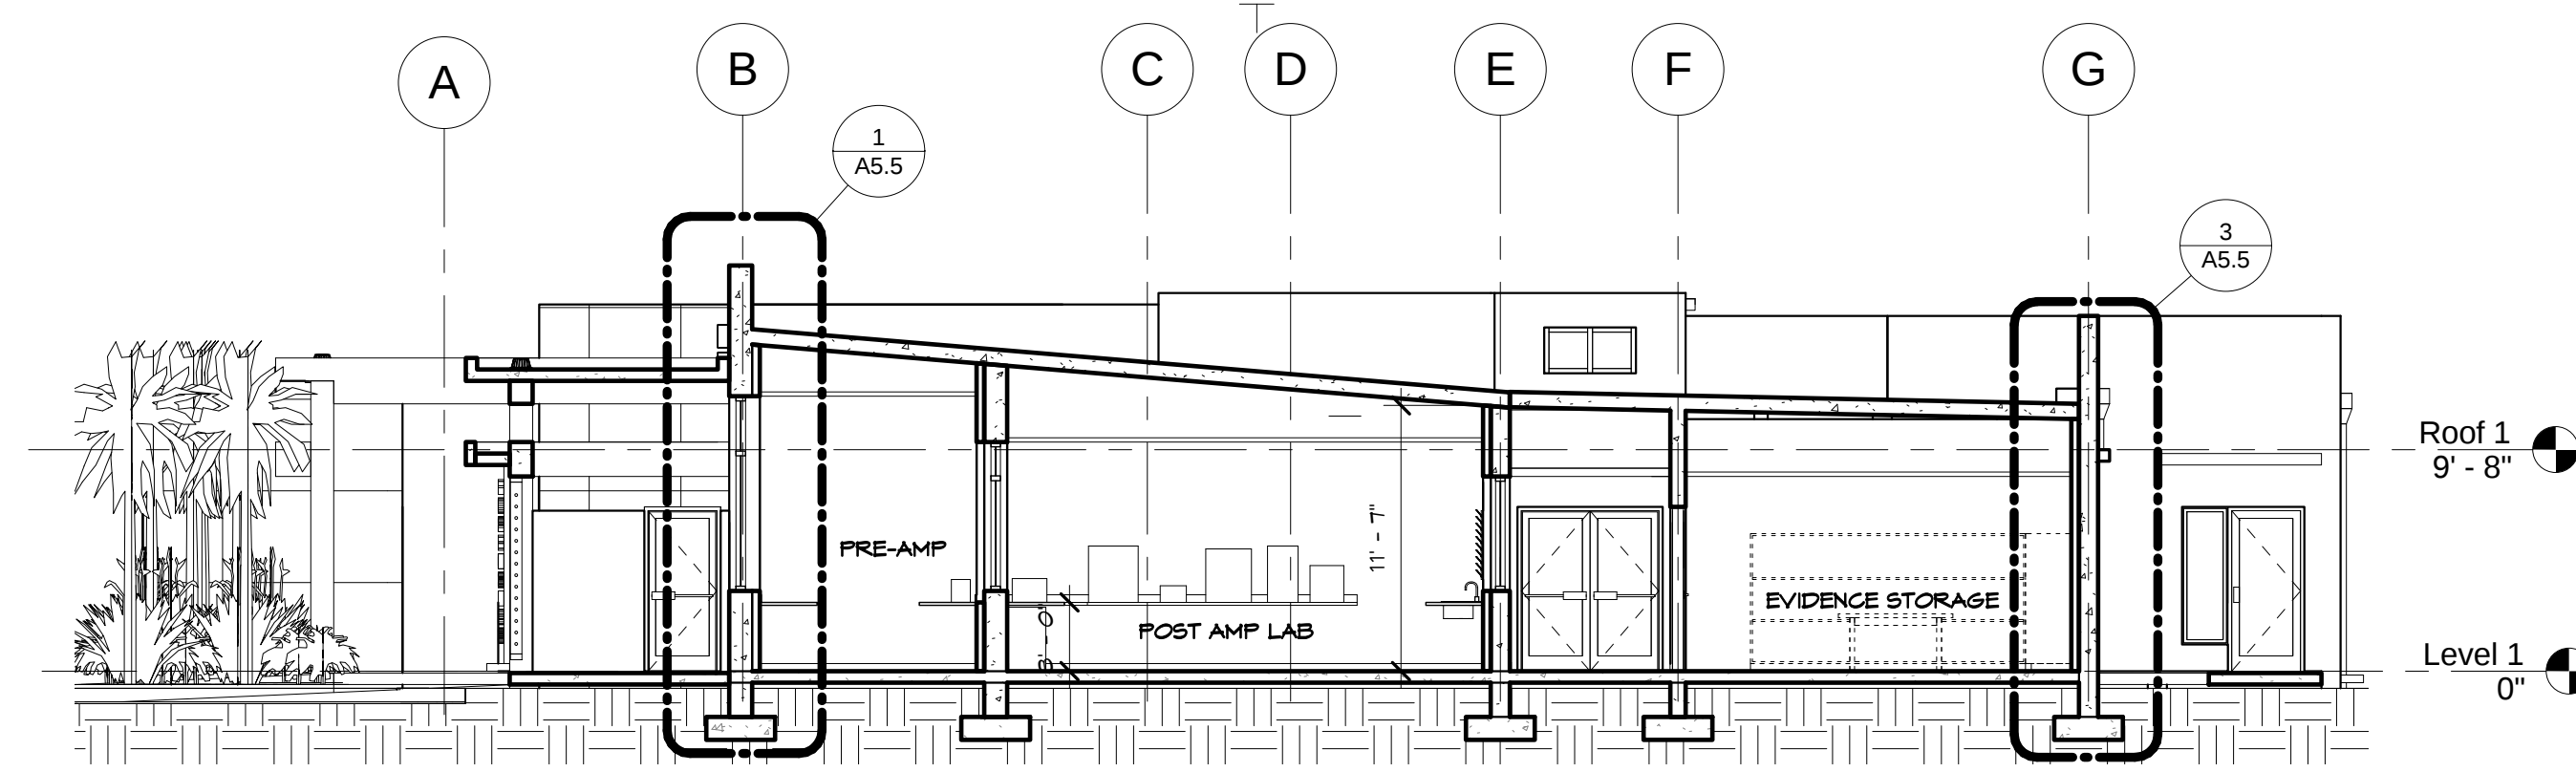


1 SECTION
SCALE: 1/8" = 1'-0"

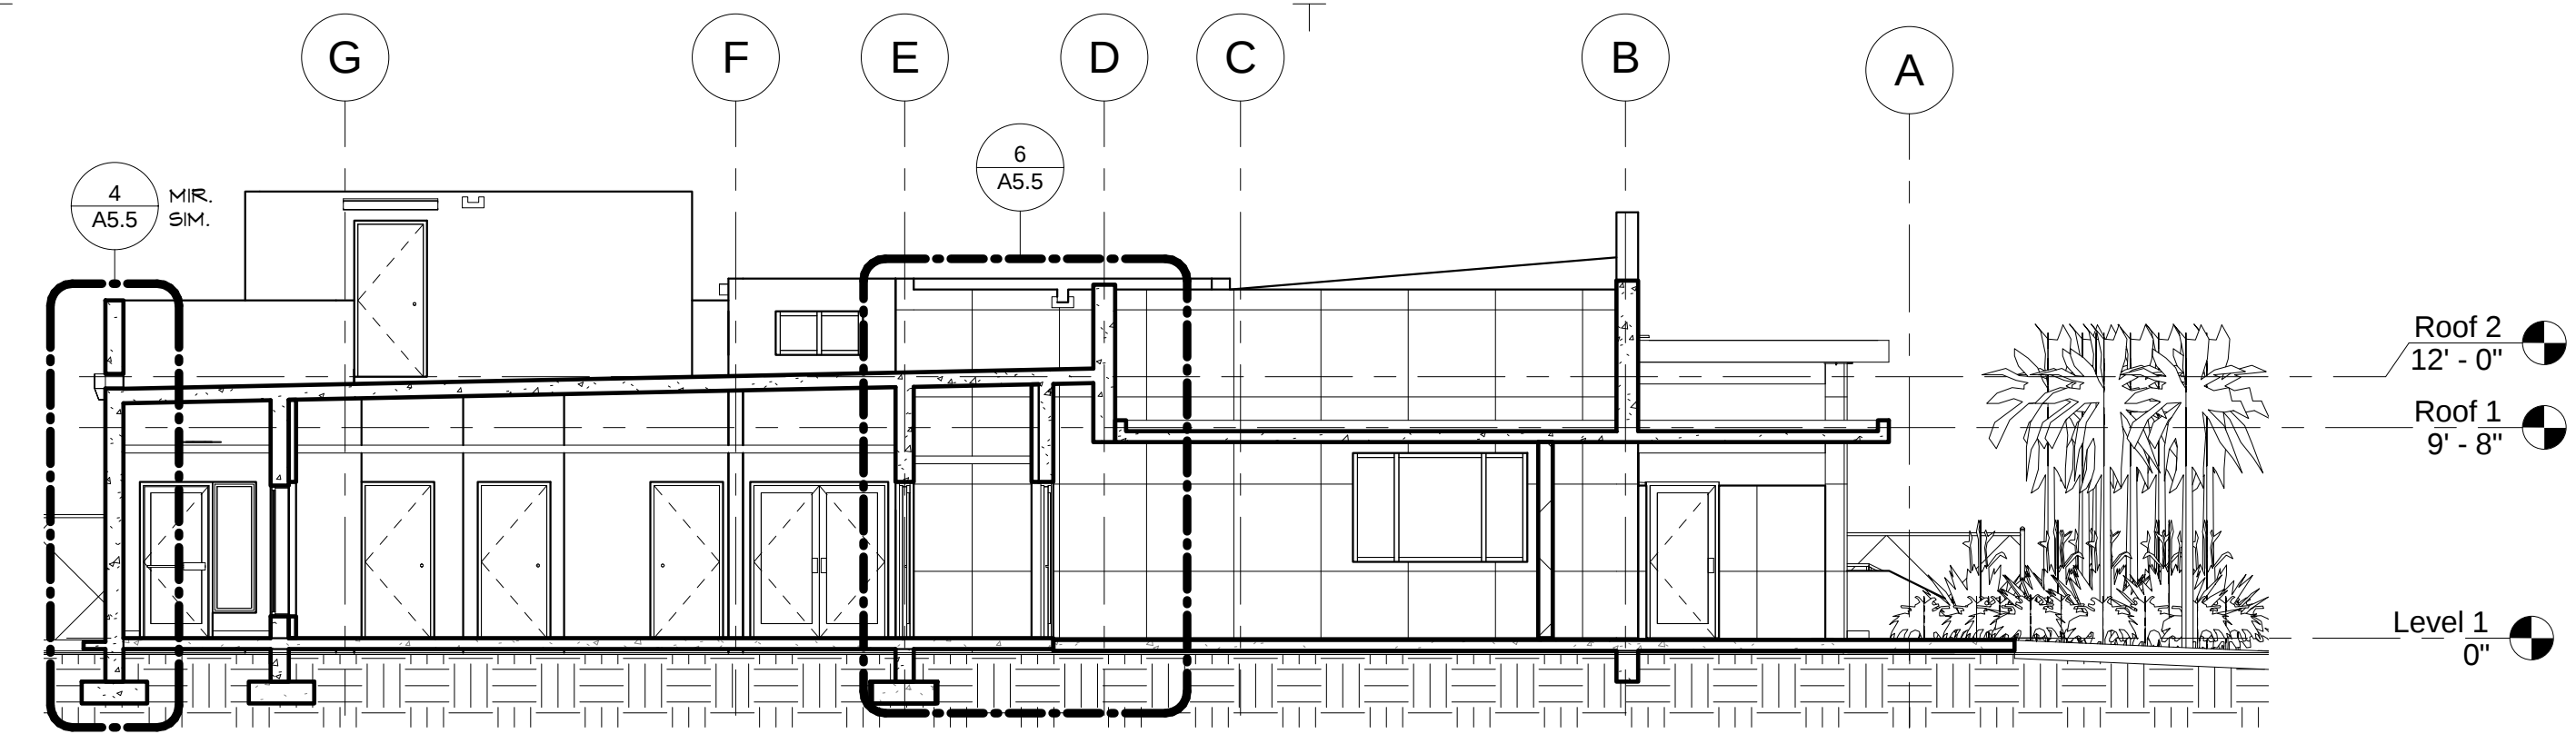


2 SECTION
SCALE: 1/8" = 1'-0"

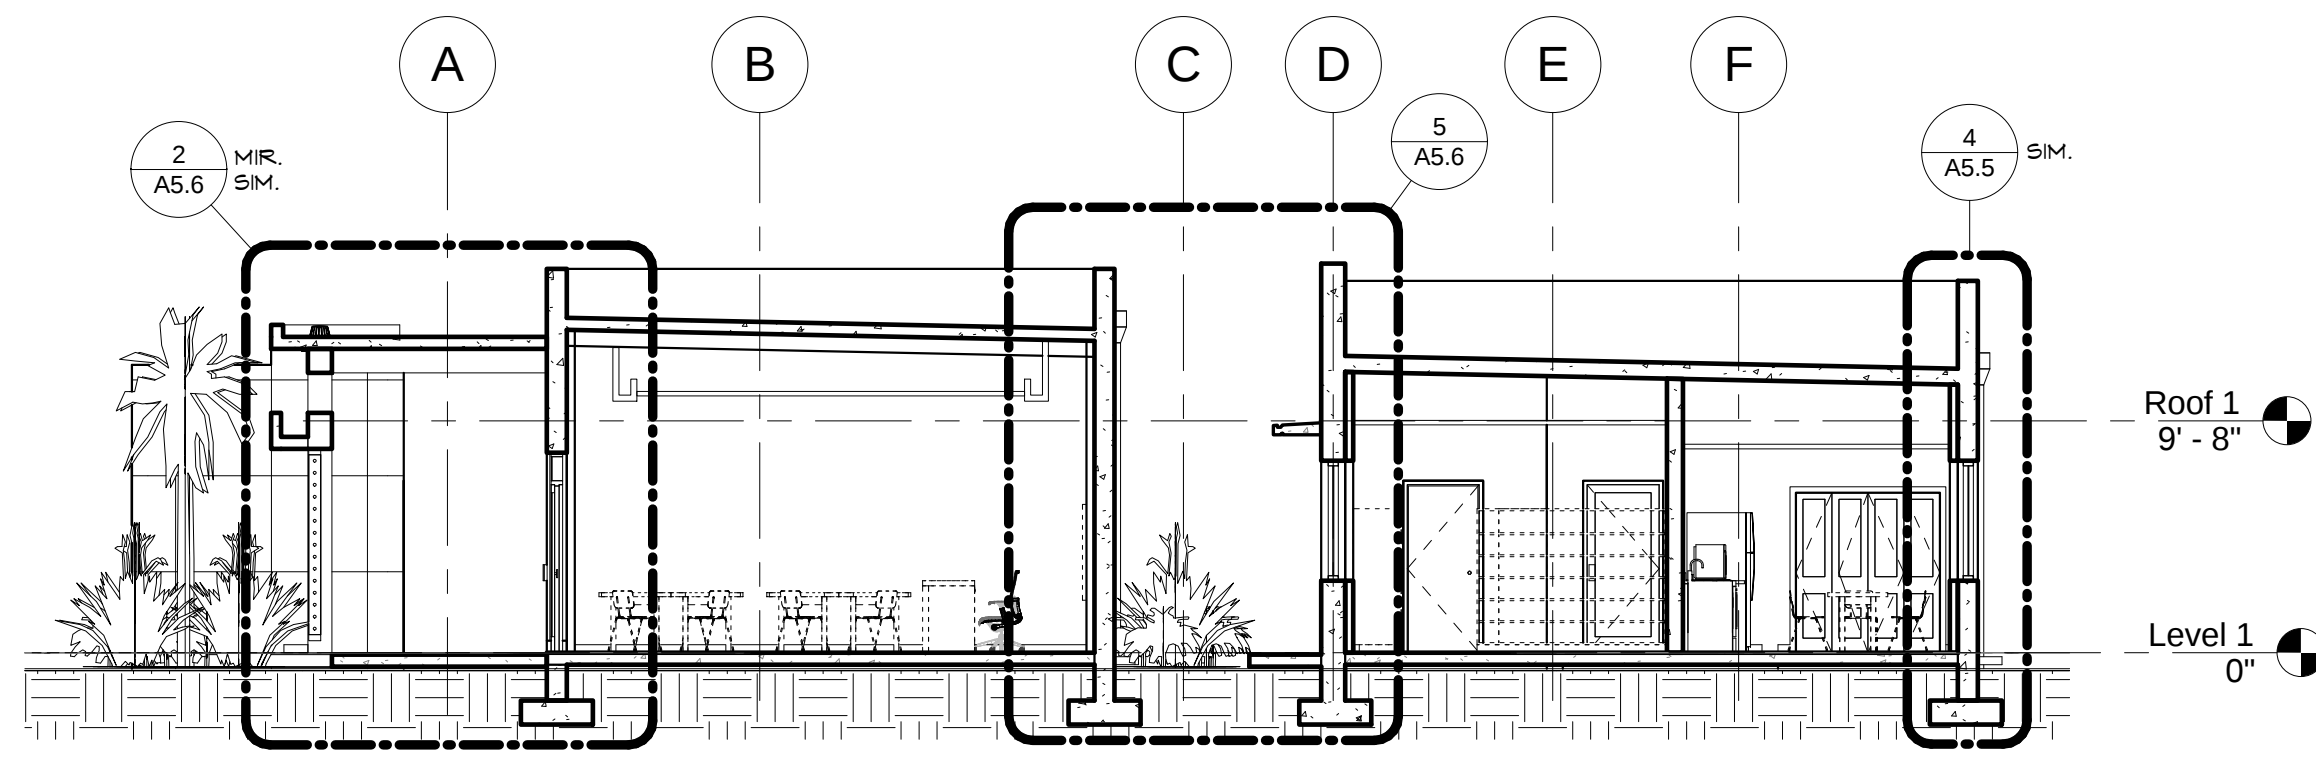


3 SECTION
SCALE: 1/8" = 1'-0"

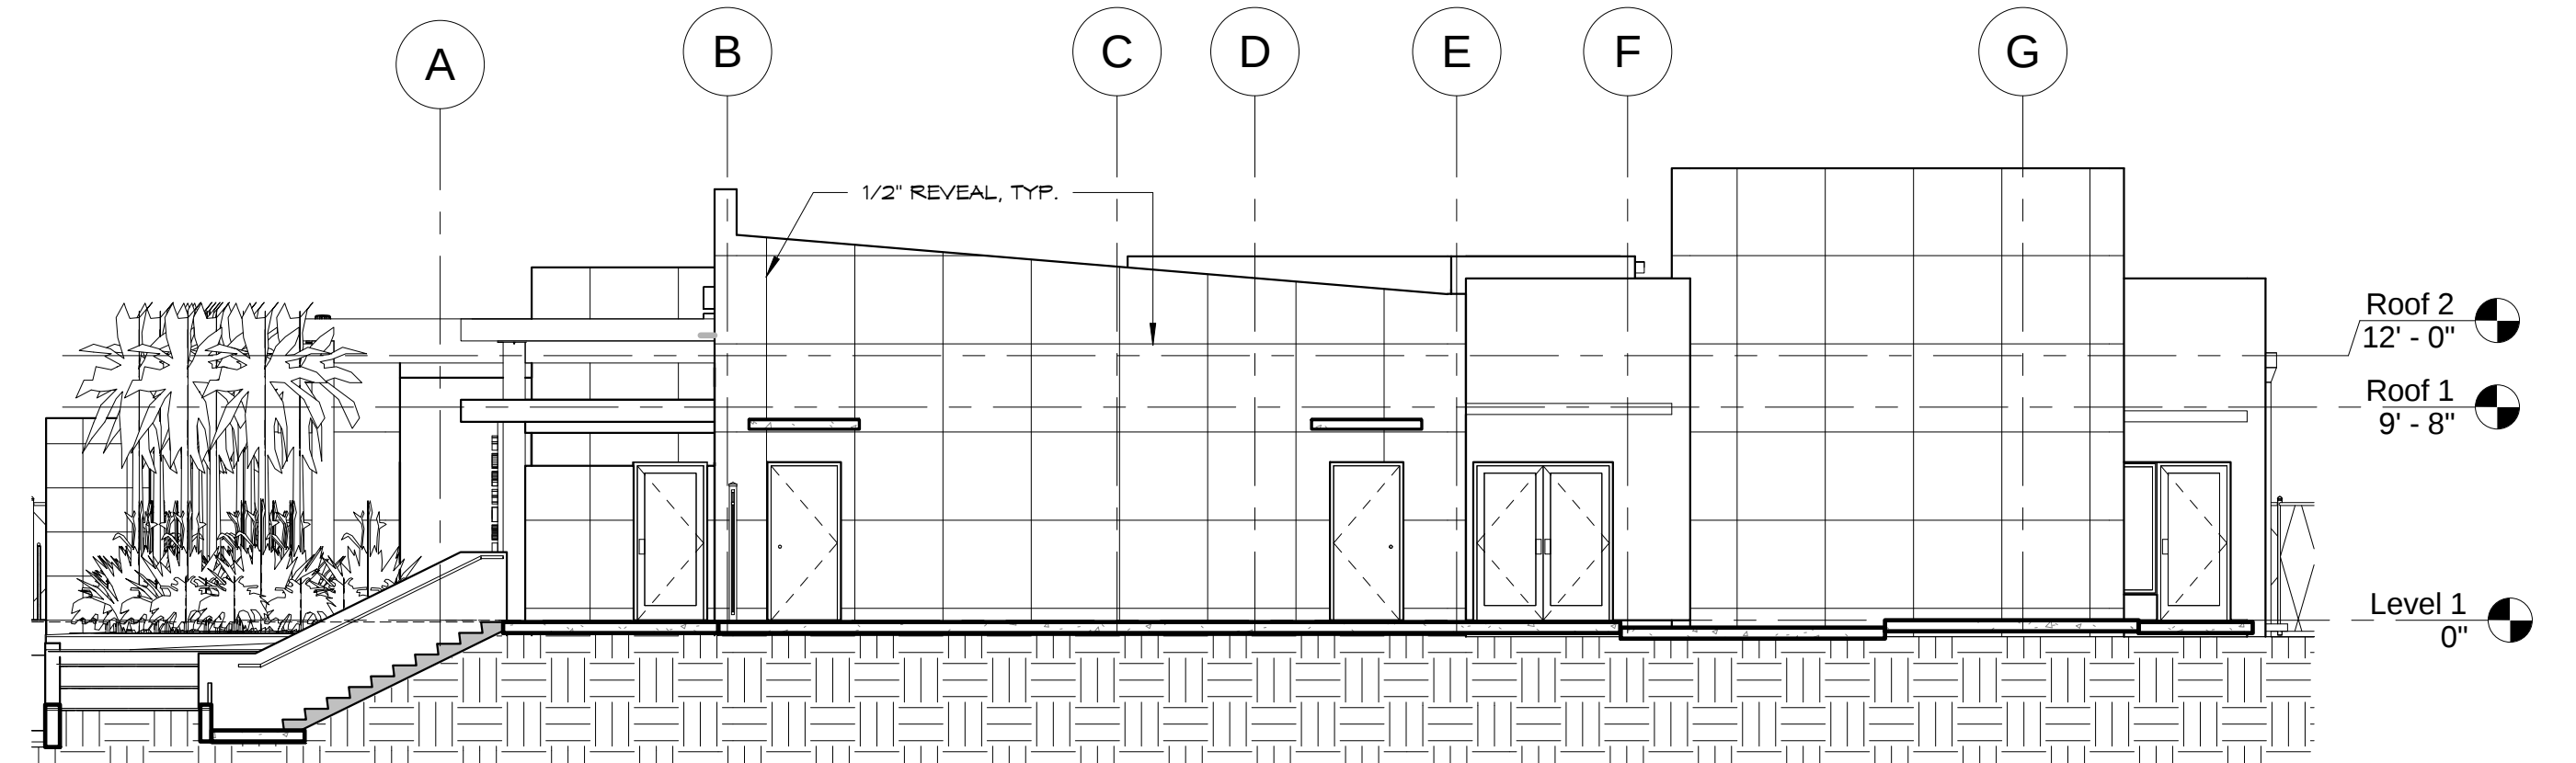


4 SECTION
SCALE: 1/8" = 1'-0"

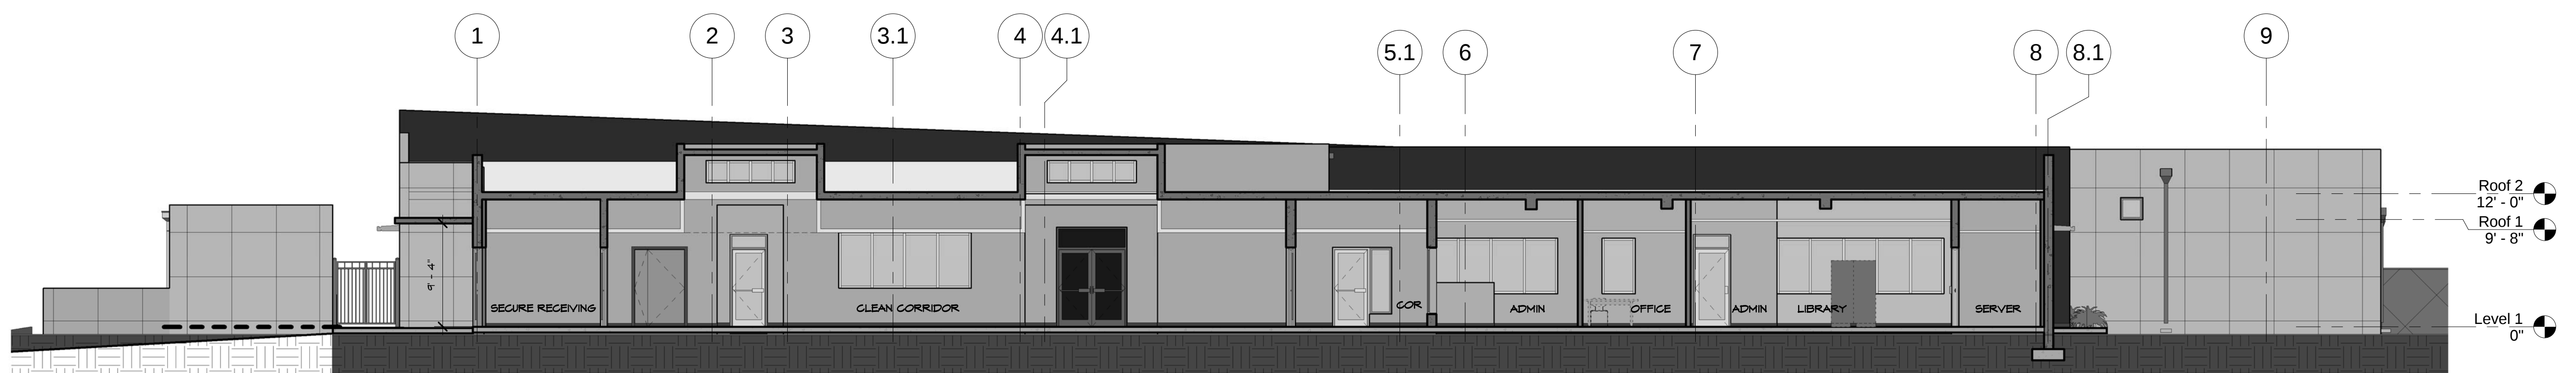


5 SECTION
SCALE: 1/8" = 1'-0"

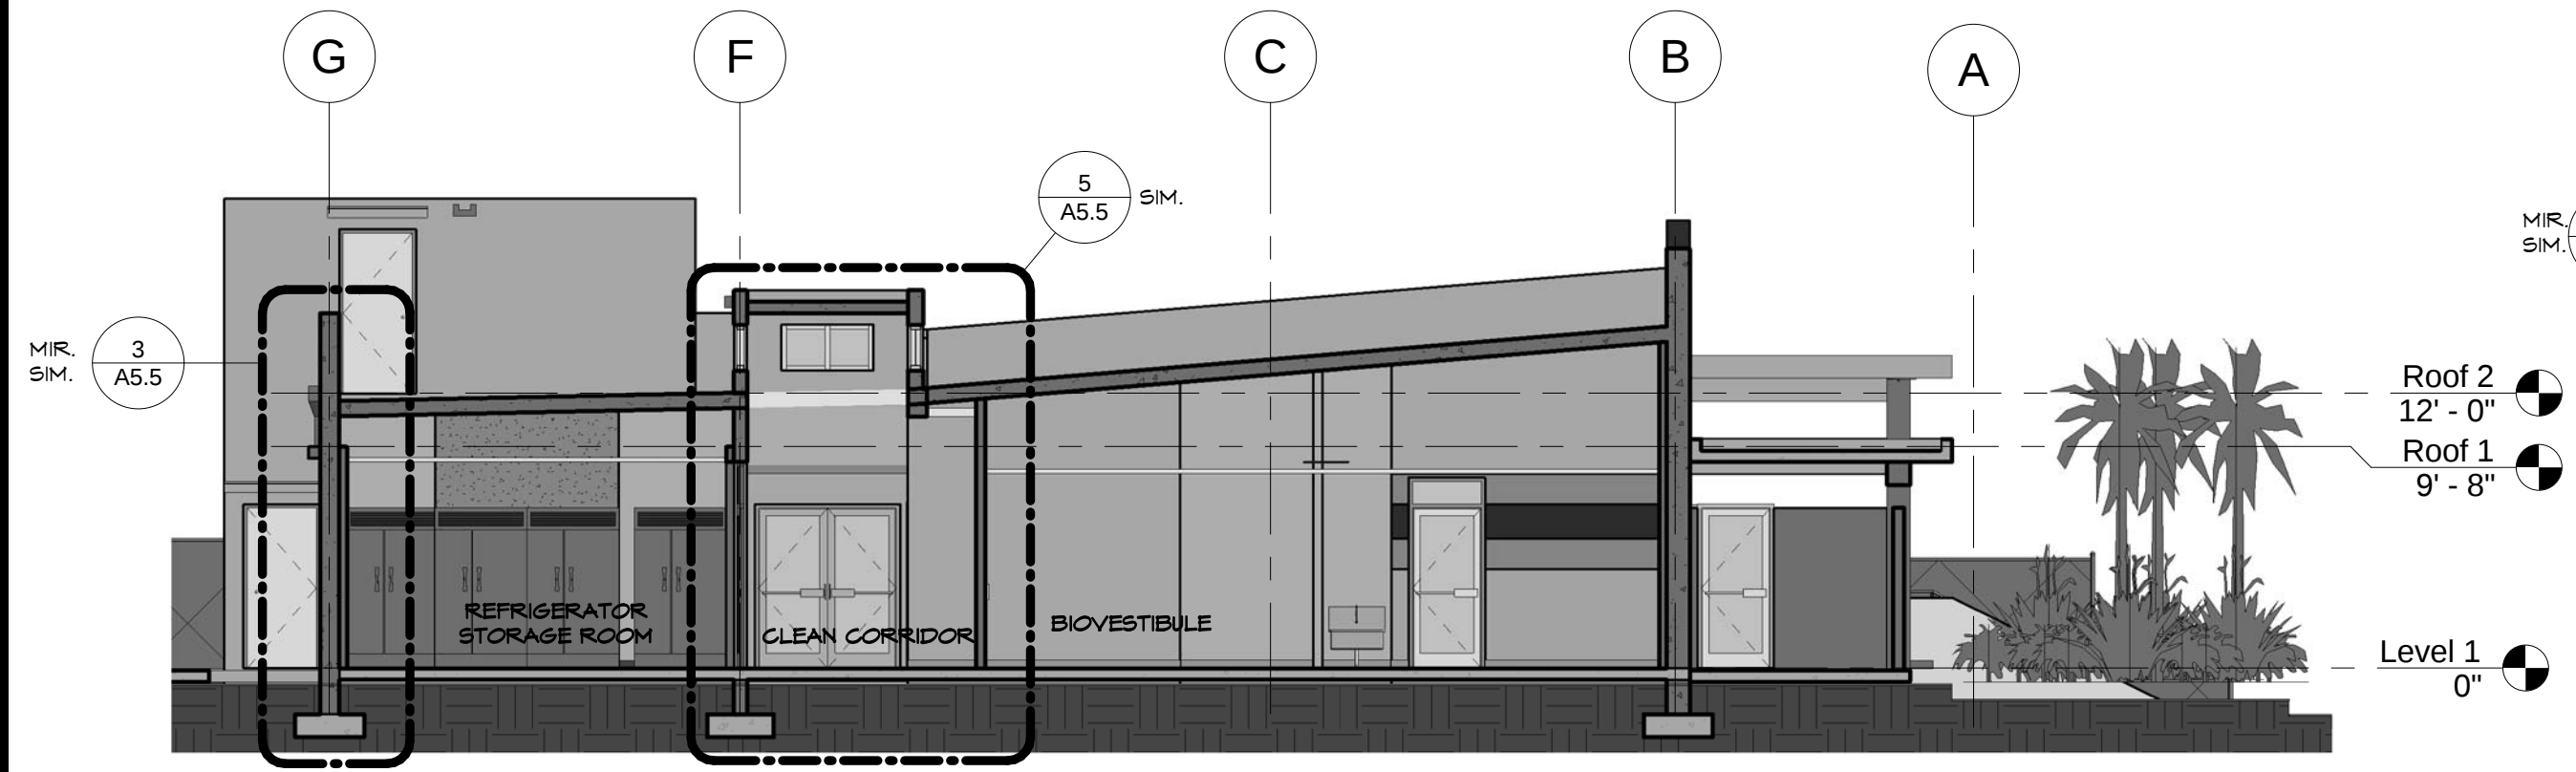

6 SECTION
SCALE: 1/8" = 1'-0"

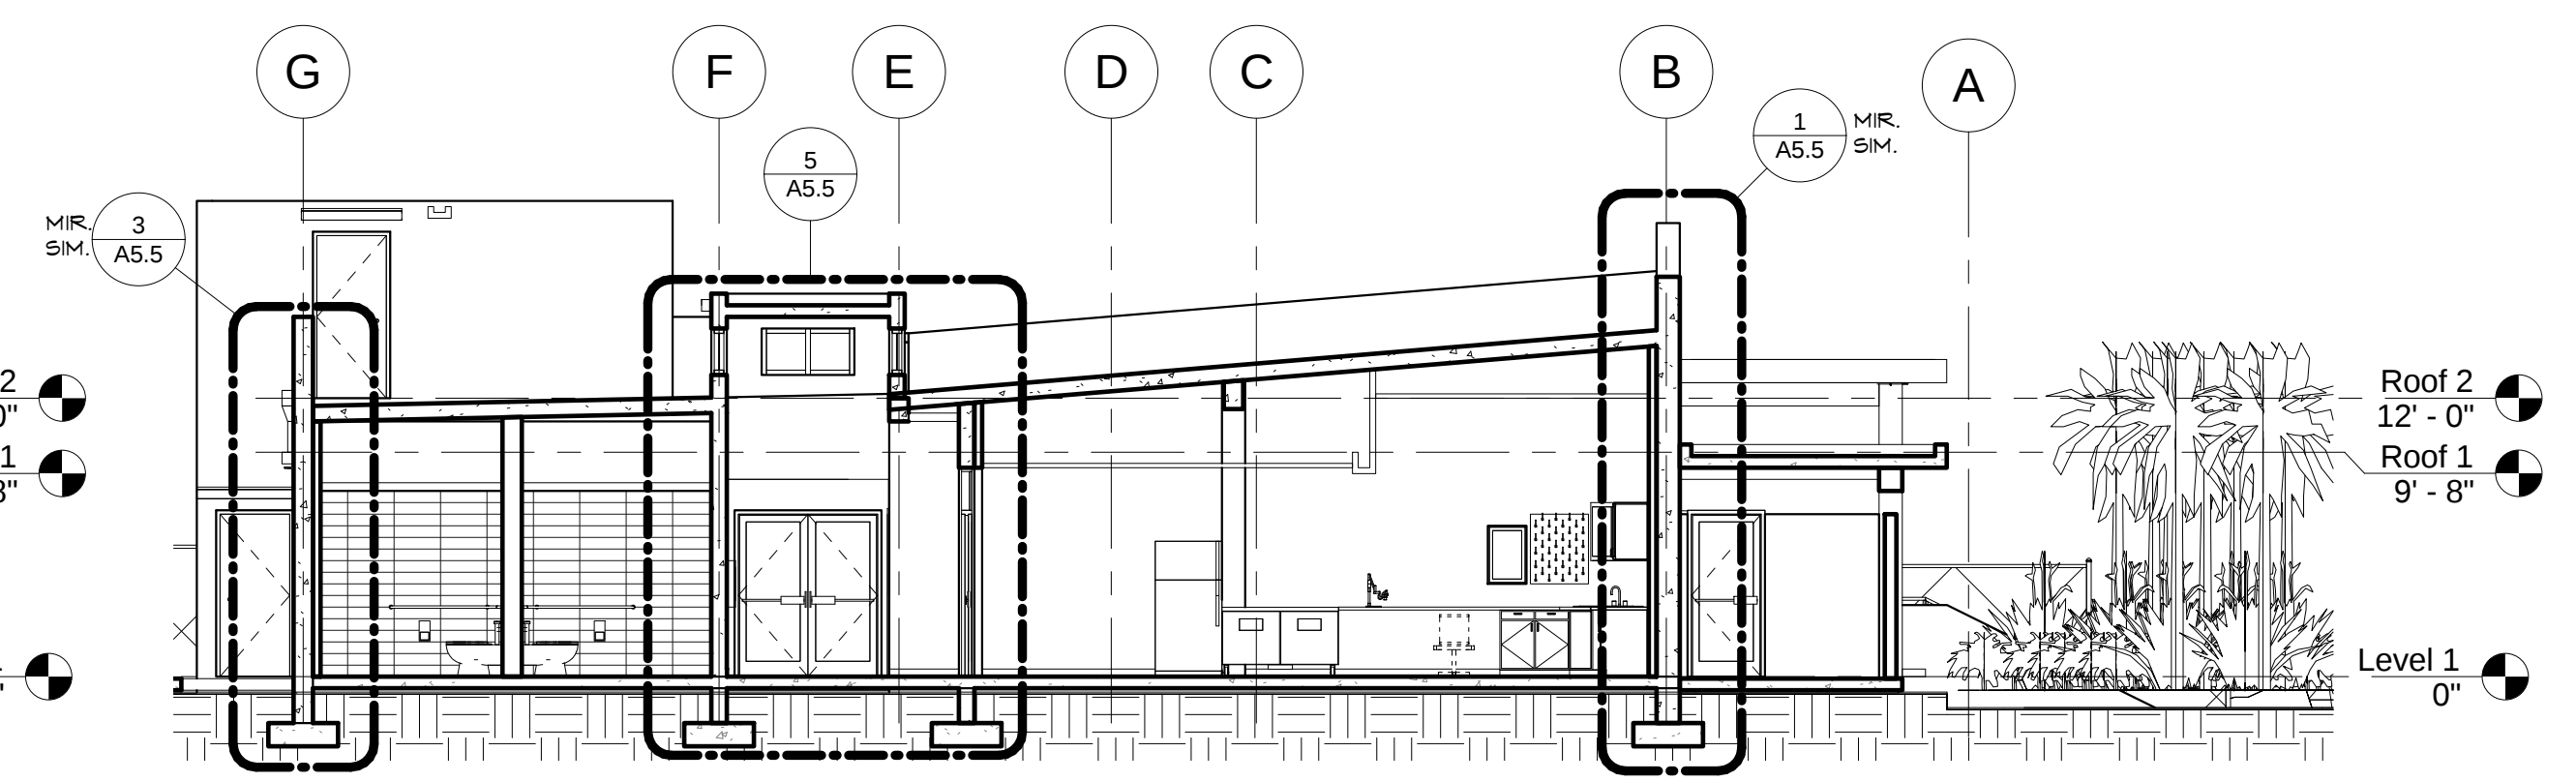

7 SECTION
SCALE: 1/8" = 1'-0"

 

IF SHEET IS LESS THAN 24" X 36"
REDUCED PRINT - USE GRAPHIC SCALES

REVISIONS		
No.	Description	Date

TRMA
Taniguchi Ruth Makio Architects
100 Cliff Business Center, P.O. Box EA, Agaña, GU 96910
Tel.: (671) 475-8772 • Fax: (671) 472-3381

Architecture
Planning
Interior Design

BID DOCUMENTS



I HEREBY CERTIFY THAT THIS PLAN WAS PREPARED BY ME OR UNDER MY DIRECT SUPERVISION
DATE: _____

Project:
**GUAM COMMUNITY COLLEGE
FORENSIC DNA LAB**

Title:
BUILDING SECTIONS

Designed: **TRMA**
Drawn: **RM/TP**
Checked: **CTC**
Supv: **MM**
Scale: 1/8" = 1'-0"
Date: 12/17/12
Project No. 1026
Drawing No.

A5.3
Sheet No. _____ of _____

REVISIONS		
No.	Description	Date

TRMA

Taniguchi Ruth Makio Architects
 100 Cliff Business Center, P.O. Box EA, Agaña, GU 96910
 Tel.: (671) 475-8772 • Fax: (671) 472-3381

Architecture
 Planning
 Interior Design

BID
 DOCUMENTS



I HEREBY CERTIFY THAT THIS PLAN WAS PREPARED
 BY ME OR UNDER MY DIRECT SUPERVISION
 DATE: _____


Project:
 GUAM COMMUNITY
 COLLEGE
 FORENSIC DNA LAB

Title:
 BUILDING SECTIONS


Designed: **TRMA**
 Drawn: **RM/TP**
 Checked: **CTC**
 Supv: **MMM**
 Scale: **1/8" = 1'-0"**
 Date: **12/17/12**
 Project No. **1026** File
 Drawing No.

A5.4


Sheet No. _____ of _____

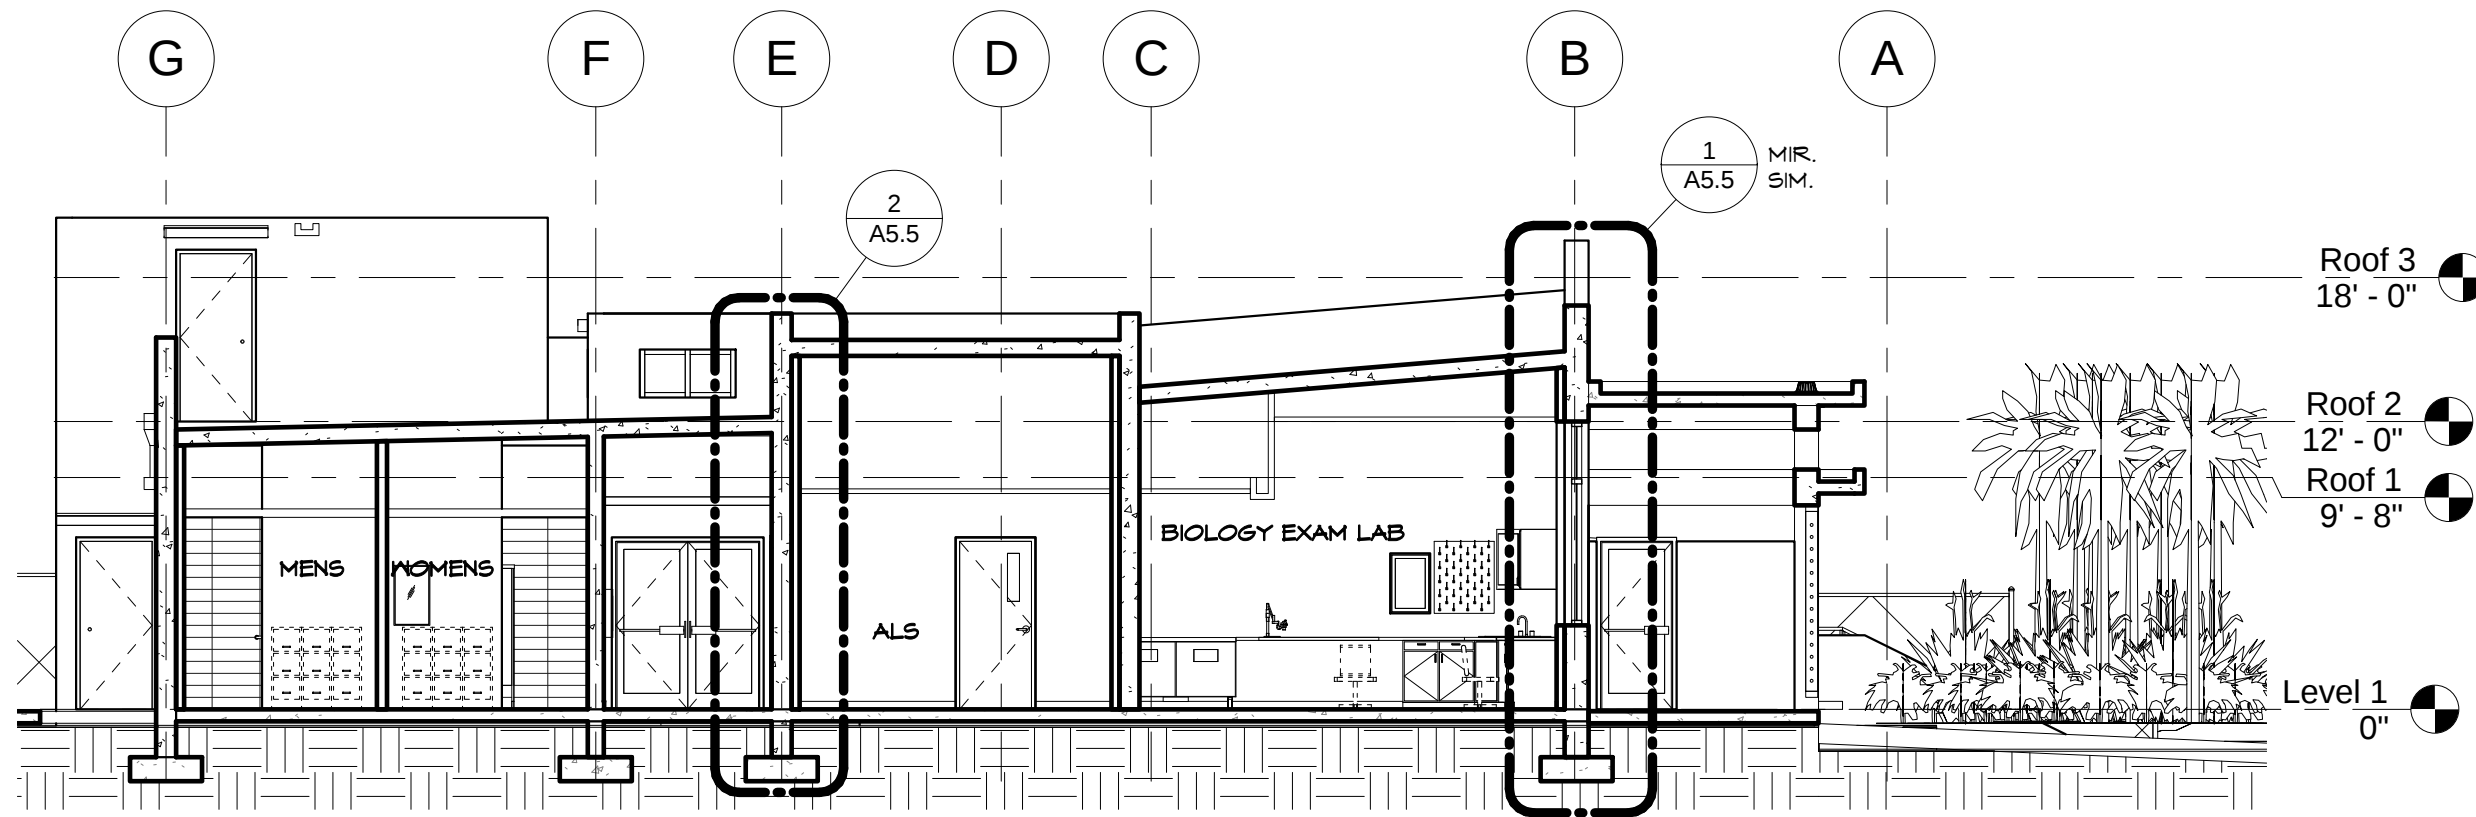


1 SECTION
 SCALE: 1/8" = 1'-0"

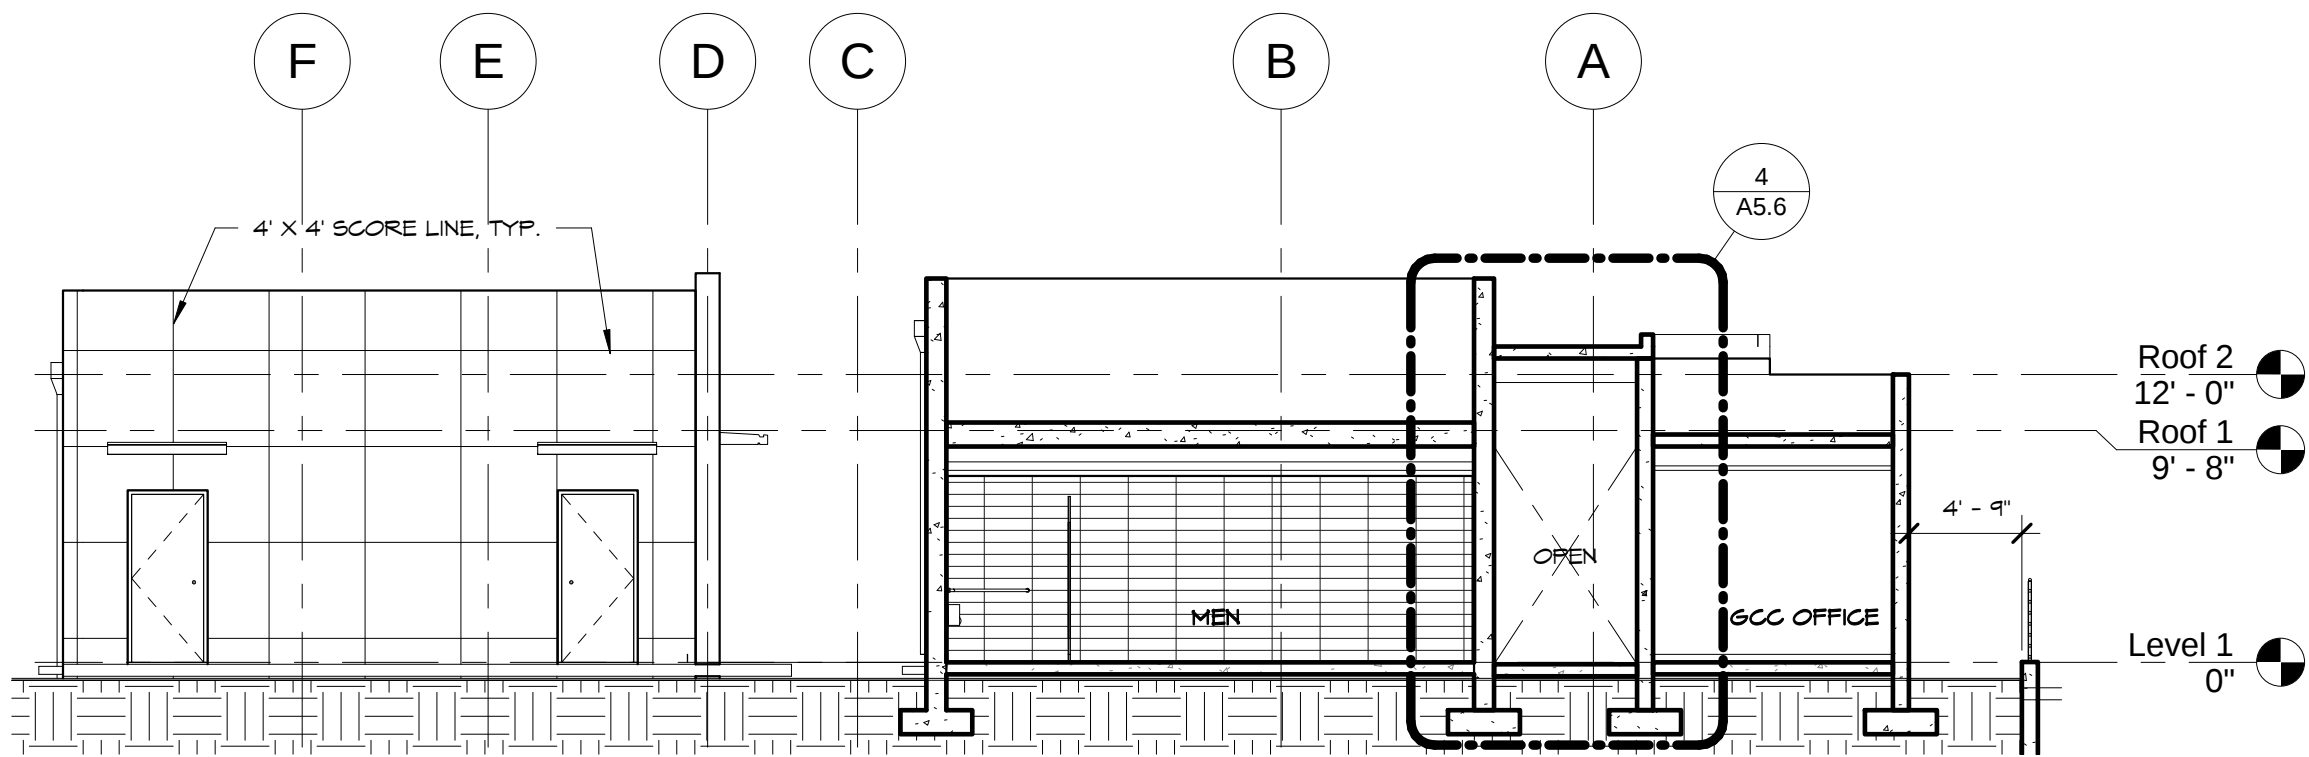

3 SECTION
 SCALE: 1/8" = 1'-0"

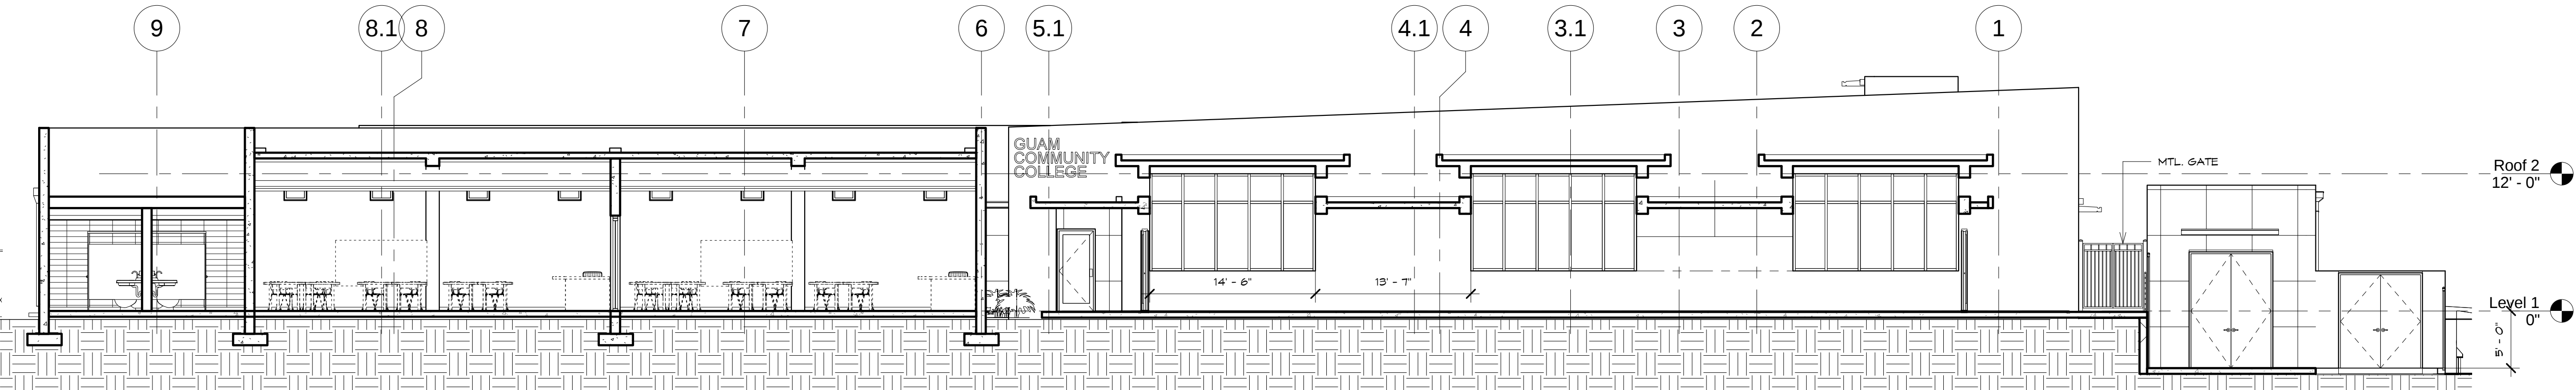


2 SECTION
 SCALE: 1/8" = 1'-0"

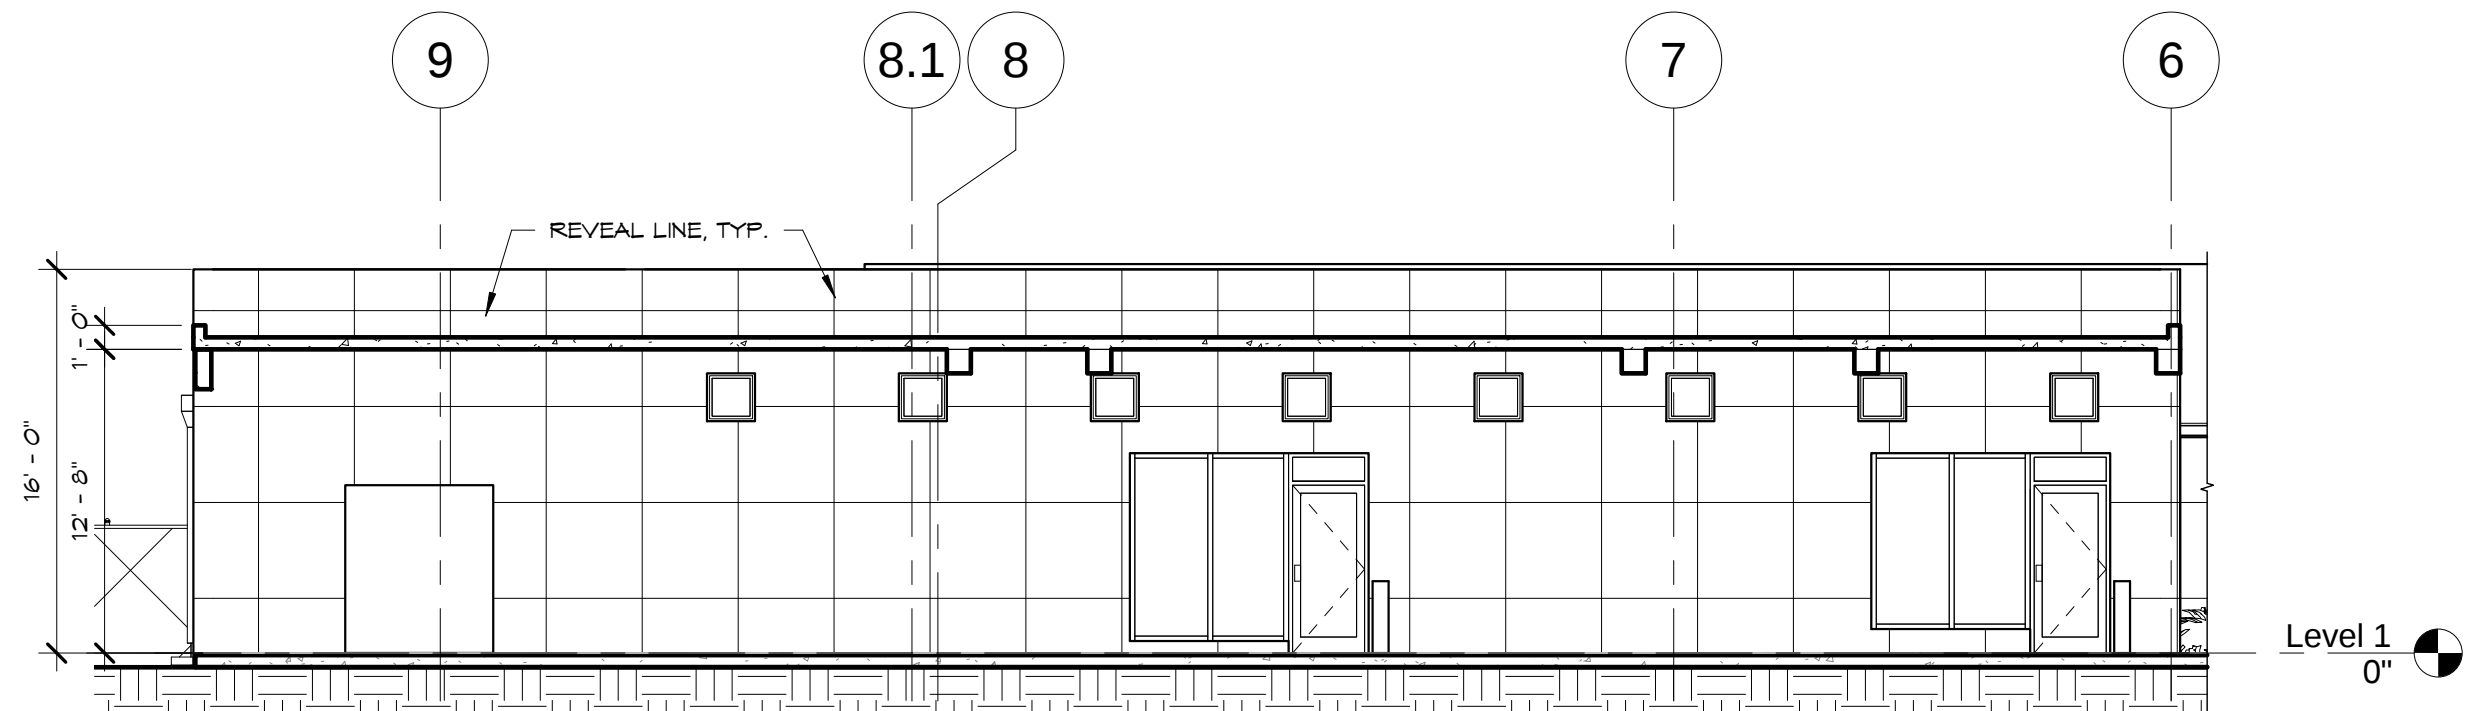


4 PORTICO SECTION
 SCALE: 1/8" = 1'-0"

IF SHEET IS LESS THAN 24" X 36"
 REDUCED PRINT - USE GRAPHIC SCALES

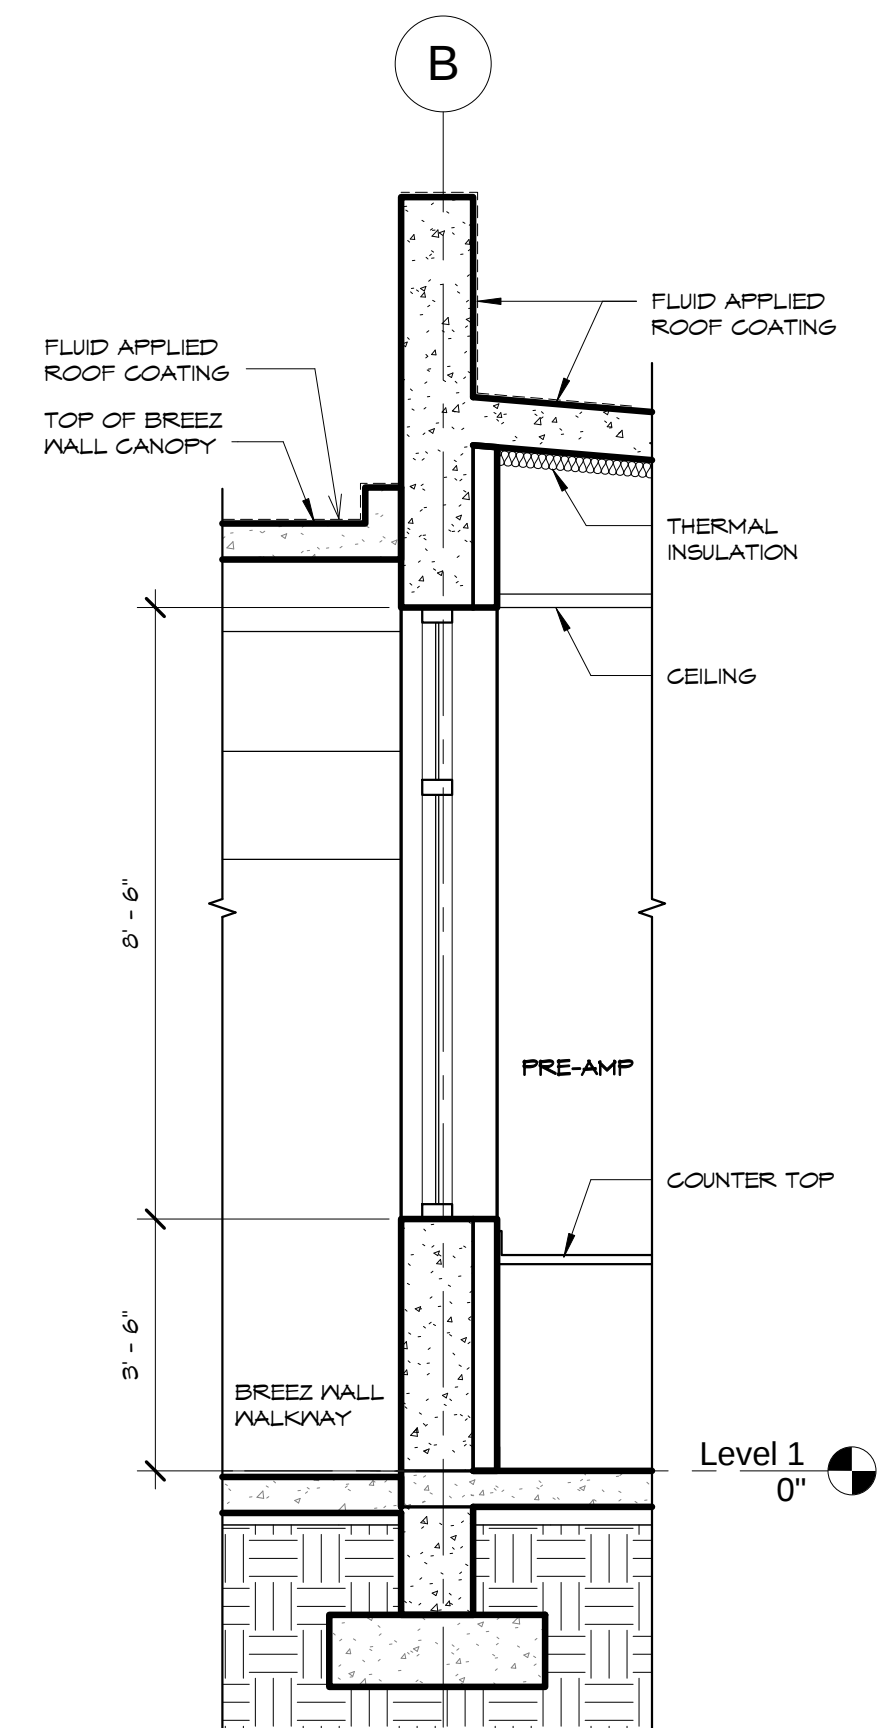


**WALL DETAIL @
GRIDLINE "B" (2)**

SCALE: 3/8" = 1'-0"

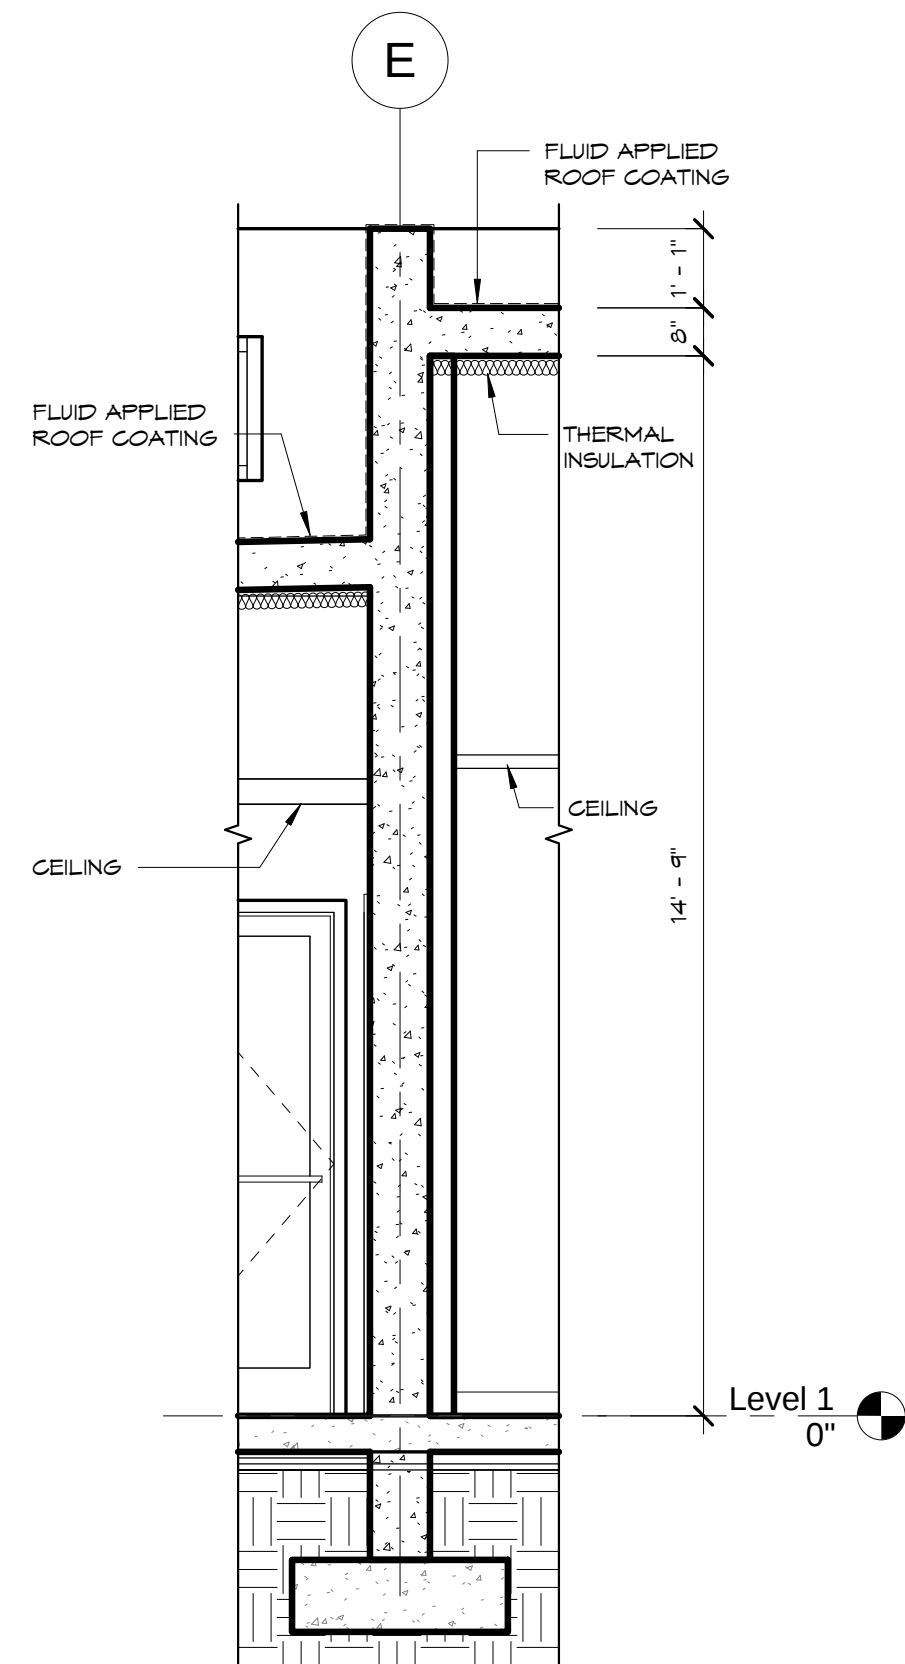


**WALL DETAIL @
GRIDLINE "E" (2)**

SCALE: 3/8" = 1'-0"

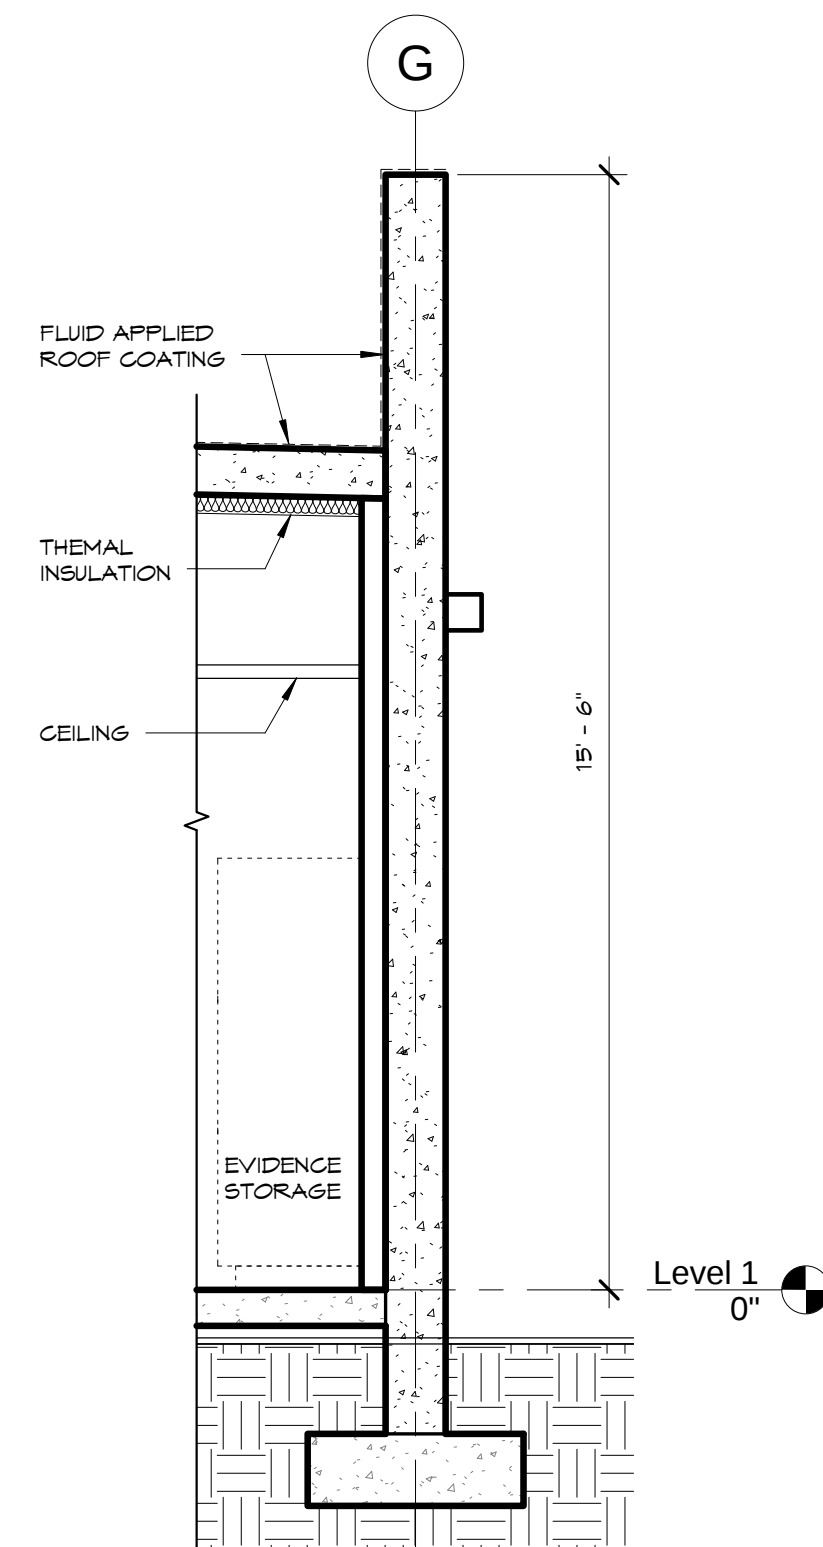


**WALL DETAIL @
GRIDLINE "G" (2)**

SCALE: 3/8" = 1'-0"

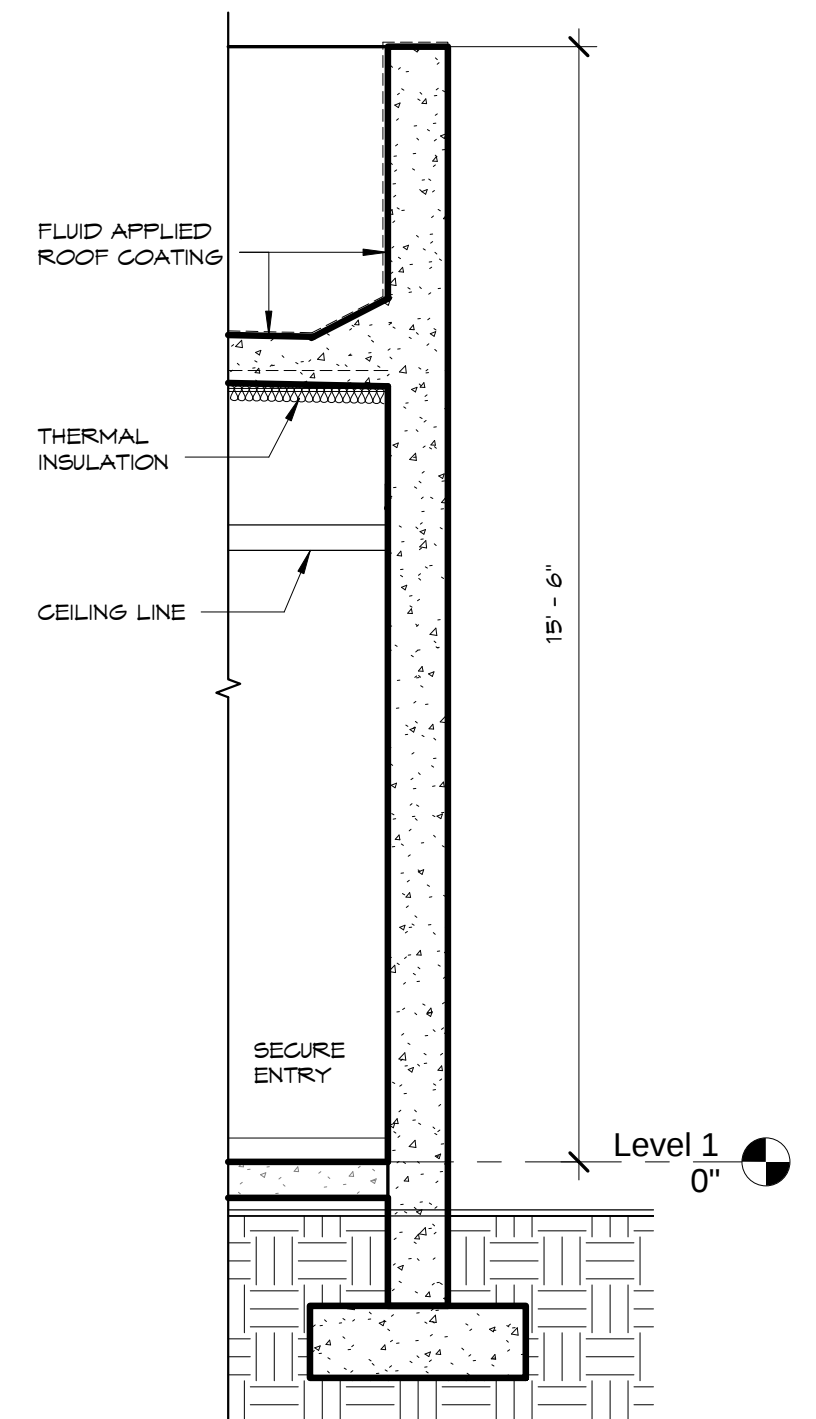


**WALL DETAIL @
GRIDLINE "G"**

SCALE: 3/8" = 1'-0"

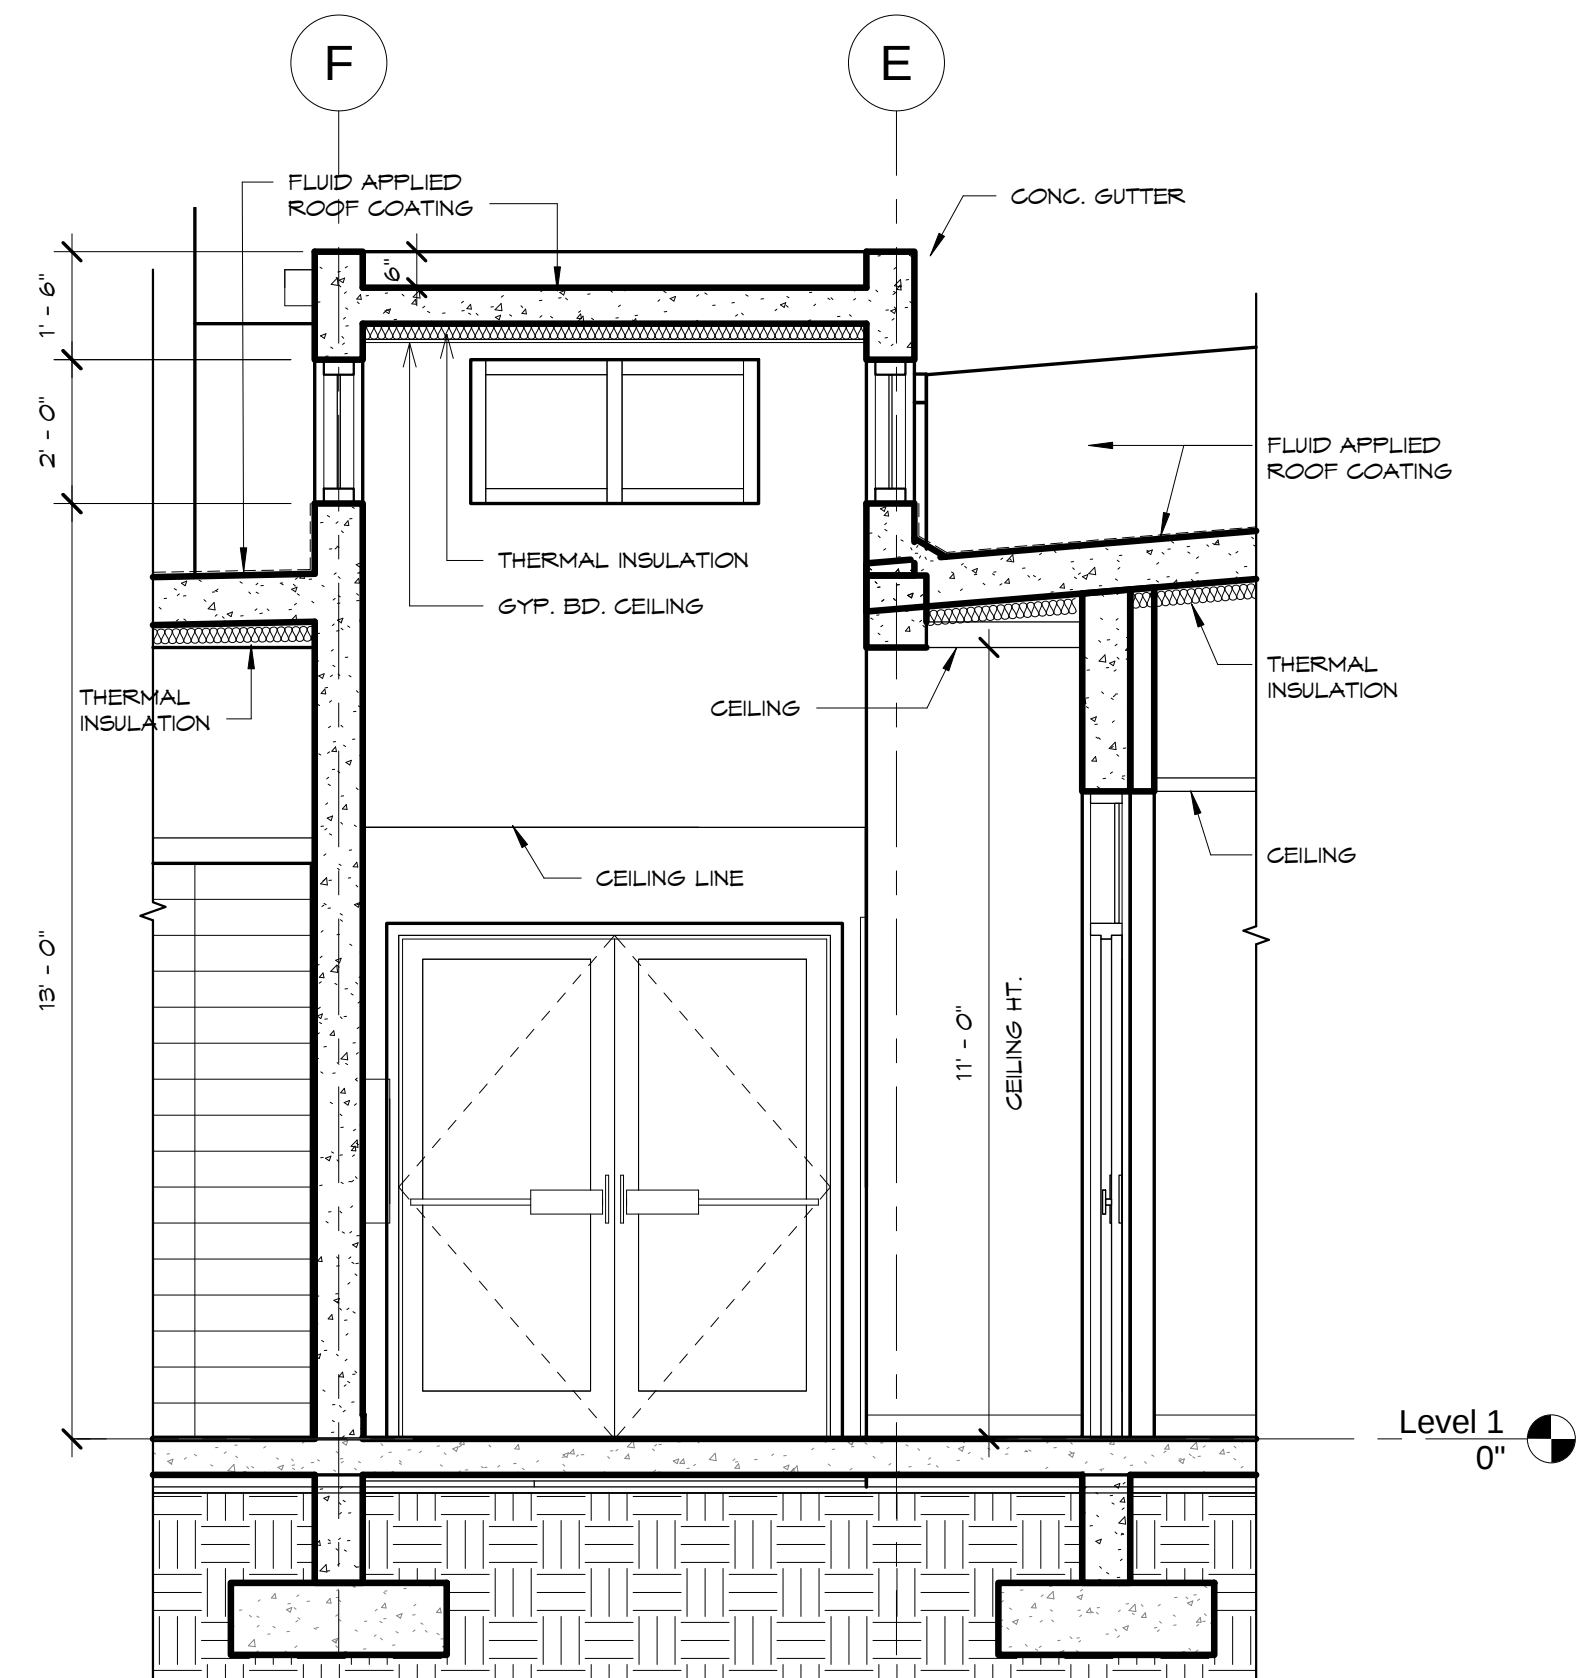


**WALL DETAIL @ GRIDLINE "F
& E"**

SCALE: 3/8" = 1'-0"

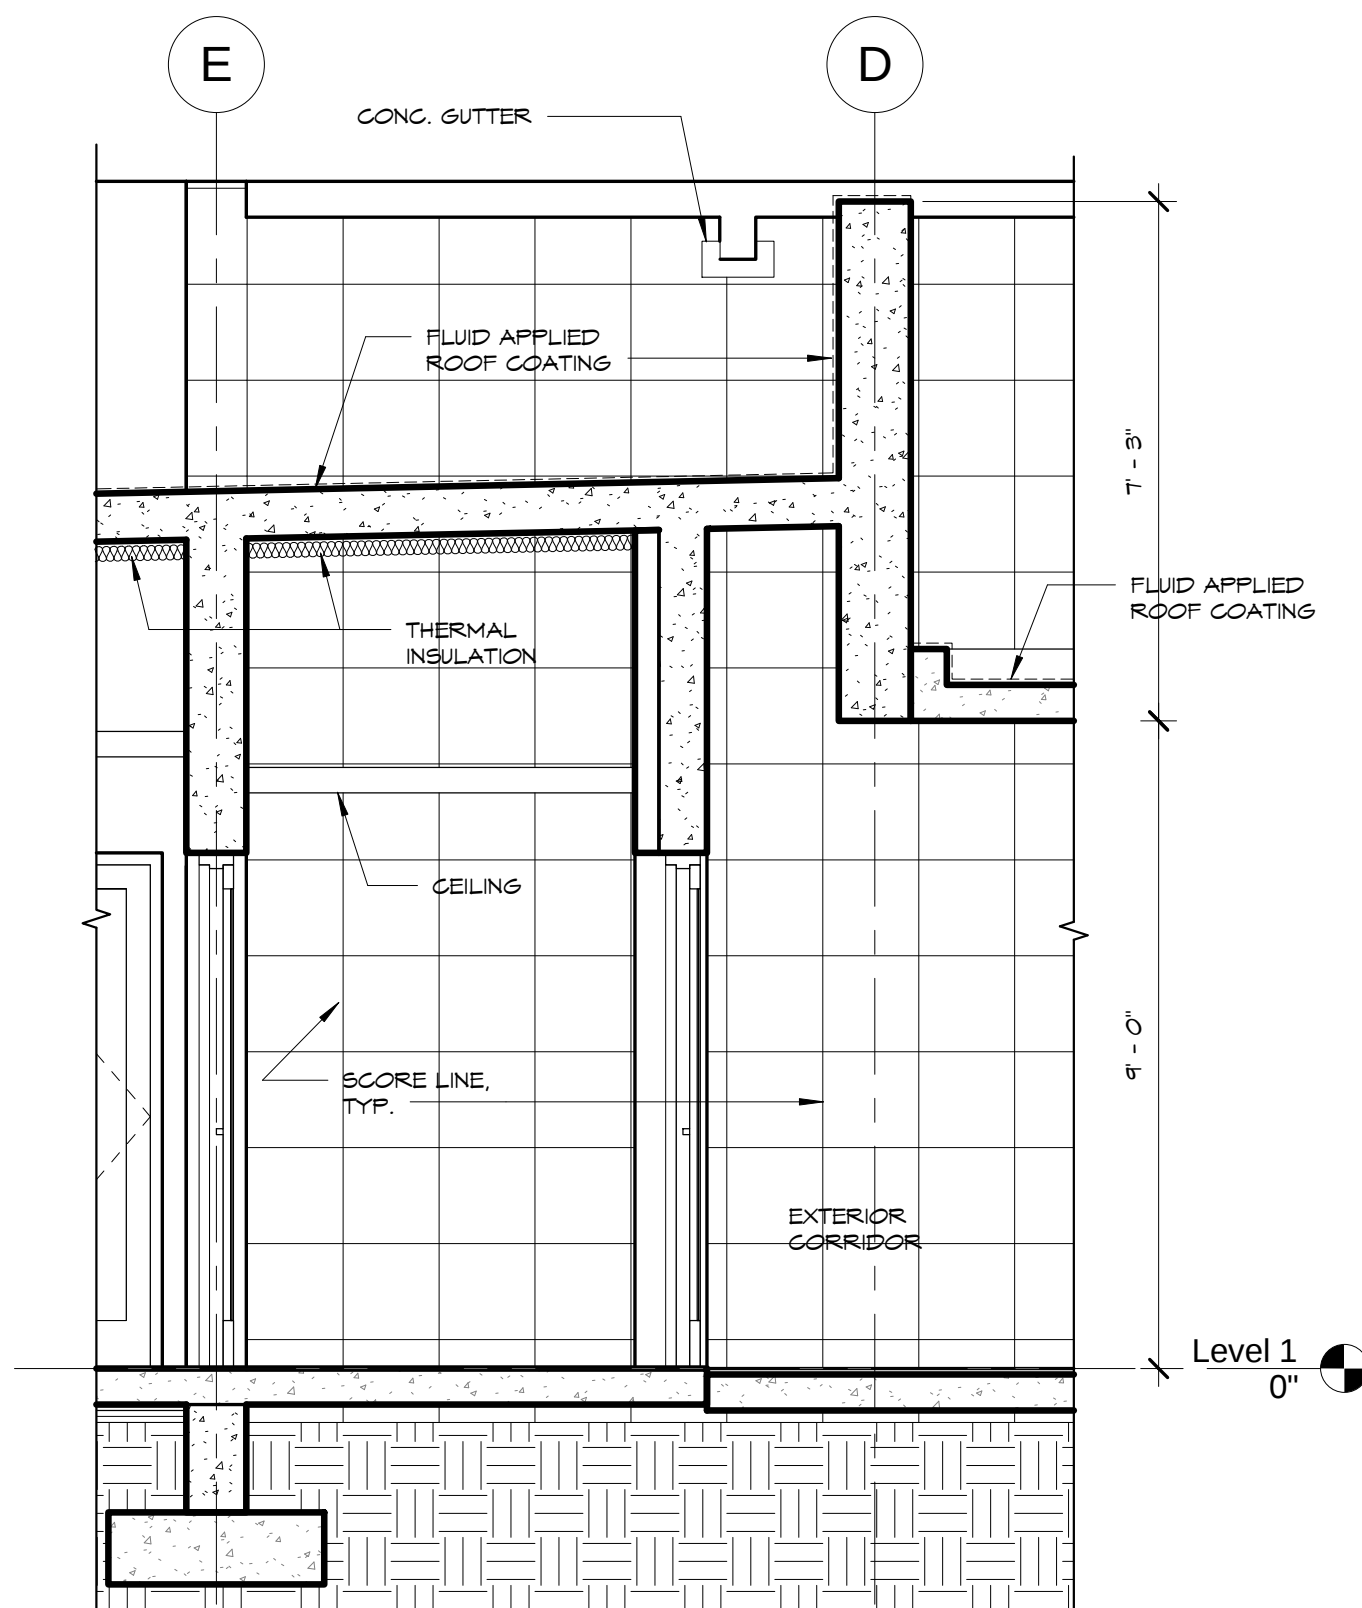

**WALL DETAIL
GRID E, D**

SCALE: 3/8" = 1'-0"

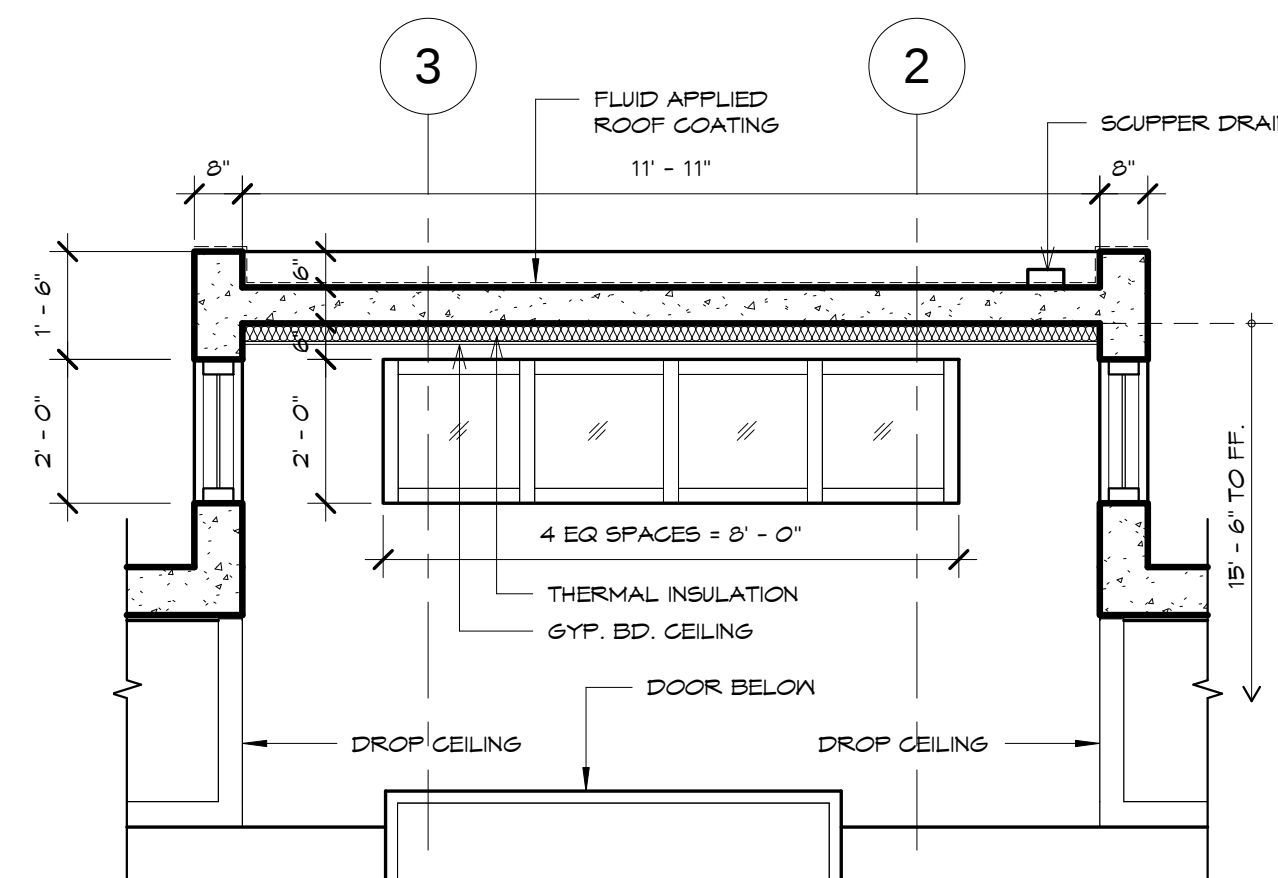

**CLEARSTORY - WALL
SECTION**

SCALE: 3/8" = 1'-0"

REVISIONS		
No.	Description	Date

TRMA
Taniguchi Ruth Makio Architects
100 Cliff Business Center, P.O. Box EA, Agaña, GU 96910
Tel.: (671) 475-8772 • Fax: (671) 472-3381

Architecture
Planning
Interior Design

**BID
DOCUMENTS**



I HEREBY CERTIFY THAT THIS PLAN WAS PREPARED
BY ME OR UNDER MY DIRECT SUPERVISION
DATE: _____


Project:
**GUAM COMMUNITY
COLLEGE
FORENSIC DNA LAB**

Title:
WALL SECTIONS

Designed: **TRMA**
Drawn: **RM/TP**
Checked: **CTC**
Supv: **MMM**
Scale: **3/8" = 1'-0"**
Date: **12/17/12**
Project No. **1026** File
Drawing No.


A5.5
Sheet No. _____ of _____

IF SHEET IS LESS THAN 24" X 36"
REDUCED PRINT - USE GRAPHIC SCALES

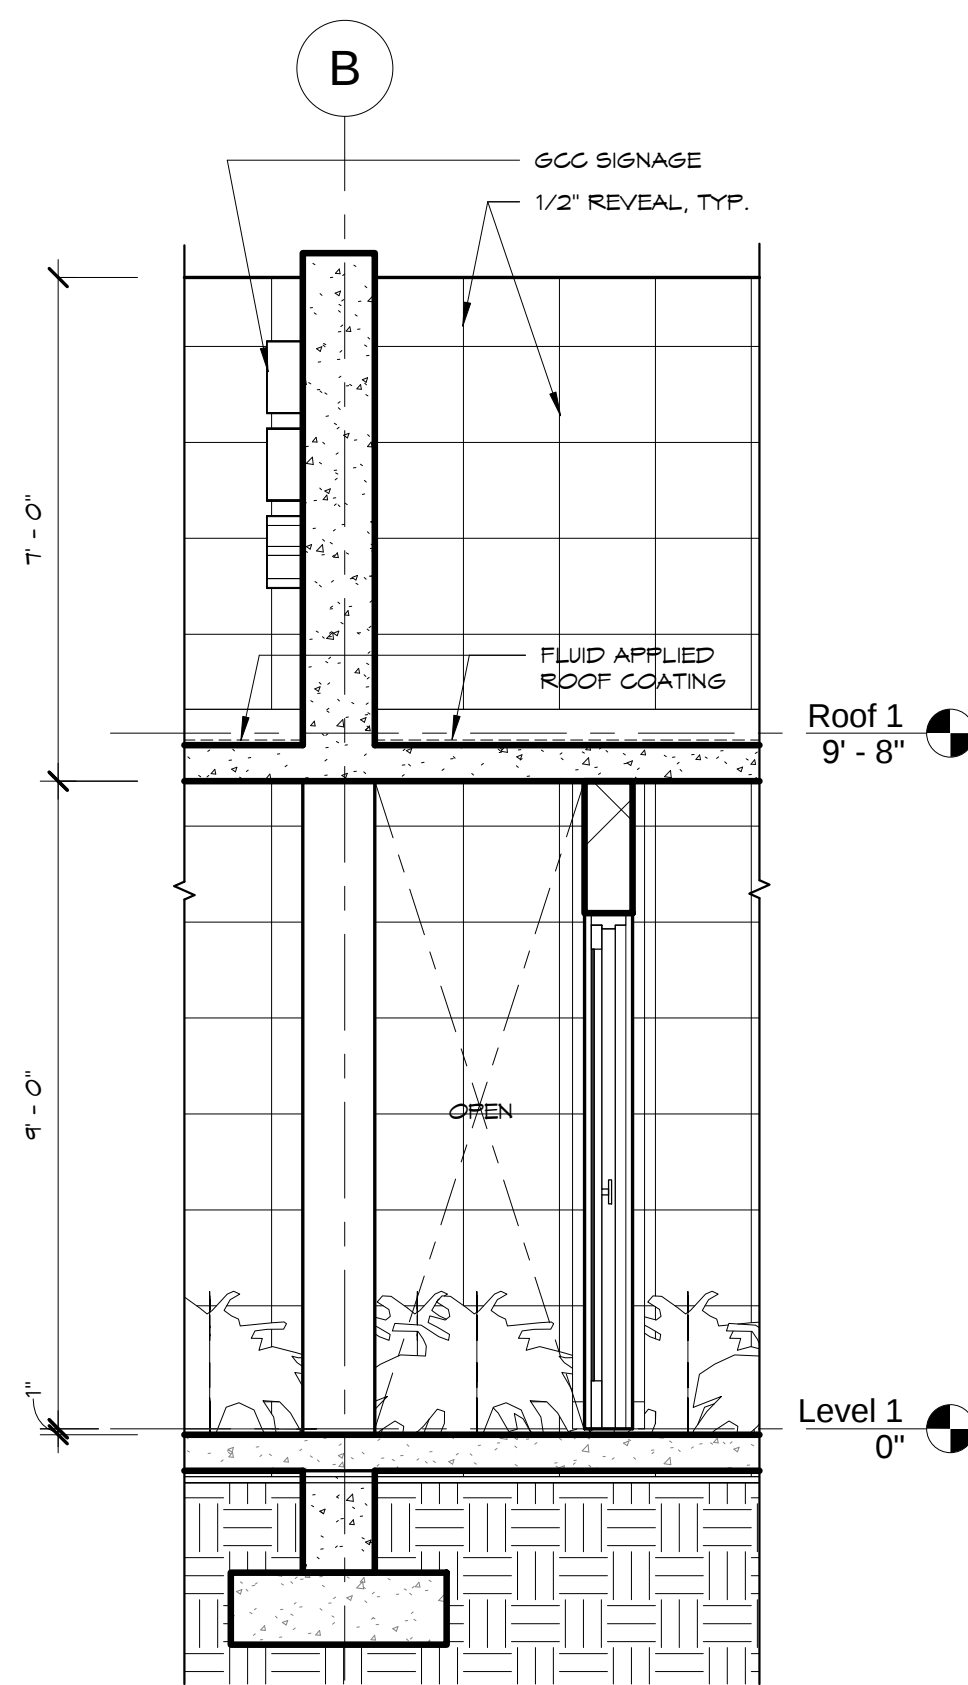


**WALL SECTION
GRID B & 5.1**

SCALE: 3/8" = 1'-0"

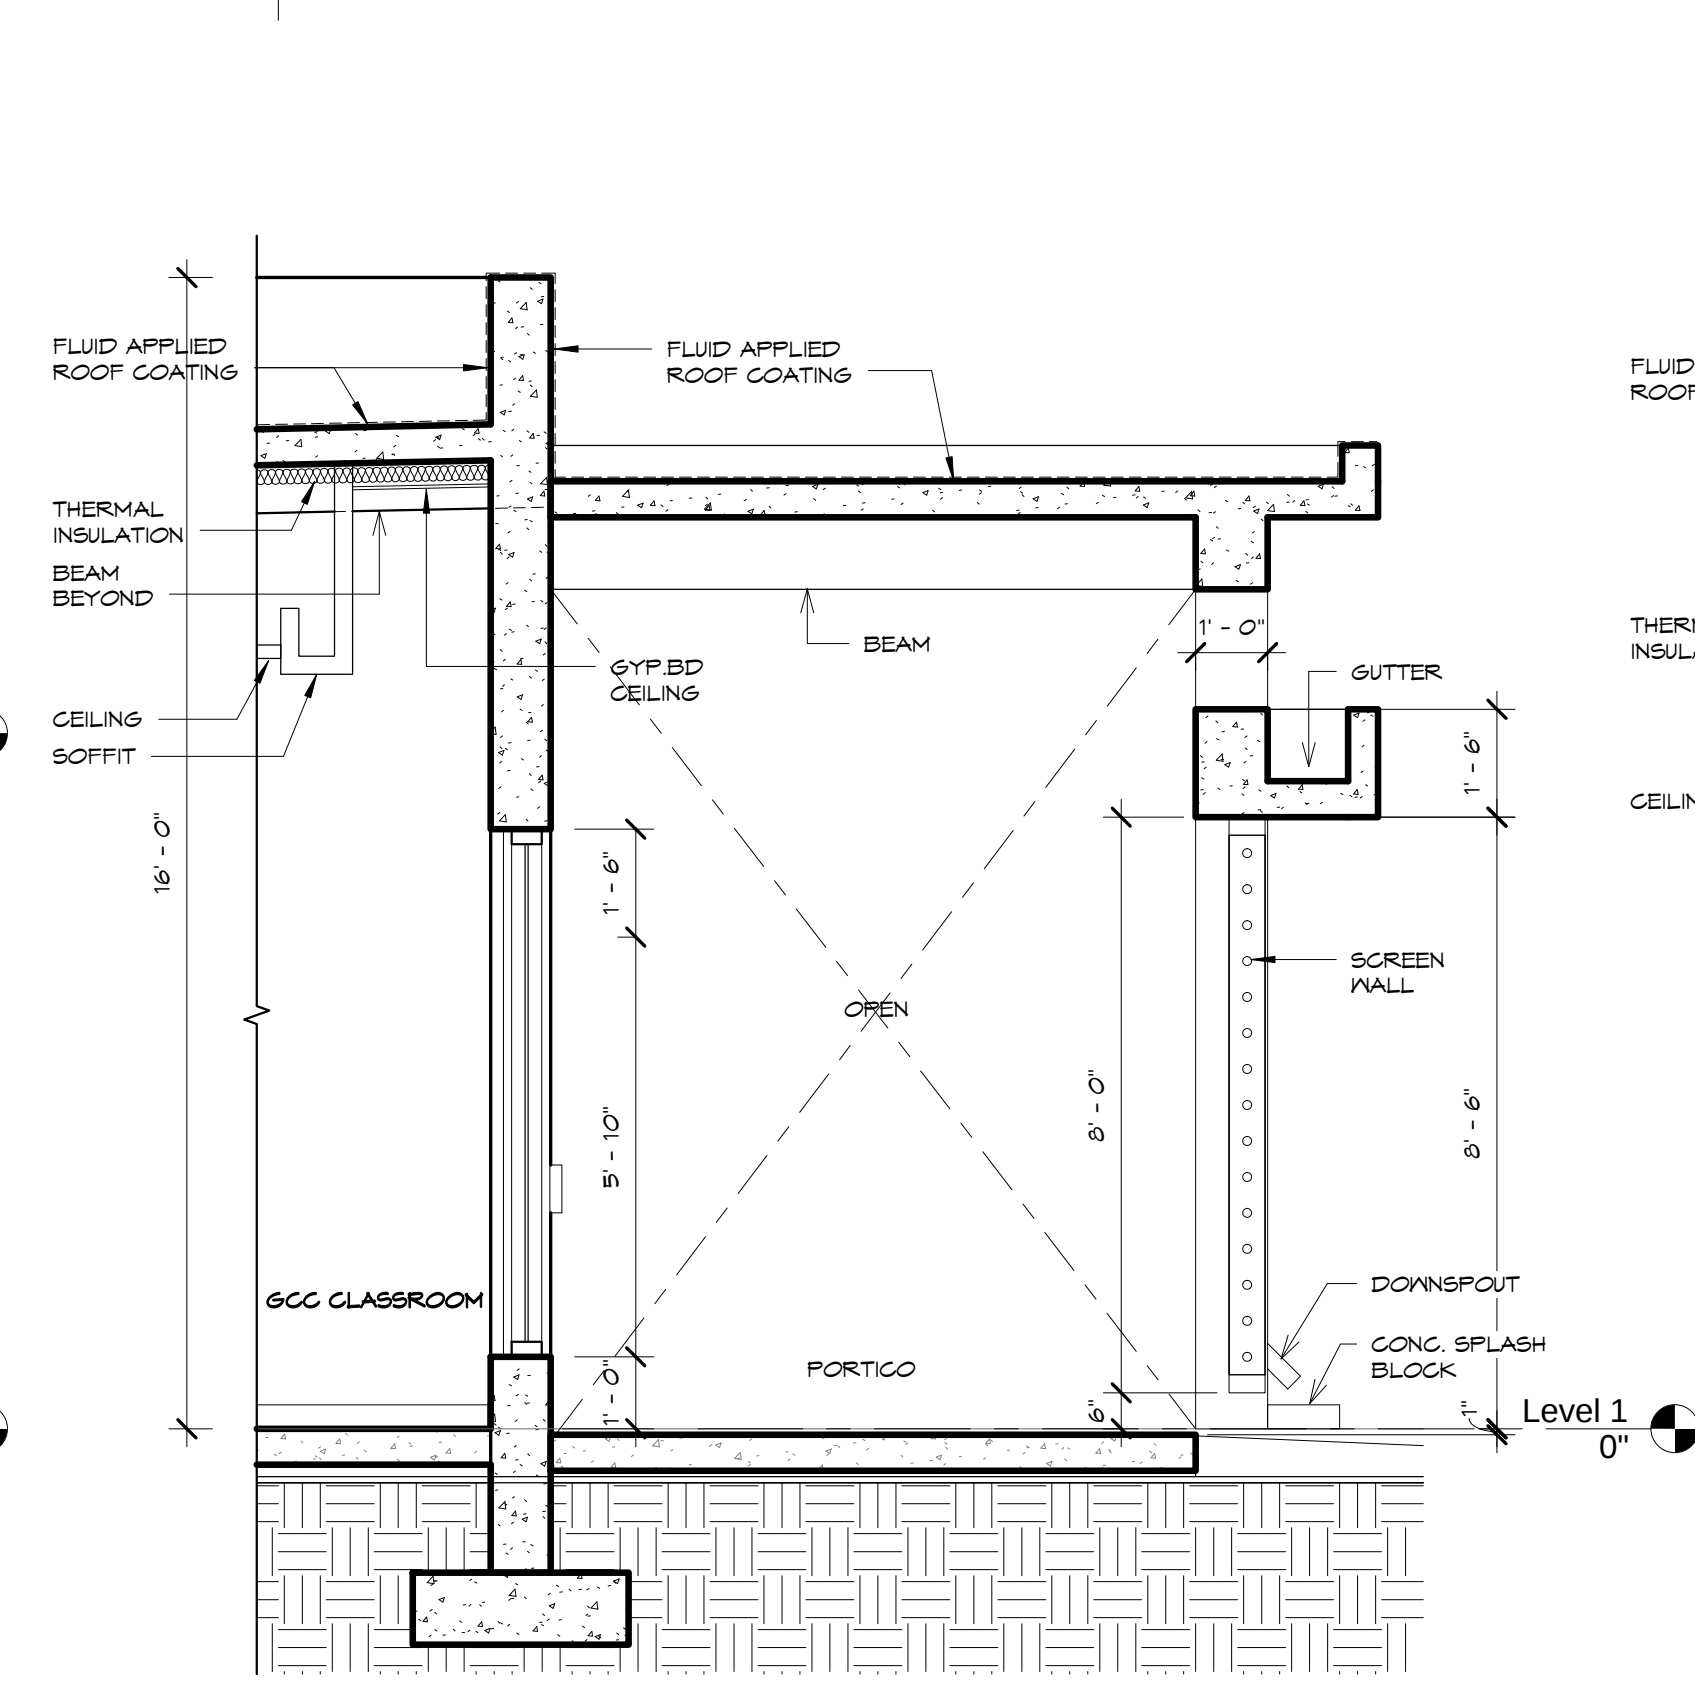


WALL SECTION

SCALE: 3/8" = 1'-0"

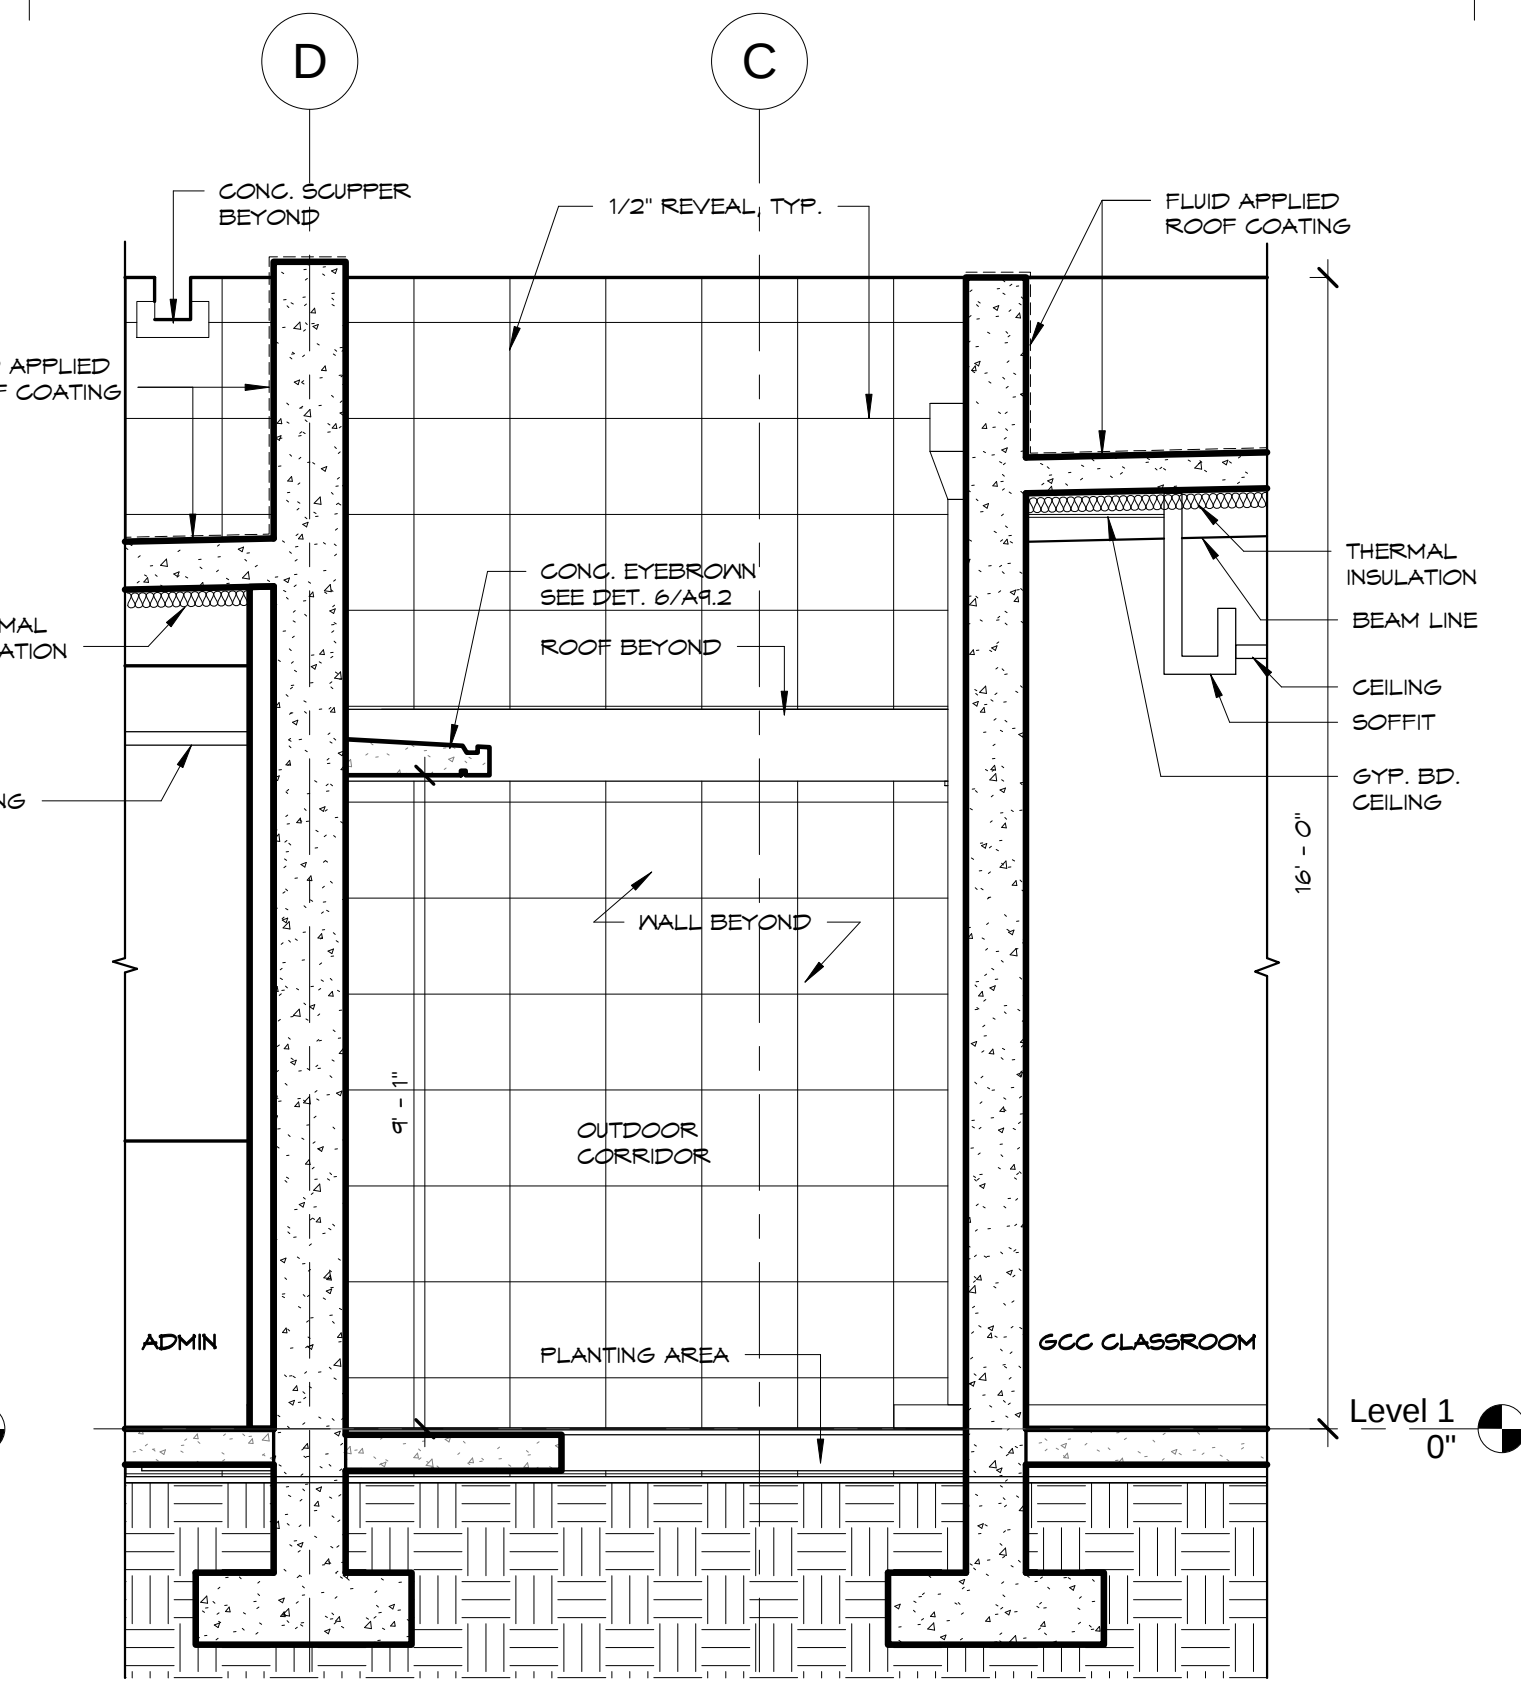


**WALL SECTION @
GRID D, C, 6**

SCALE: 3/8" = 1'-0"

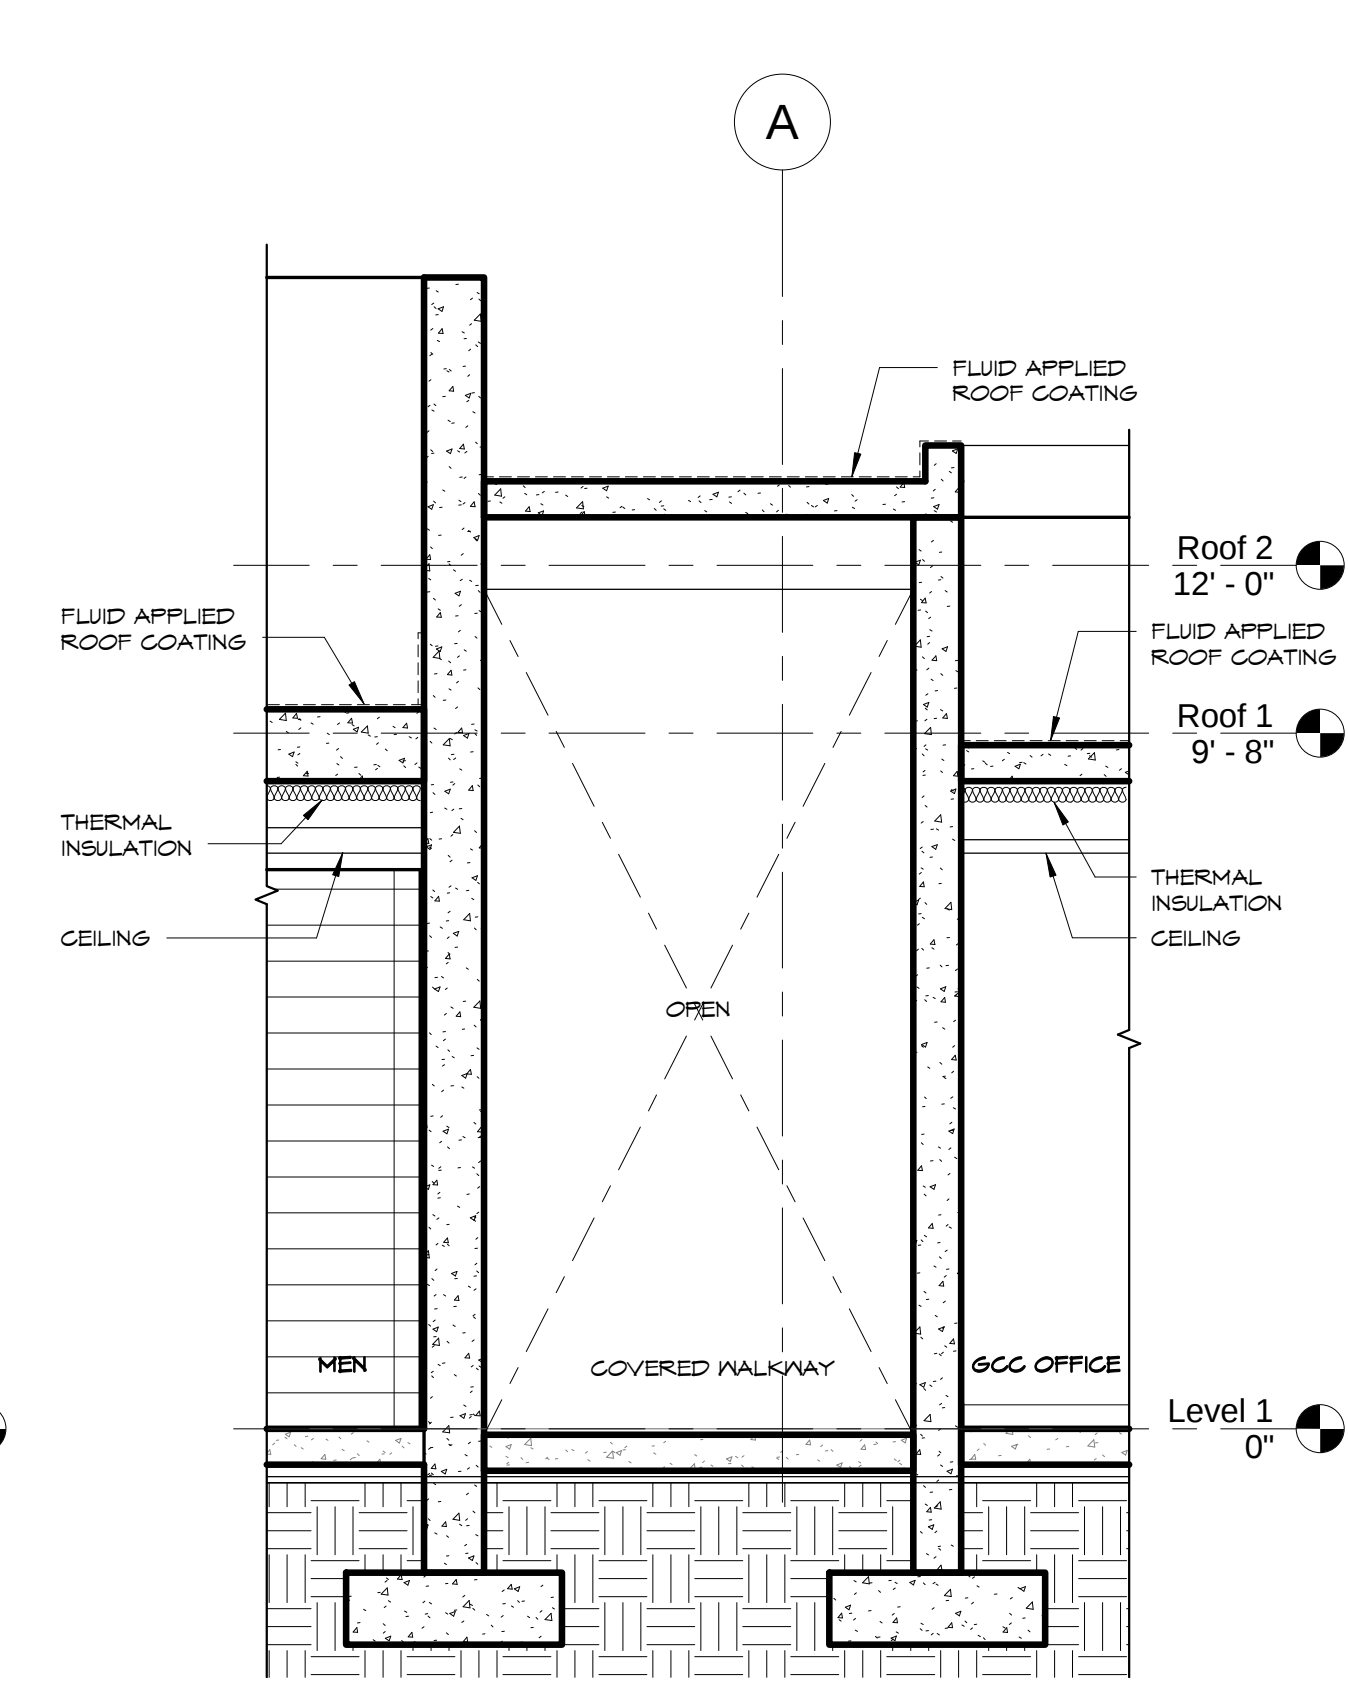


**WALL SECTION
GRID A & 9**

SCALE: 3/8" = 1'-0"

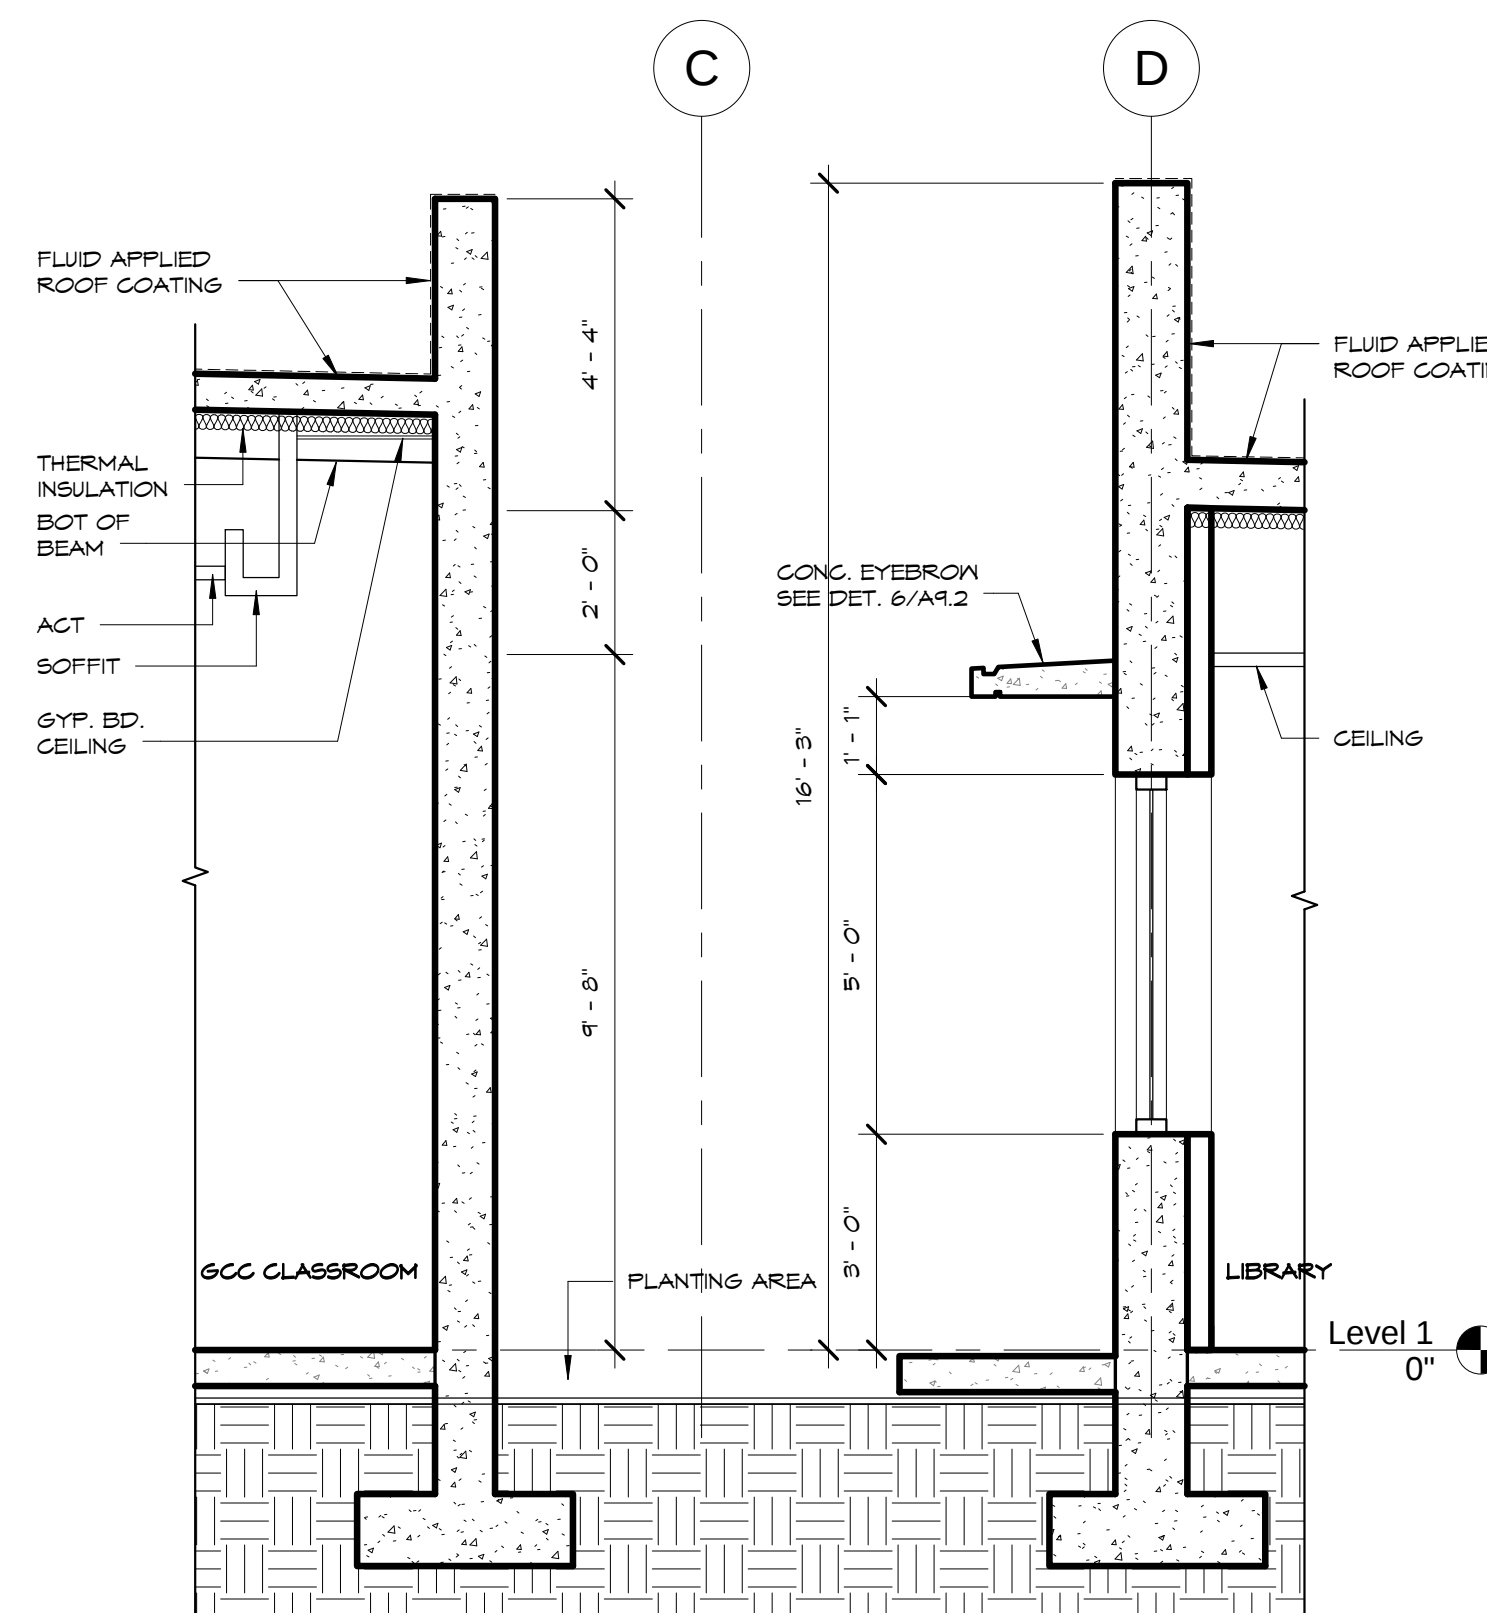

**WALL DETAIL @
GRIDLINE "C", "D"**

SCALE: 3/8" = 1'-0"

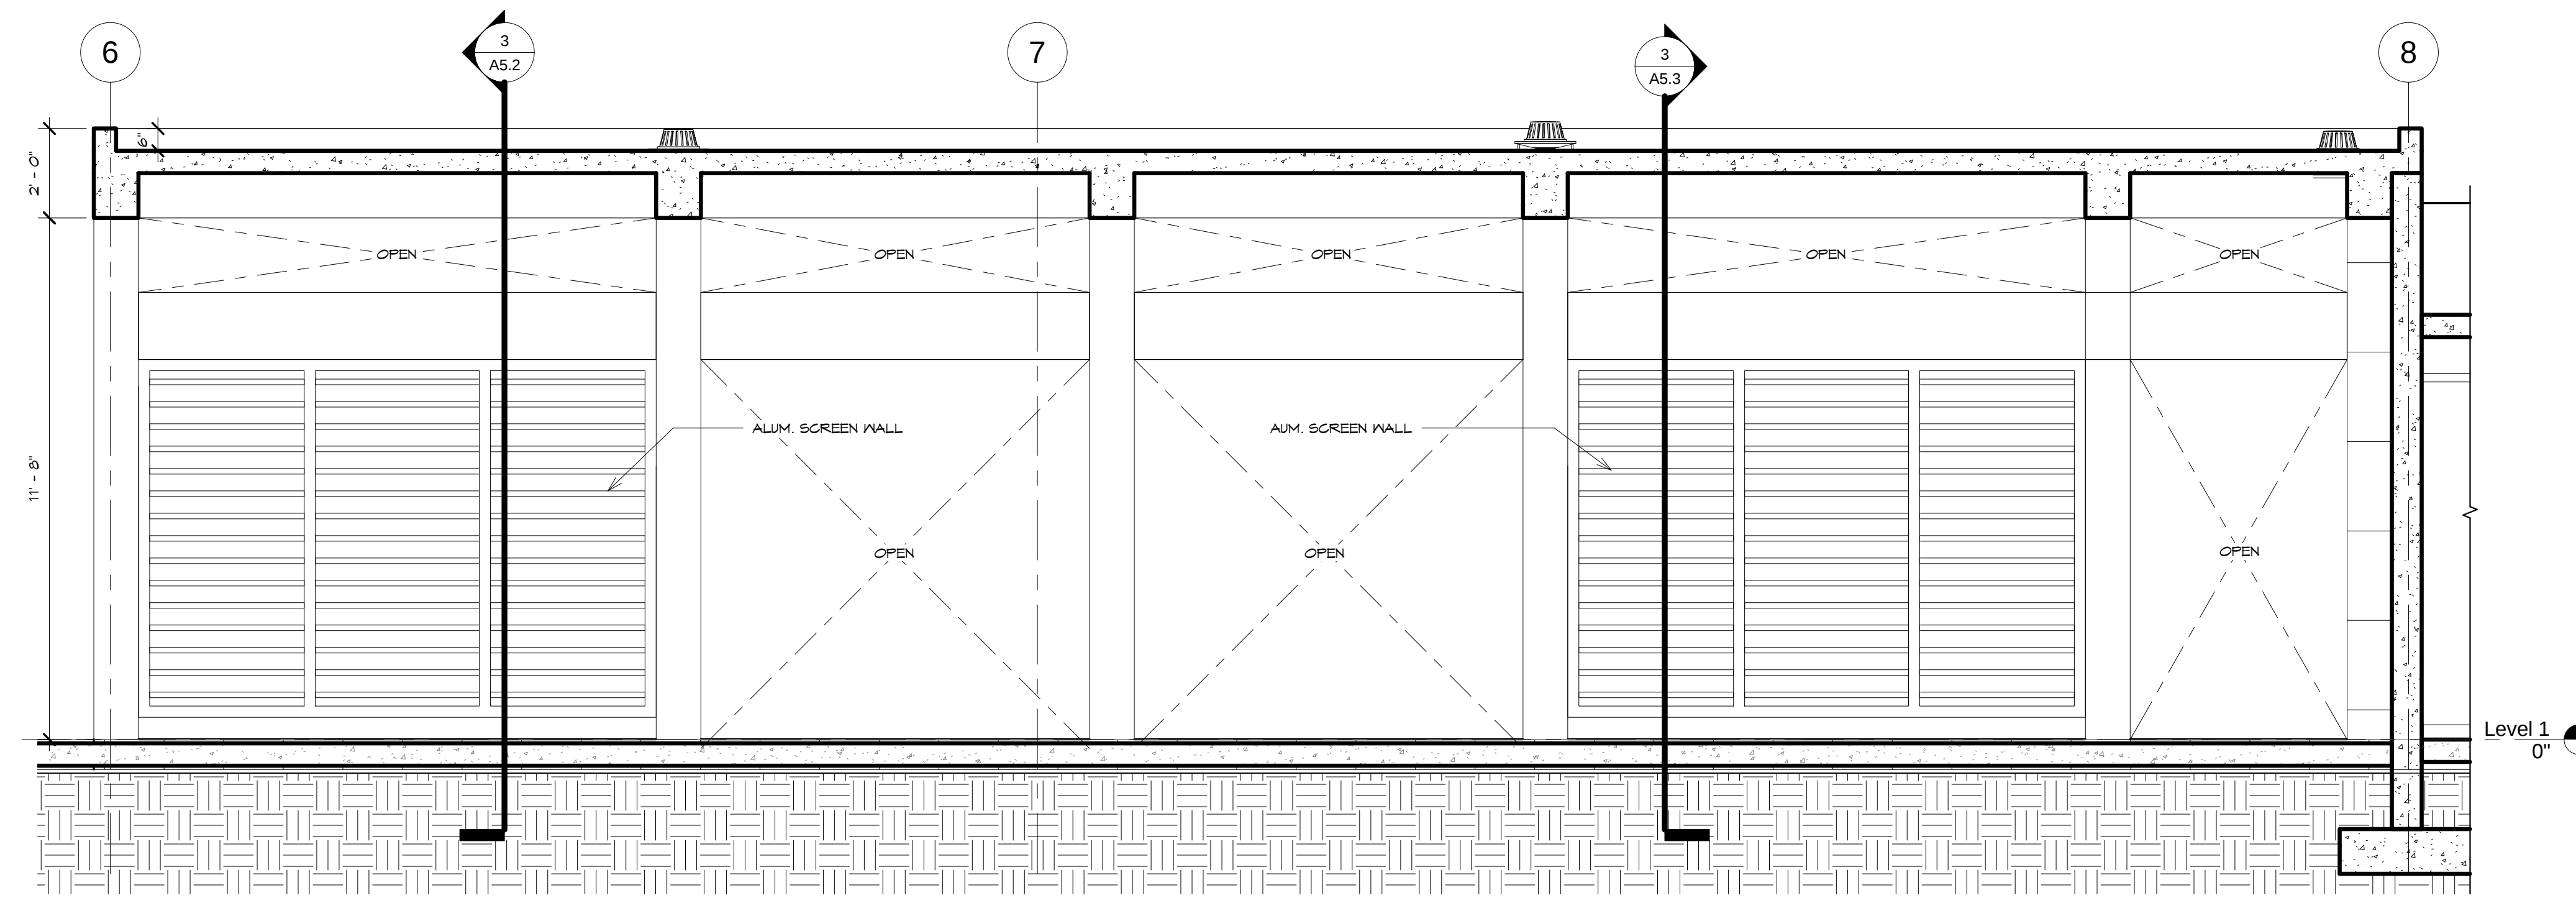

**BREEZ WALL WALKWAY
SECTION 2**

SCALE: 3/8" = 1'-0"

REVISIONS		
No.	Description	Date

TRMA
Taniguchi Ruth Makio Architects
 100 Cliff Business Center, P.O. Box EA, Agaña, GU 96910
 Tel.: (671) 475-8772 • Fax: (671) 472-3381

Architecture
 Planning
 Interior Design

**BID
DOCUMENTS**

I HEREBY CERTIFY THAT THIS PLAN WAS PREPARED BY ME OR UNDER MY DIRECT SUPERVISION.

DATE: _____


Project:
**GUAM COMMUNITY COLLEGE
 FORENSIC DNA LAB**

Title:
WALL SECTIONS


Designed: **TRMA**
 Drawn: **RM/TP**
 Checked: **CTC**
 Supv: **MM**
 Scale: **3/8" = 1'-0"**
 Date: **12/17/12**
 Project No. **1026**
 Drawing No. _____

A5.6

Sheet No. _____ of _____

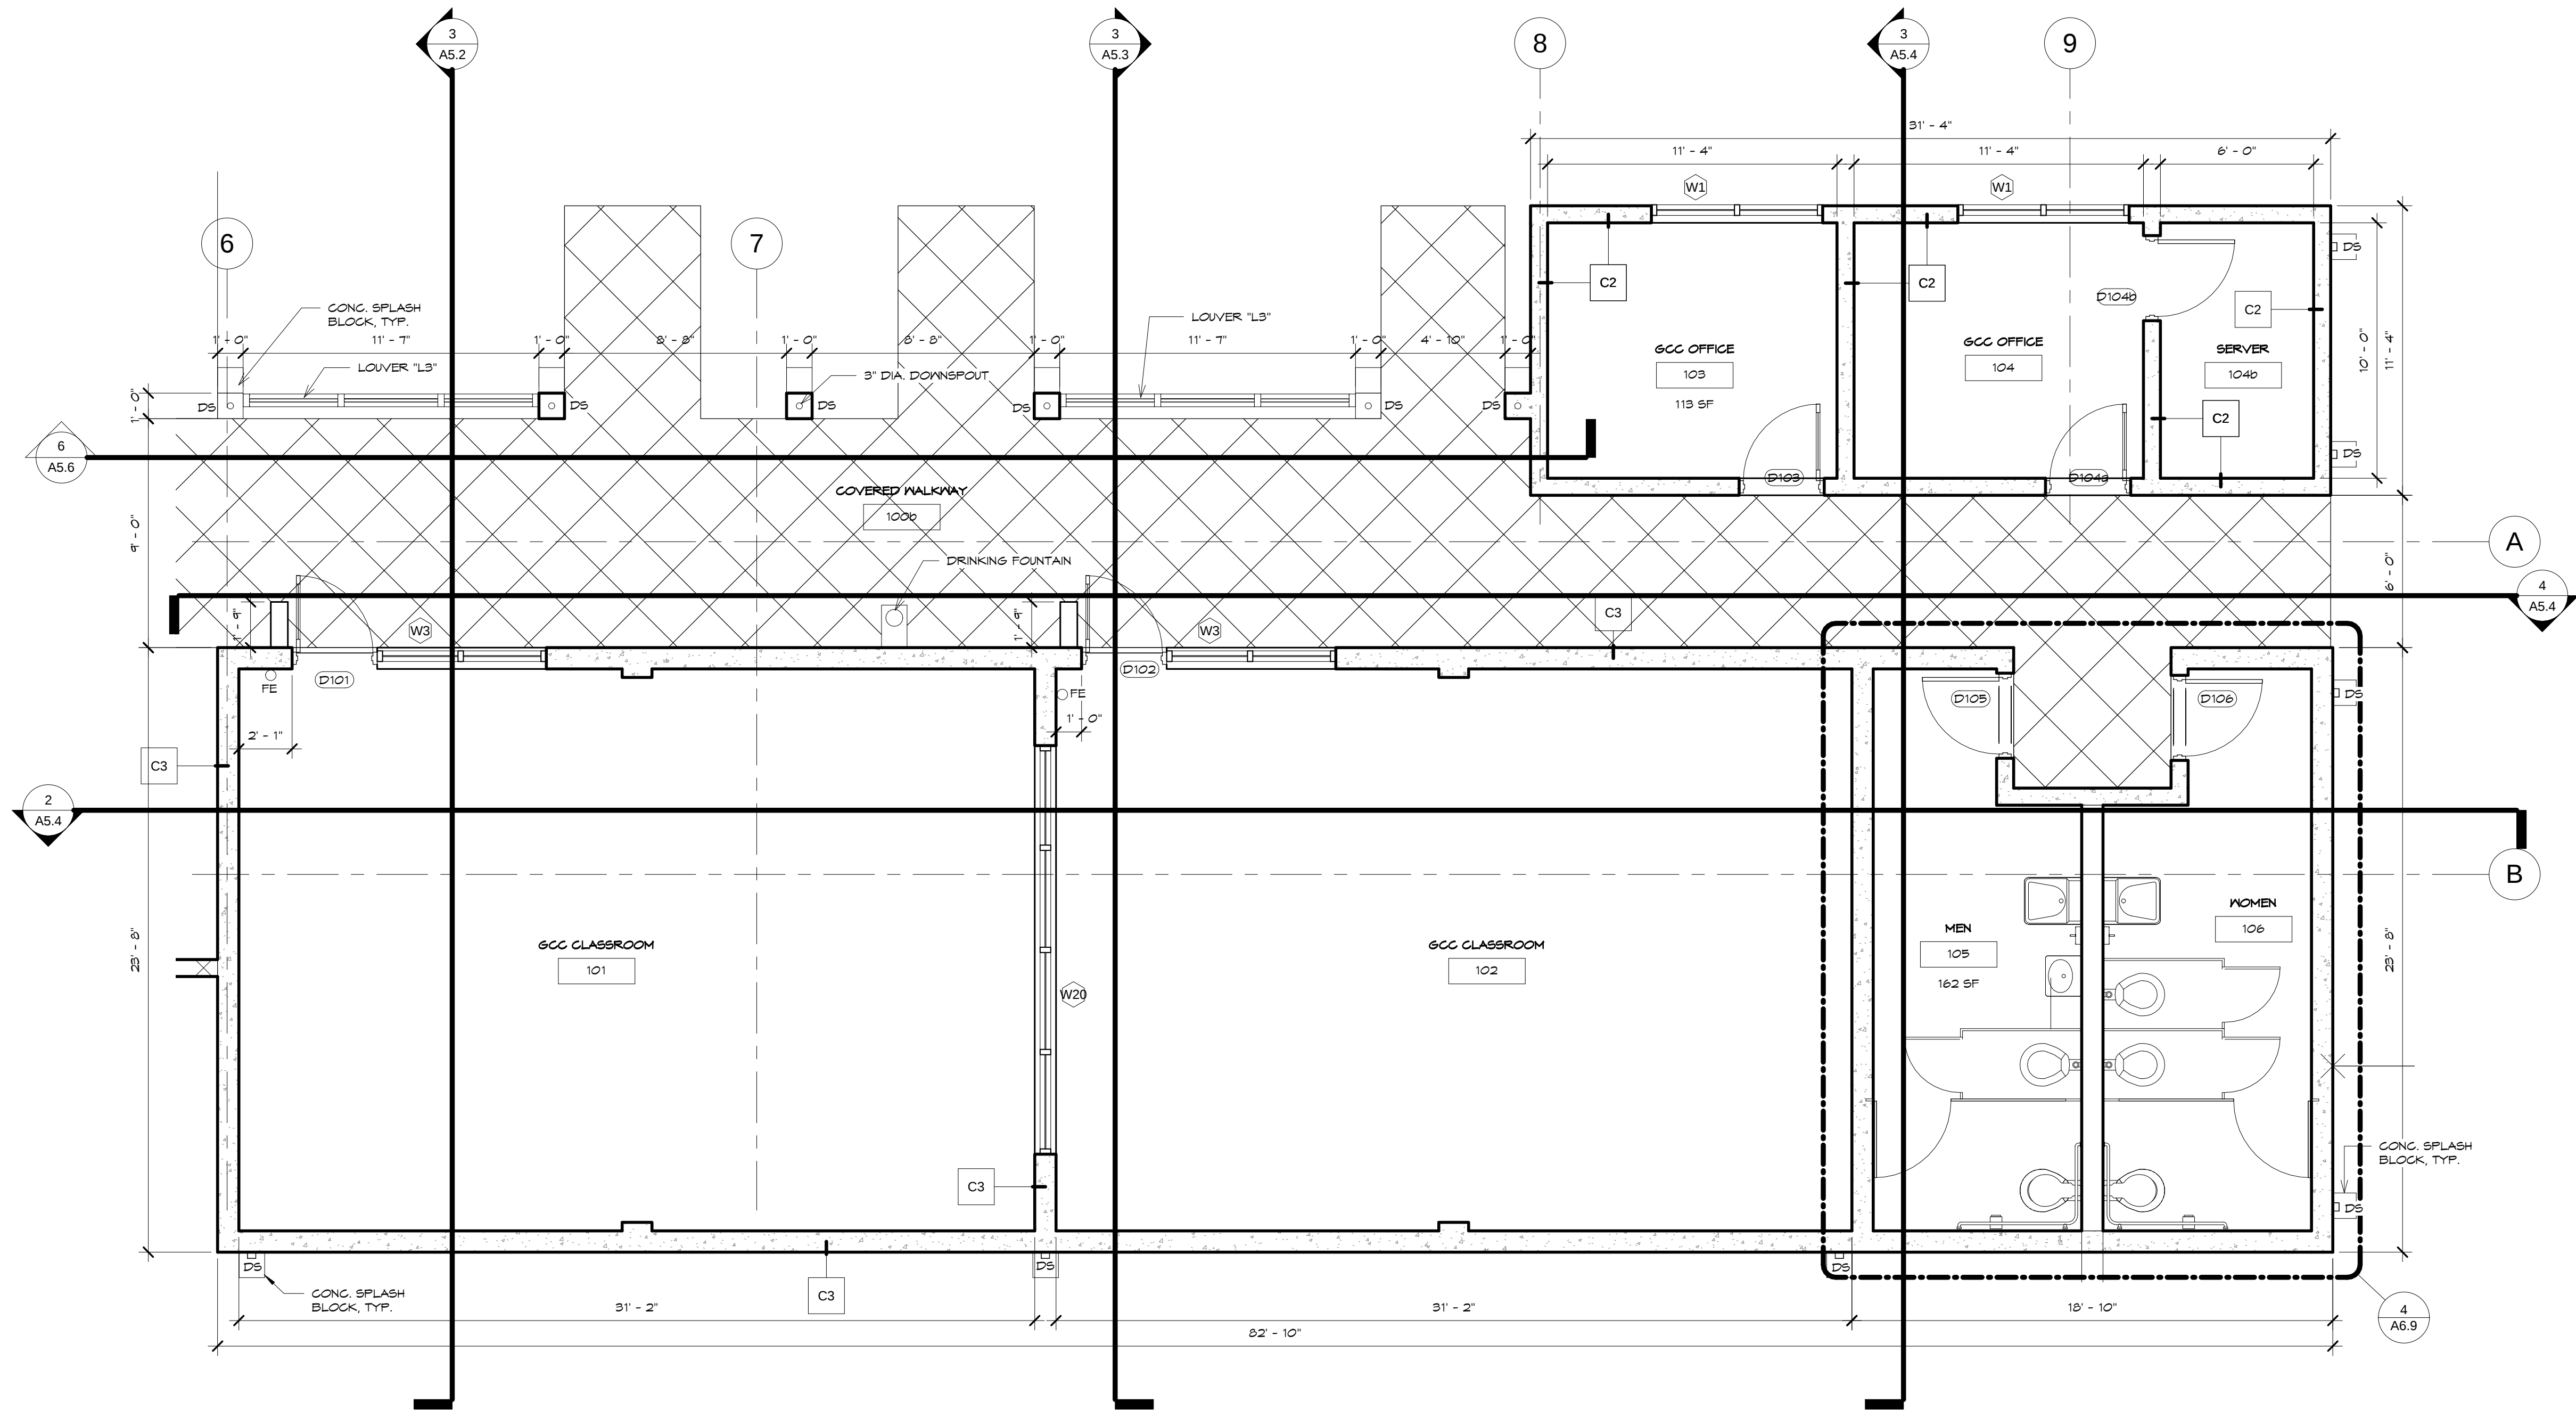

1 ENLARGED PLAN
SCALE: 1/4" = 1'-0"

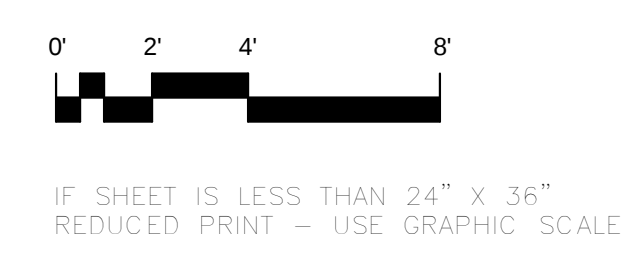

REVISIONS		
No.	Description	Date

TRMA
Taniguchi Ruth Makio Architects
100 Cliff Business Center, P.O. Box EA, Agaña, GU 96910
Tel.: (671) 475-8772 • Fax: (671) 472-3381
Architecture
Planning
Interior Design

BID
DOCUMENTS

I HEREBY CERTIFY THAT THIS PLAN WAS PREPARED BY ME OR UNDER MY DIRECT SUPERVISION.





DATE: _____

Project:
GUAM COMMUNITY COLLEGE
FORENSIC DNA LAB

Title:
GCC CLASSROOM
DETAIL PLAN





Designed: TRMA
Drawn: RM/TP
Checked: CTC
Supv: MWM
Scale: 1/4" = 1'-0"
Date: 12/17/12
Project No. 1026
Drawing No.

A6.1
Sheet No. _____ of _____

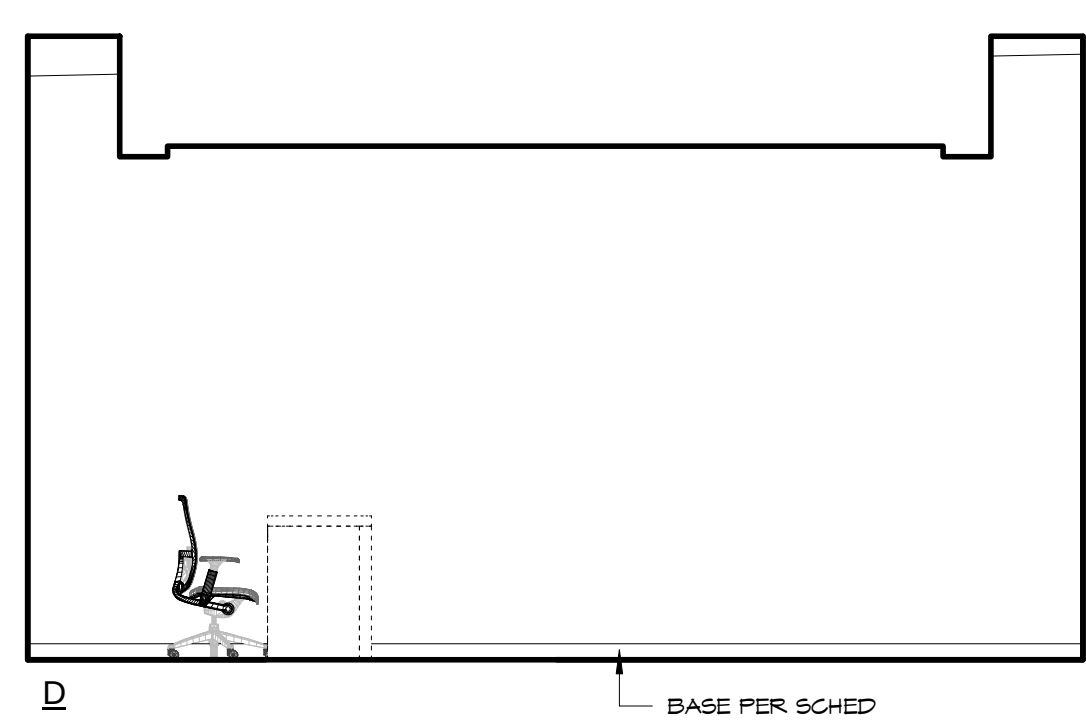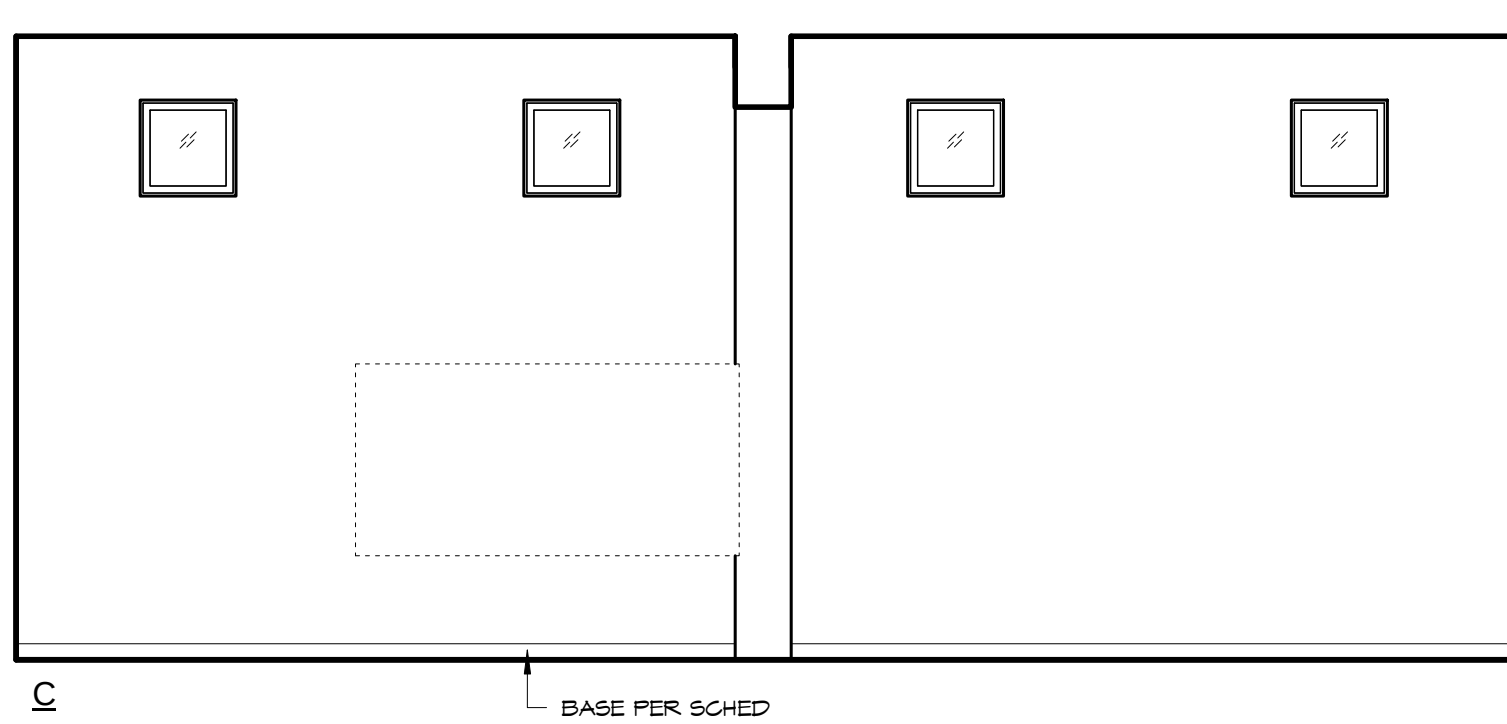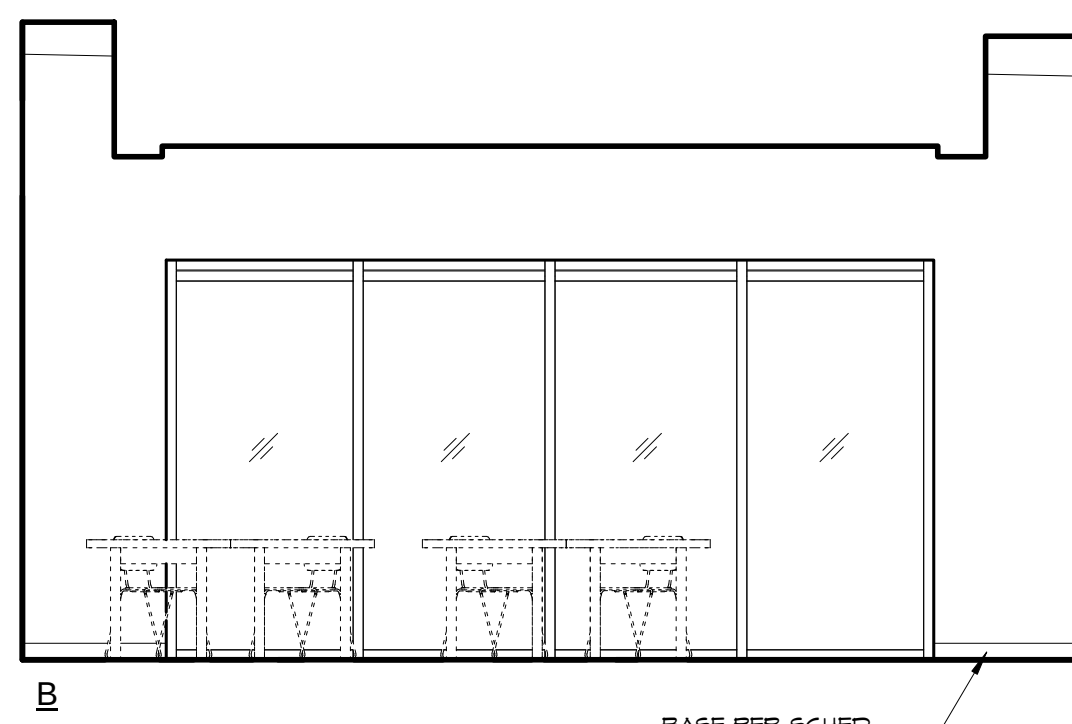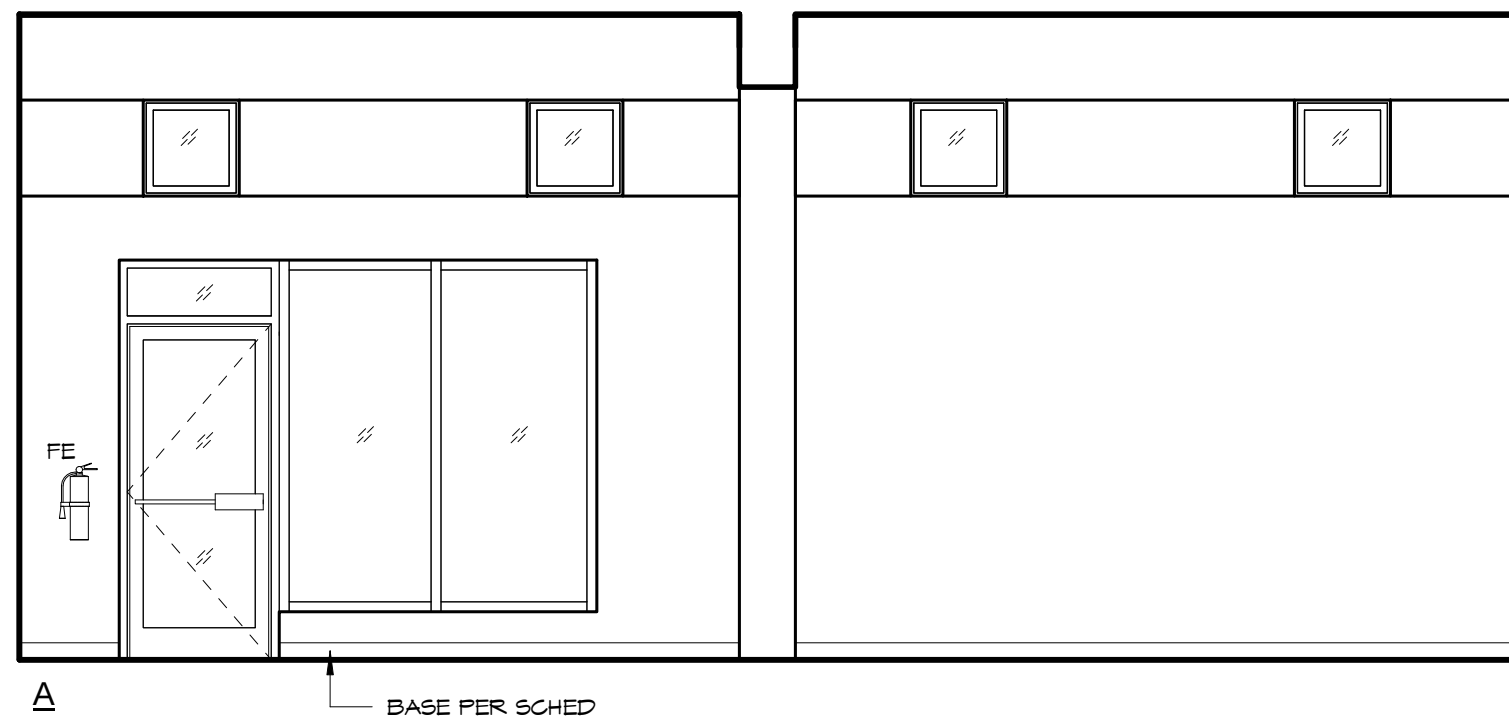





INTERIOR ELEVATIONS CLASSROOM 101

1 SCALE: 1/4" = 1'-0"

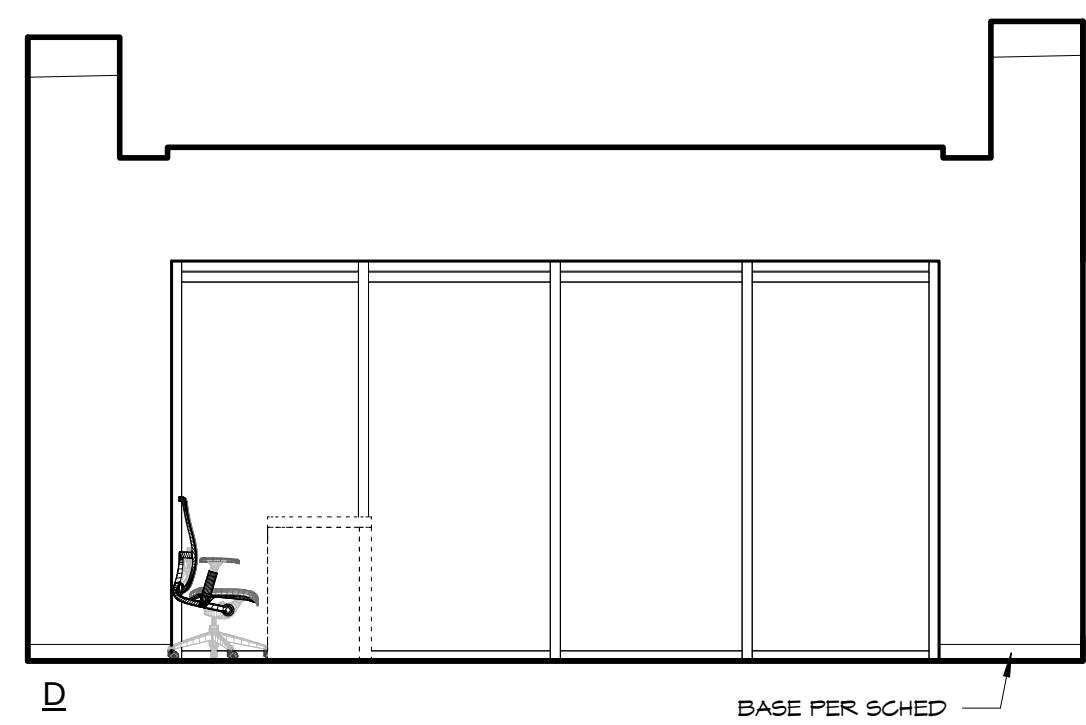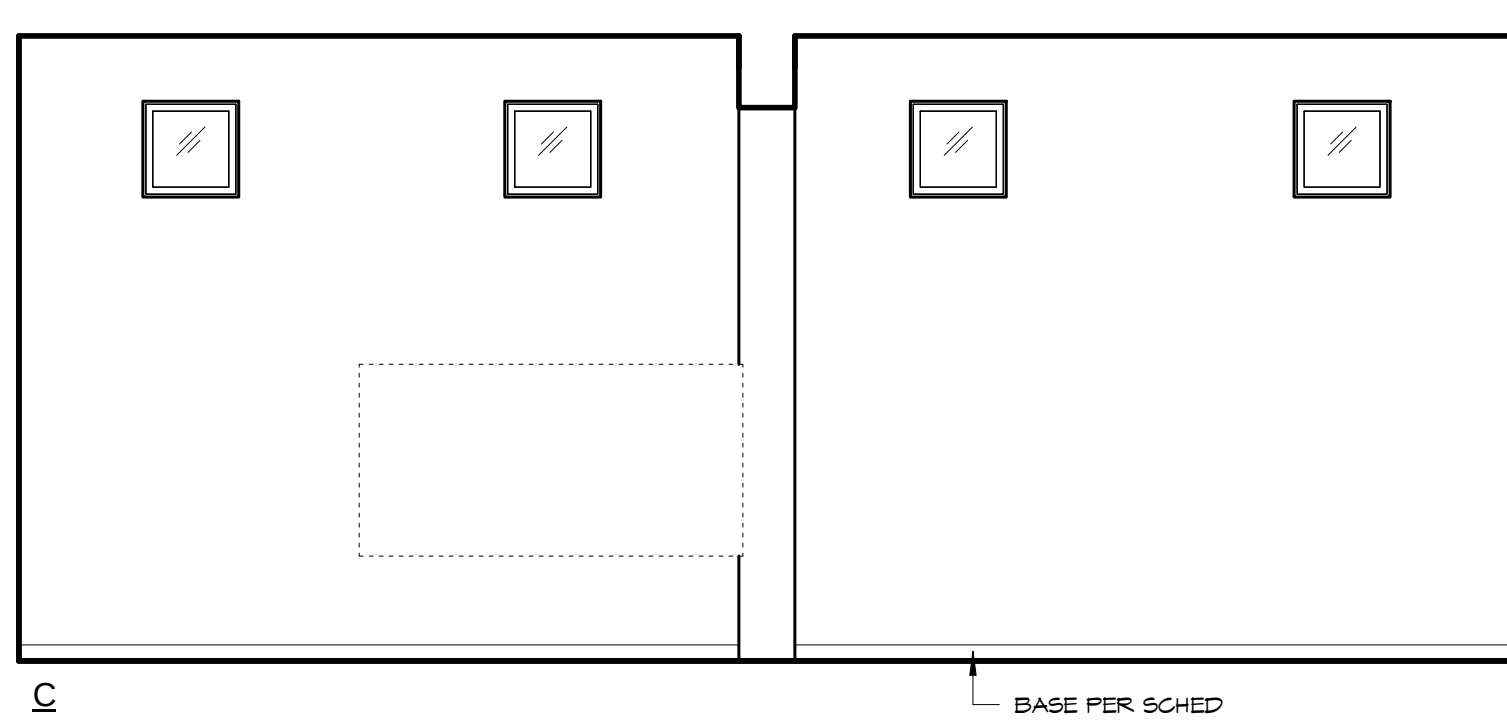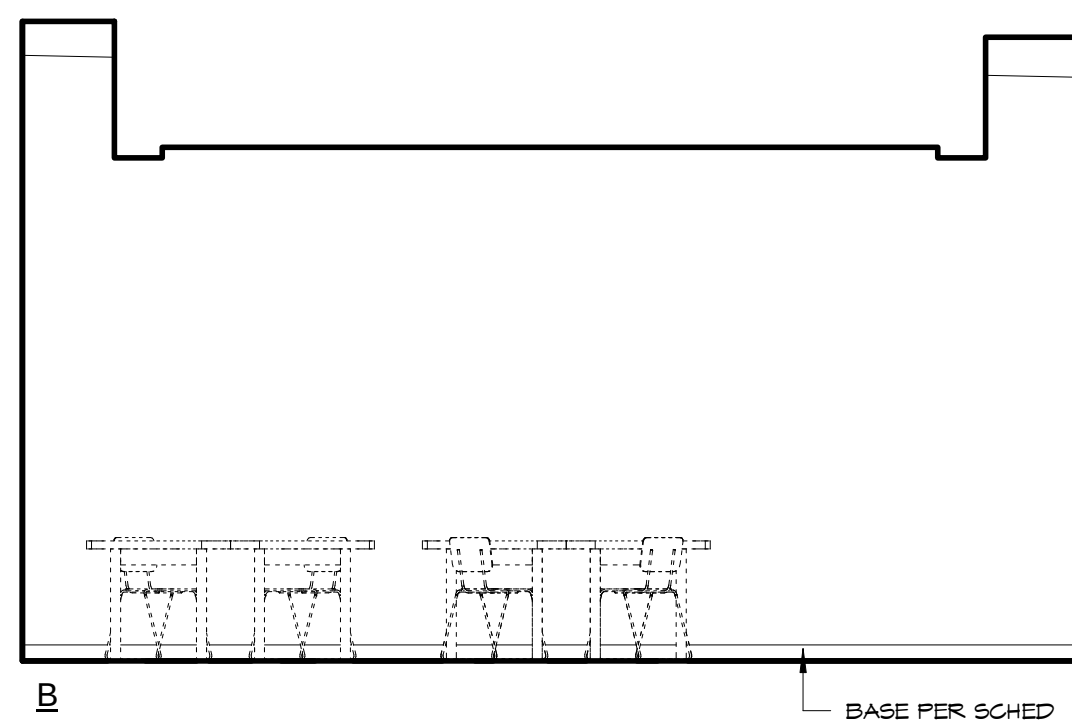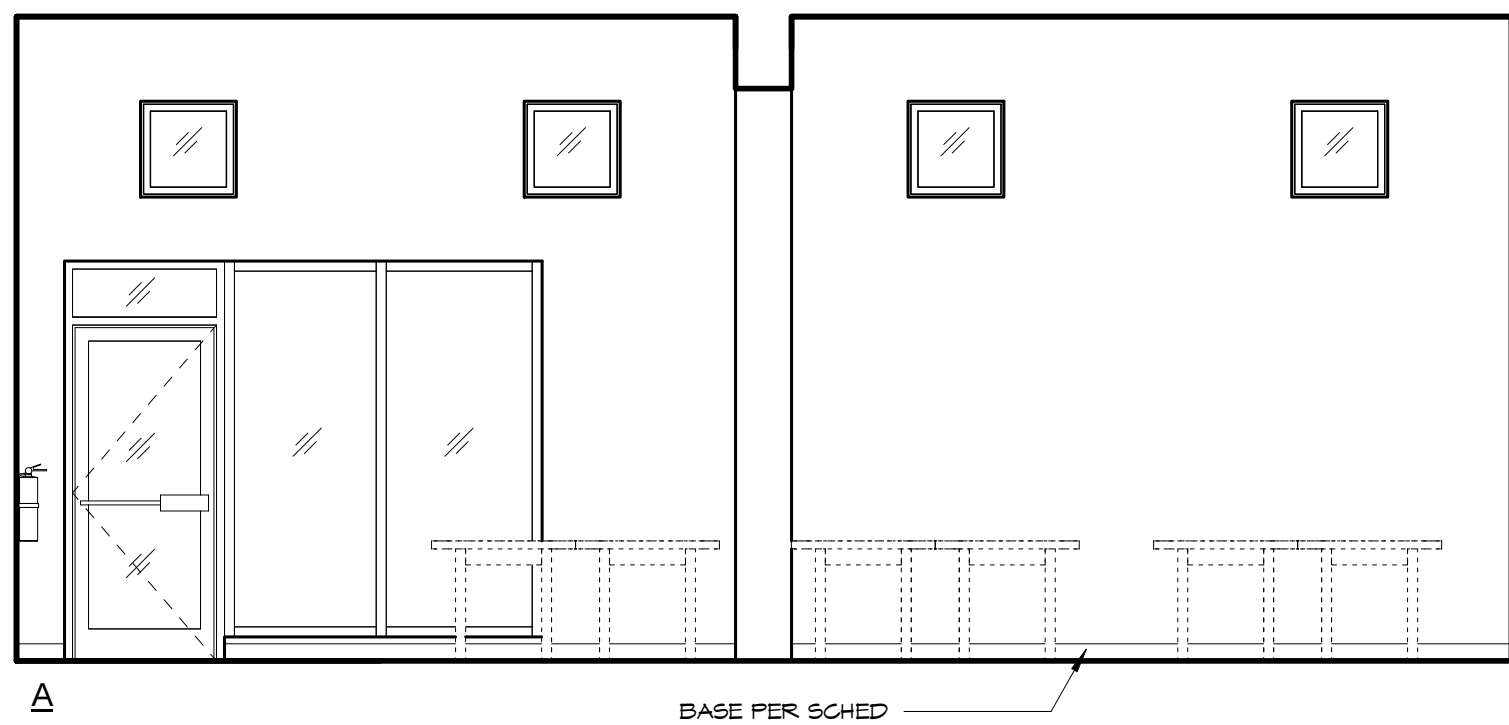





INTERIOR ELEVATIONS CLASSROOM (102)

 2 SCALE: 1/4" = 1'-0"

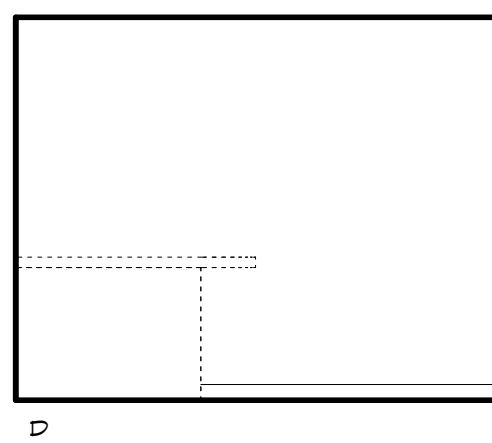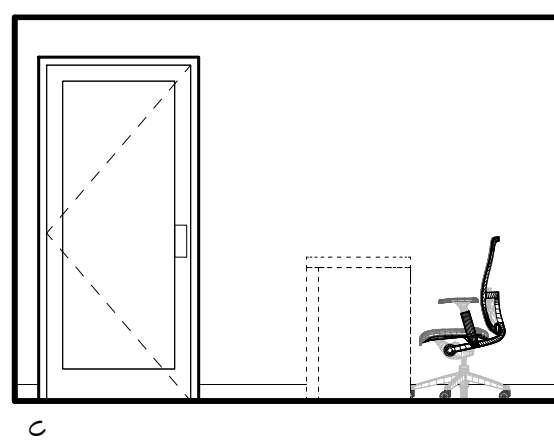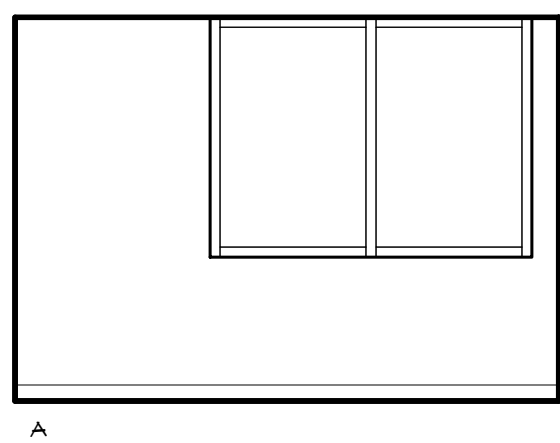

OFFICE 103 "A"

3 SCALE: 1/4" = 1'-0"

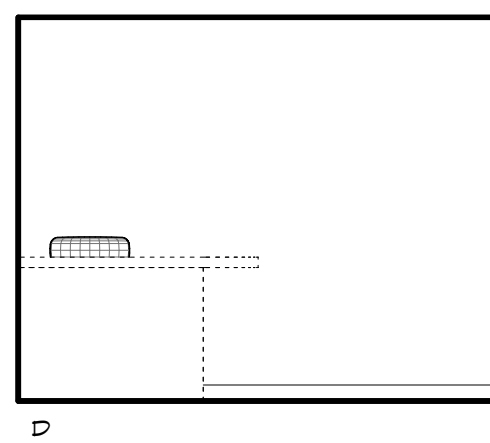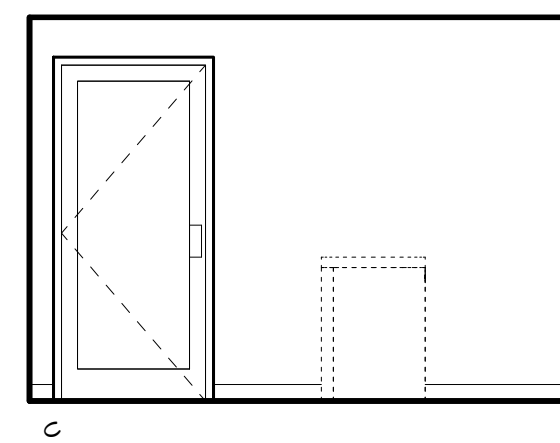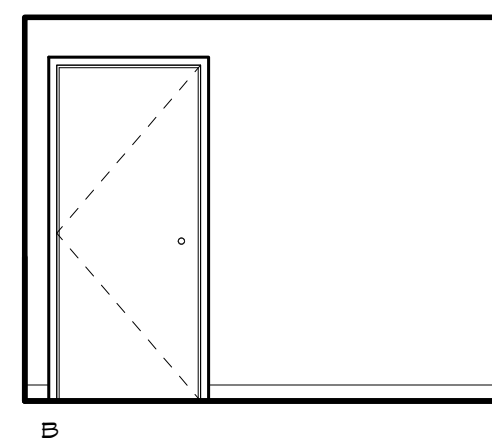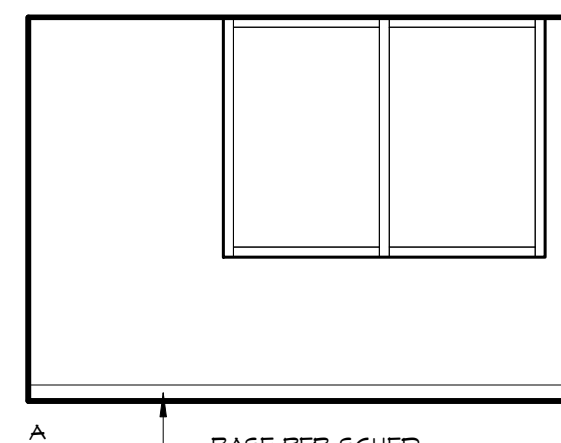

OFFICE (104)

4 SCALE: 1/4" = 1'-0"

REVISIONS		
No.	Description	Date

TRMA
Taniguchi Ruth Makio Architects
100 Cliff Business Center, P.O. Box EA, Agaña, GU 96910
Tel.: (671) 475-8772 • Fax: (671) 472-3381

Architecture
Planning
Interior Design

BID DOCUMENTS



I HEREBY CERTIFY THAT THIS PLAN WAS PREPARED
BY ME OR UNDER MY DIRECT SUPERVISION
DATE: _____

Project:
GUAM COMMUNITY
COLLEGE
FORENSIC DNA LAB

Title:
CLASS ROOM
INTERIOR ELEVATIONS

Designed: TRMA
Drawn: RM/TP
Checked: CTC
Supv: MWM
Scale: 1/4" = 1'-0"
Date: 12/17/12
Project No. 1026 File
Drawing No.

A6.2

Sheet No. _____ of _____

IF SHEET IS LESS THAN 24" X 36"
REDUCED PRINT - USE GRAPHIC SCALES

EQUIPMENT LIST

POST AMP LAB ROOM 31

PO1	GEN. ANALYZER 3500
PO2	DUCTLESS CHEM. HOOD FE 2620
PO3	EN. ANALYZER 9700
PO4	UNDER COUNTER FREEZER 5.6 CU. FT.
PO5	FREEZER 20.1 CU. FT.
PO6	REFRIGERATOR
PO7	GEN. AMPLIFIER 1500
PO8	MINI CENTRIFUGE HF120
PO9	MINI VORTEX 6560
PO10	MELL PLATE CENTRIFUGE
PO11	UV CROSSLINKER C1000

PRE AMP LAB ROOM 30


PR1	PCR SETUP CABINET
PR2	UNDER COUNTER FREEZER 5.6 CU. FT.
PR3	FREEZER
PR4	REFRIGERATOR
PR5	MINI CENTRIFUGE HF120
PR6	MINI VORTEX 6560

REAGENT LAB (EXTRACTION) ROOM 29

E1	BIOROBOT EZ1-ADVANCED XL 9001492
E2	AUTOCLAVED 8000
E3	BIO. SAFETY CABINET/HOOD PURIFIER CLASS II
E4	LARGE REF. CENTRIFUGE GL31R
E5	UNDER COUNTER FREEZER 5.6 CU. FT.
E6	FREEZER 20.1 CU. FT.
E7	REF. MICROCENTRIFUGE 541TR
E8	UV CROSSLINKER C1000
E9	VACUUM CONCENTRATOR DNA 120
E10	VORTEMP 56 HEAT & ORBITAL SHAKER
E11	MINI CENTRIFUGE HF120
E12	MINI VORTEX ROCKING PLATFORM G 560

LABORATORY REQUIREMENTS

- PROVIDE FLOOR DRAINS AT ALL LAB SPACES, EYE WASH LOCATIONS, AND STORAGE ROOMS.
- PROVIDE EMERGENCY EYE WASHES AT CORRIDORS.
- PROVIDE BACKUP GENERATOR WITH UPS AND LINE CONDITIONER TO LAB SINKS.
- PROVIDE REVERS OSMOSIS FILTERED WATER SUPPLY TO LAB SINKS.
- PROVIDE 36-IN HIGH X 30-IN DEEP LAB COUNTER TOP SURFACE.
- INSTALL POWER AND DATA OUTLETS AT EACH LABORATORY WALL 6-FT ON CENTER ABOVE COUNTER TOP SURFACE.
- PROVIDE 2 SETS OF POWER OUTLETS AT EACH EXTERIOR WALL OF THE LABORATORY BUILDING, MINIMUM.

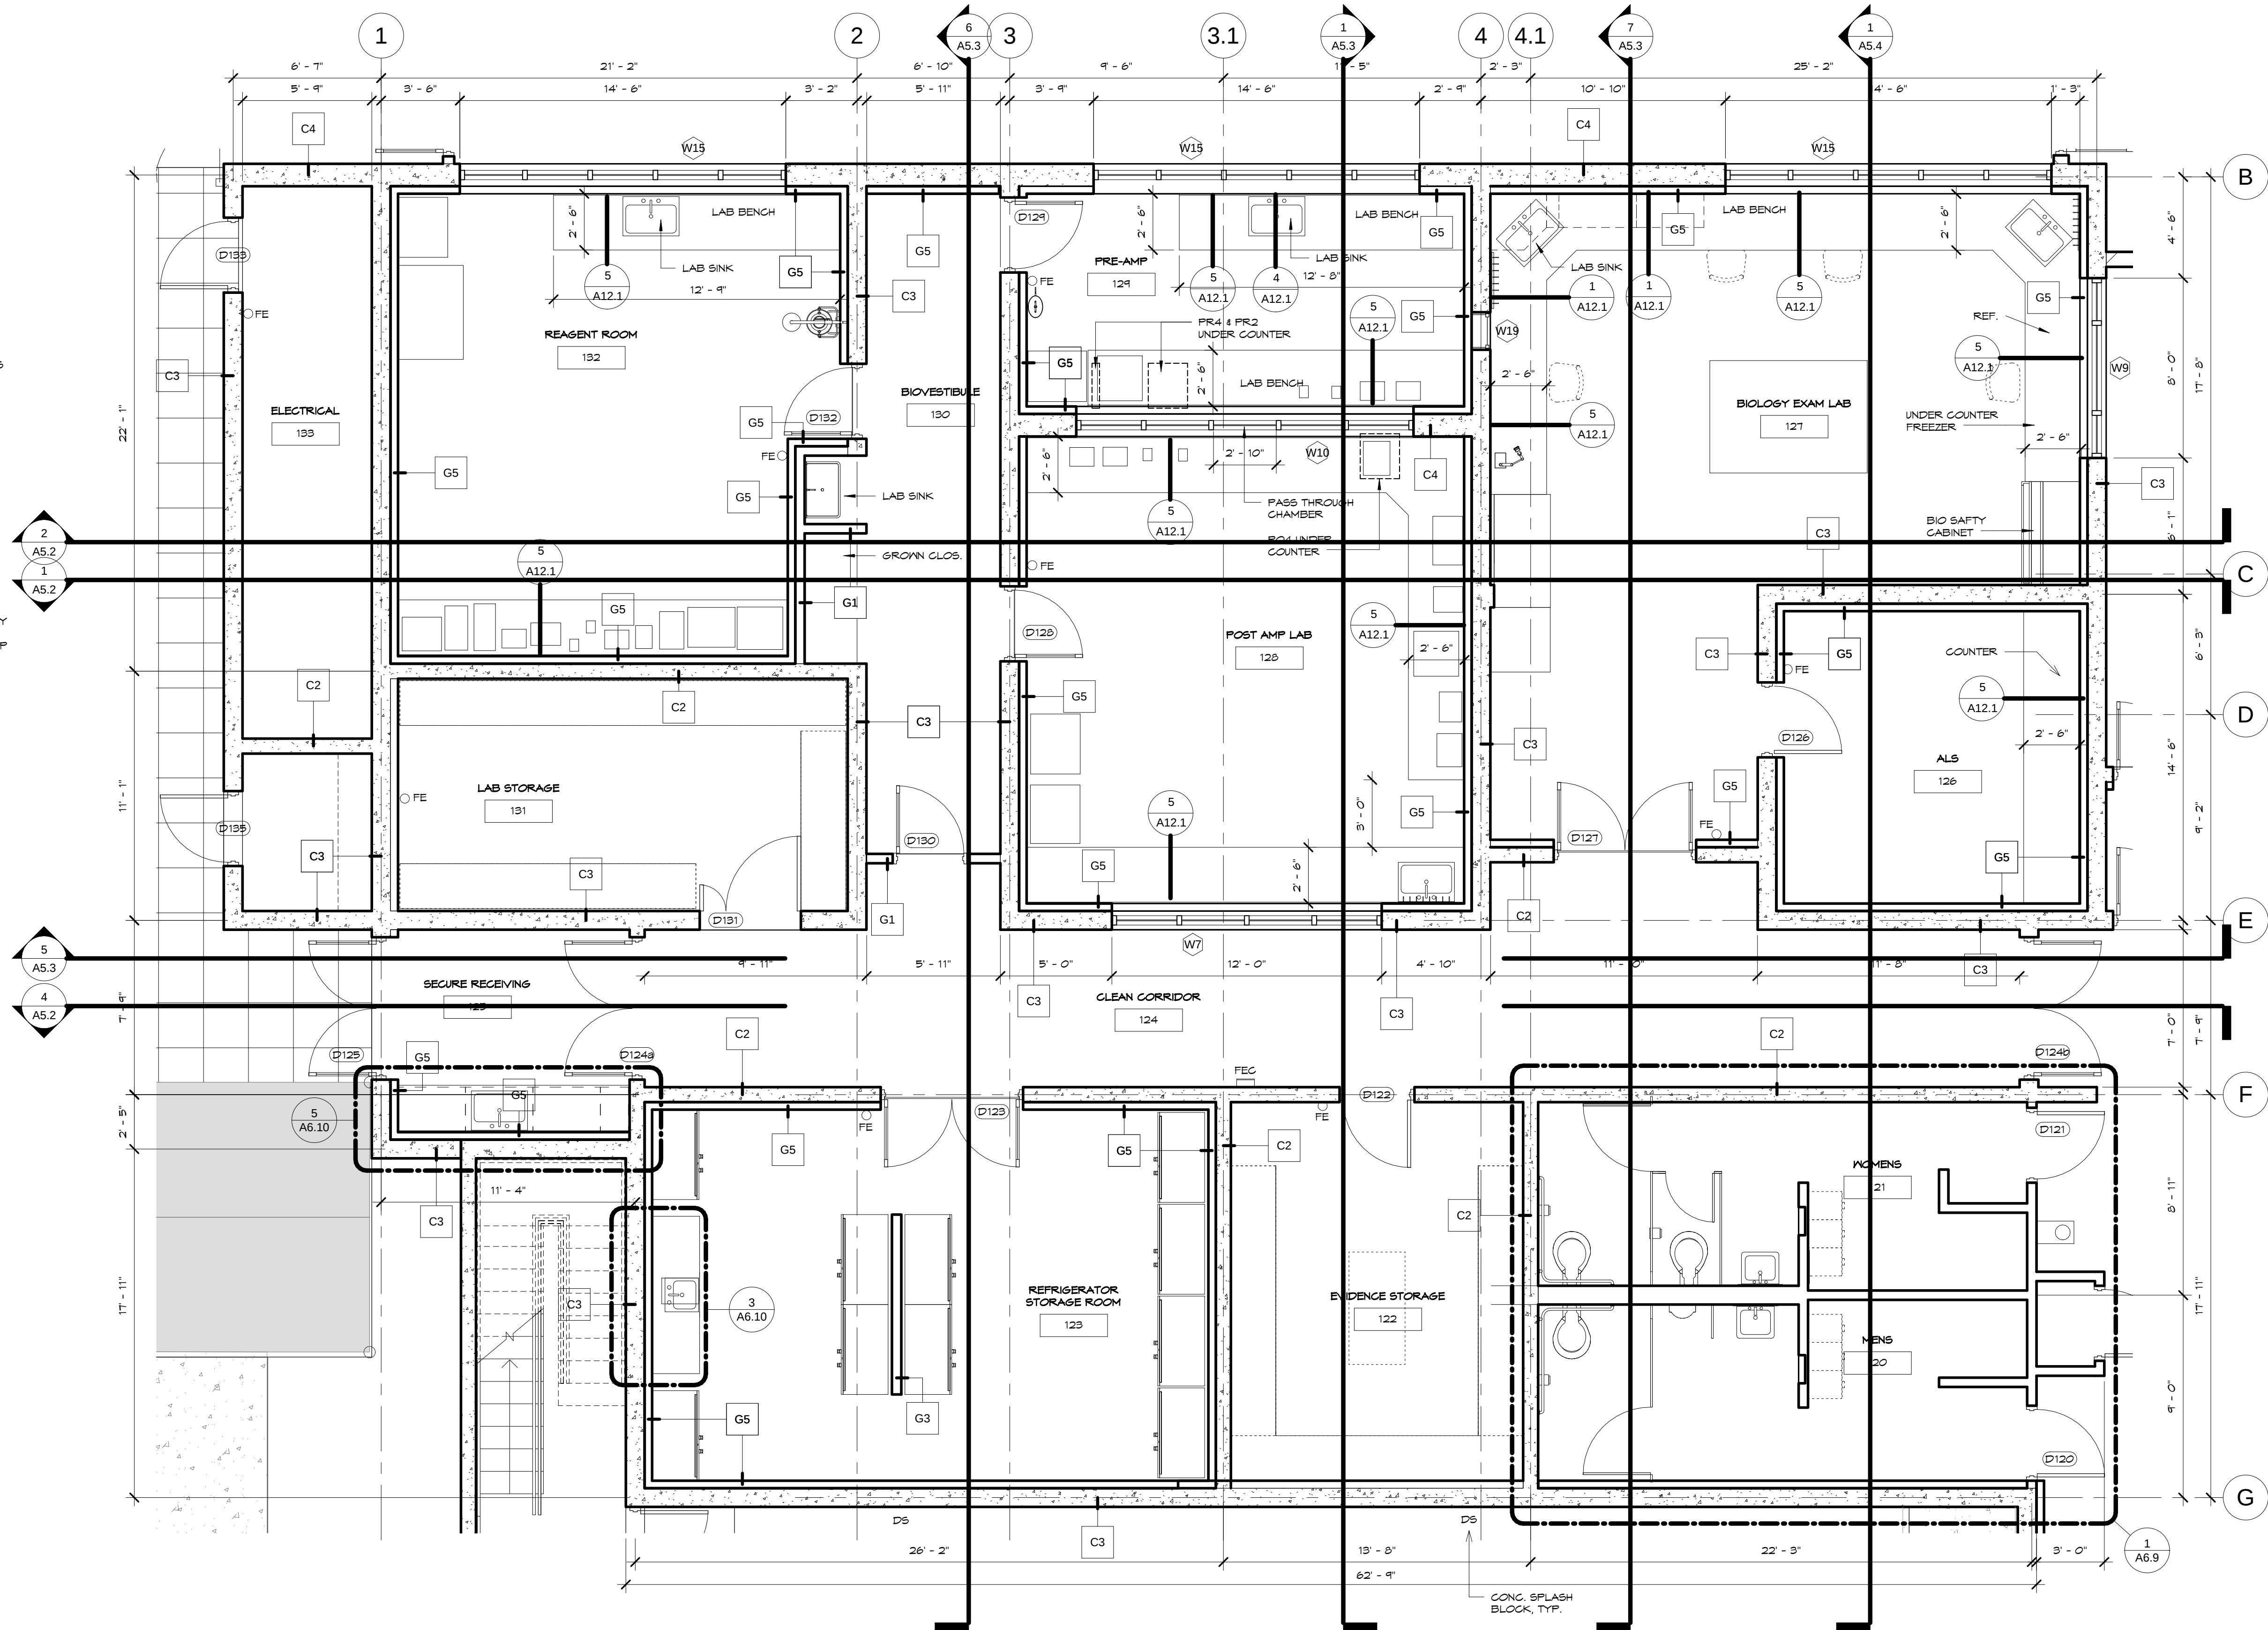

1 LAB DETAIL PLAN
1/4" = 1'-0"

REVISIONS

No.	Description	Date

TRMA

Taniguchi Ruth Makio Architects
100 Cliff Business Center, P.O. Box EA, Agaña, GU 96910
Tel.: (671) 475-8772 • Fax: (671) 472-3381

Architecture
Planning
Interior Design

BID
DOCUMENTS

I HEREBY CERTIFY THAT THIS PLAN WAS PREPARED
BY ME OR UNDER MY DIRECT SUPERVISION
DATE: _____

Project:

GUAM COMMUNITY
COLLEGE
FORENSIC DNA LAB

Title:

LAB DETAIL PLAN

Designed:

TRMA

Drawn:

RM/TP

Checked:

CTC

Supv:

MMM

Scale:

1/4" = 1'-0"

Date:

12/17/12

Project No. File

1026

Drawing No.

A6.3



 



Sheet No. of

IF SHEET IS LESS THAN 24" X 36"
REDUCED PRINT - USE GRAPHIC SCALES




1 REAGENT ROOM
INT.ELEVATIONS (132)

SCALE: 1/4" = 1'-0"

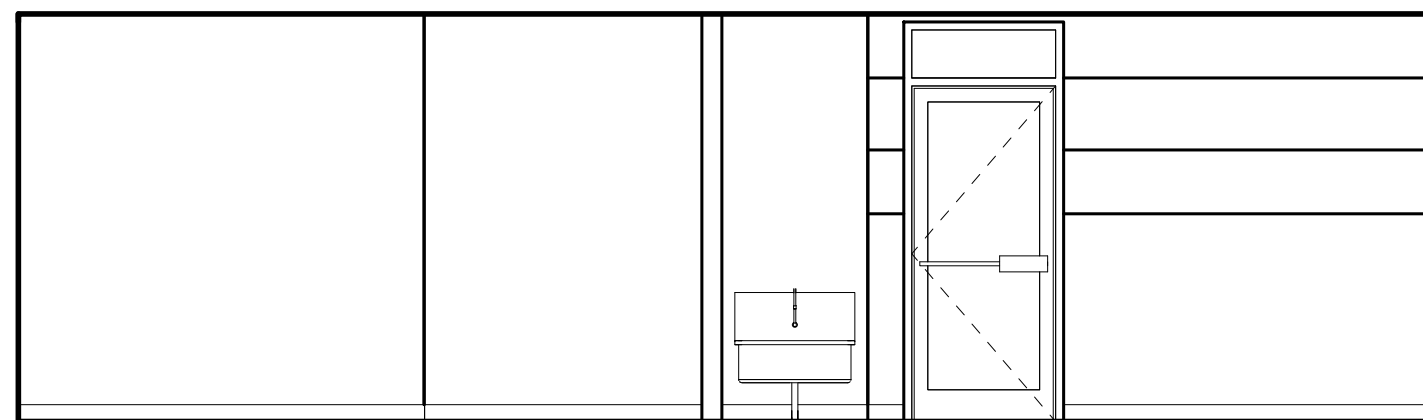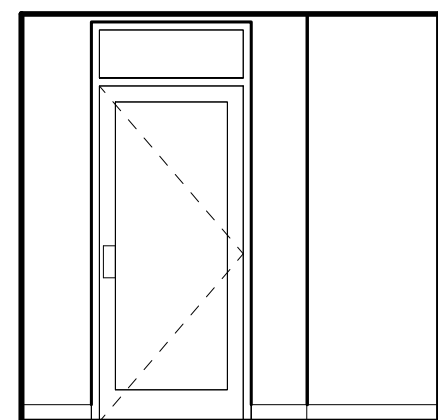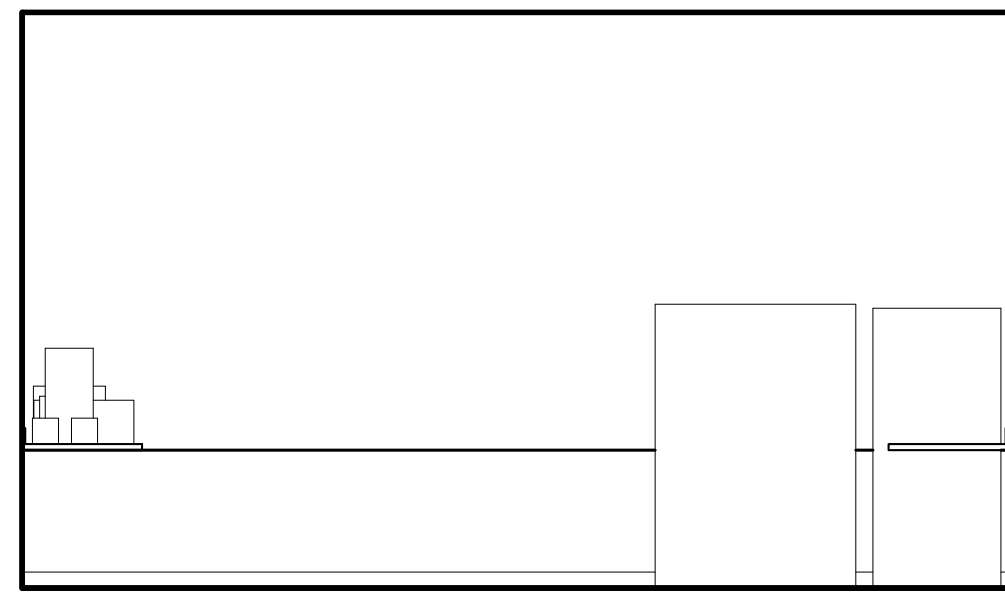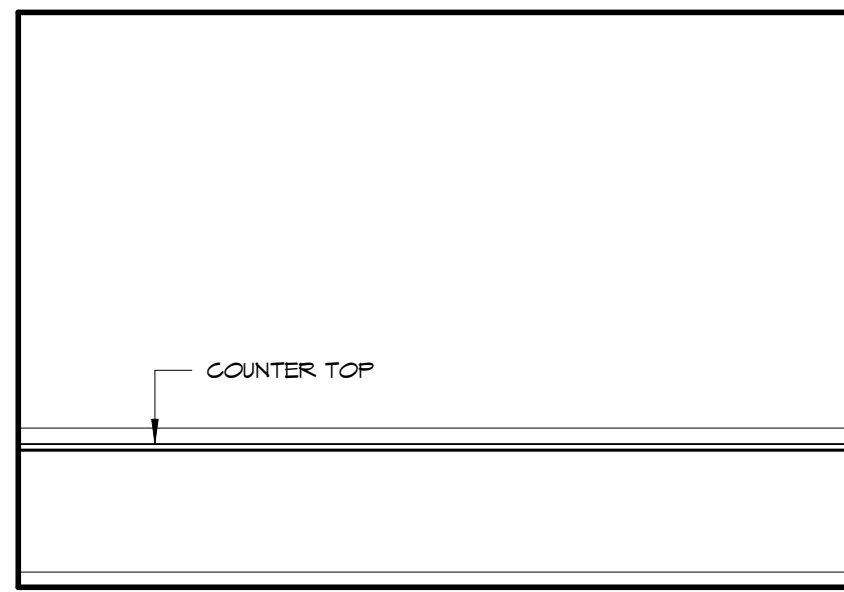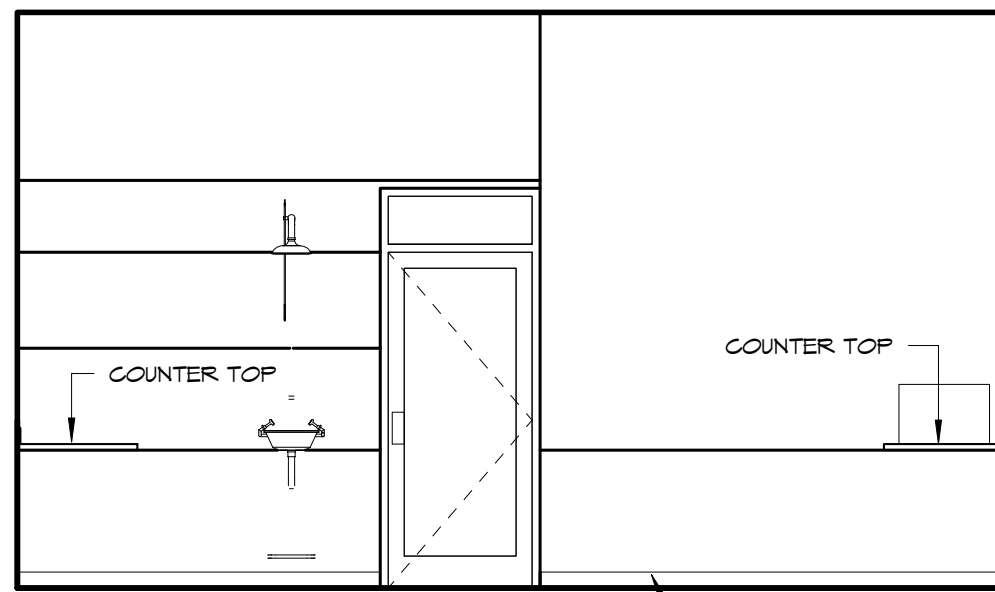




2 BIOVESTIBULE INT.
ELEVATIONS (130)

SCALE: 1/4" = 1'-0"

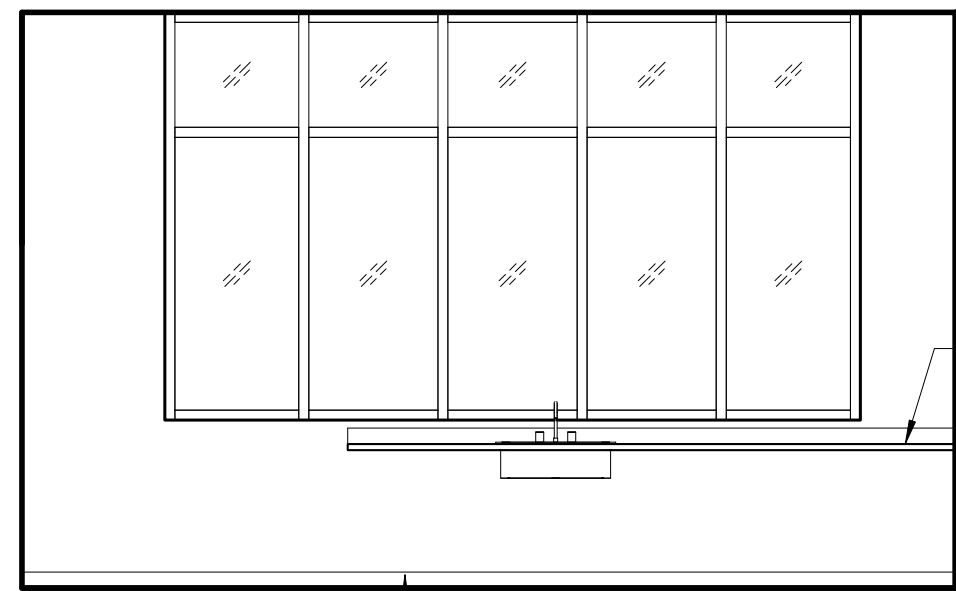




3 PRE-AMP INT. ELEVATIONS
(129)

SCALE: 1/4" = 1'-0"

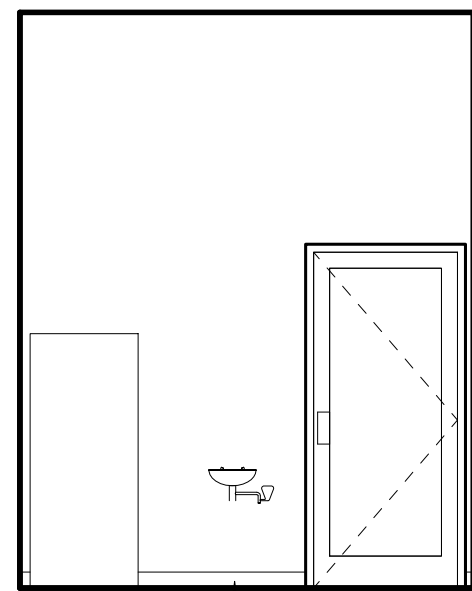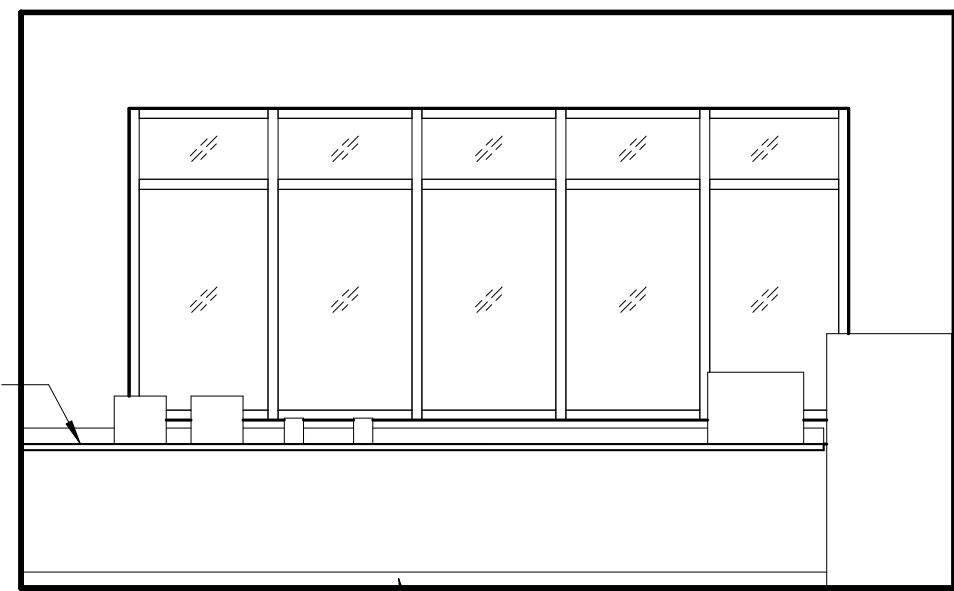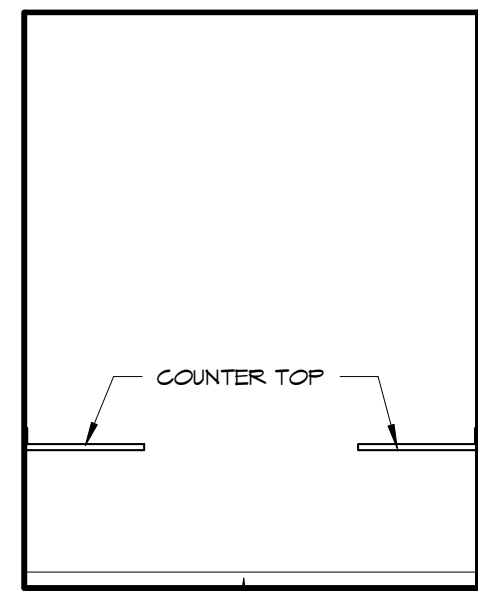

4 POST AMP INT. ELEVATIONS
(128)

SCALE: 1/4" = 1'-0"

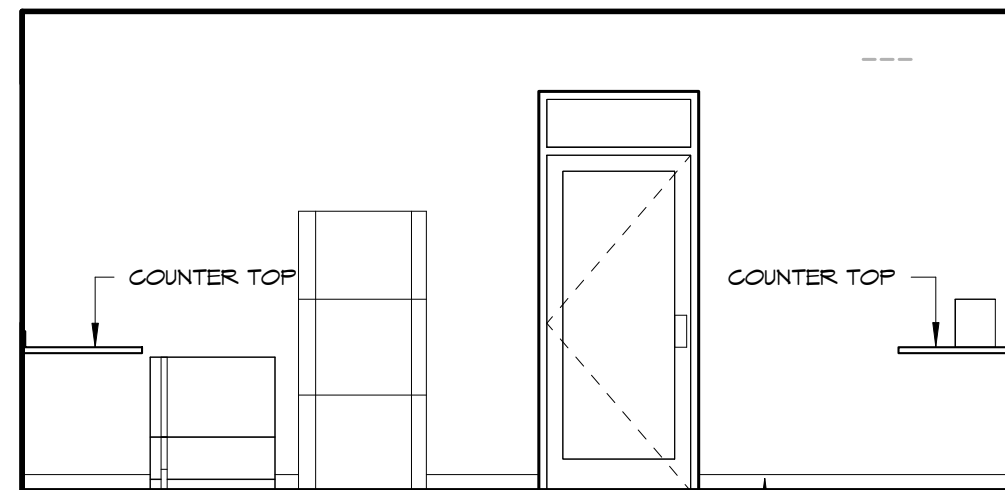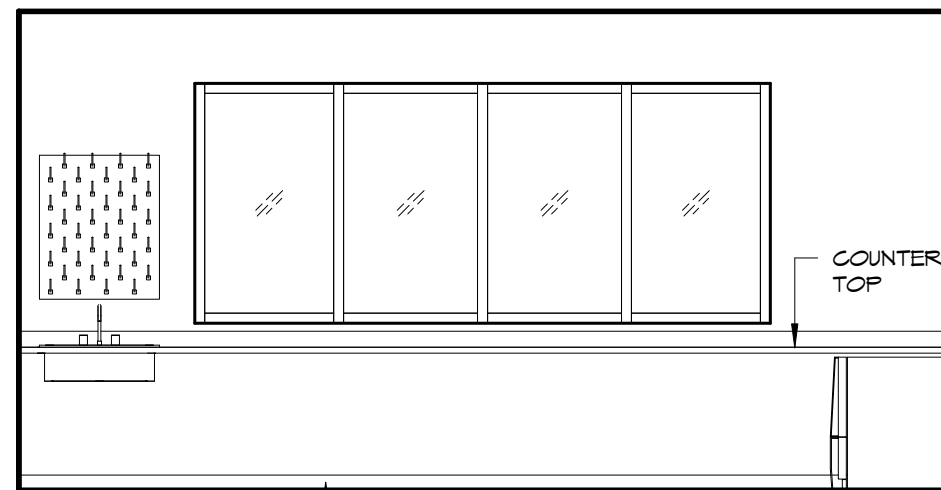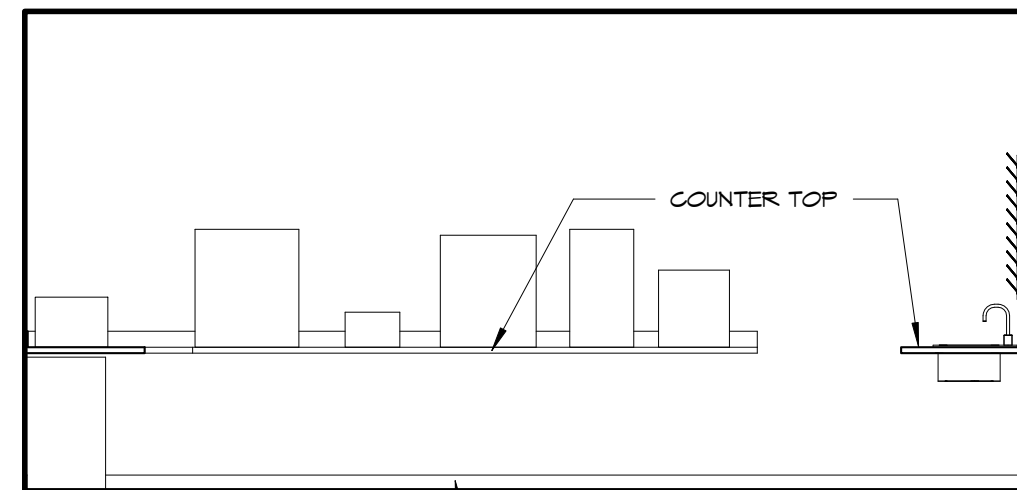

IF SHEET IS LESS THAN 24" X 36"
REDUCED PRINT - USE GRAPHIC SCALES

REVISIONS		
No.	Description	Date

TRMA
Taniguchi Ruth Makio Architects
100 Cliff Business Center, P.O. Box EA, Agaña, GU 96910
Tel.: (671) 475-8772 • Fax: (671) 472-3381

Architecture
Planning
Interior Design

BID
DOCUMENTS




Project:
GUAM COMMUNITY
COLLEGE
FORENSIC DNA LAB

Title:
LAB. INTERIOR
ELEVATIONS

Designed: TRMA
Drawn: RM/TP
Checked: CTC
Supv: MWM
Scale: 1/4" = 1'-0"
Date: 12/17/12
Project No. 1026
Drawing No.


A6.4

Sheet No. of

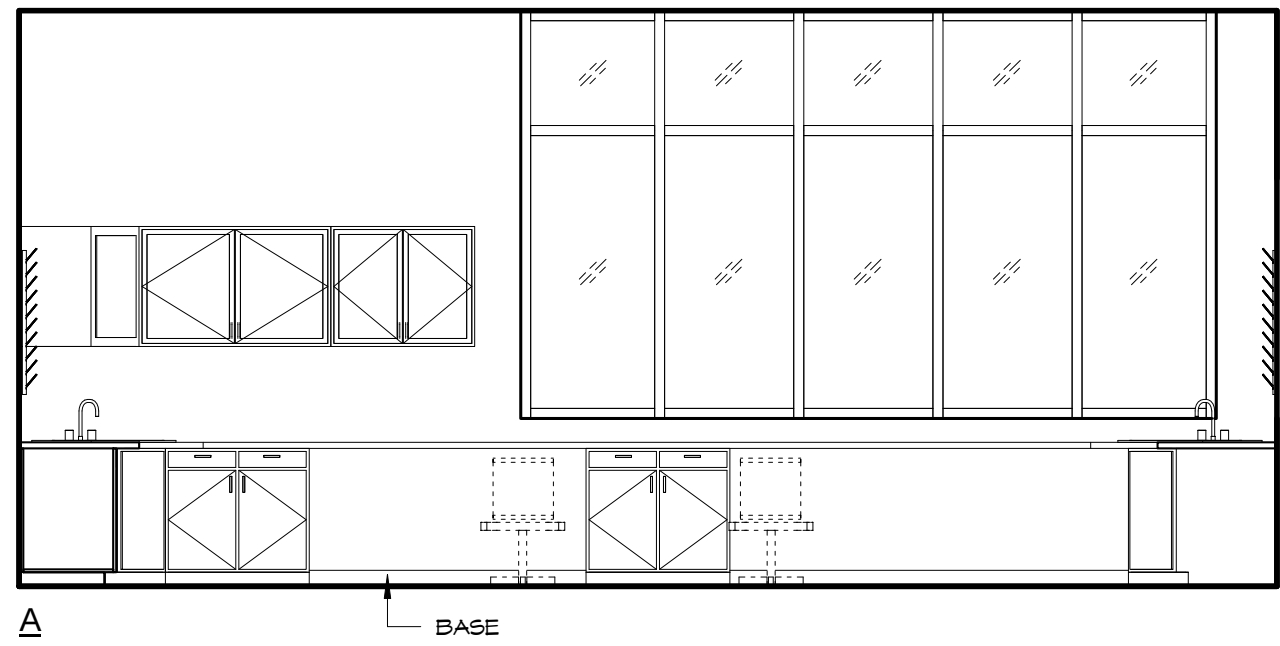


A

BASE

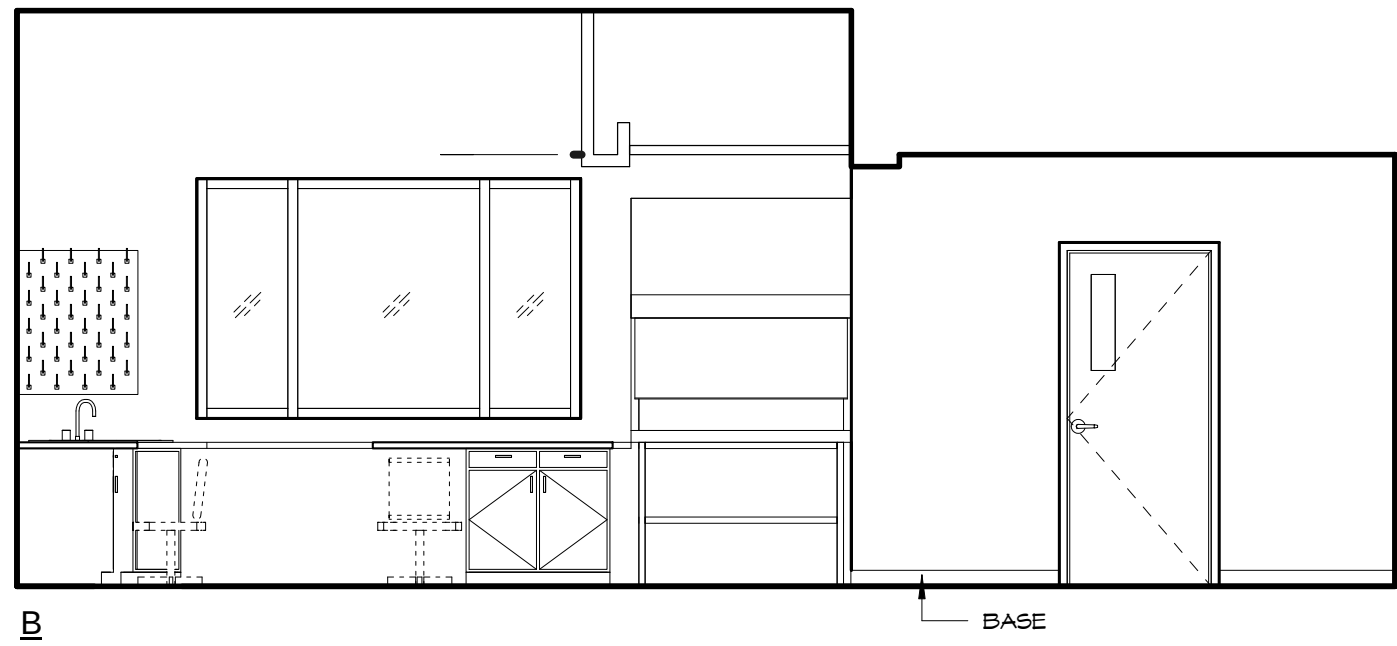

B

BASE

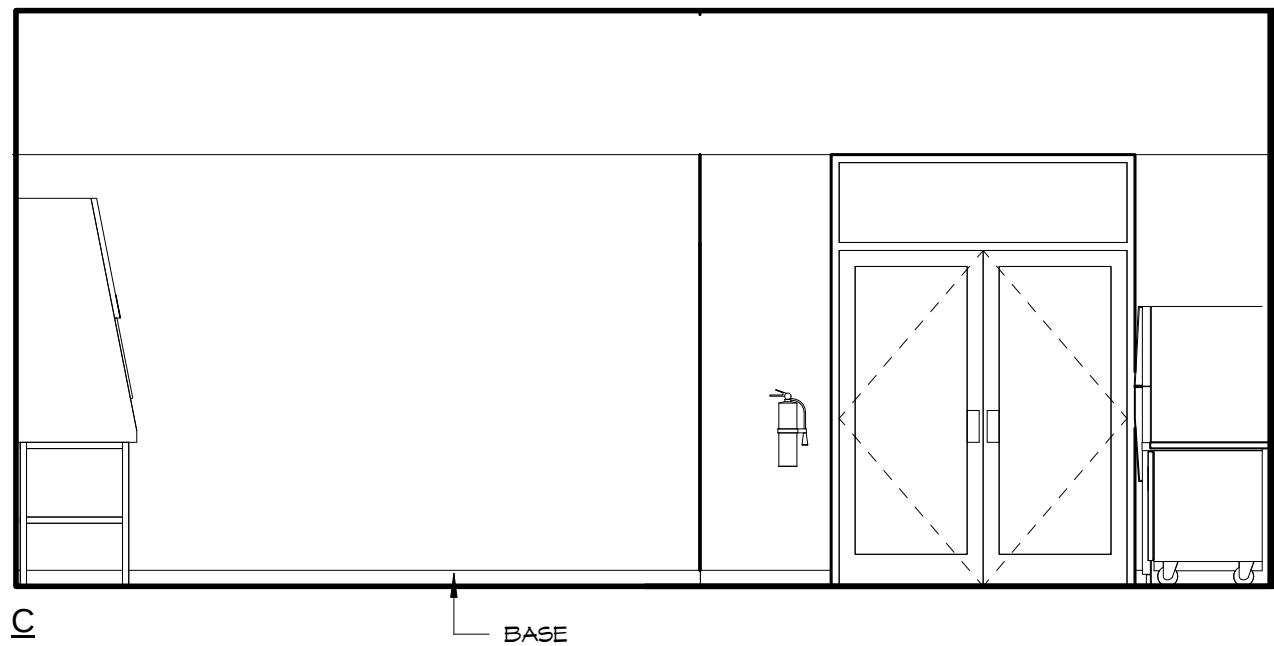


C

BASE

1


BIOLOGY EXAM INT. ELEVATIONS (127)

SCALE: 1/4" = 1'-0"

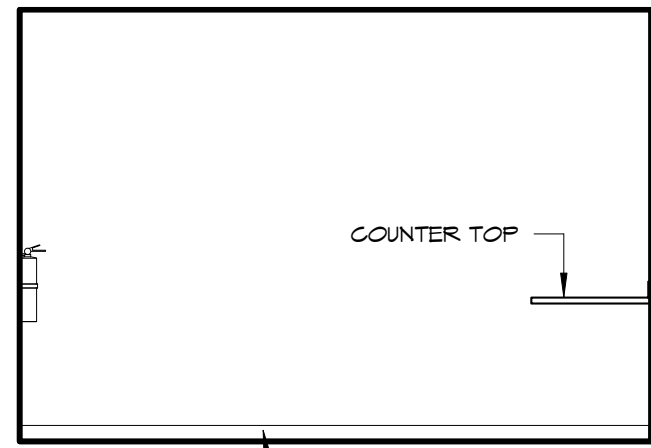


A

BASE

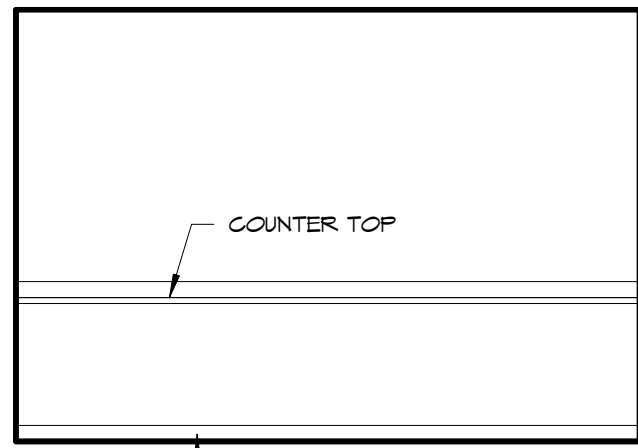


B

BASE

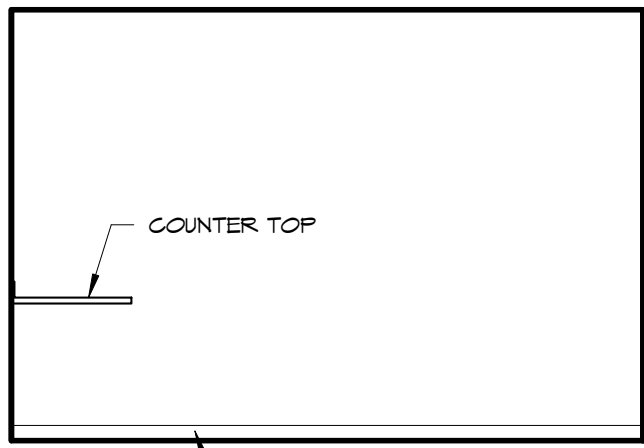


C

BASE

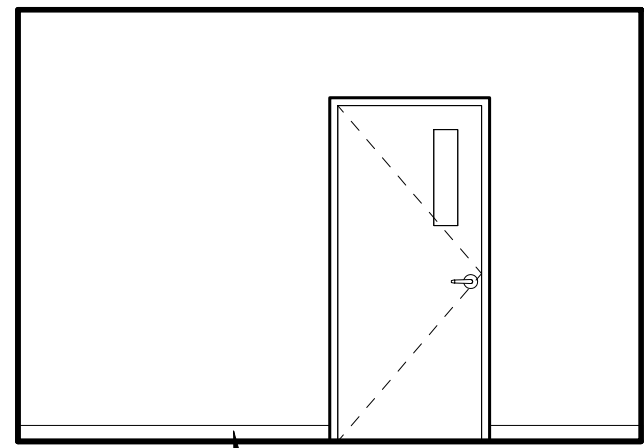

D

BASE

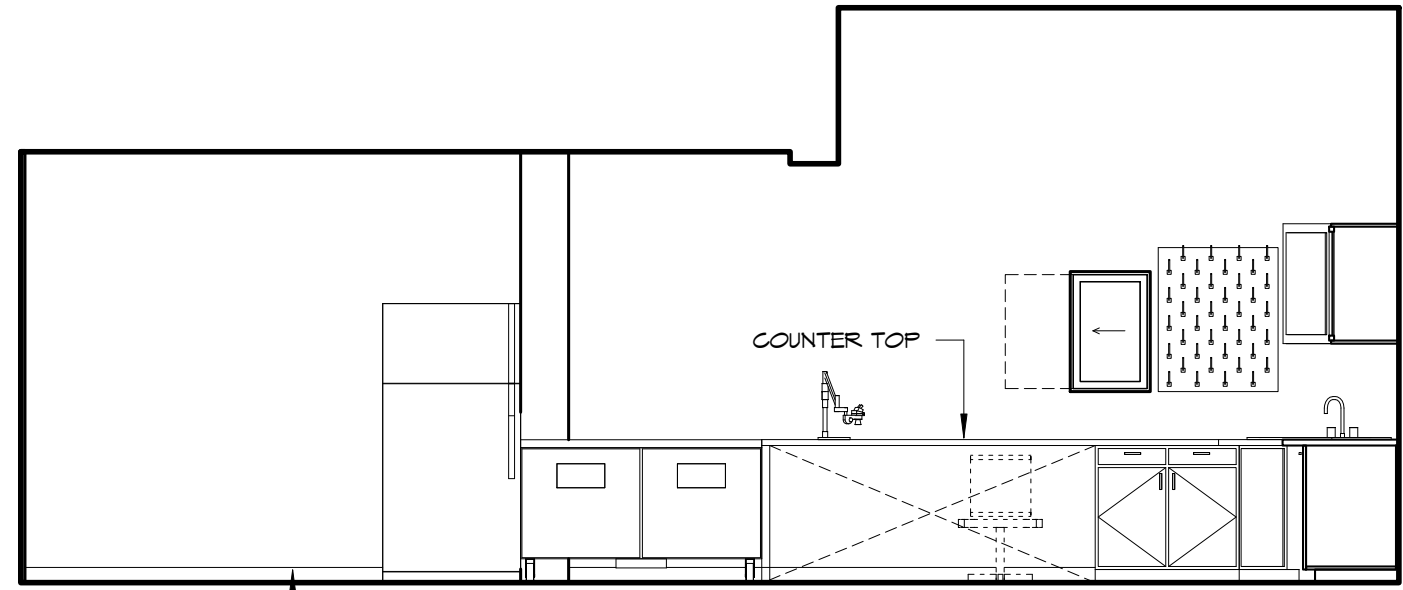


D

BASE

2


ALS INT. ELEVATIONS (126)

SCALE: 1/4" = 1'-0"

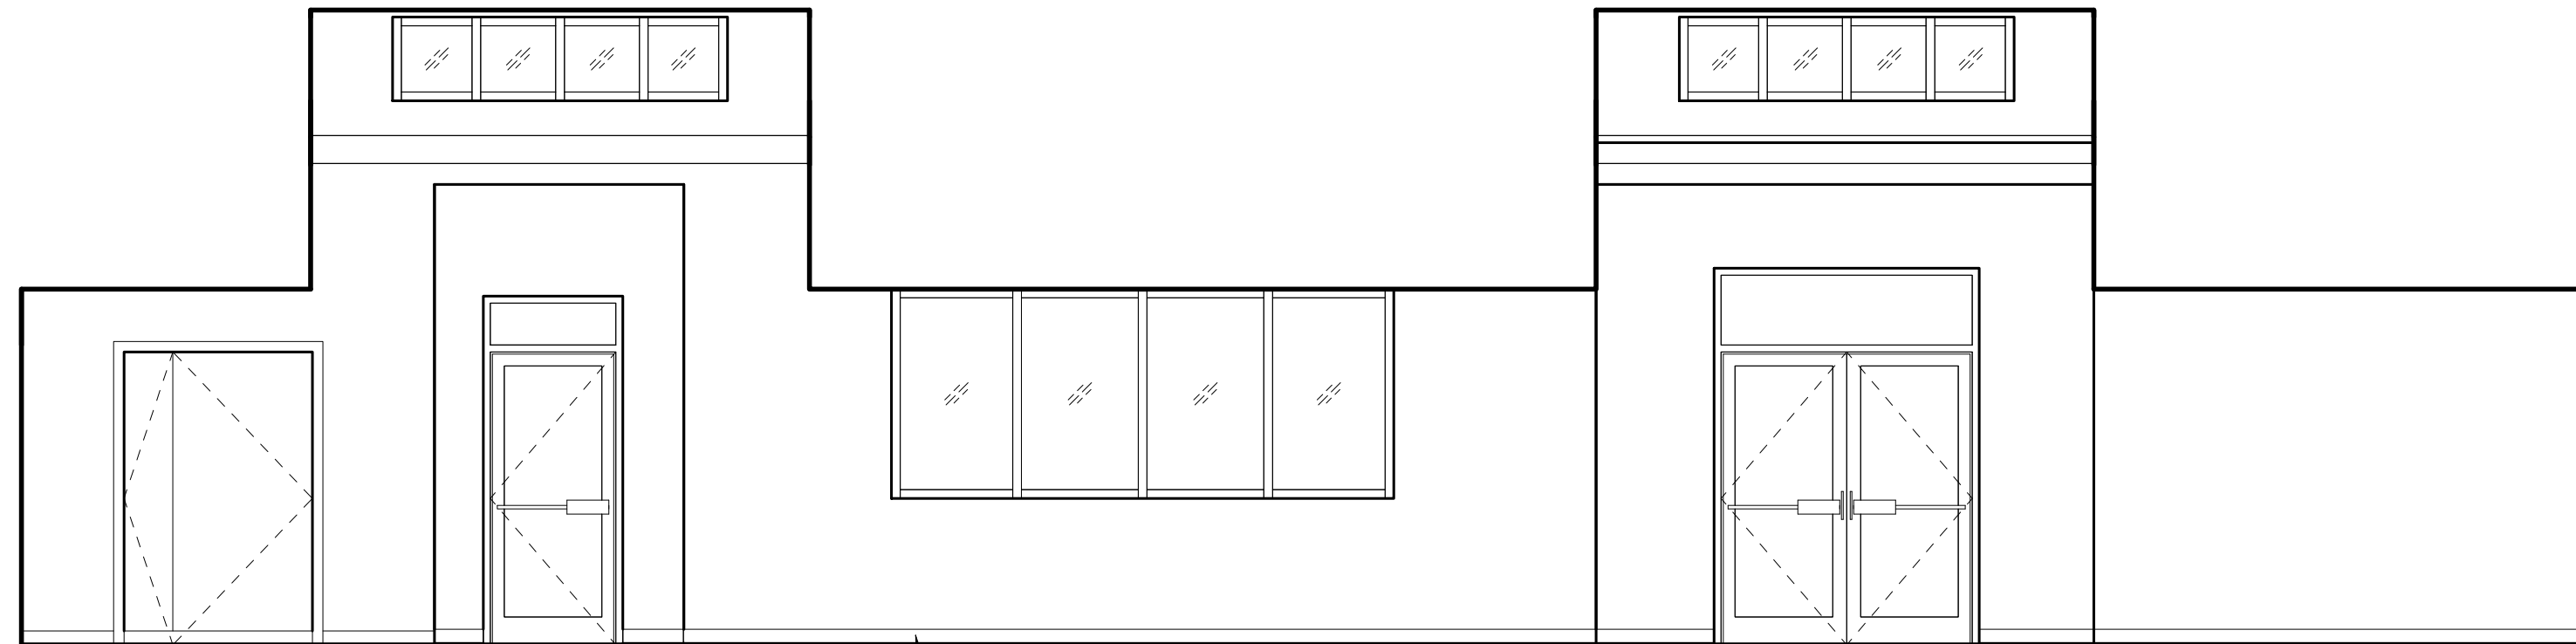


A

BASE

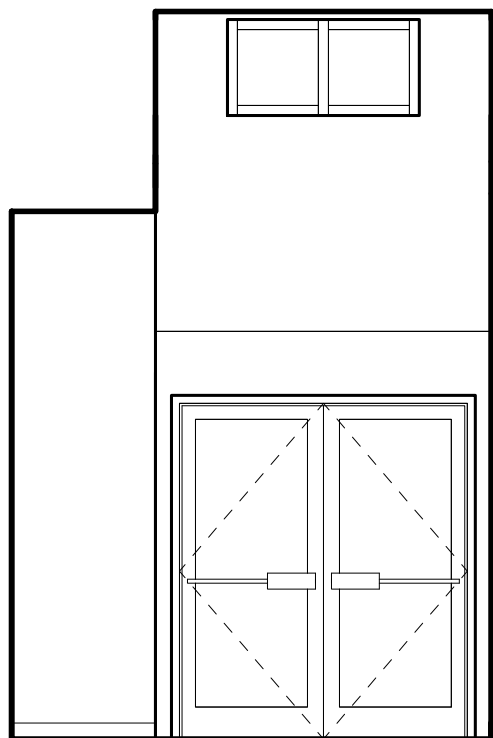


B

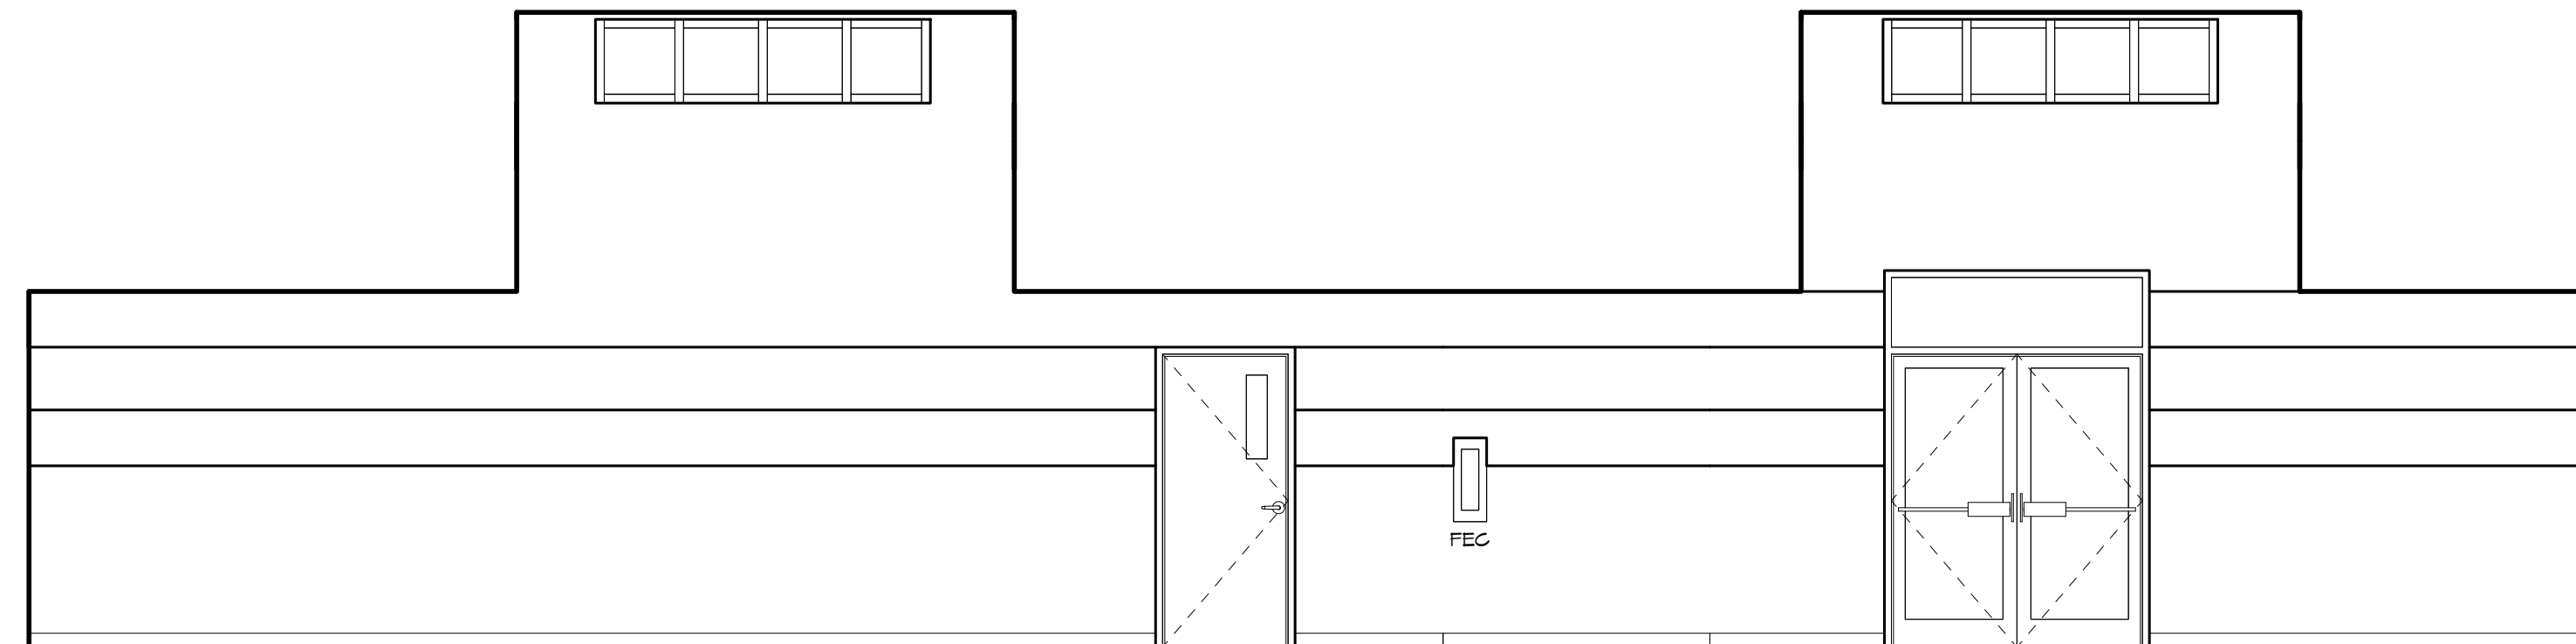

C

FEG

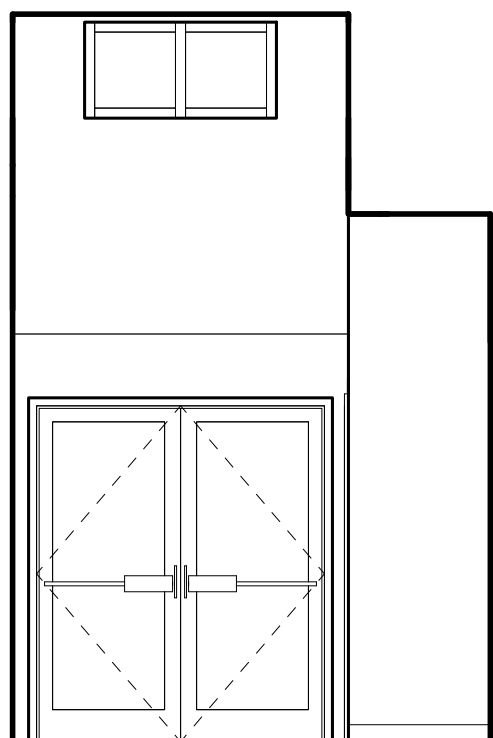

D

4

CLEAN CORRIDOR INT. ELEVS (124)

SCALE: 1/4" = 1'-0"

REVISIONS		
No.	Description	Date

TRMA
Taniguchi Ruth Makio Architects
100 Cliff Business Center, P.O. Box EA, Agaña, GU 96910
Tel.: (671) 475-8772 • Fax: (671) 472-3381

Architecture
Planning
Interior Design

BID
DOCUMENTS



Project:
GUAM COMMUNITY
COLLEGE
FORENSIC DNA LAB

 
Title:
LAB. INTERIOR
ELEVATIONS

Designed: TRMA
Drawn: RM/TP
Checked: CTC
Supv: MM
Scale: 1/4" = 1'-0"
Date: 12/17/12
Project No. 1026
Drawing No.


A6.5
Sheet No. of




IF SHEET IS LESS THAN 24" X 36"
REDUCED PRINT - USE GRAPHIC SCALES




A

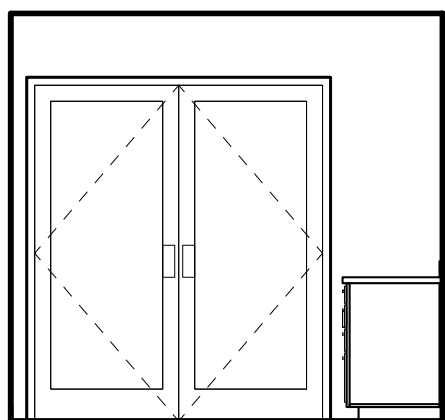

B

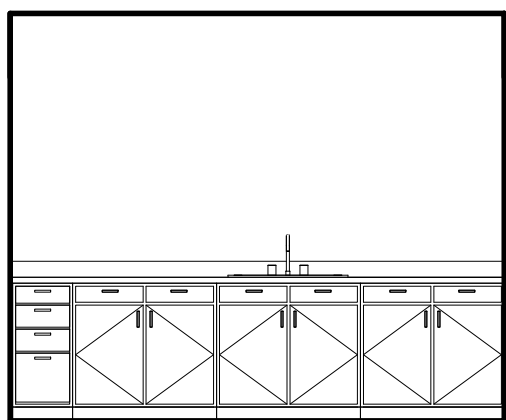

C

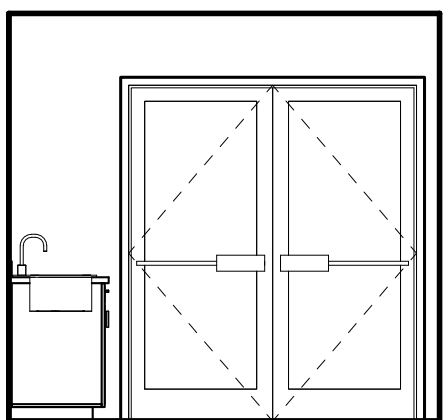


D

1

SEC. REC. "A" (125)


SCALE: 1/4" = 1'-0"

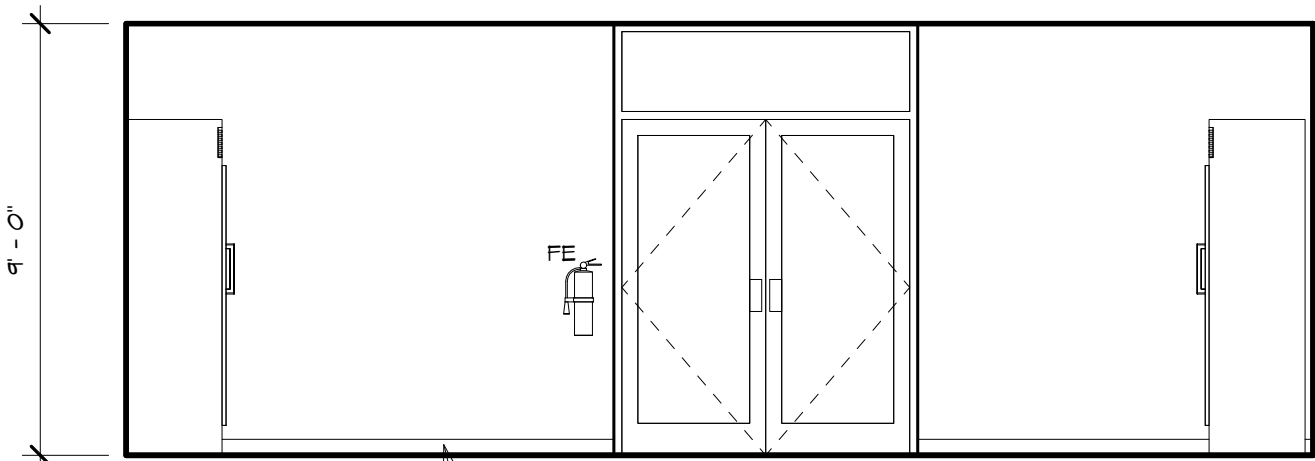


A

REFRIGERATOR STORAGE.
(123)


SCALE: 1/4" = 1'-0"

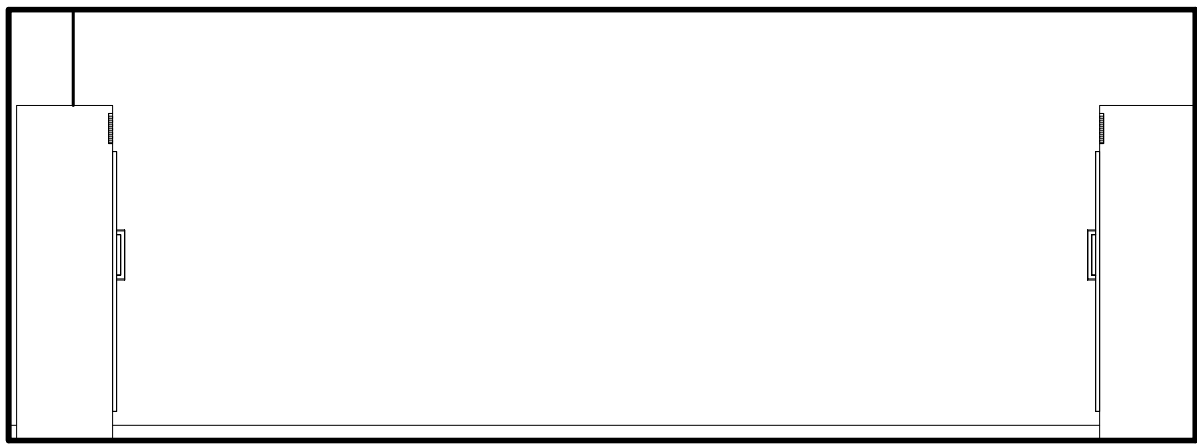

C

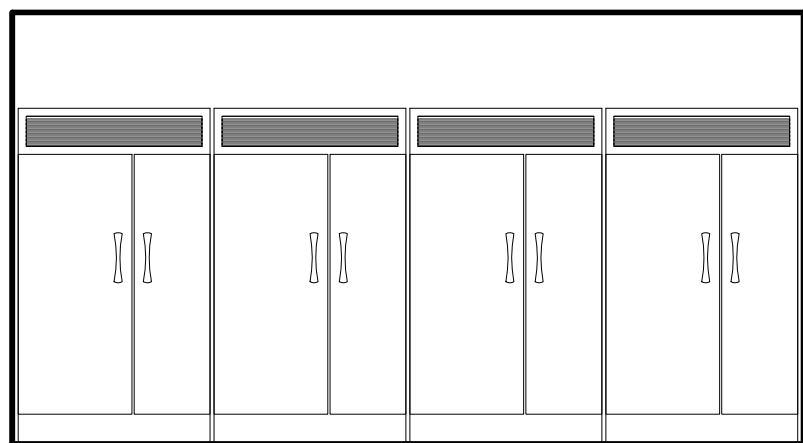

B2

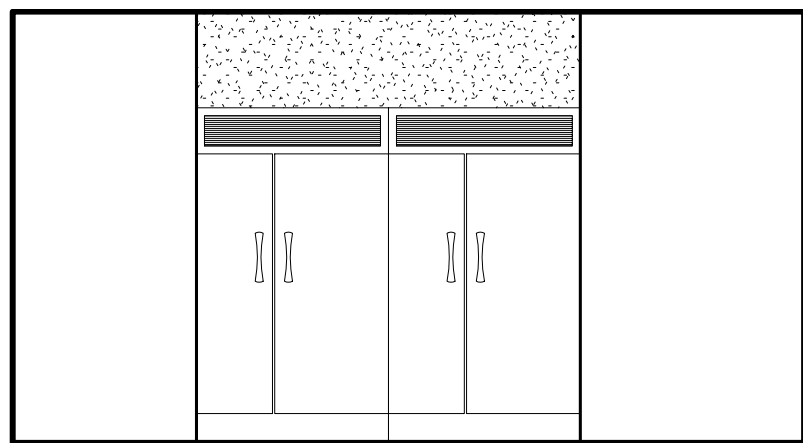


D2


3

REFRIGERATOR STORAGE
"B2" AND "D2" (123)

SCALE: 1/4" = 1'-0"

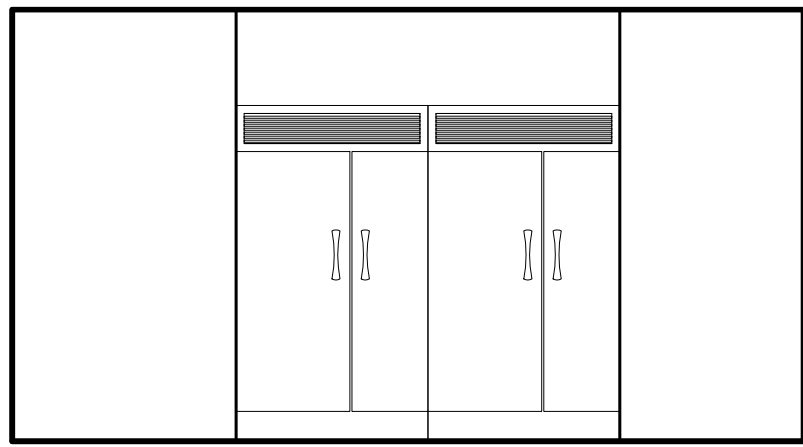

B

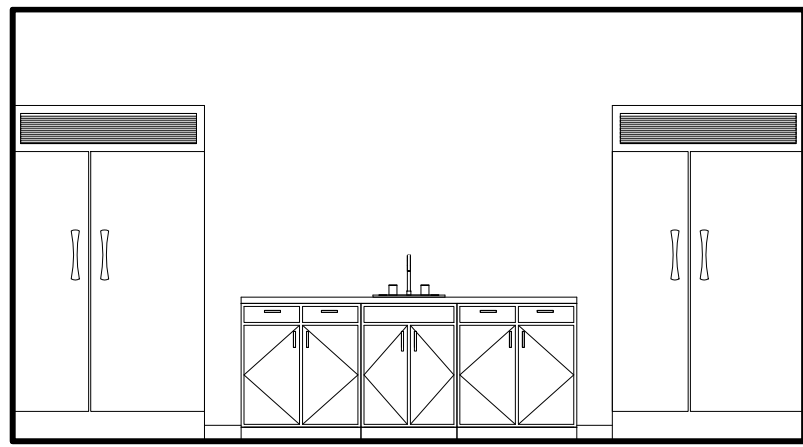

D

REVISIONS		
No.	Description	Date

TRMA
Taniguchi Ruth Makio Architects
100 Cliff Business Center, P.O. Box EA, Agaña, GU 96910
Tel.: (671) 475-8772 • Fax: (671) 472-3381

Architecture
Planning
Interior Design

BID
DOCUMENTS





Project:
GUAM COMMUNITY
COLLEGE
FORENSIC DNA LAB





Title:
LAB. INTERIOR
ELEVATIONS

Designed: TRMA
Drawn: RM/TP
Checked: CTC
Supv: MWM
Scale: 1/4" = 1'-0"
Date: 12/17/12
Project No. 1026
Drawing No.




A6.6
Sheet No. _____ of _____

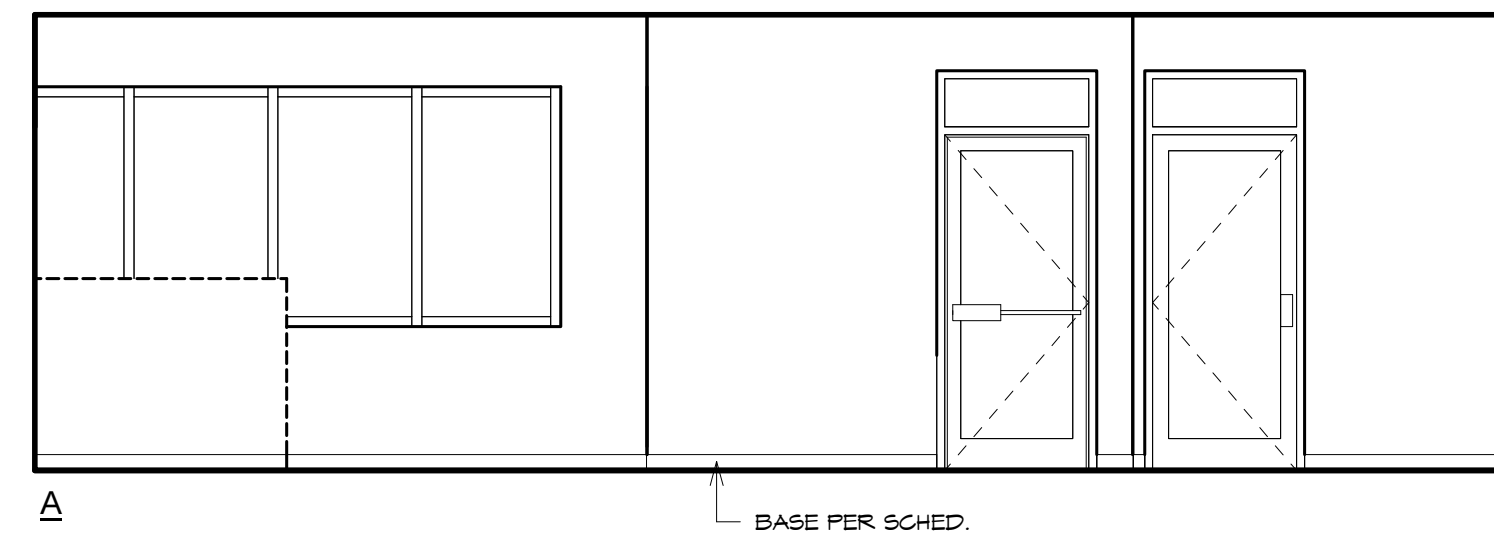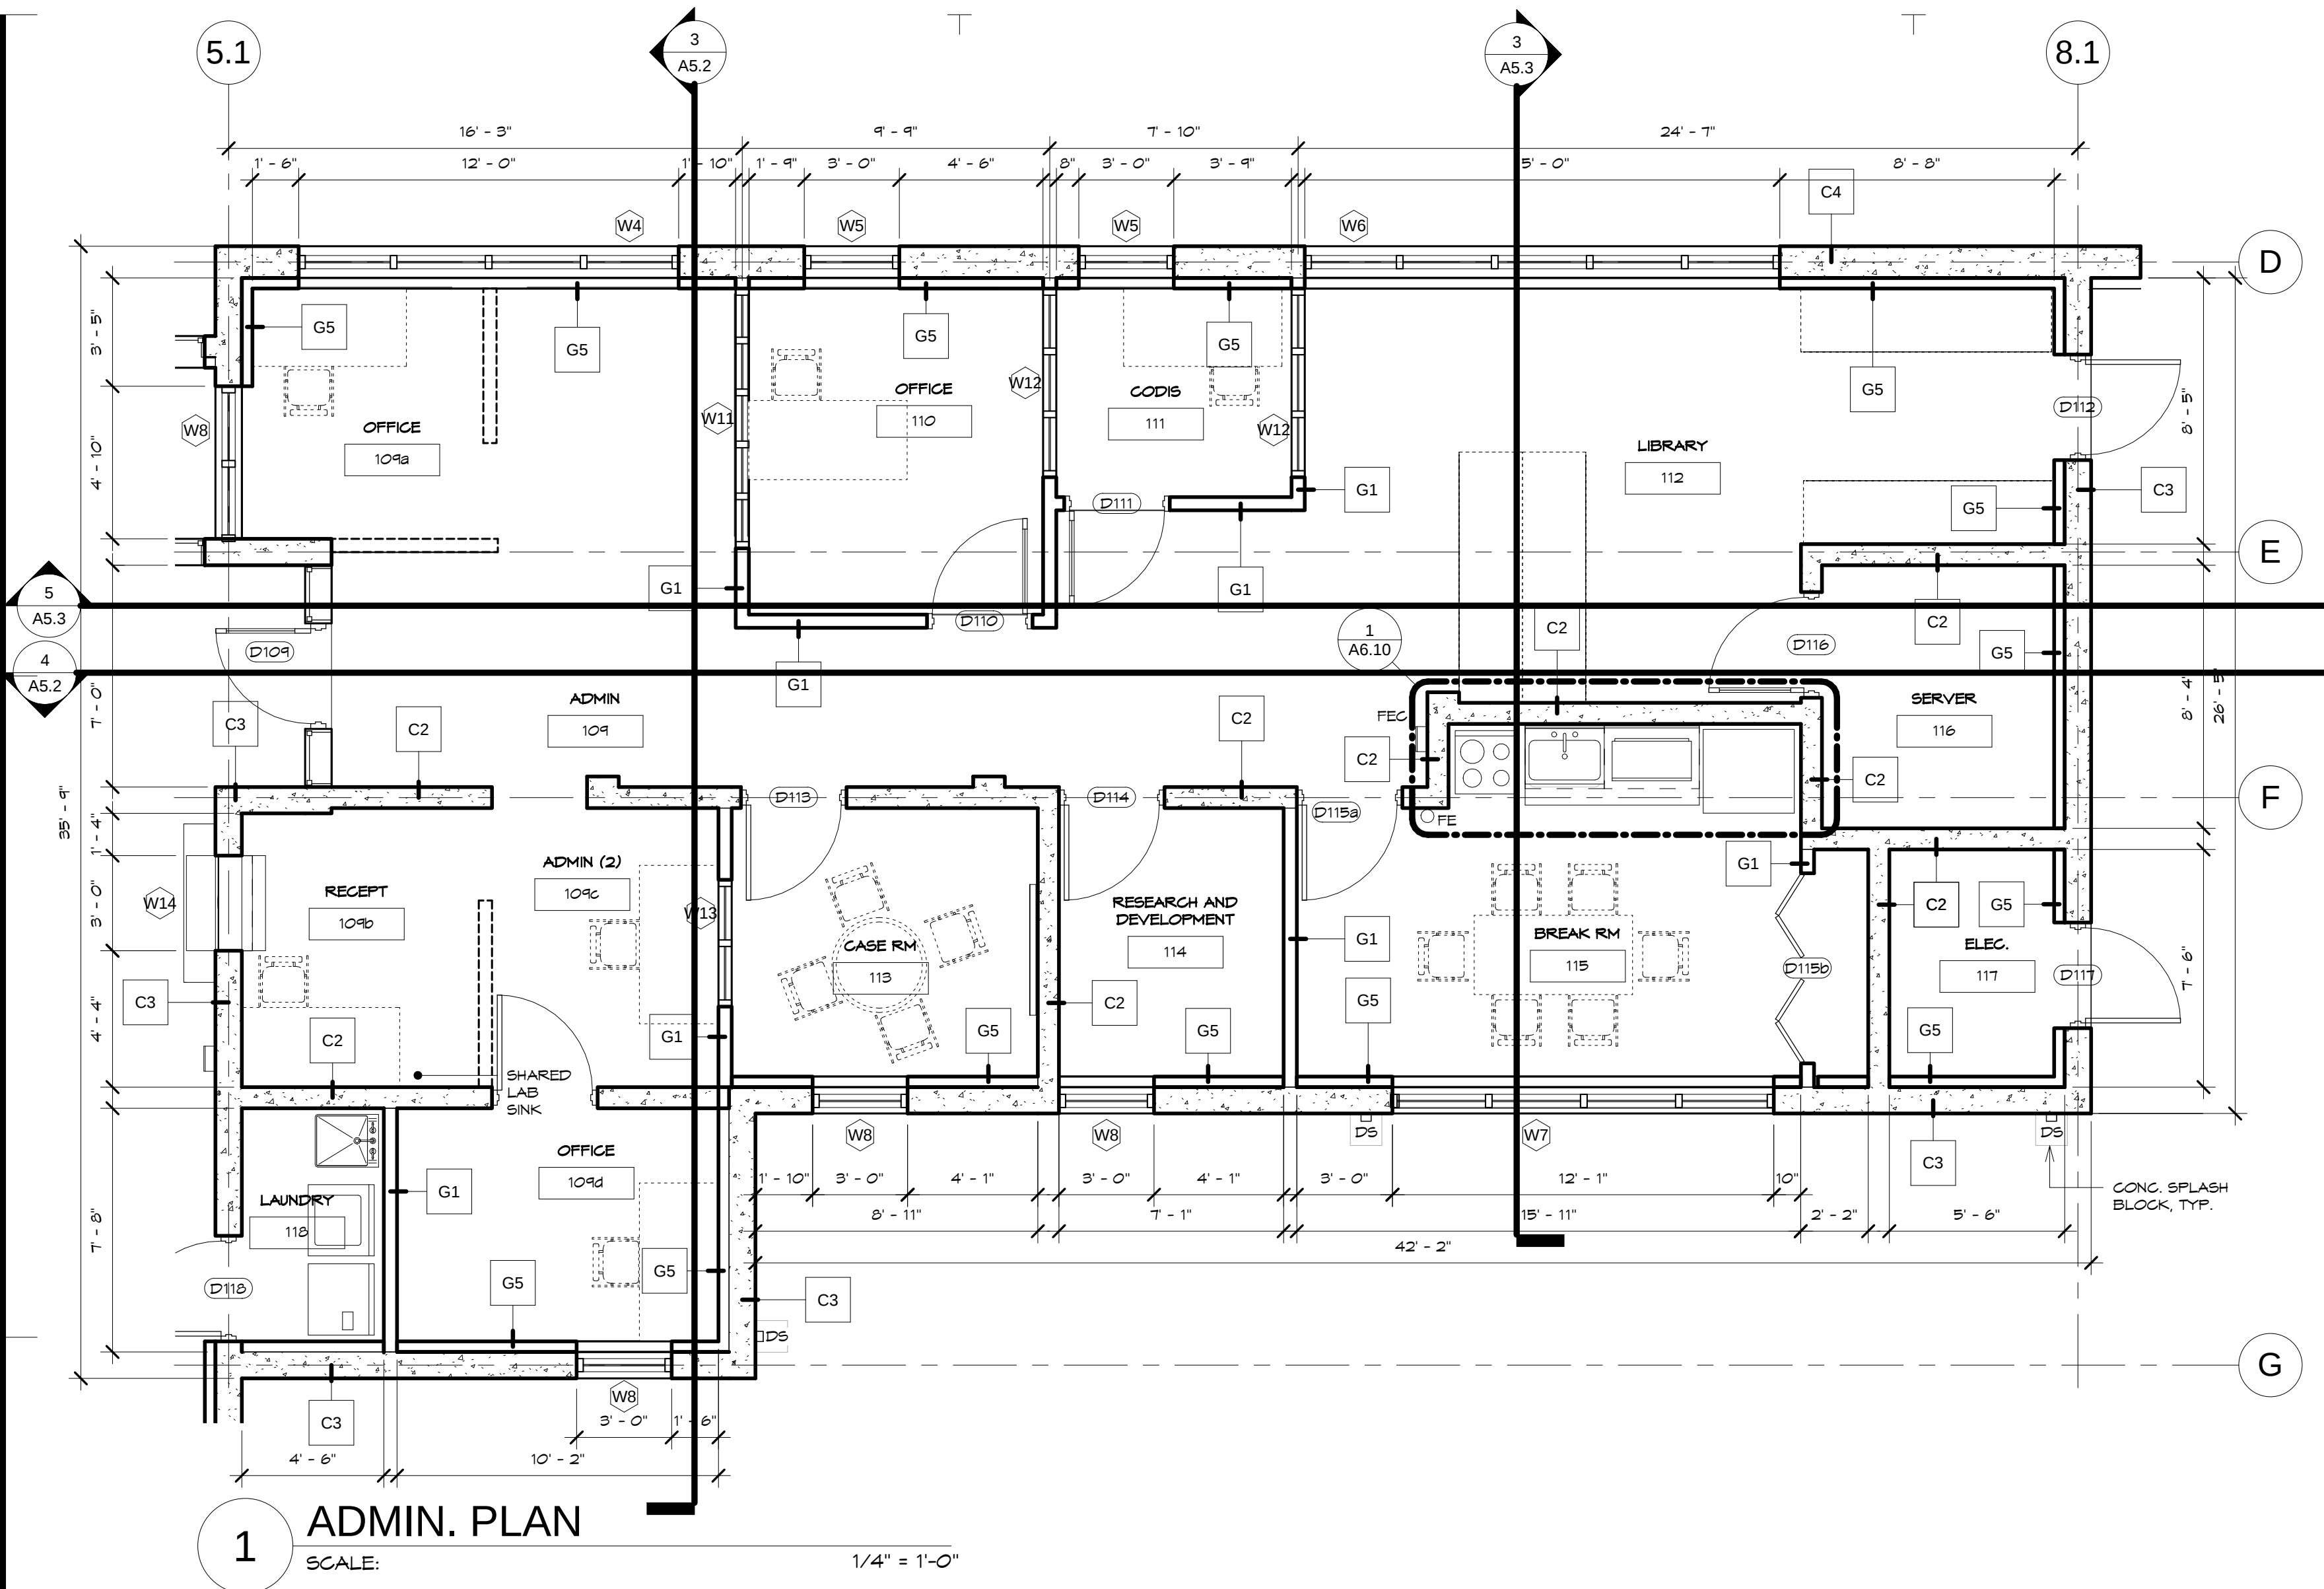









2 ADMIN AREA (109)
SCALE: 1/4" = 1'-0"

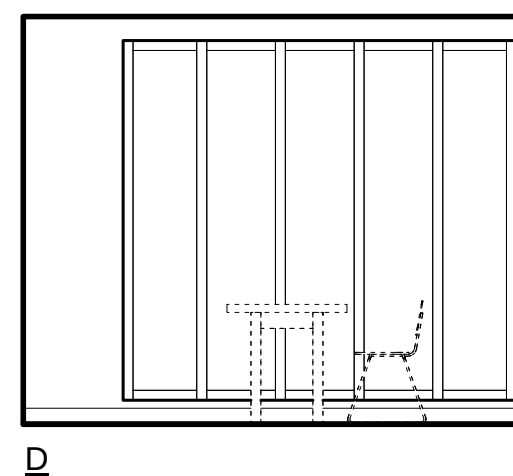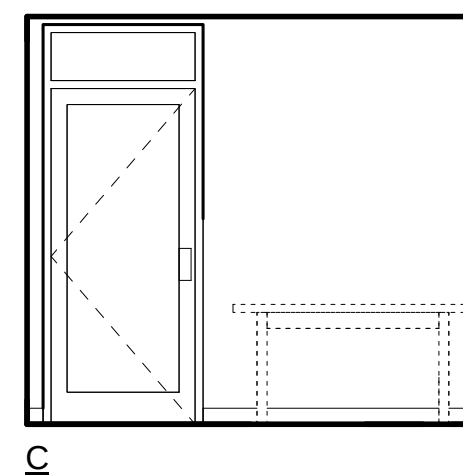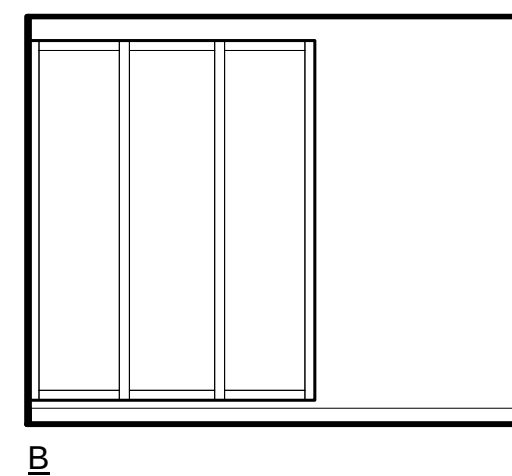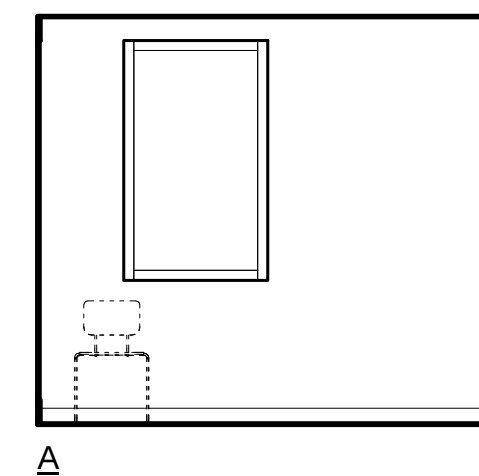


3 OFFICE (110)
SCALE: 1/4" = 1'-0"

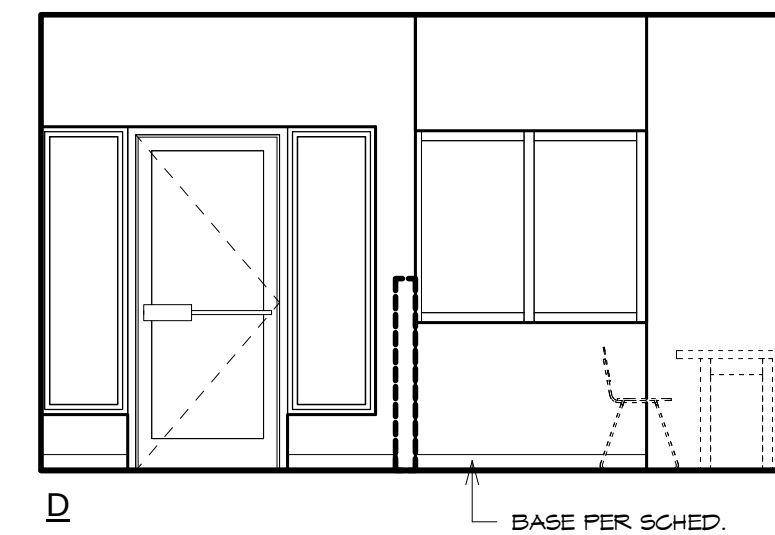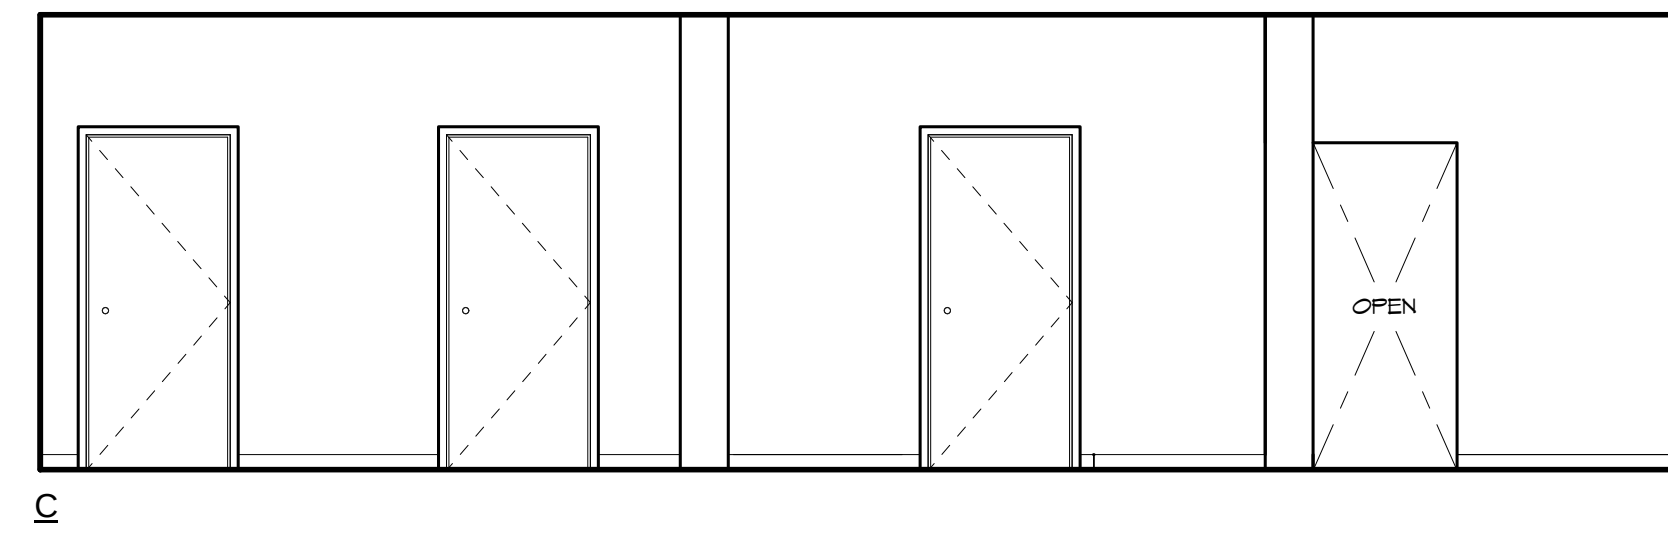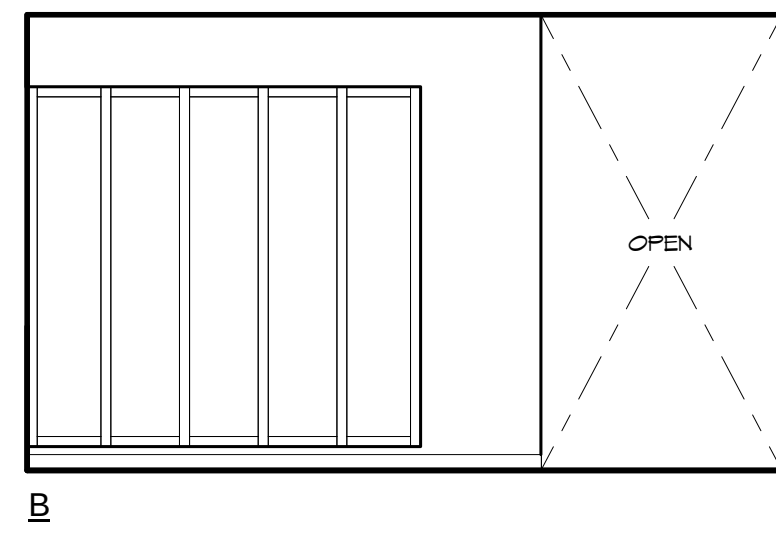

4 CODIS (111)
SCALE: 1/4" = 1'-0"

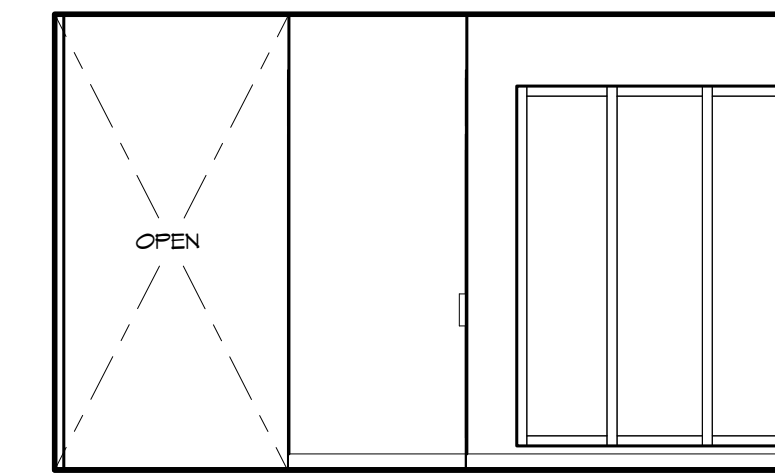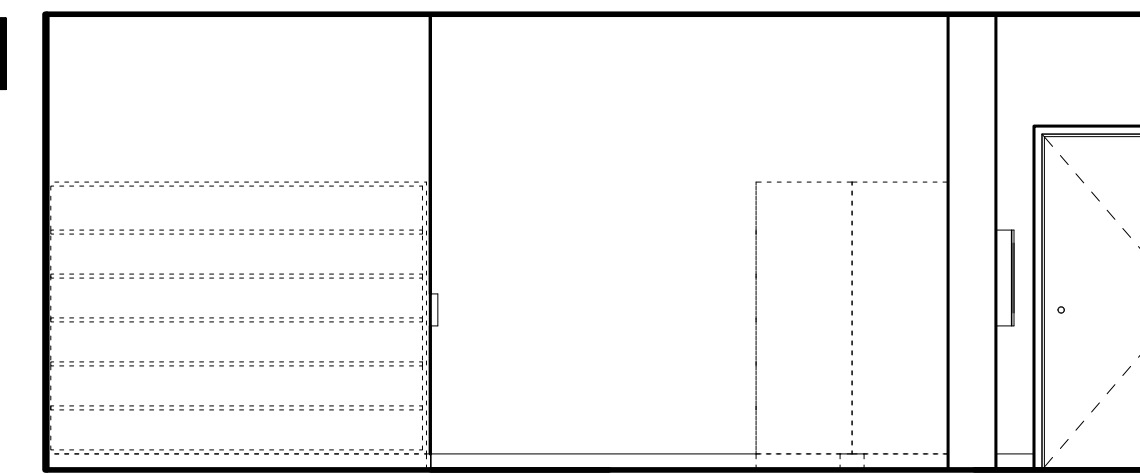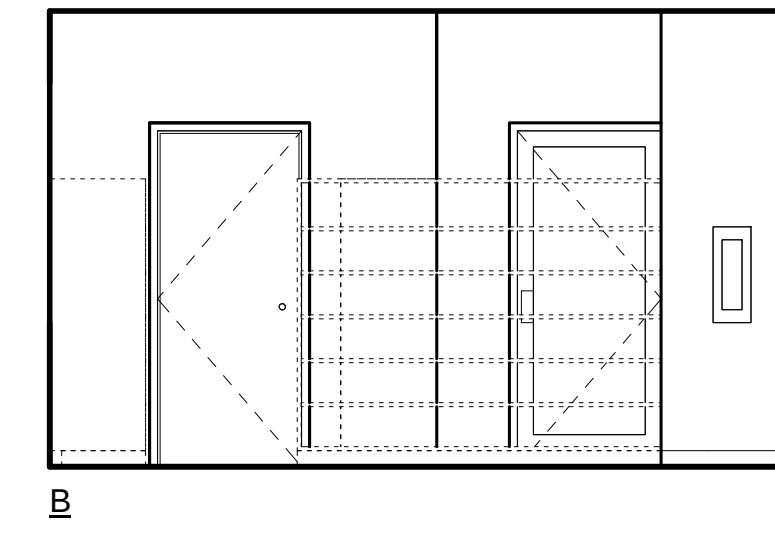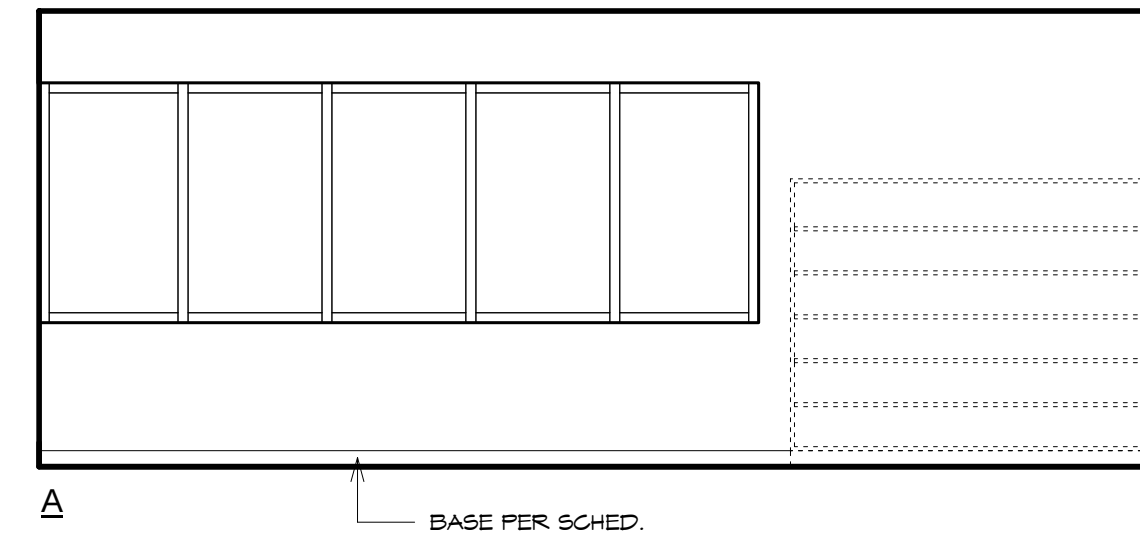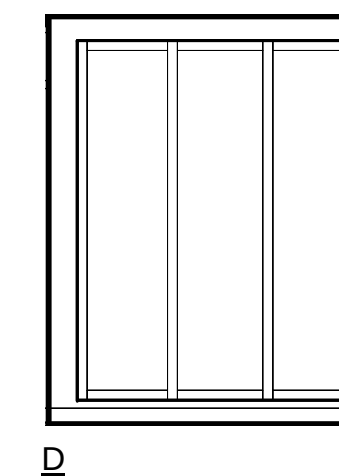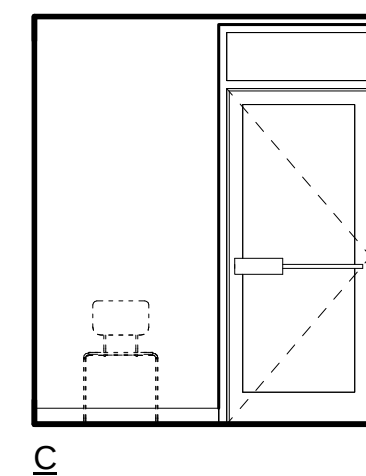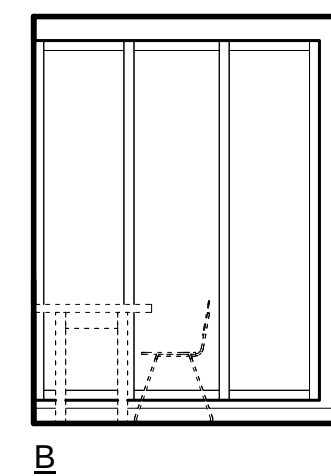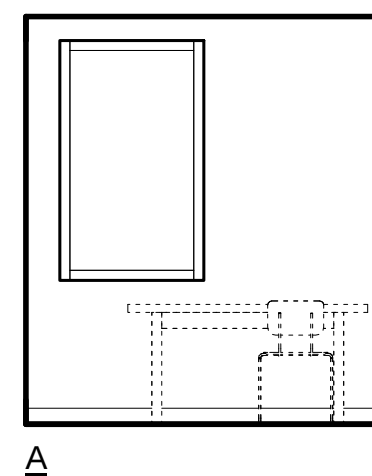


5 LIBRARY (112)
SCALE: 1/4" = 1'-0"

 


IF SHEET IS LESS THAN 24" X 36"
REDUCED PRINT - USE GRAPHIC SCALES

REVISIONS		
No.	Description	Date
TRMA Taniguchi Ruth Makio Architects 100 Cliff Business Center, P.O. Box EA, Agaña, GU 96910 Tel.: (671) 475-8772 • Fax: (671) 472-3381		
Architecture Planning Interior Design		
BID DOCUMENTS		
I HEREBY CERTIFY THAT THIS PLAN WAS PREPARED BY ME OR UNDER MY DIRECT SUPERVISION DATE: _____		
Project: GUAM COMMUNITY COLLEGE FORENSIC DNA LAB		
Title: ADMIN/LIBRARY DETAIL PLAN AND INT. ELEVS.		
Designed:	TRMA	
Drawn:	RM/TP	
Checked:	CTC	
Supv:	MMM	
Scale:	1/4" = 1'-0"	
Date:	12/17/12	
Project No.	1026	File
Drawing No.	A6.7	
Sheet No.	of	

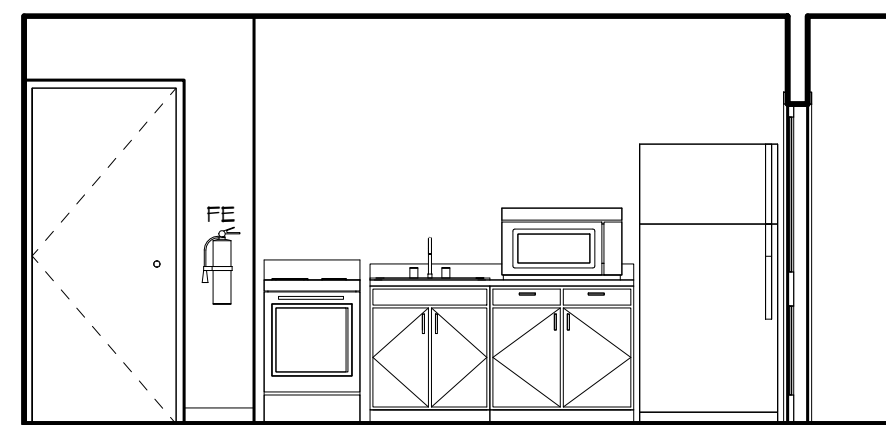


A

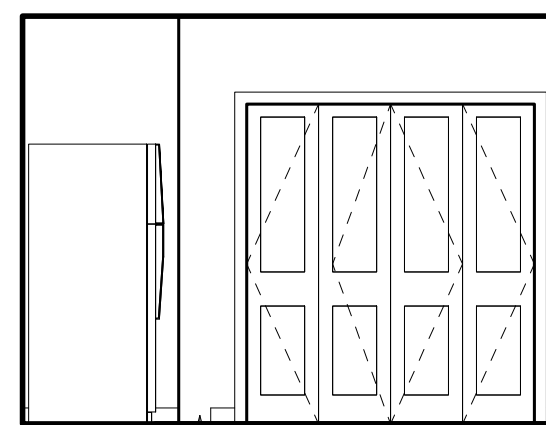


B

BASE PER SCHED.

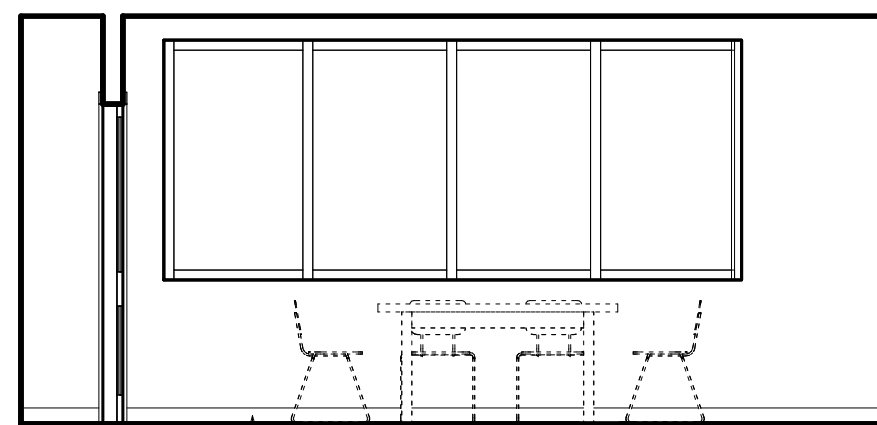


C

BASE PER SCHED.

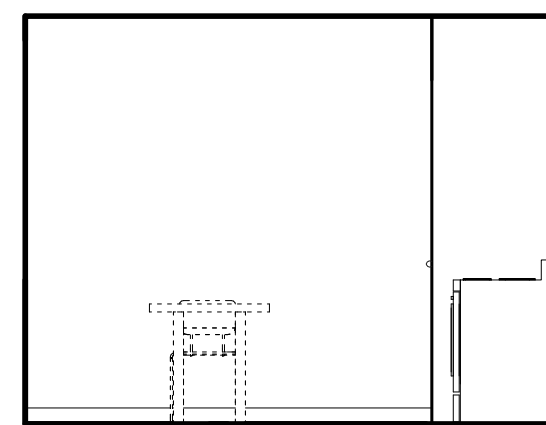


D


1 BREAK RM. INT. ELEVS.
SCALE: 1/4" = 1'-0"

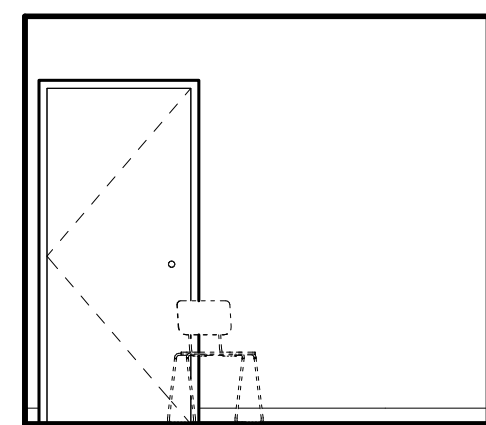


A

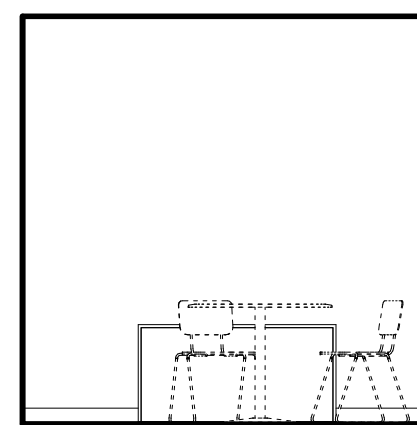

B

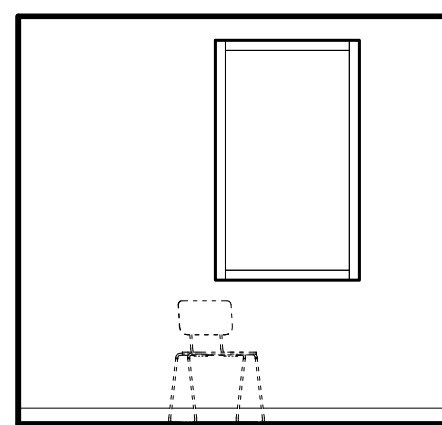


C

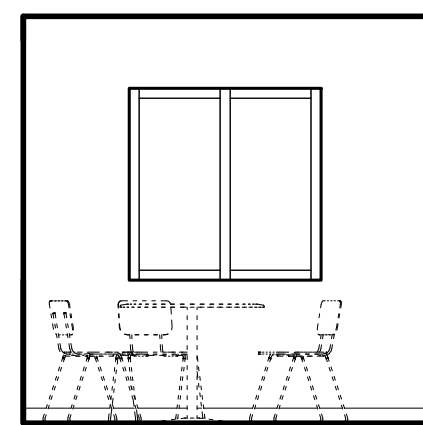


D


2 CASE RM. INT. ELEVS.
SCALE: 1/4" = 1'-0"

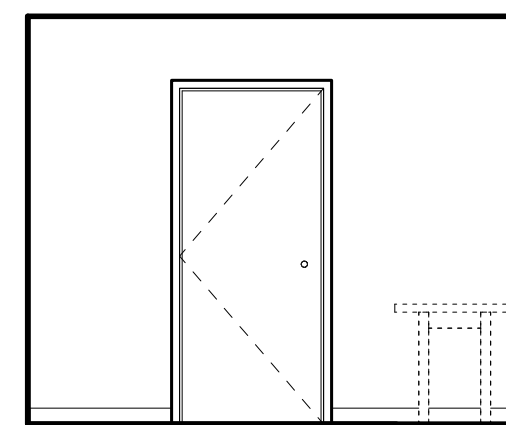


A

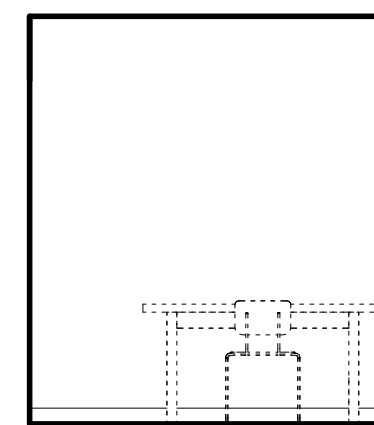


B

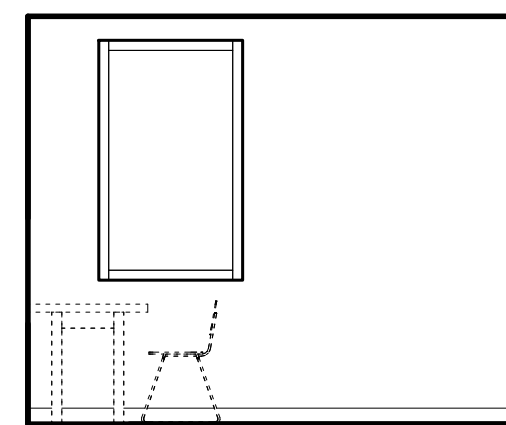


C

 


4 OFFICE (109d)
SCALE: 1/4" = 1'-0"

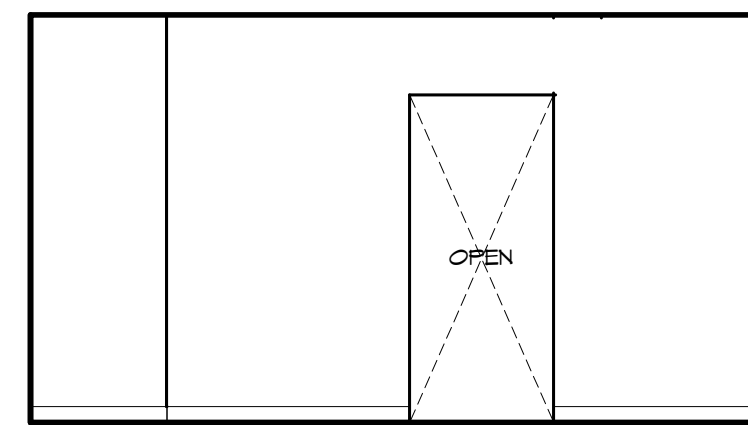


A

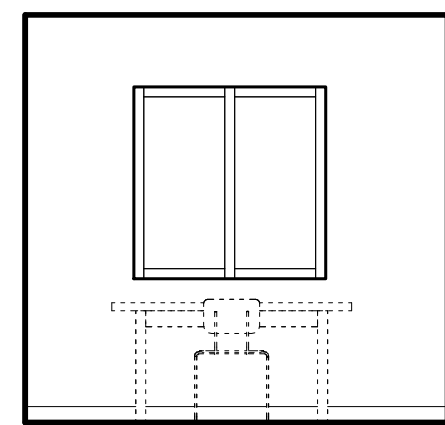

B

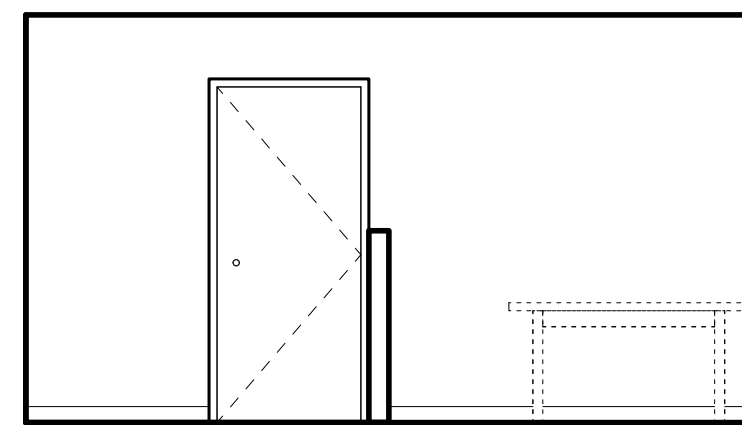


C

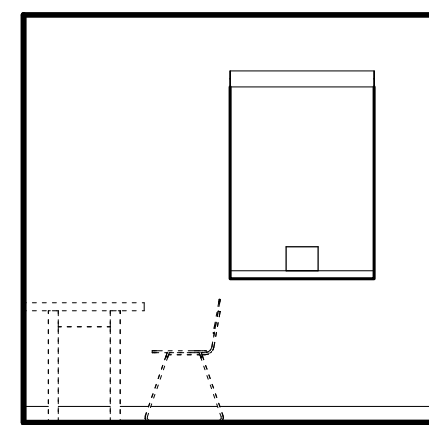


D


3 ADMIN/RECEPT (109b), (109c)
SCALE: 1/4" = 1'-0"

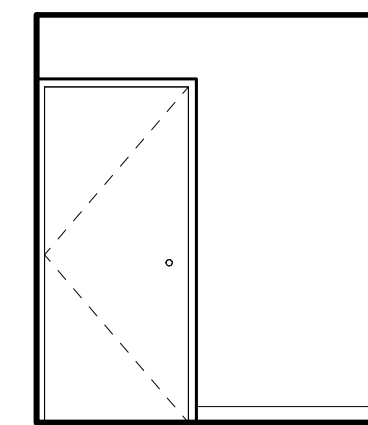


A

 

B

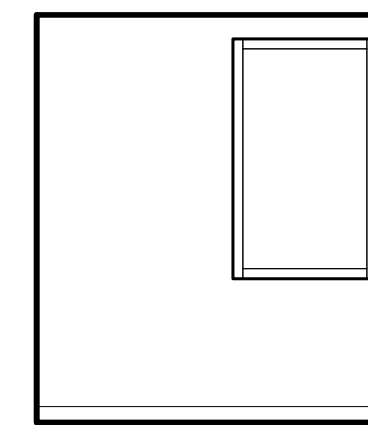


C

 


D


5 RESEARCH "A" (114)
SCALE: 1/4" = 1'-0"

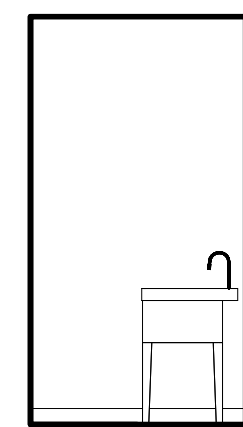


A

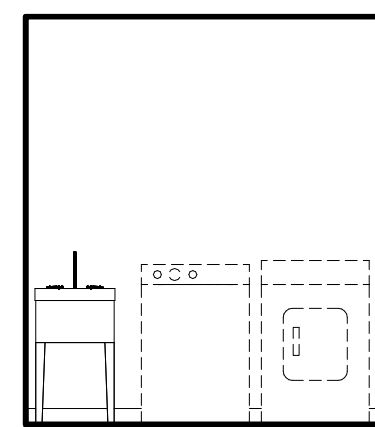

B

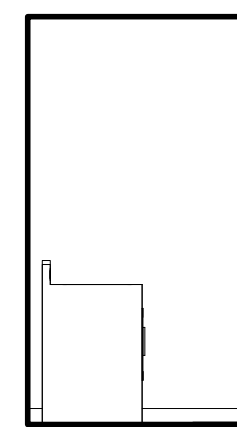

C

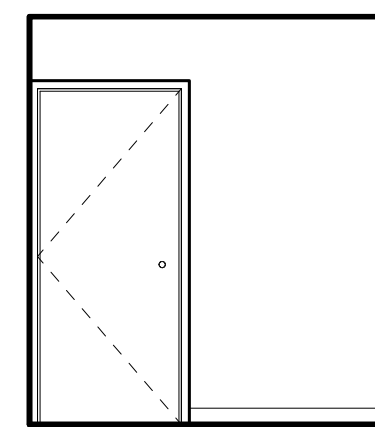

D

9 LAUNDRY "A"
SCALE: 1/4" = 1'-0"



IF SHEET IS LESS THAN 24" X 36"
REDUCED PRINT - USE GRAPHIC SCALES

REVISIONS		
No.	Description	Date

TRMA
Taniguchi Ruth Makio Architects
100 Cliff Business Center, P.O. Box EA, Agaña, GU 96910
Tel.: (671) 475-8772 • Fax: (671) 472-3381

Architecture
Planning
Interior Design

BID
DOCUMENTS




I HEREBY CERTIFY THAT THIS PLAN WAS PREPARED
BY ME OR UNDER MY DIRECT SUPERVISION
DATE: _____

Project:
GUAM COMMUNITY
COLLEGE
FORENSIC DNA LAB


Title:
ADMIN. INTERIOR
ELEVATIONS

Designed: TRMA
Drawn: RM/TP
Checked: CTC
Supv: MM
Scale: 1/4" = 1'-0"
Date: 11/28/12
Project No. 1026
Drawing No.

A6.8
Sheet No. _____ of _____

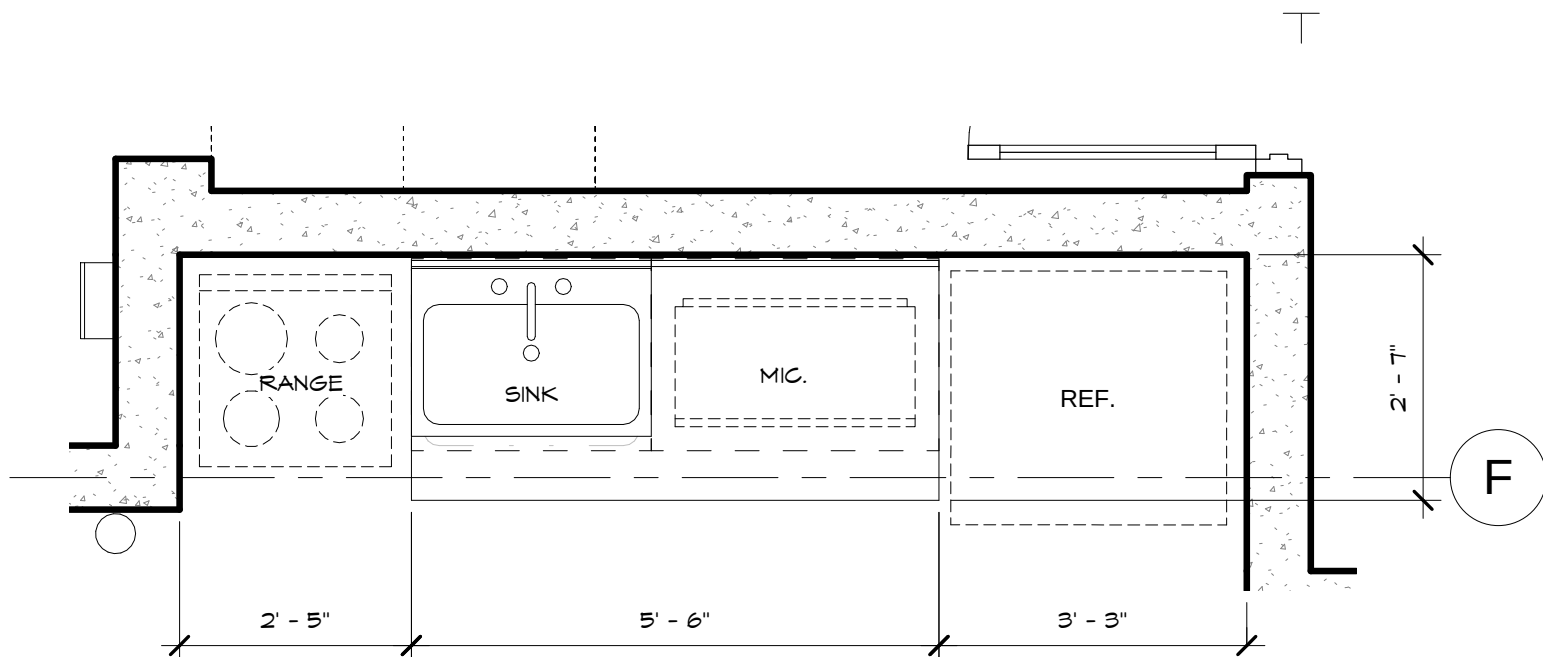


PLAN

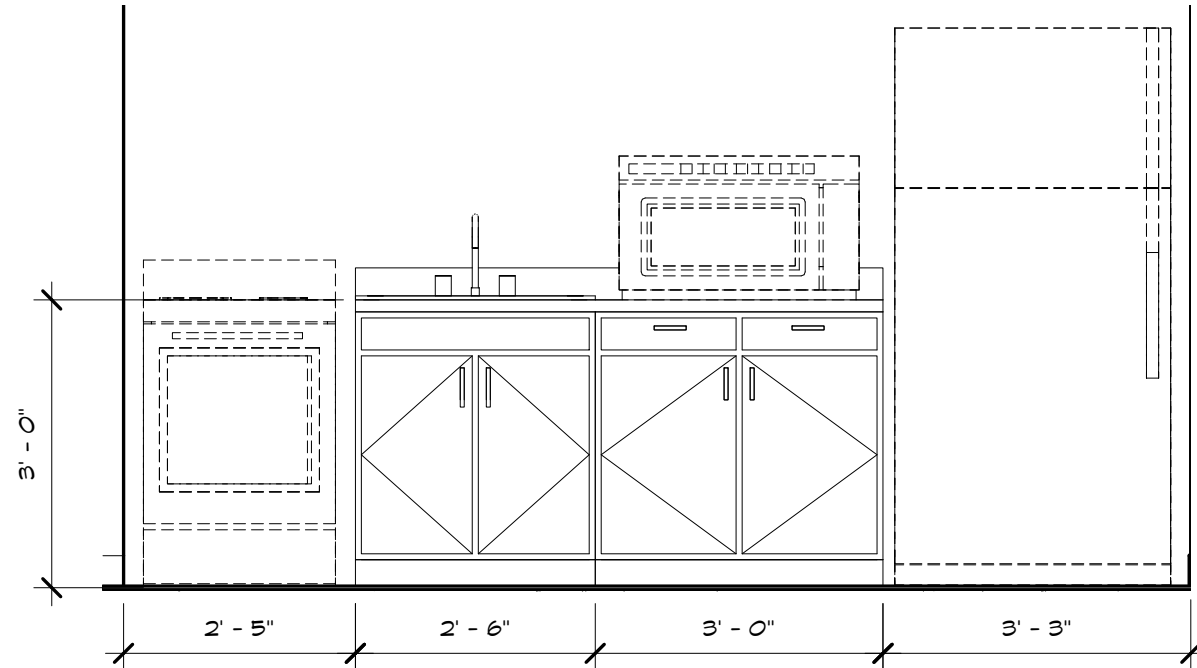


ELEVATION

1 KIT. DETAIL PLAN @ BREAKRM.
SCALE: 1/2" = 1'-0"

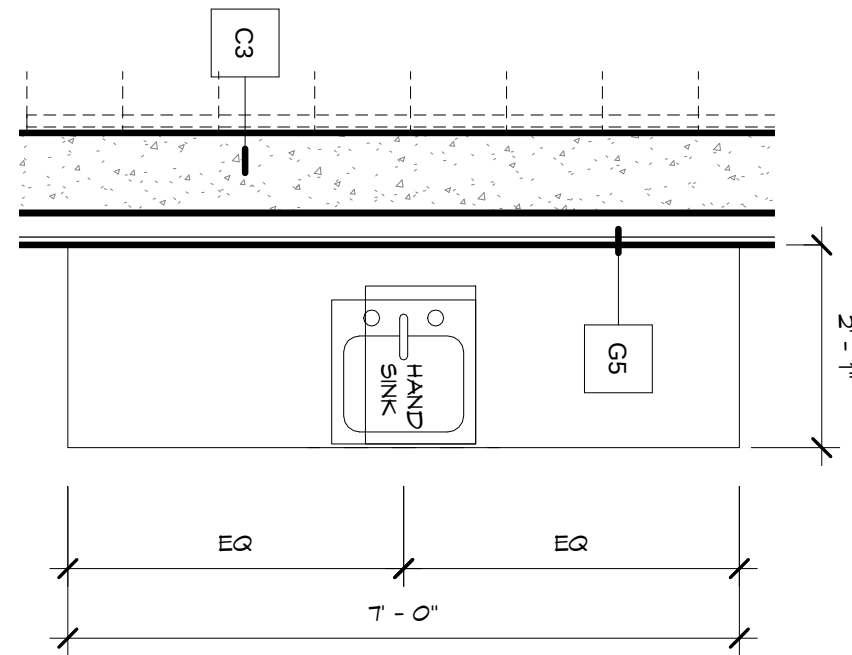


PLAN

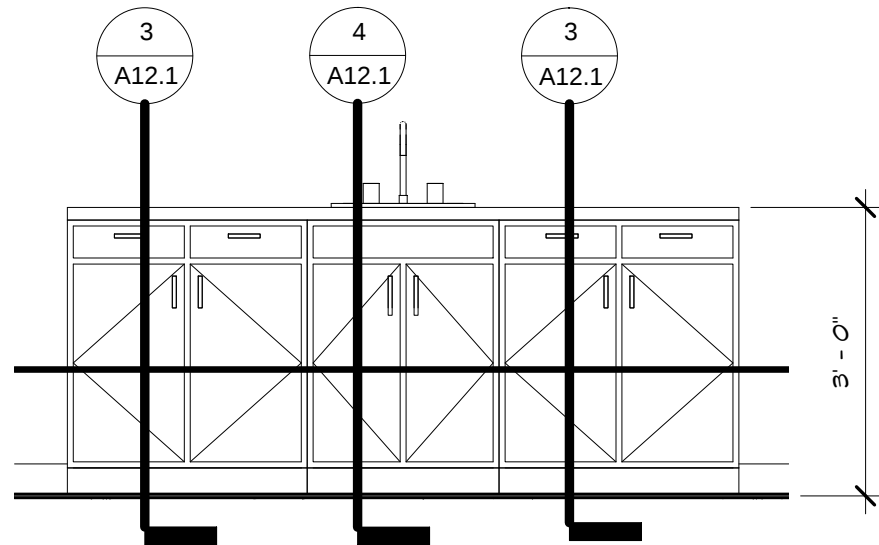


ELEVATION

3 CABINET DETAIL PLAN @ REF. STO.
SCALE 1/2" = 1'-0"

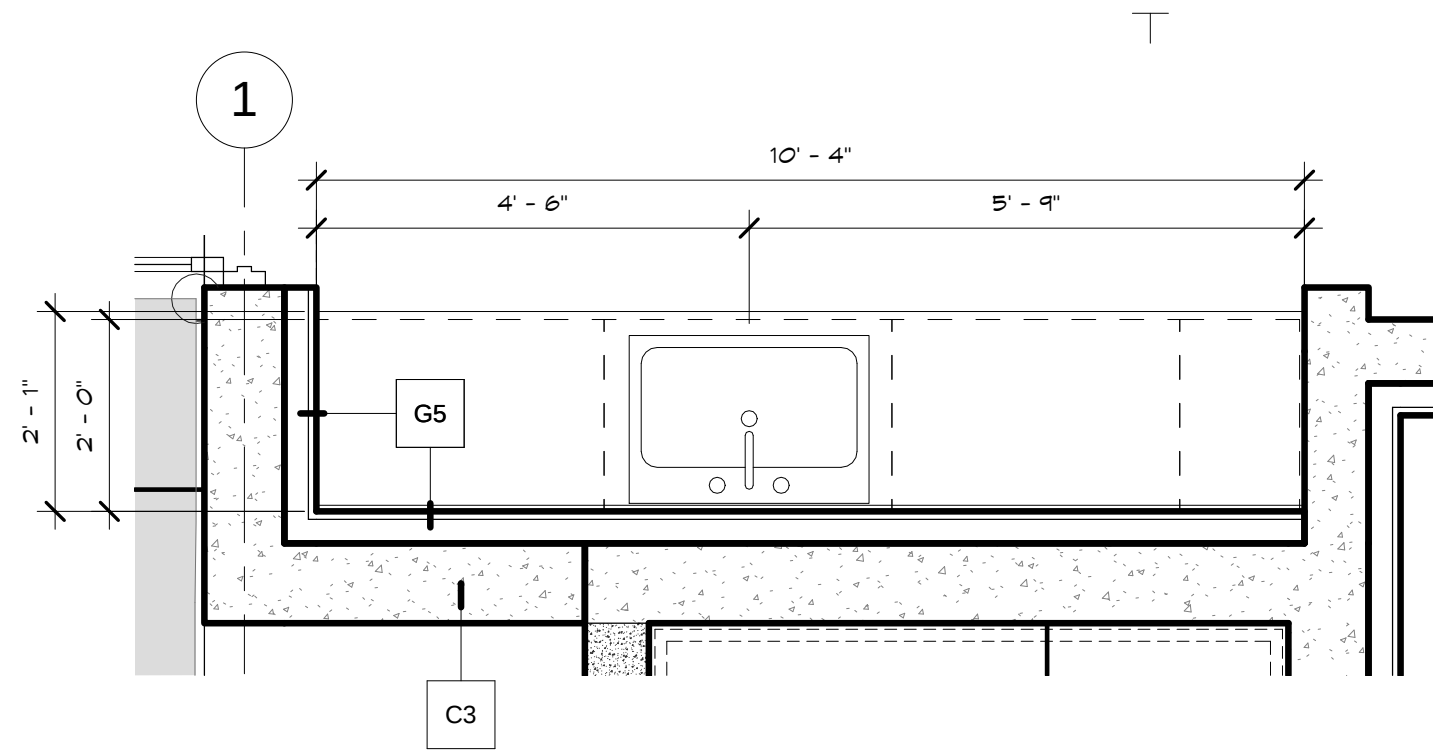

PLAN

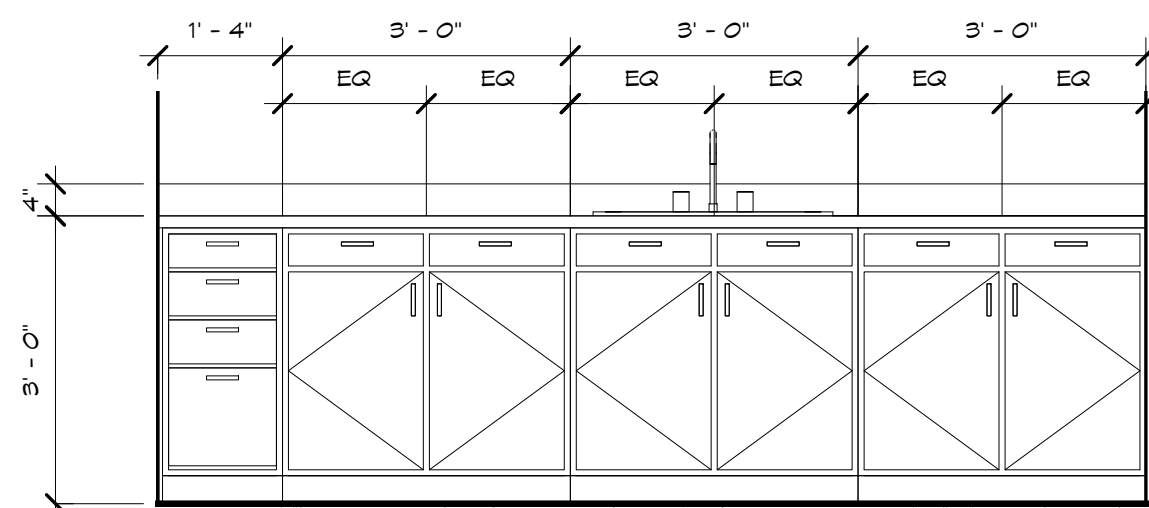

ELEVATION

5 CABINET DETAIL PLAN @ SECURE RECEIVING
SCALE: 1/2" = 1'-0"

REVISIONS		
No.	Description	Date

TRMA
Taniguchi Ruth Makio Architects
100 Cliff Business Center, P.O. Box EA, Agaña, GU 96910
Tel.: (671) 475-8772 • Fax: (671) 472-3381

Architecture
Planning
Interior Design

BID
DOCUMENTS




Project:
GUAM COMMUNITY COLLEGE
FORENSIC DNA LAB

Title:
CASEWORK DETAIL PLAN AND ELEVATIONS


Designed: TRMA
Drawn: RM/TP
Checked: CTC
Supv: MAM
Scale: 1/2" = 1'-0"
Date: 12/17/12
Project No. 1026 File
Drawing No.

A6.10
Sheet No. _____ of _____


IF SHEET IS LESS THAN 24" X 36"
REDUCED PRINT - USE GRAPHIC SCALES

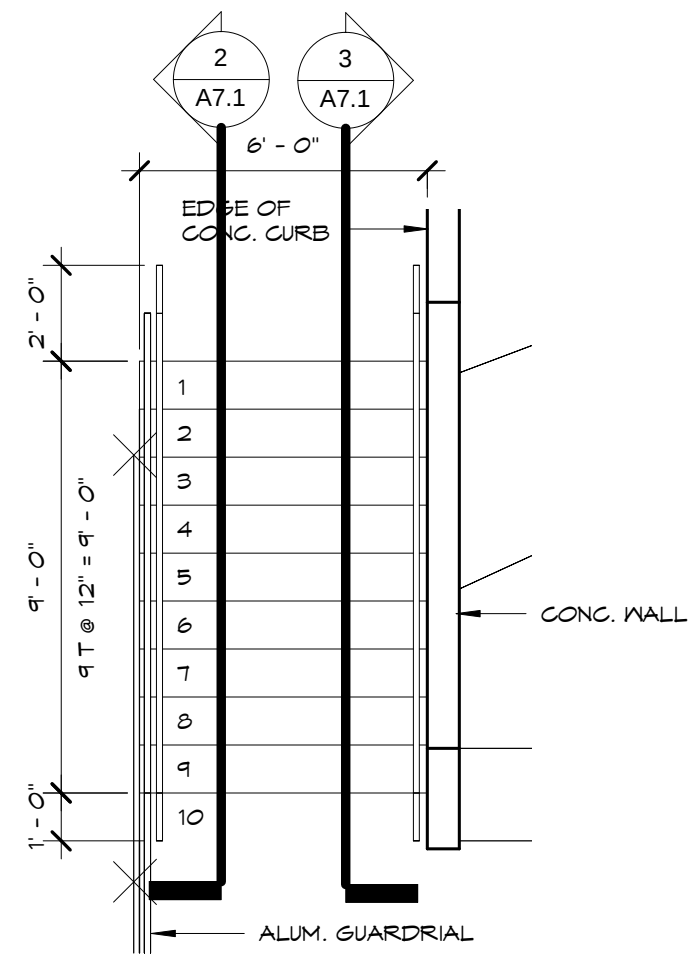


1 STAIR # 1 PLAN
SCALE: 1/4" = 1'-0"

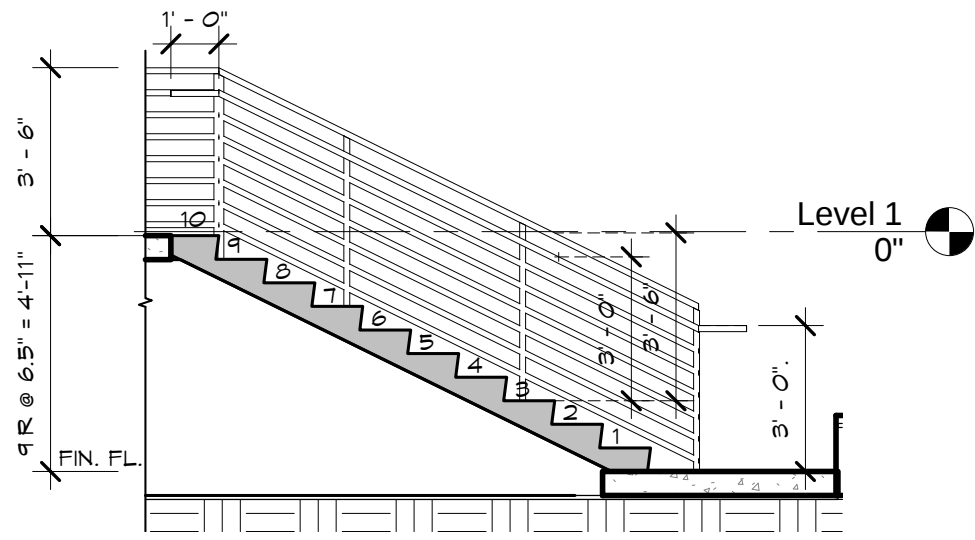


2 STAIR SECTION 1
SCALE: 1/4" = 1'-0"

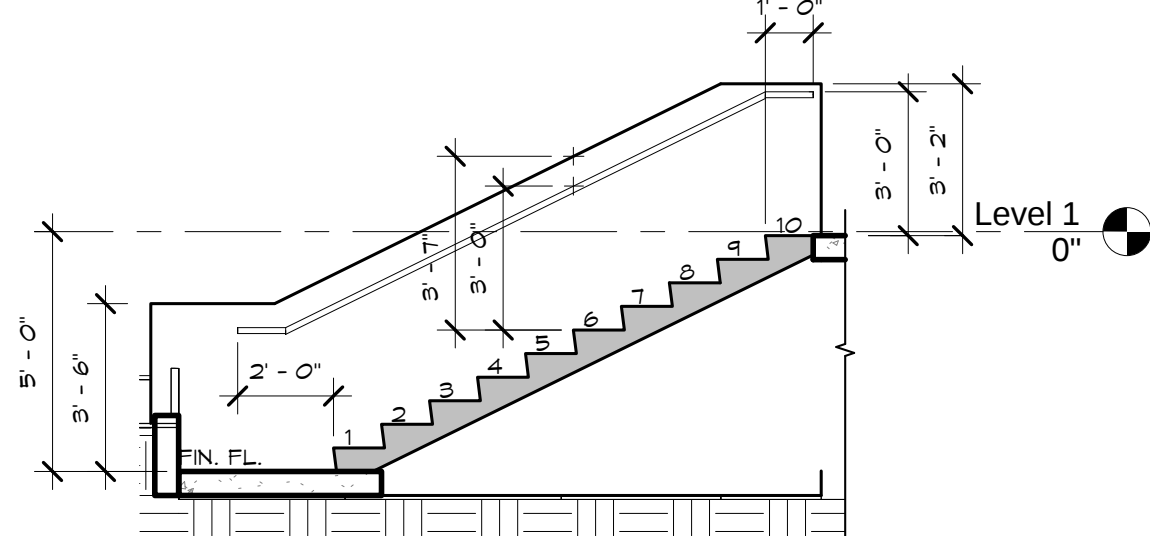


3 STAIR SECTION 2
SCALE: 1/4" = 1'-0"

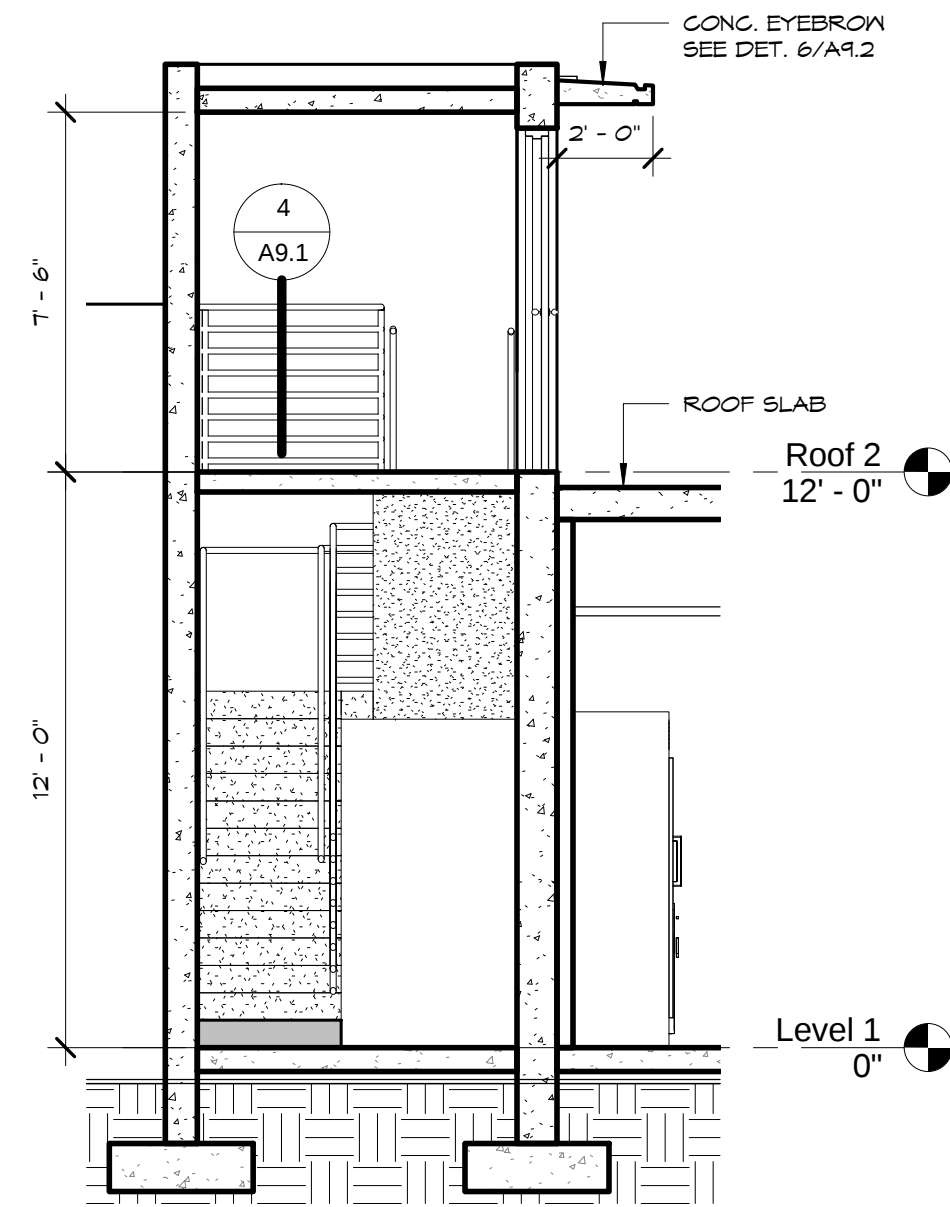


8 STAIR # 2 SECTION C
SCALE: 1/4" = 1'-0"

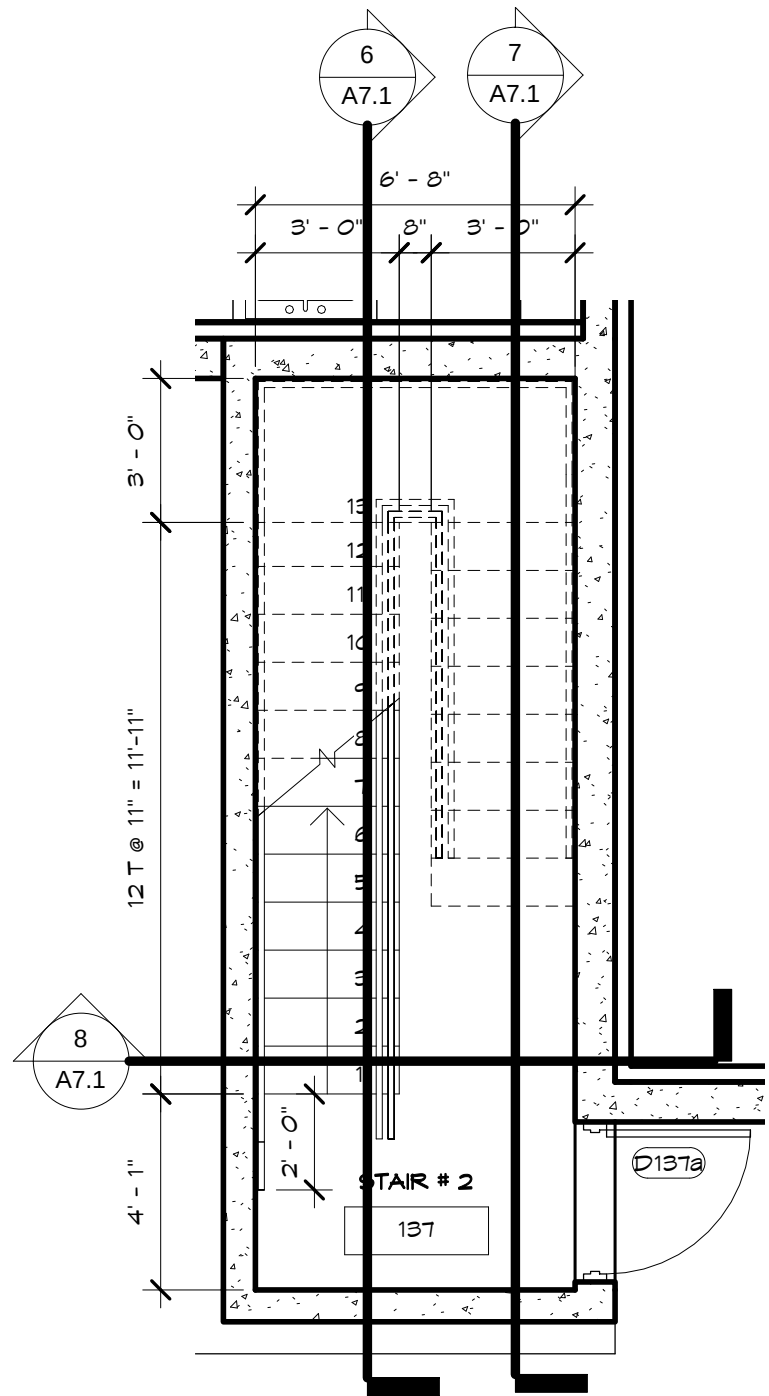


4 STAIR # 2 PLAN - FIRST FLOOR
SCALE: 1/4" = 1'-0"

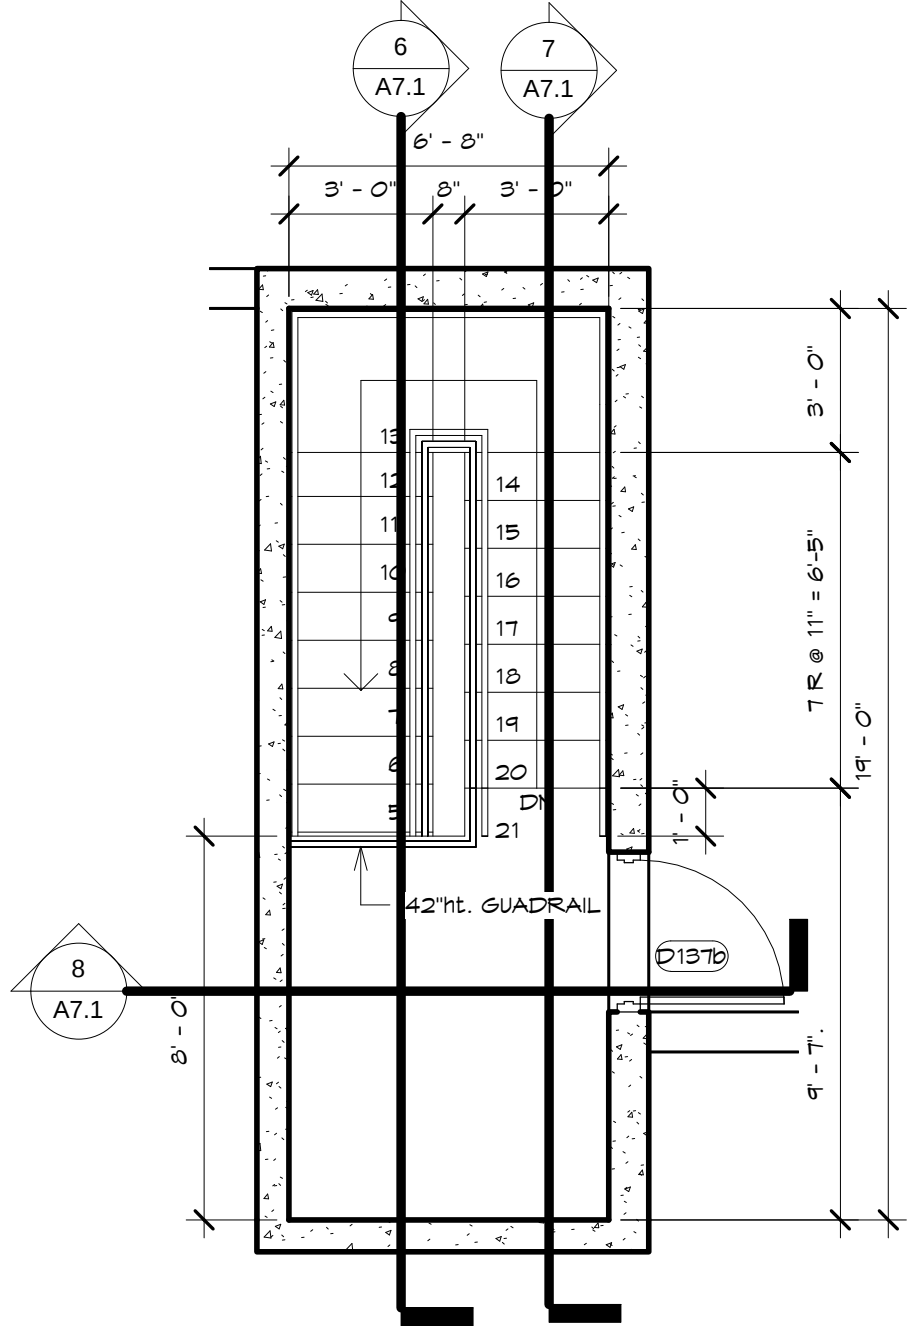

5 STAIR # 2 PLAN - ROOF LEVEL
SCALE: 1/4" = 1'-0"

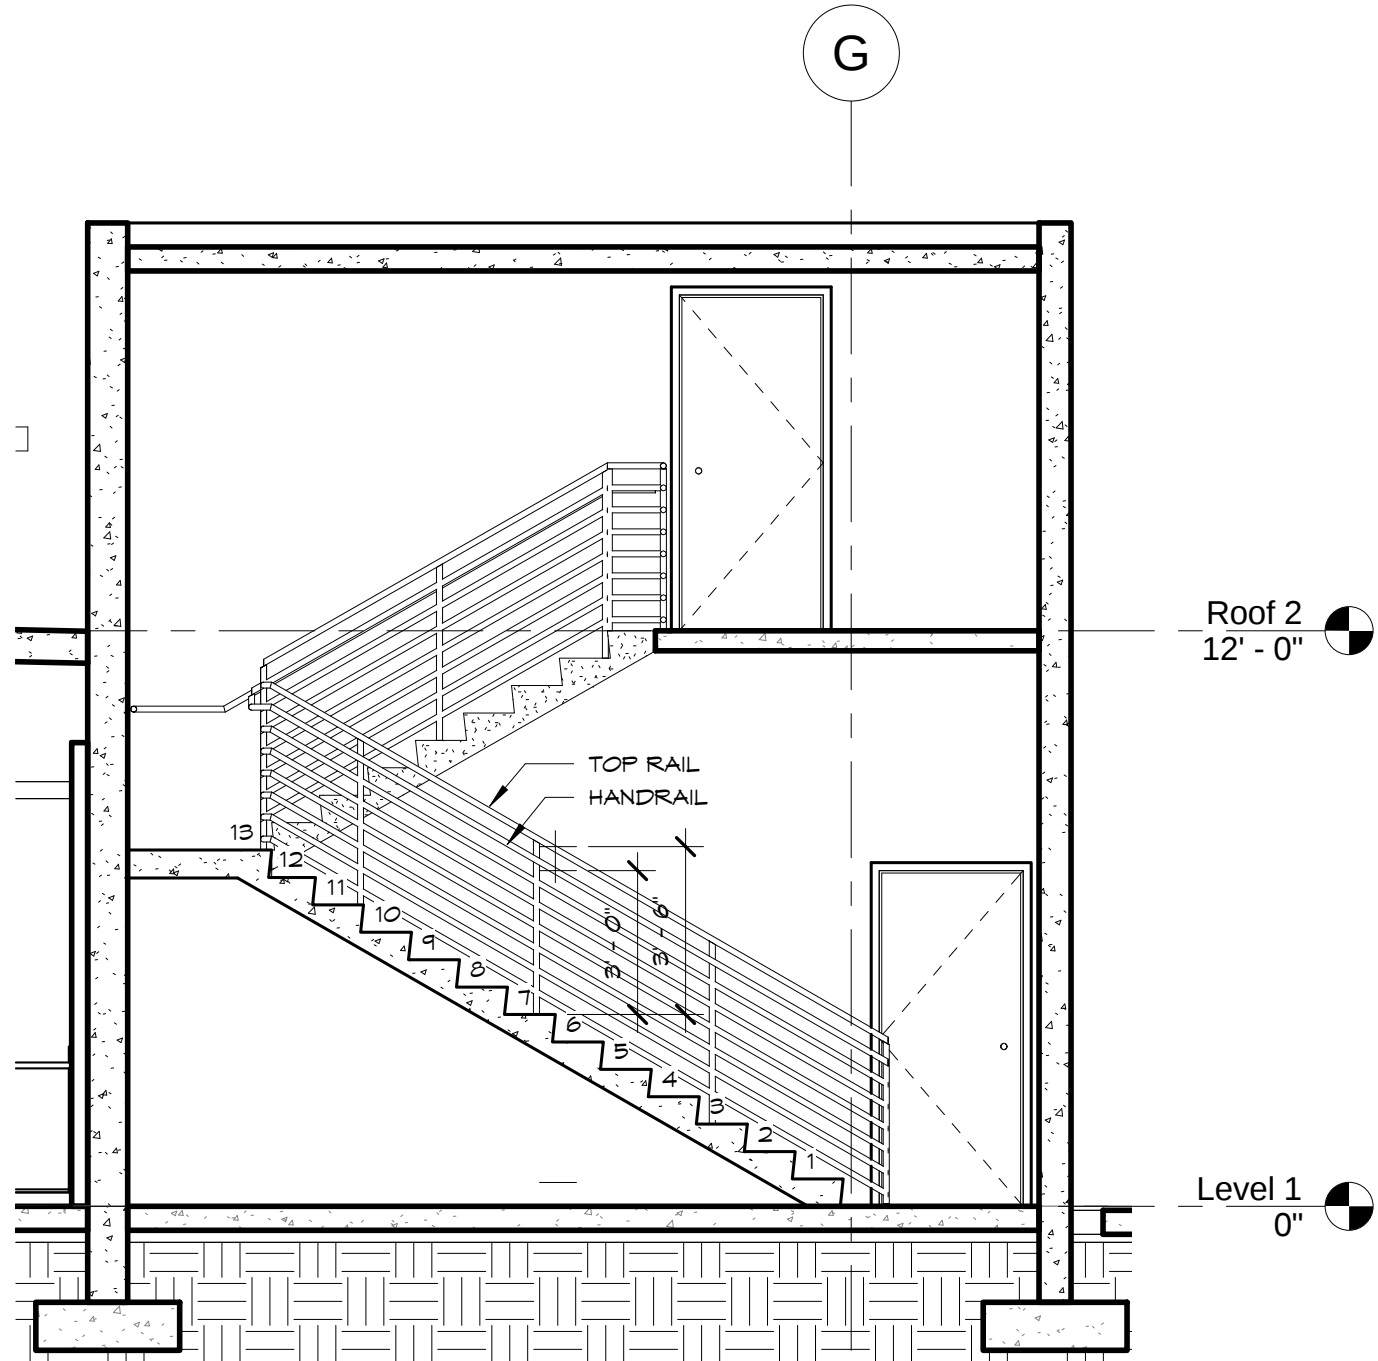

6 STAIR # 2 SECTION A
SCALE: 1/4" = 1'-0"

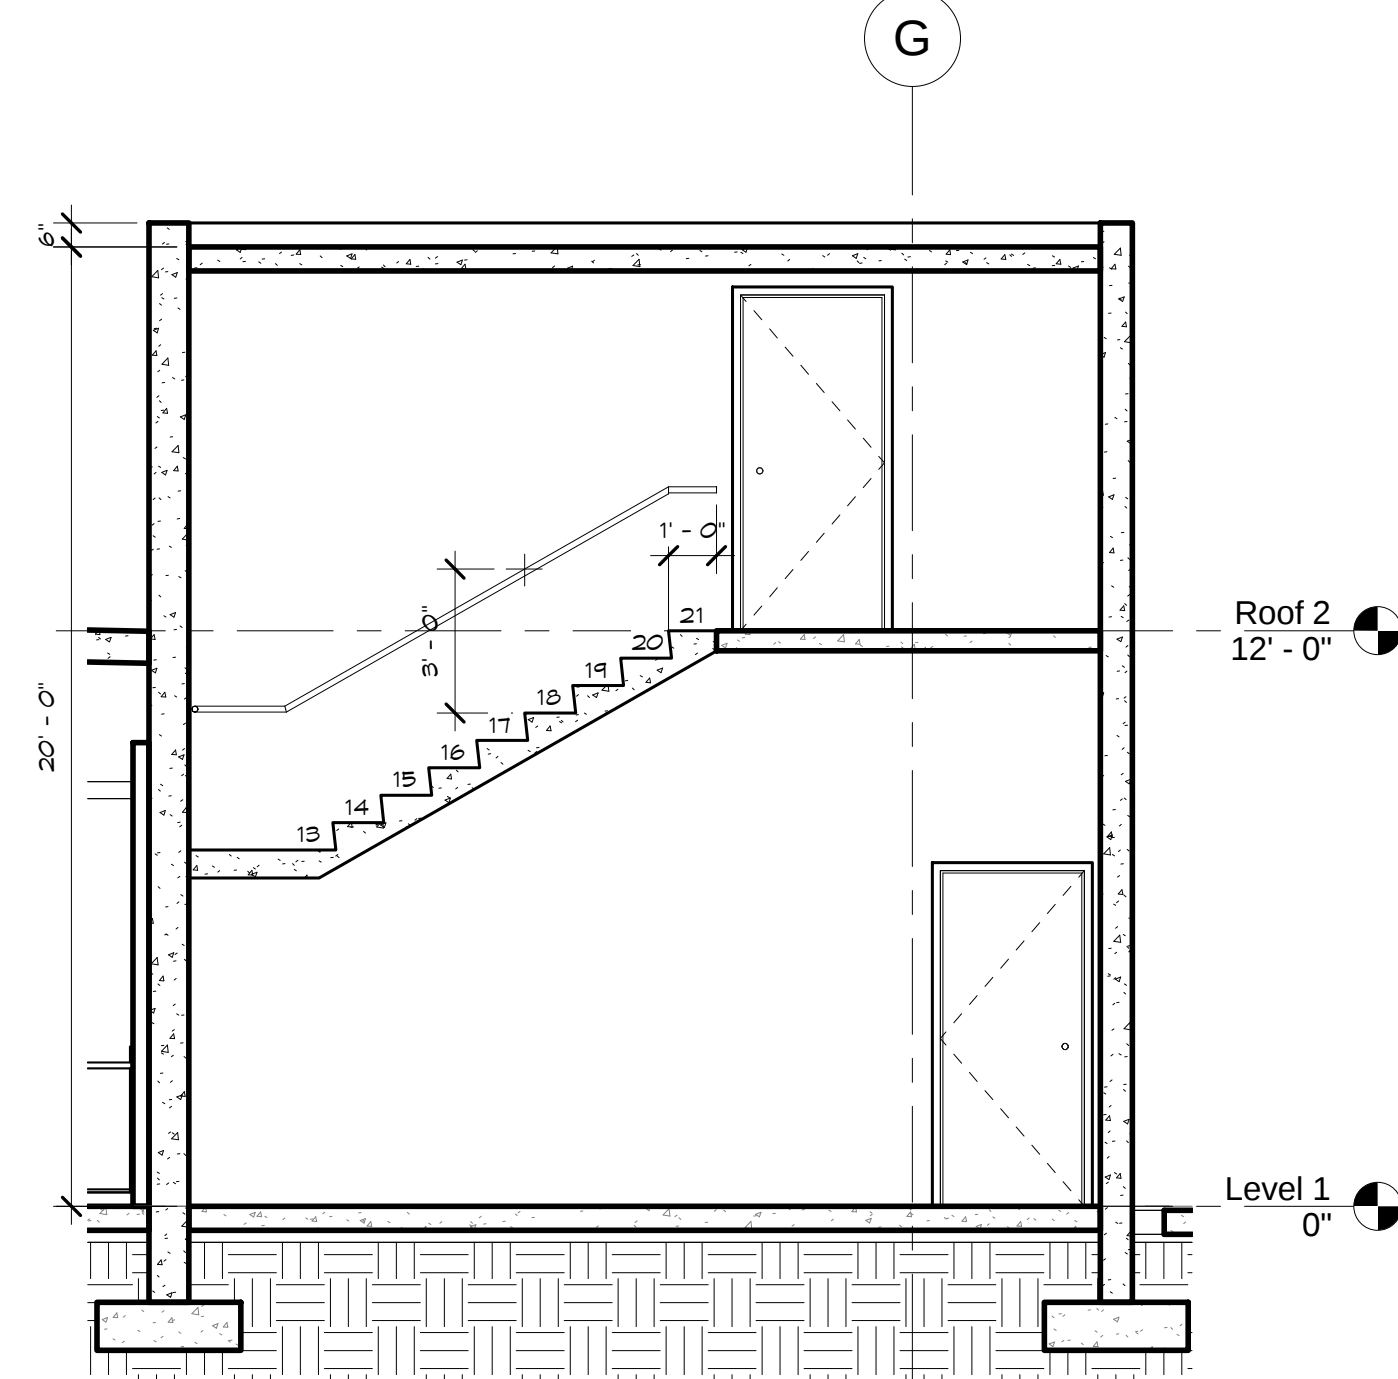


7 STAIR # 2 SECTION B
SCALE: 1/4" = 1'-0"

REVISIONS		
No.	Description	Date

TRMA
Taniguchi Ruth Makio Architects
100 Cliff Business Center, P.O. Box EA, Agaña, GU 96910
Tel.: (671) 475-8772 • Fax: (671) 472-3381

Architecture
Planning
Interior Design

BID
DOCUMENTS

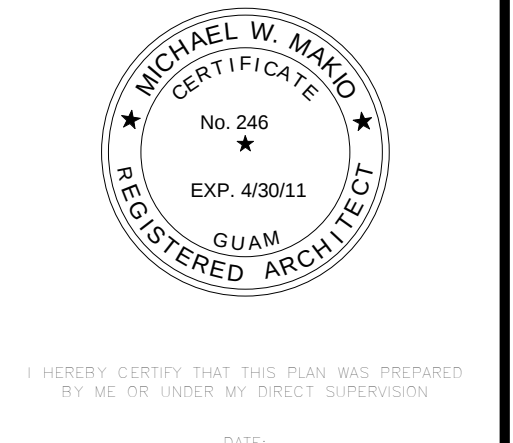






Project:
GUAM COMMUNITY
COLLEGE
FORENSIC DNA LAB

Title:
STAIR PLANS AND
SECTIONS

Designed: TRMA
Drawn: RM/TP
Checked: CTC
Supv: MM
Scale: 1/4" = 1'-0"
Date: 12/17/12
Project No. 1026
Drawing No.

A7.1
Sheet No. of

 IF SHEET IS LESS THAN 24" X 36"
REDUCED PRINT - USE GRAPHIC SCALES

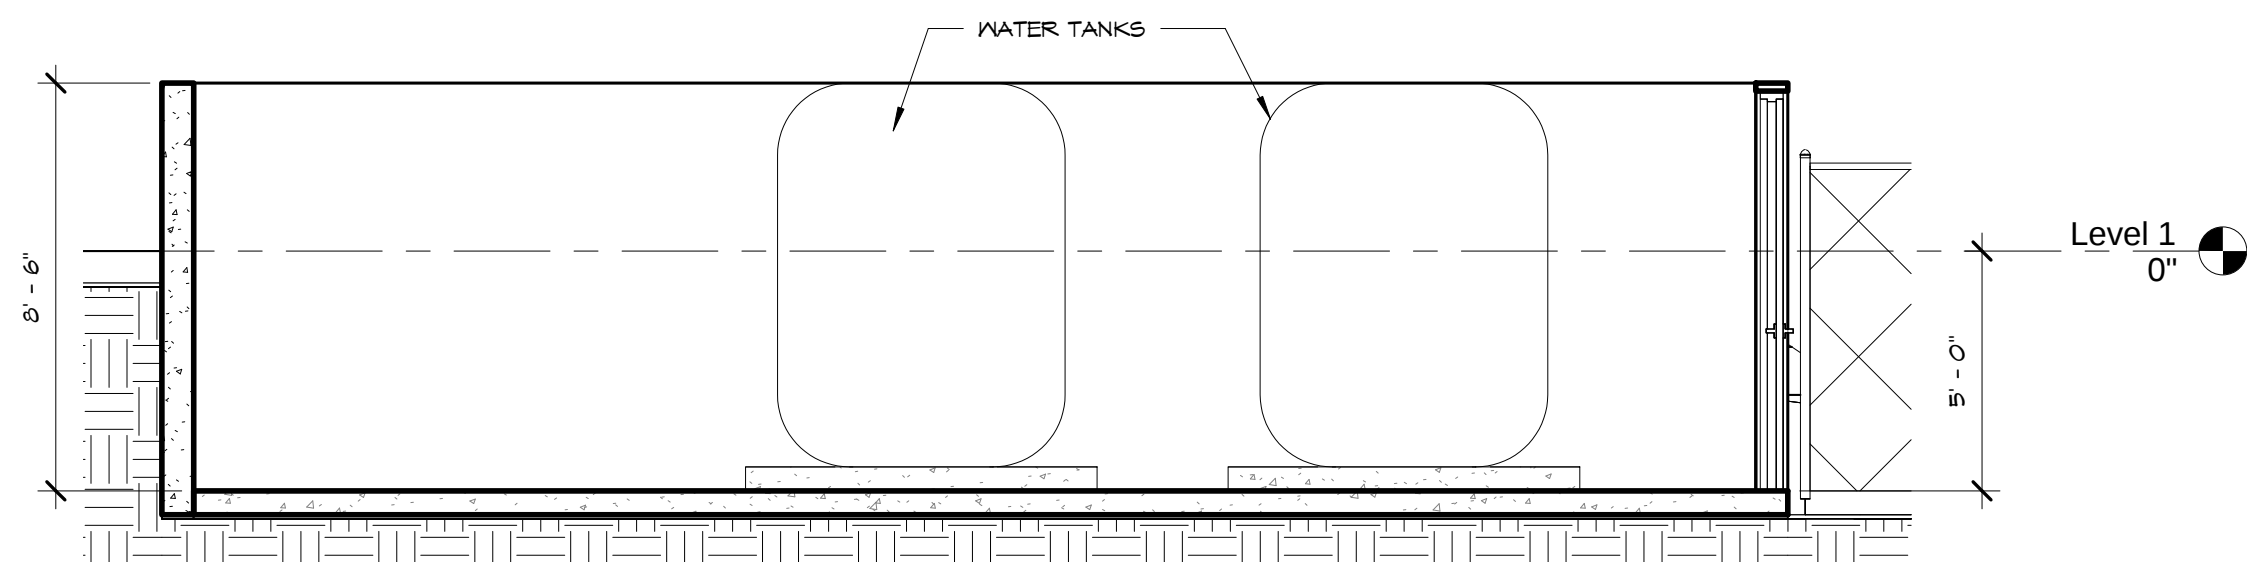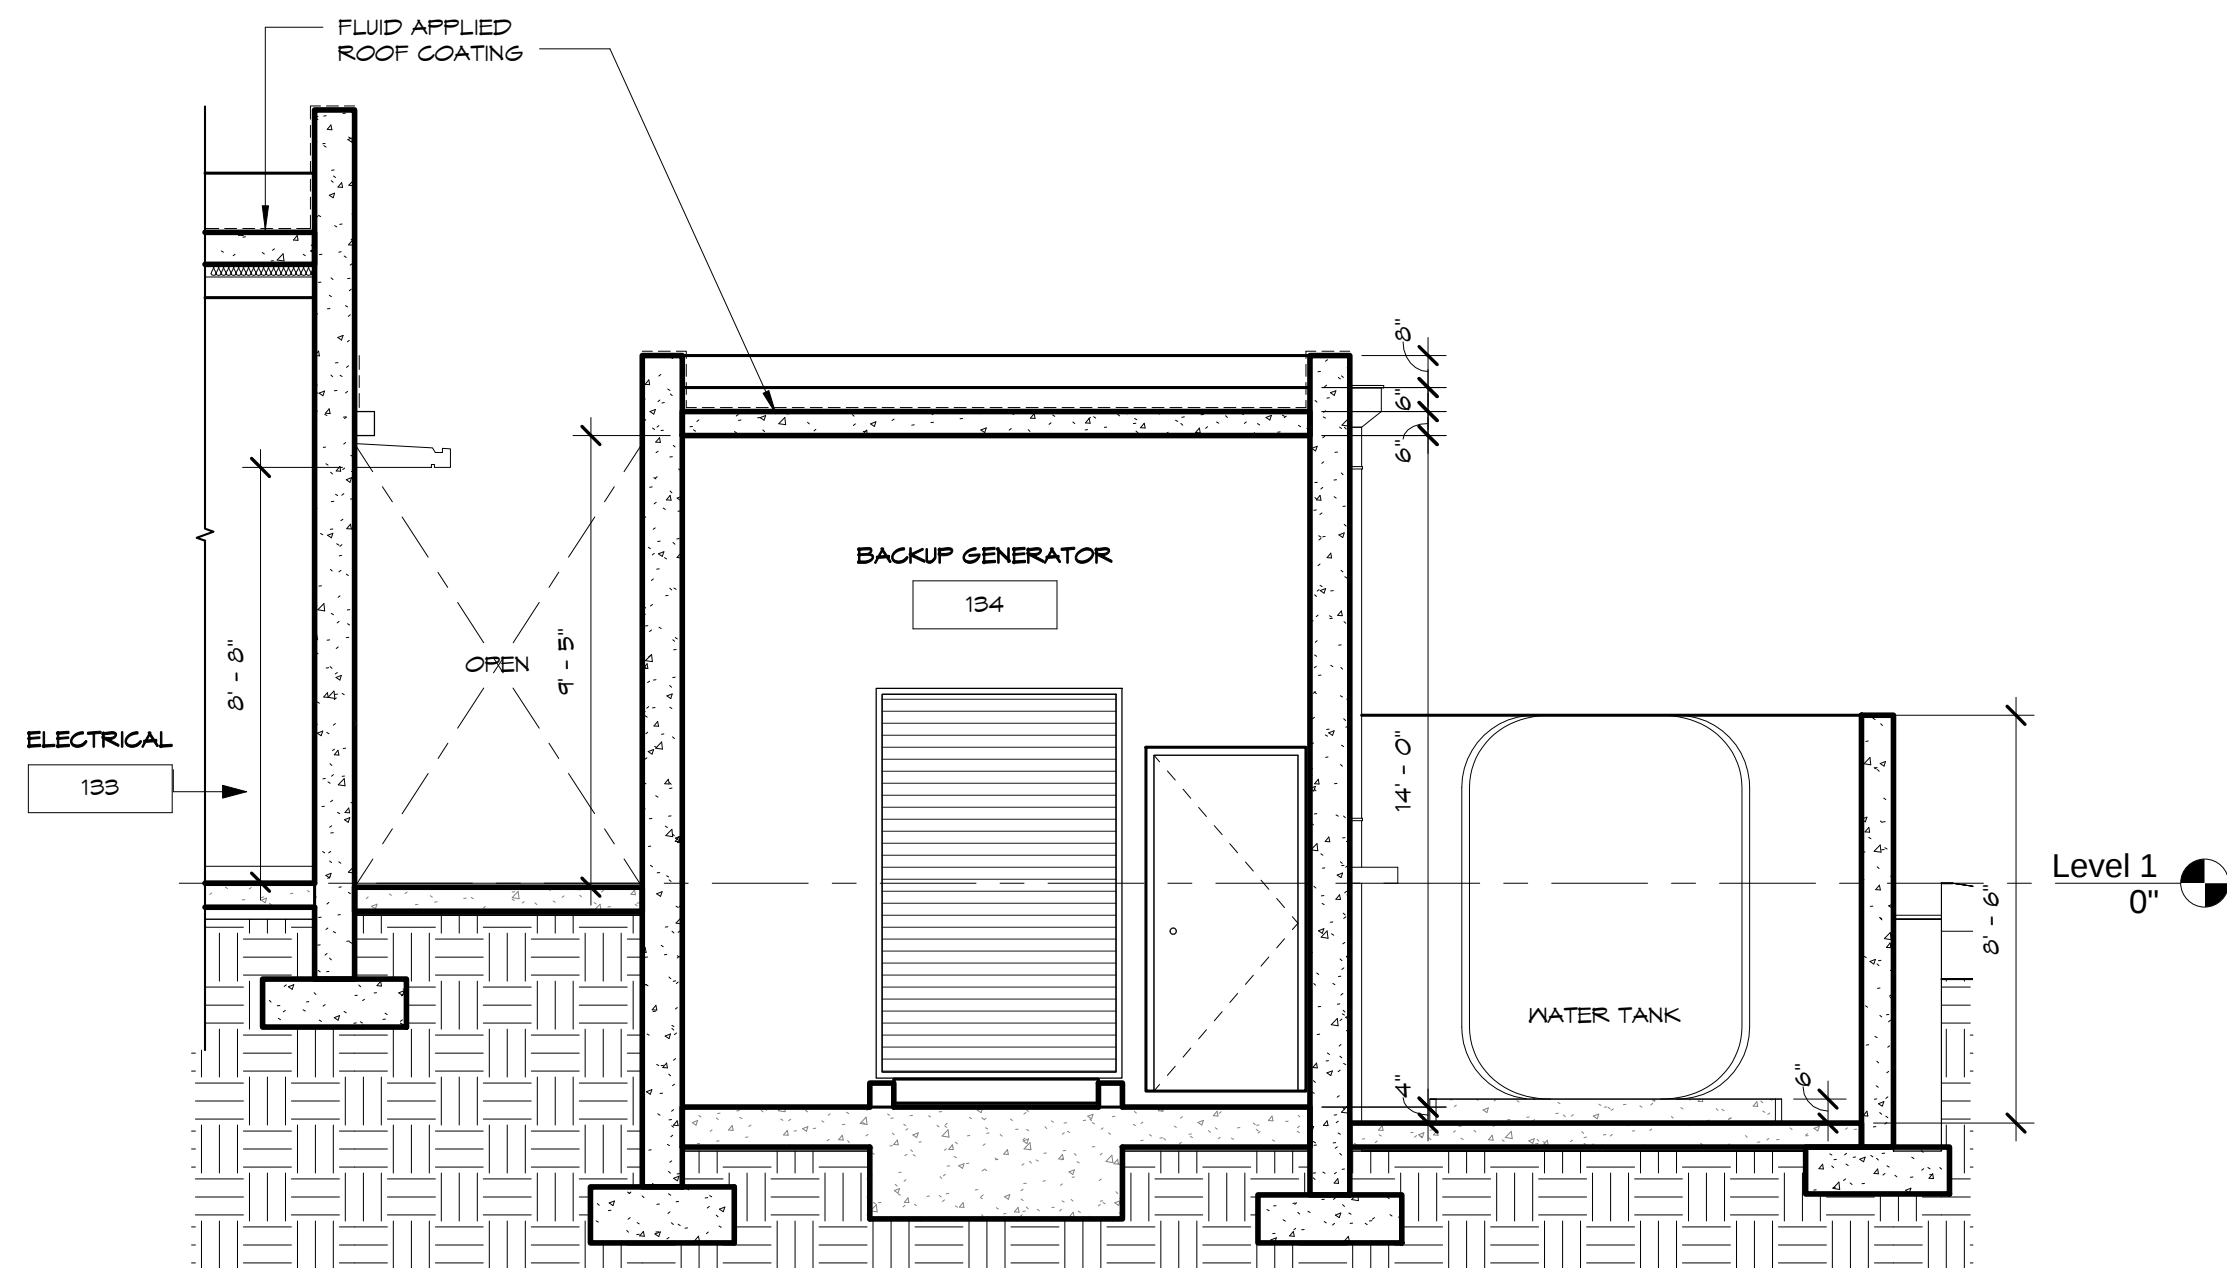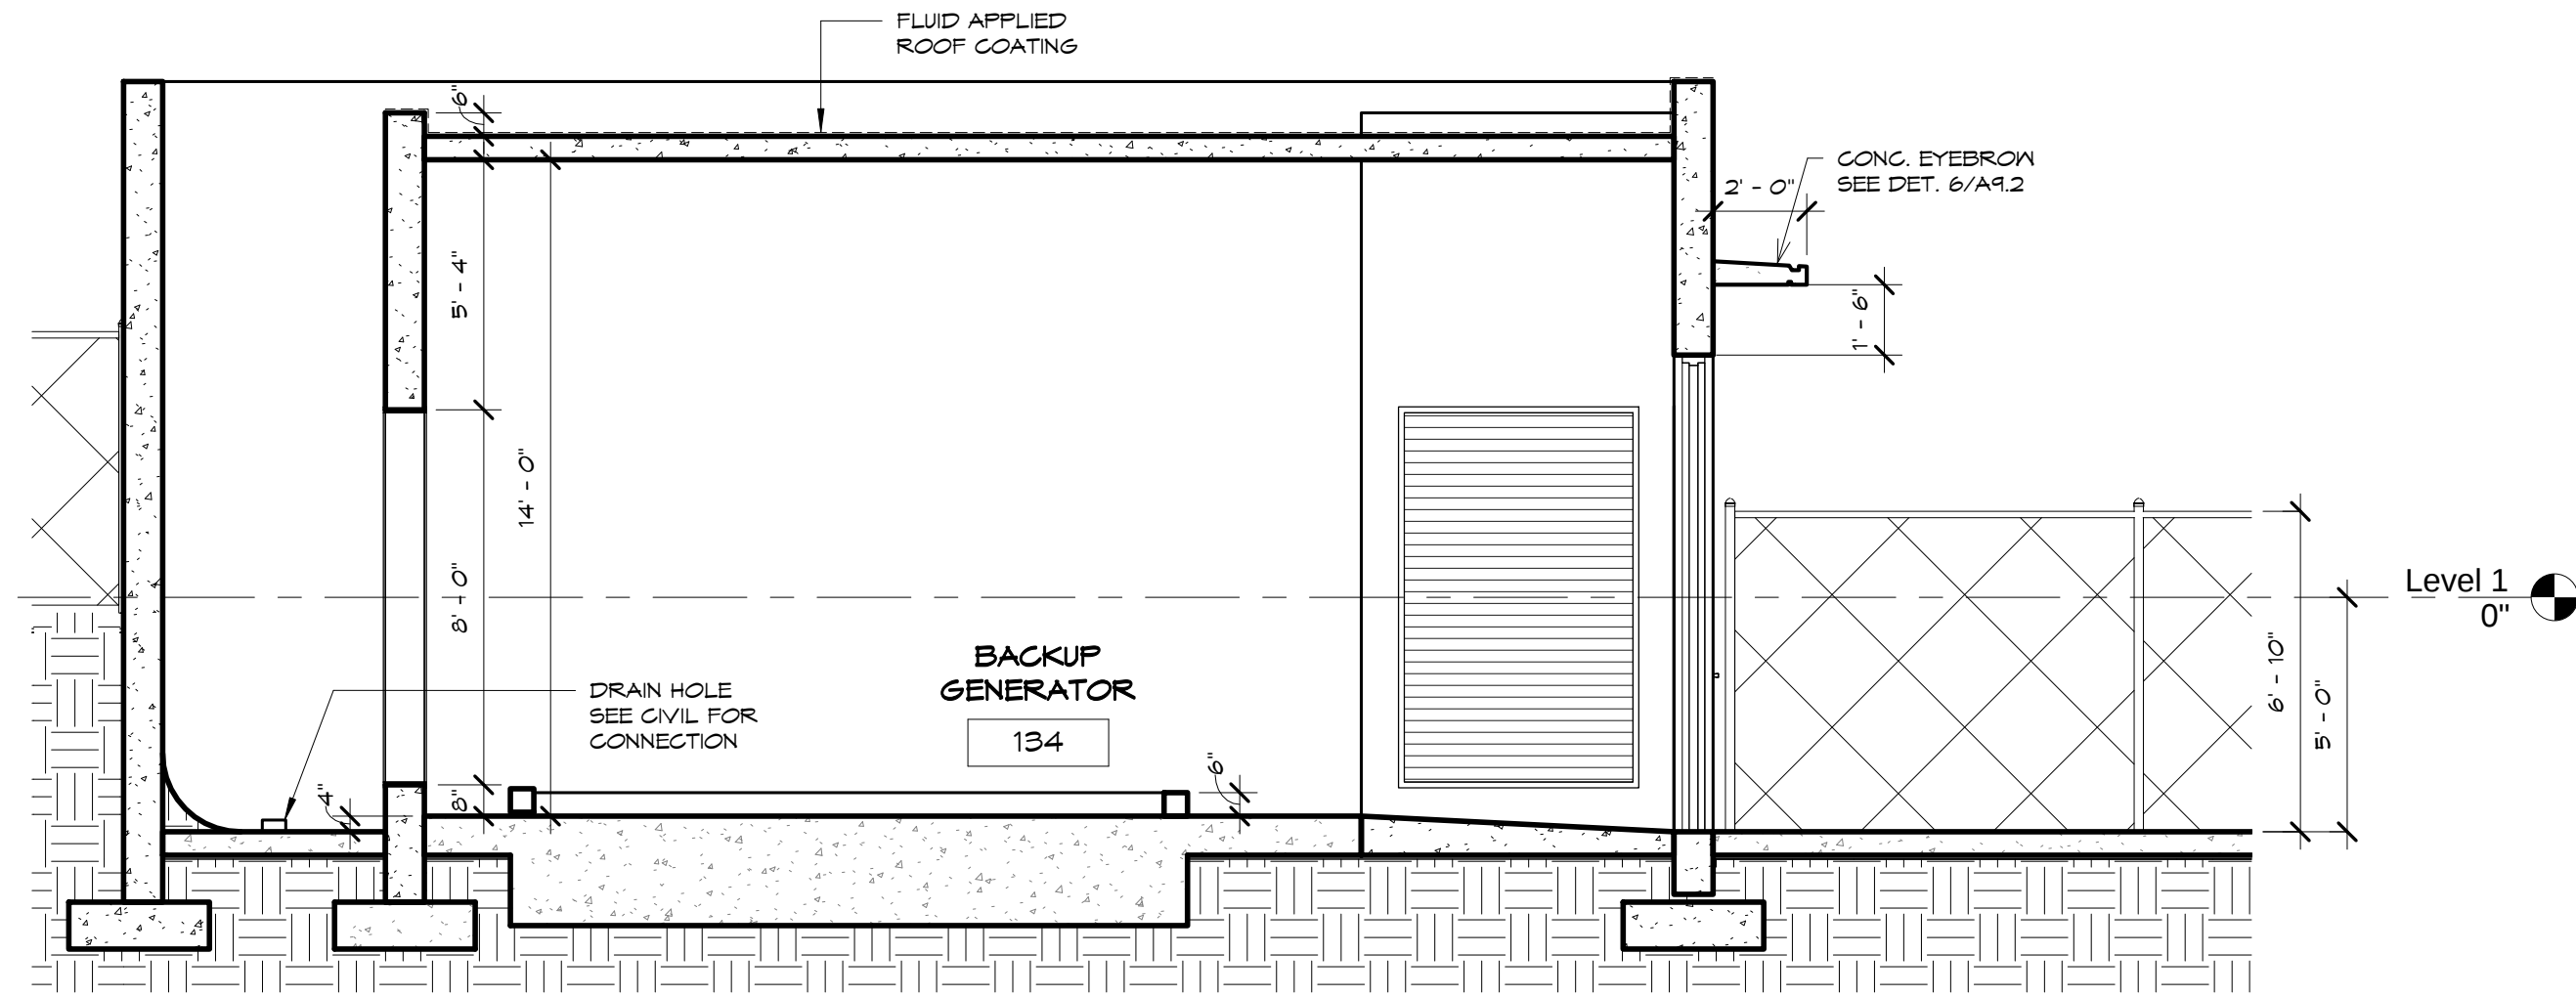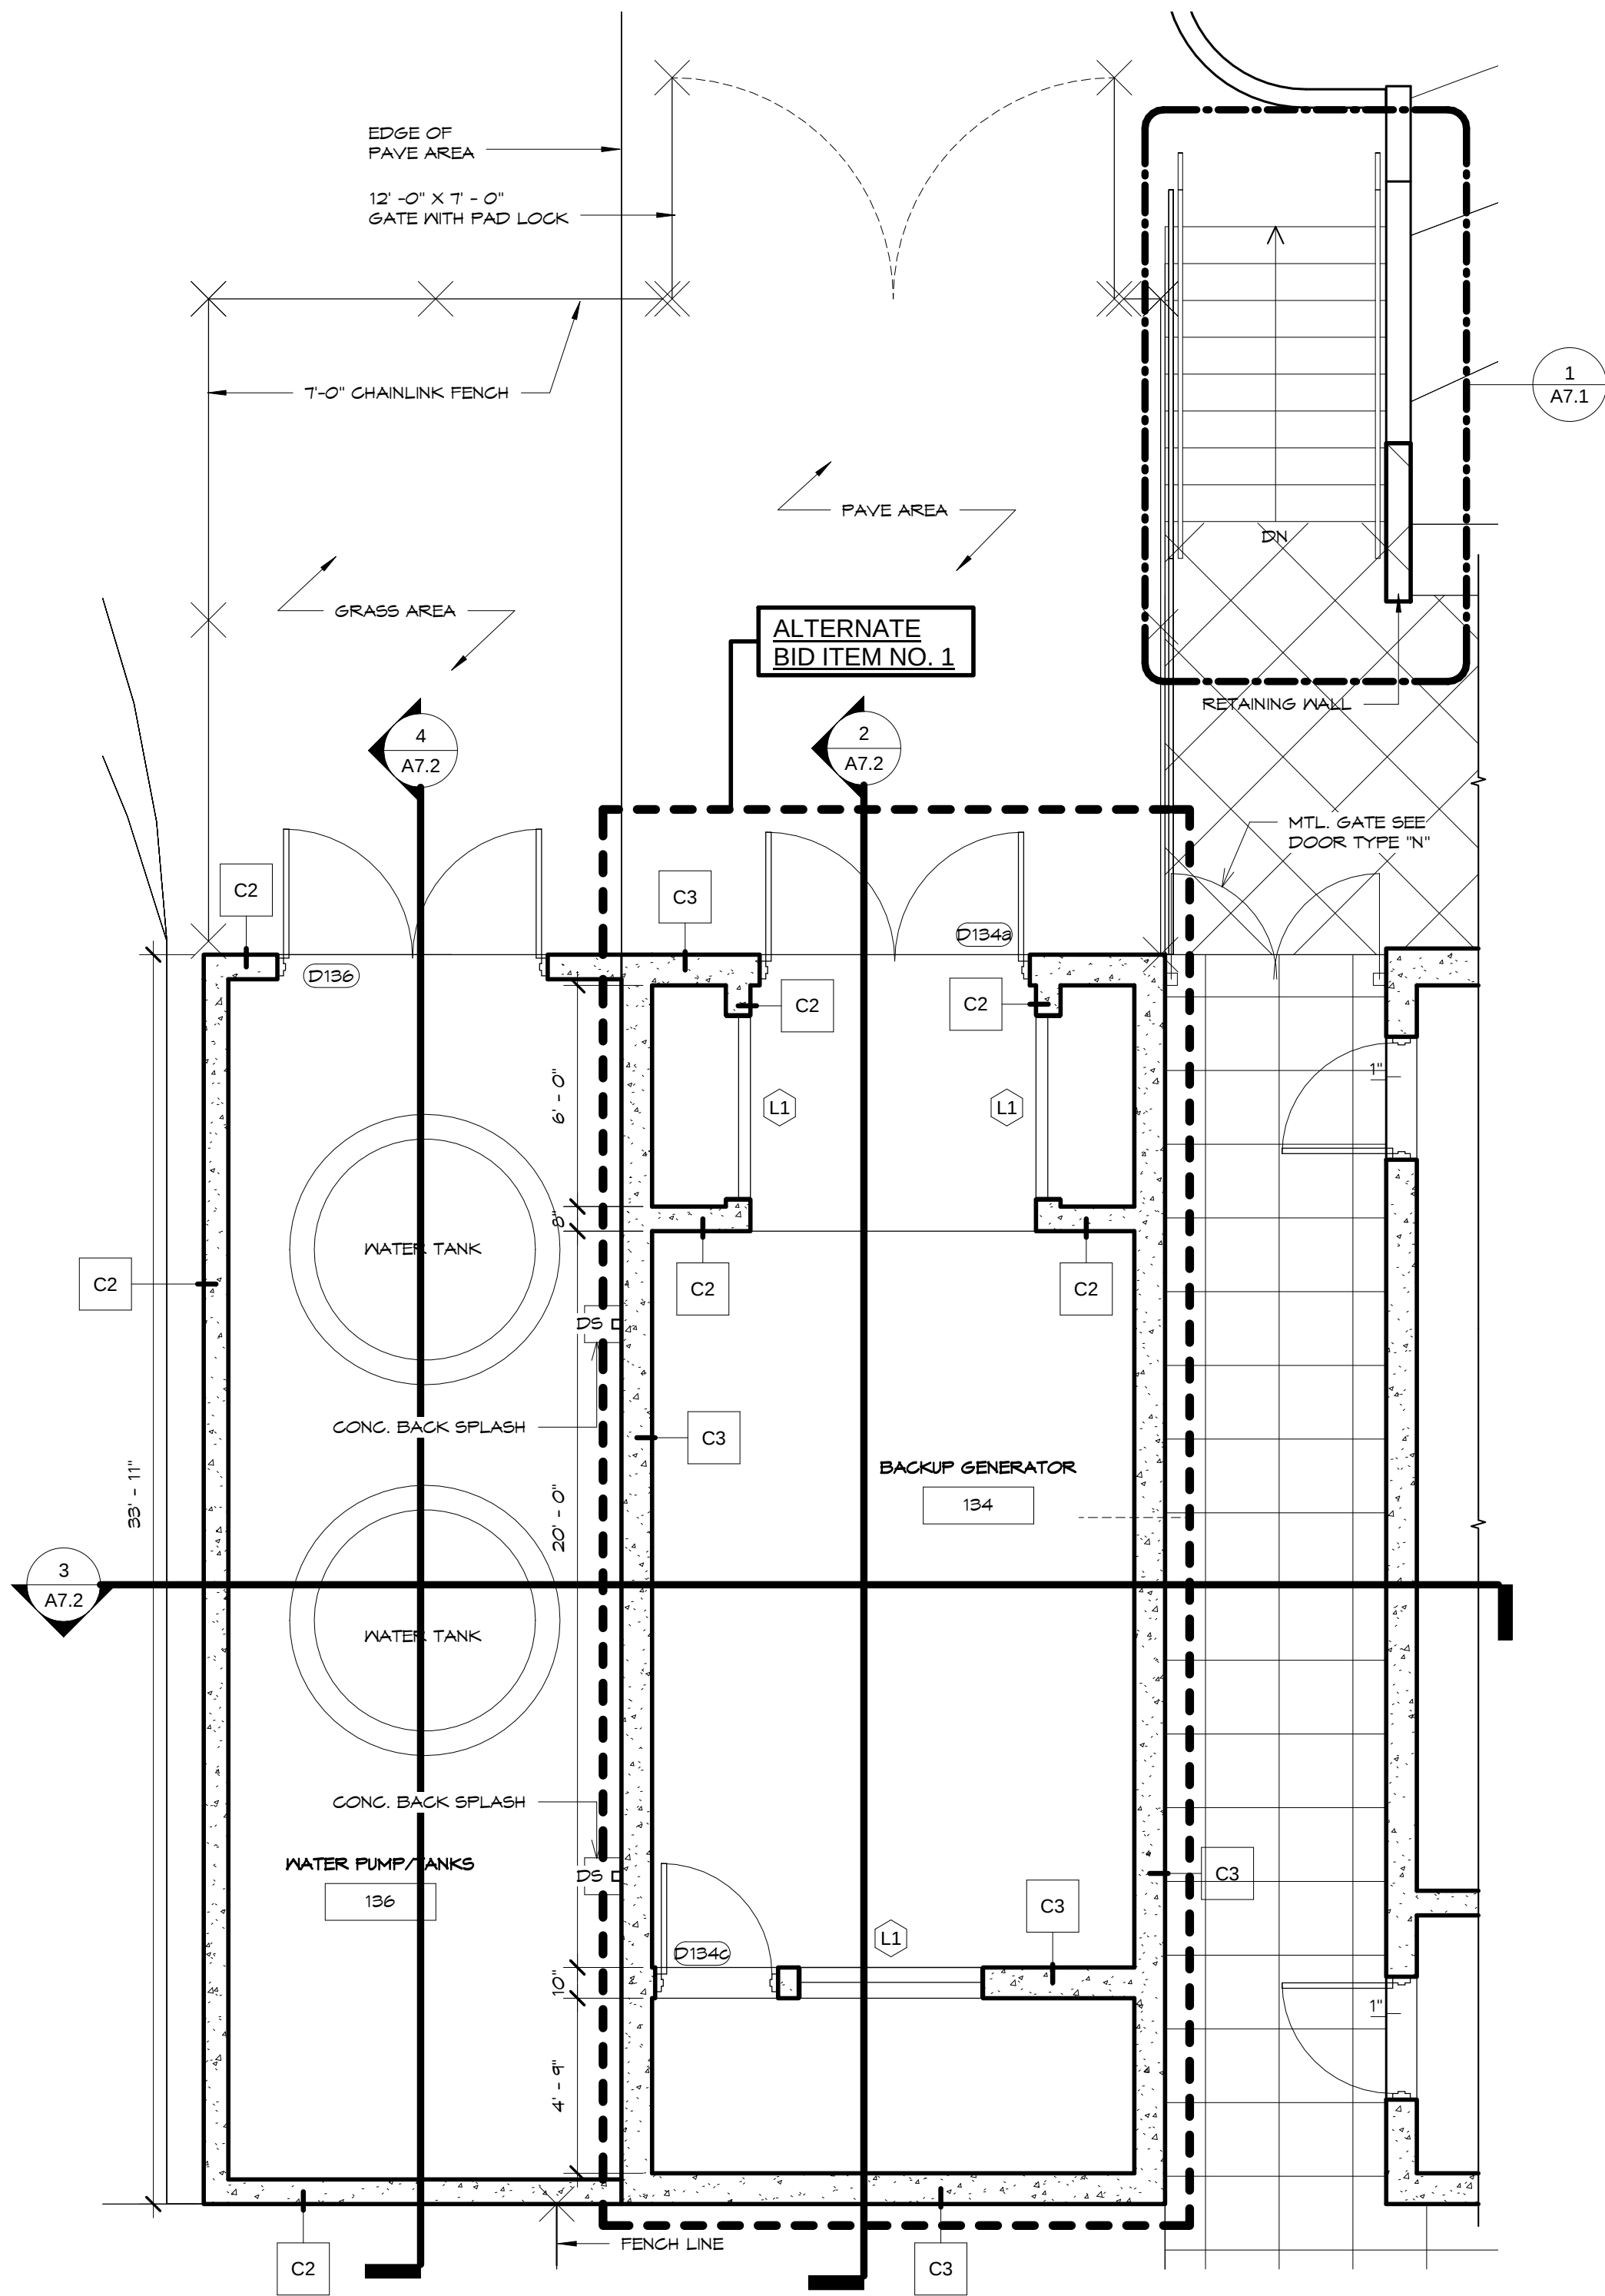


IF SHEET IS LESS THAN 24" X 36"
REDUCED PRINT - USE GRAPHIC SCALES

REVISIONS		
No.	Description	Date

TRMA
Taniguchi Ruth Makio Architects
100 Cliff Business Center, P.O. Box EA, Agaña, GU 96910
Tel.: (671) 475-8772 • Fax: (671) 472-3381

Architecture
Planning
Interior Design

BID
DOCUMENTS

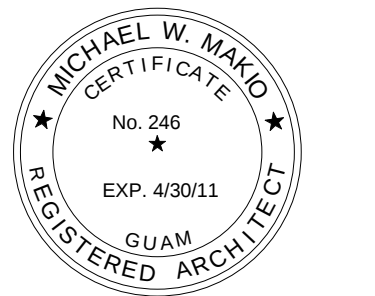


Project:
GUAM COMMUNITY
COLLEGE
FORENSIC DNA LAB

Title:
GENERATOR RM. PLAN


Designed: TRMA
Drawn: RM/TP
Checked: CTC
Supv: MM
Scale: 1/4" = 1'-0"
Date: 12/17/12
Project No. 1026
Drawing No.

A7.2


Sheet No. of

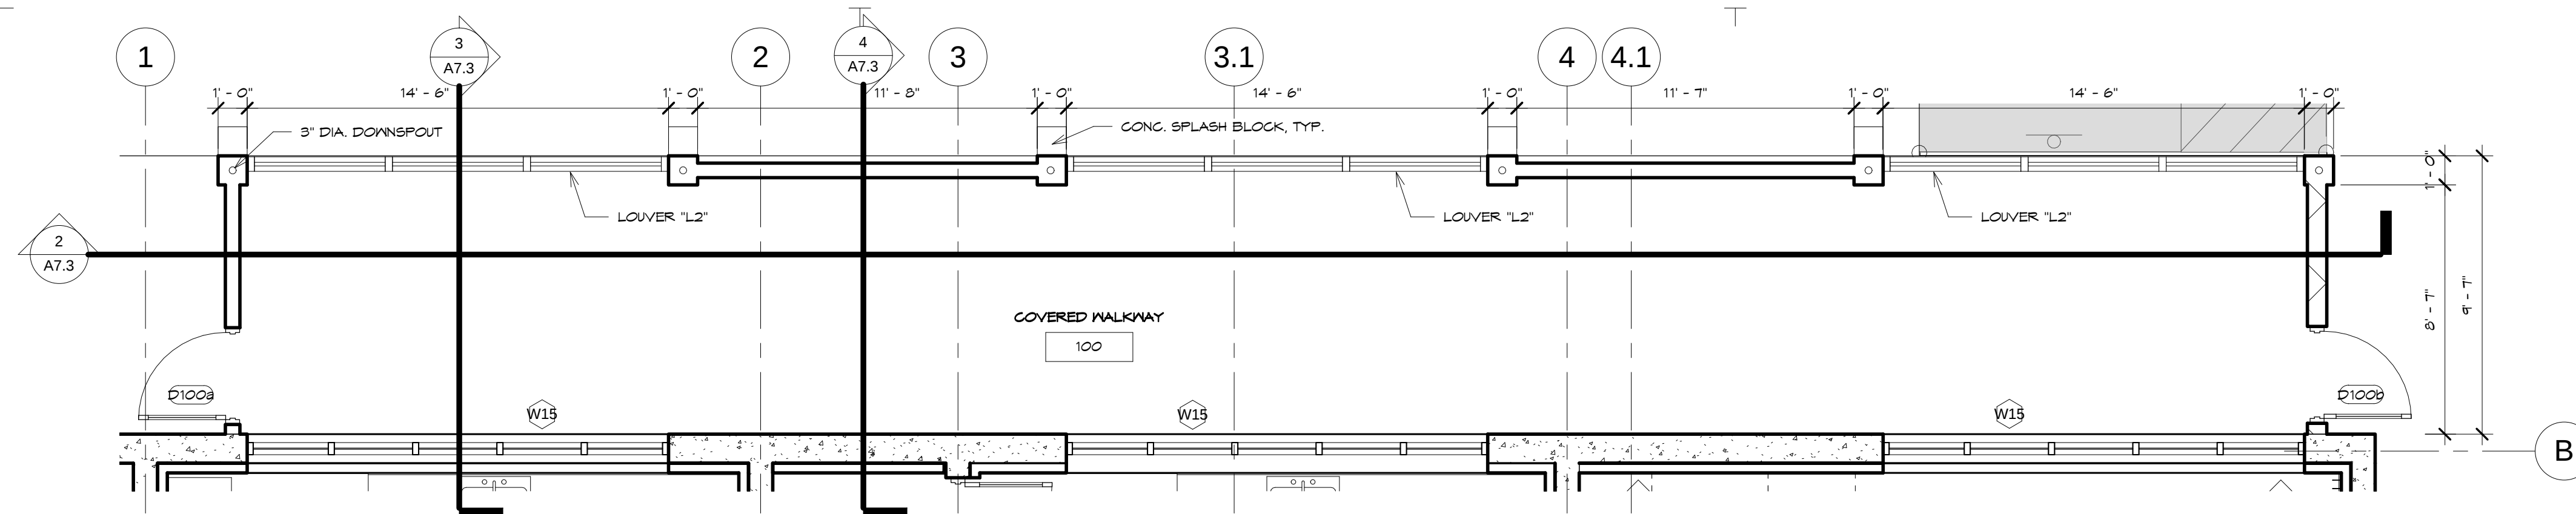


1 COVERED WALKWAY PLAN
SCALE: 1/4" = 1'-0"

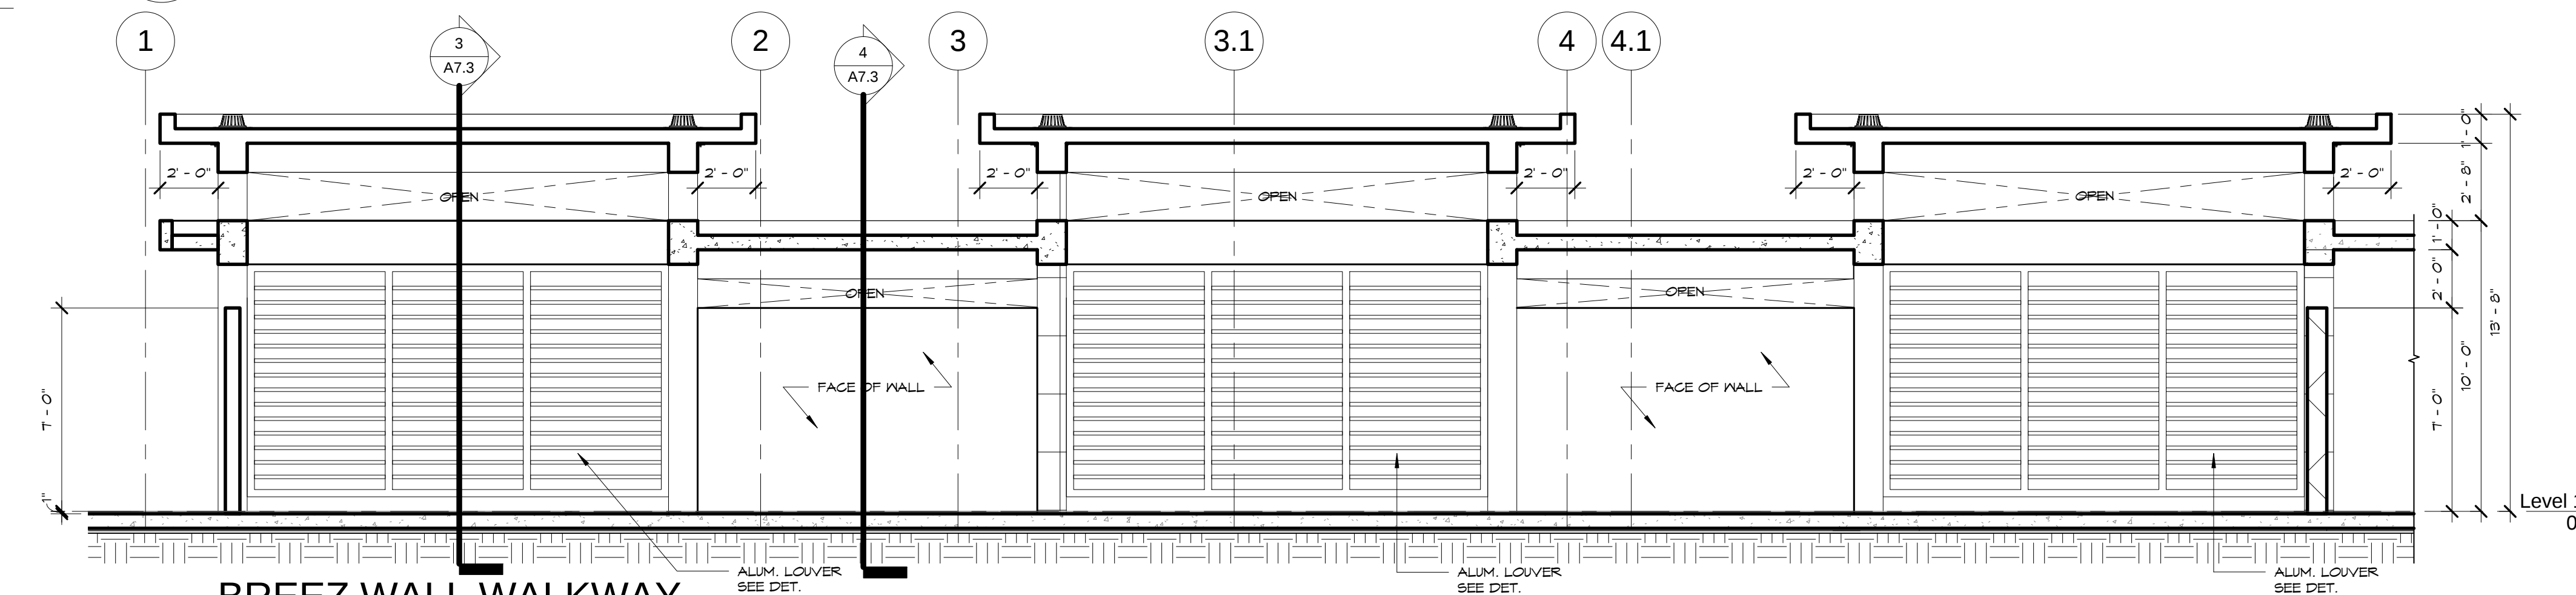


2 BREEZ WALL WALKWAY SECTION
SCALE: 1/4" = 1'-0"

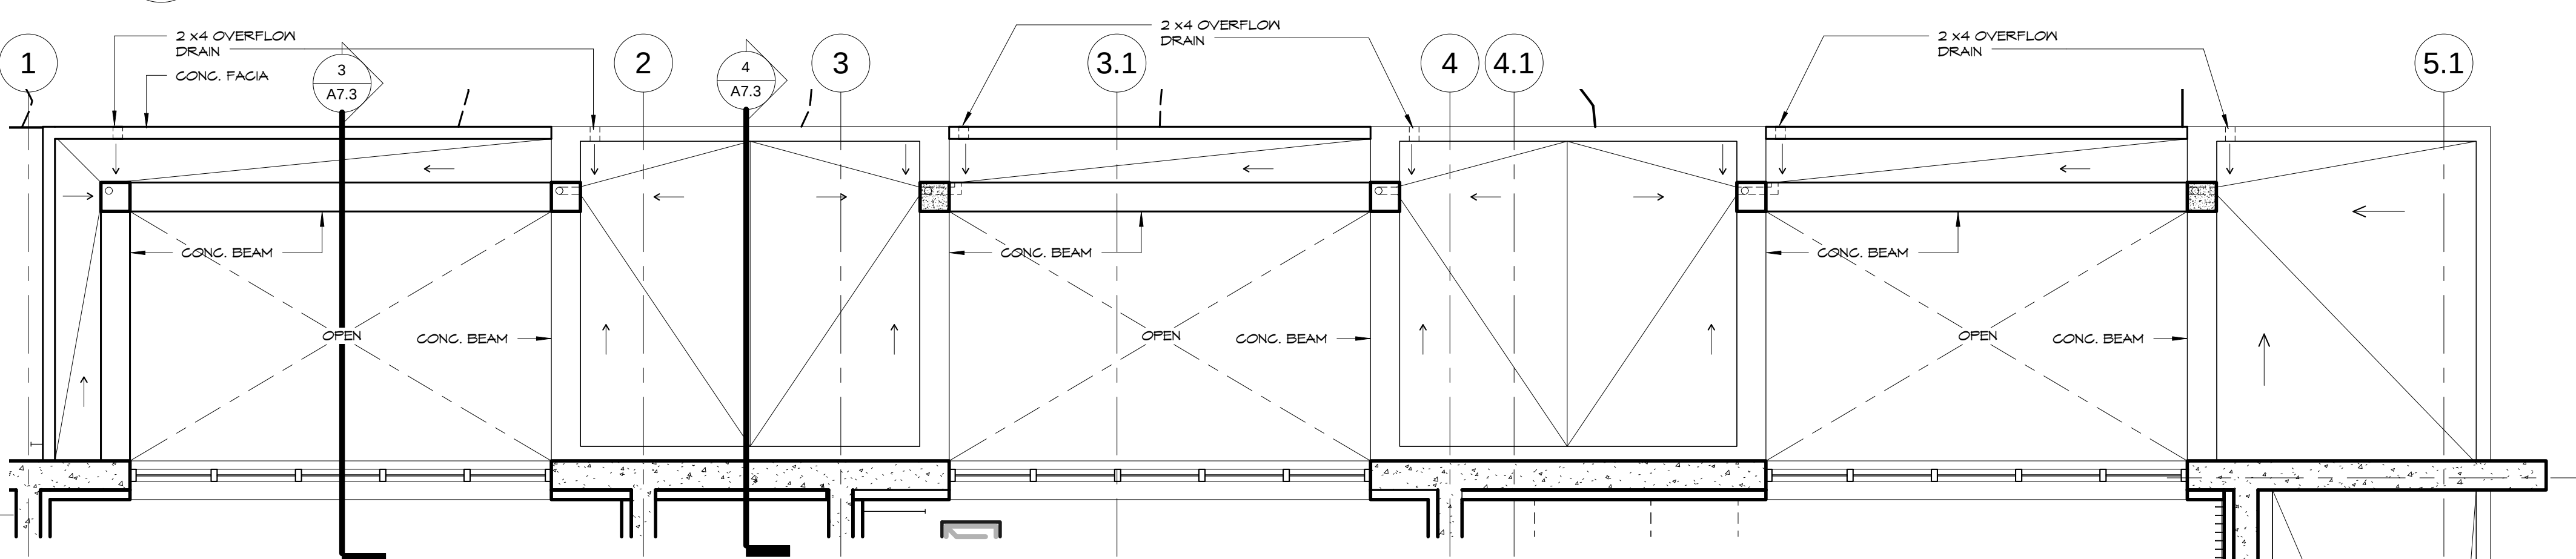

5 COVERED WALKWAY LOWER ROOF PLAN
SCALE: 1/4" = 1'-0"

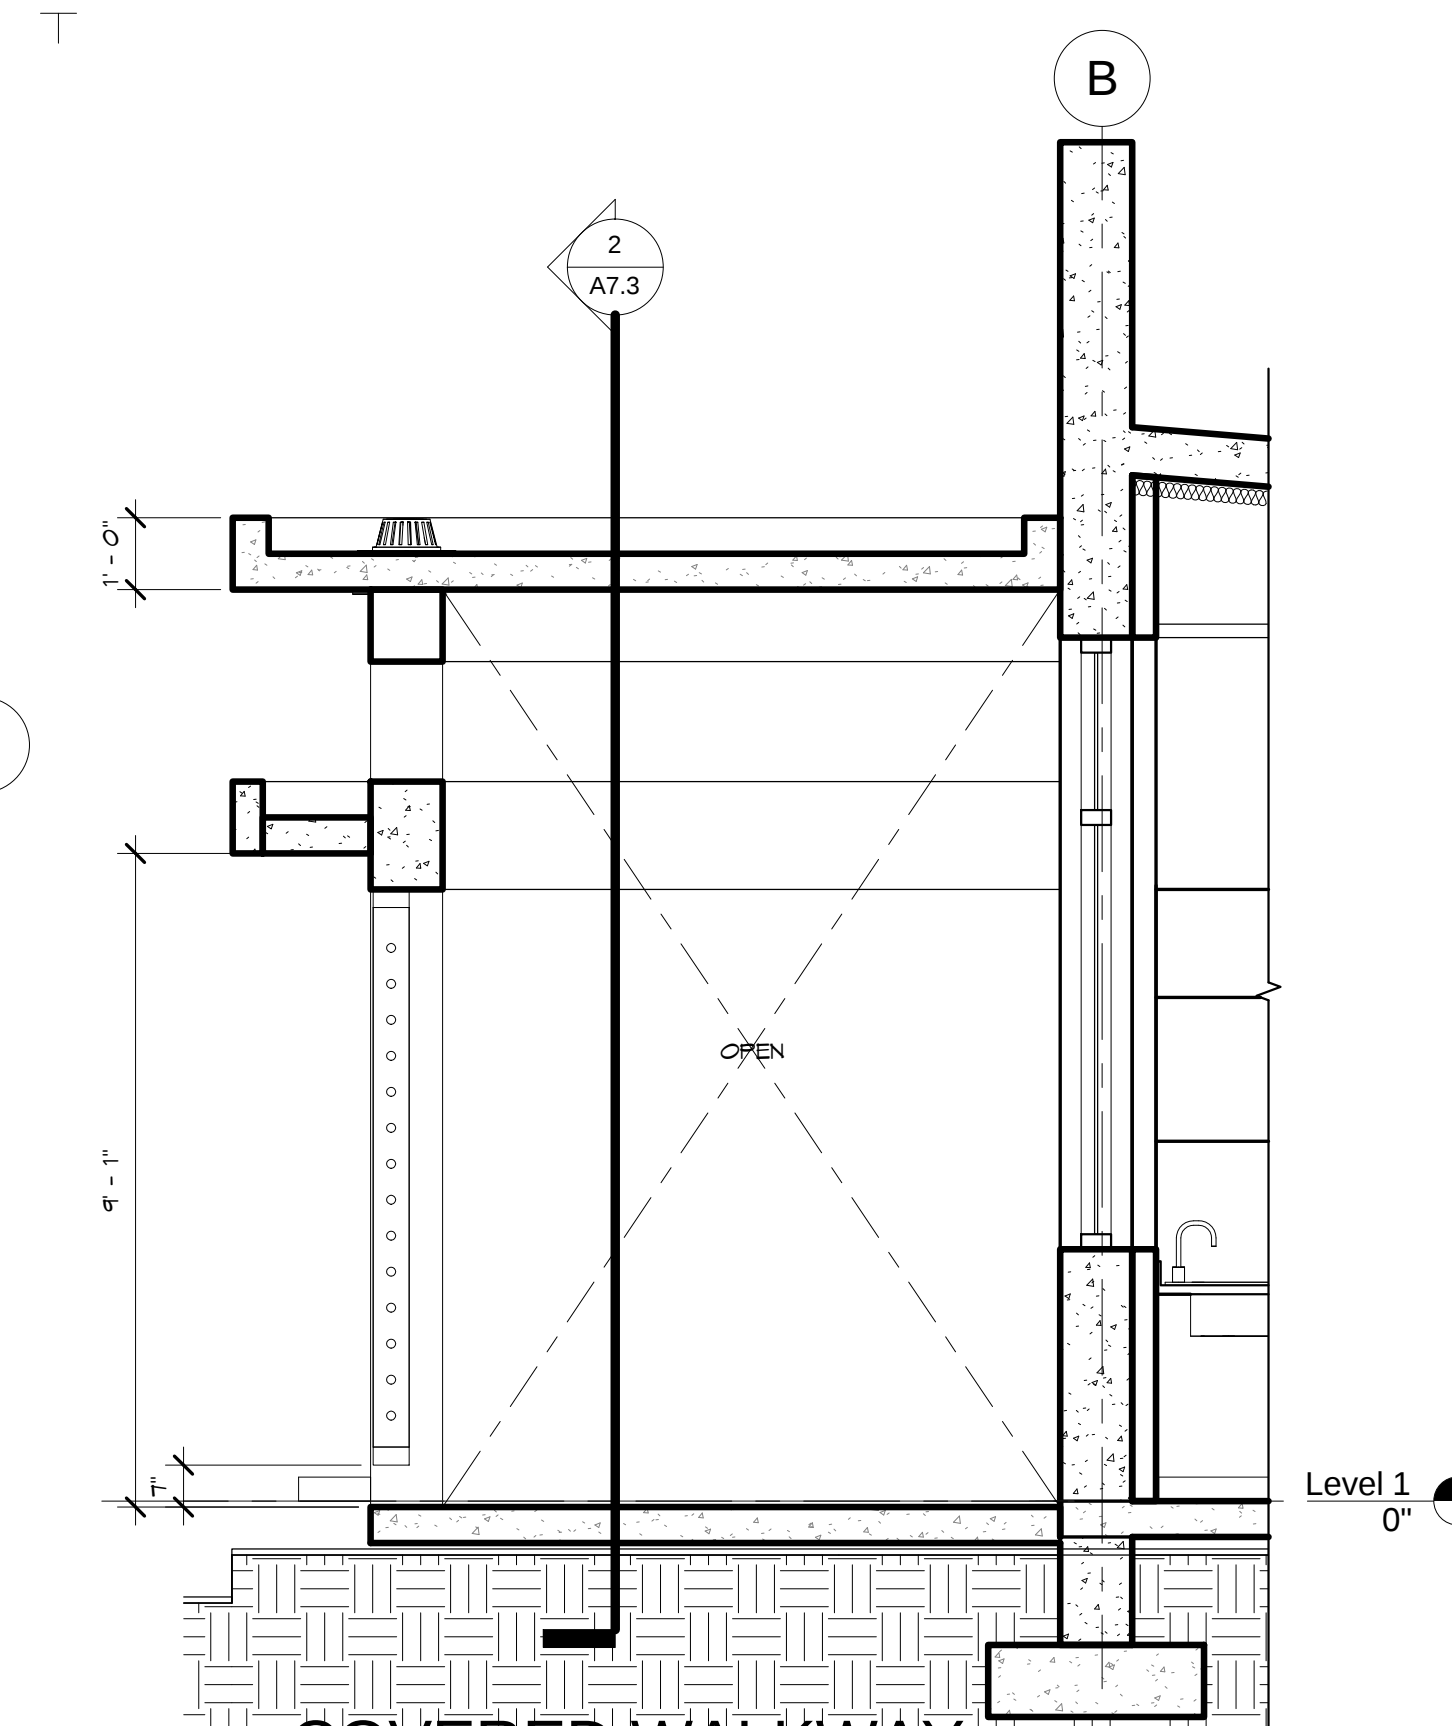

3 COVERED WALKWAY SECTION 1
SCALE: 3/8" = 1'-0"

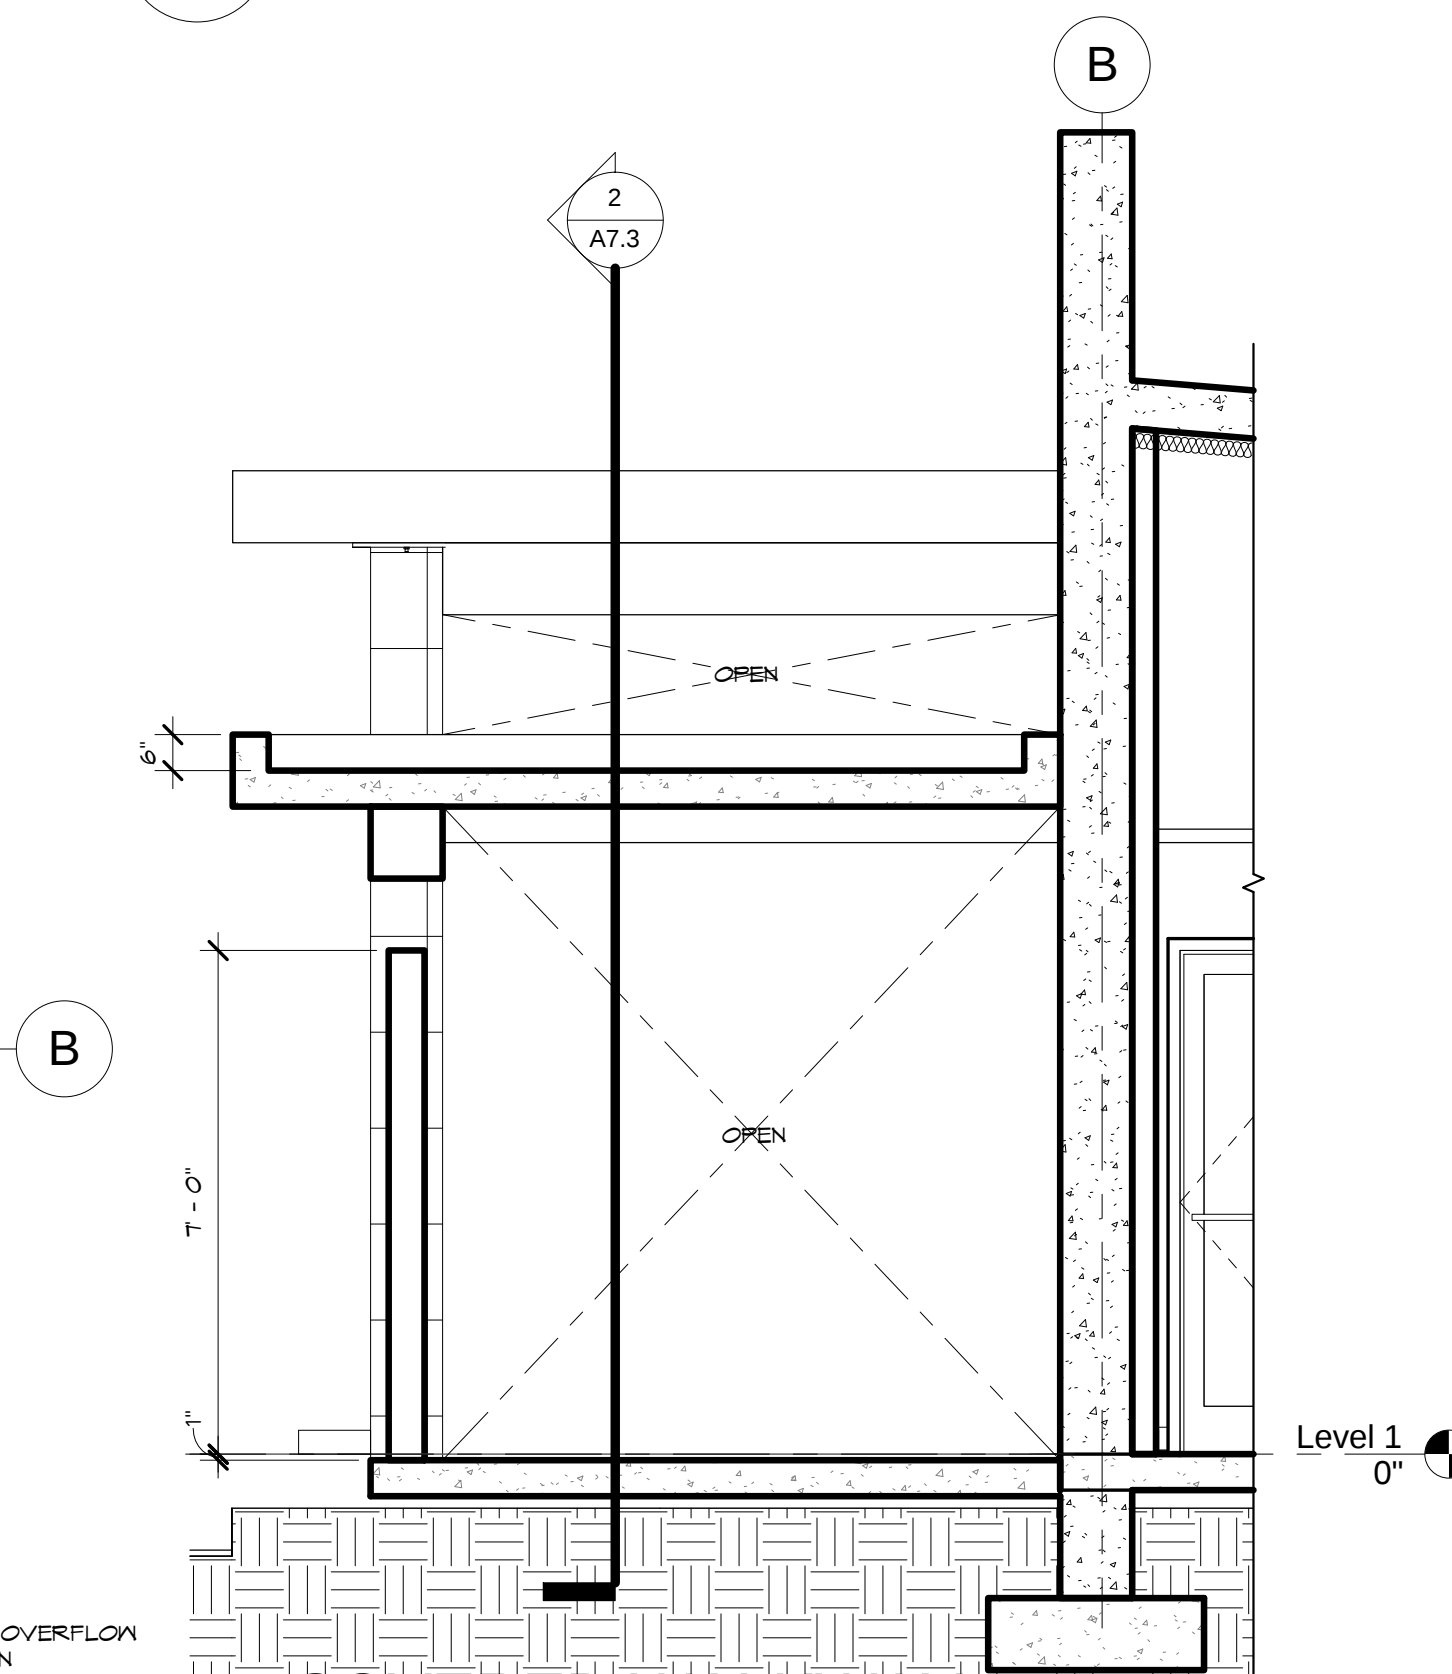

4 COVERED WALKWAY SECTION 2
SCALE: 3/8" = 1'-0"

REVISIONS		
No.	Description	Date

TRMA
Taniguchi Ruth Makio Architects
100 Cliff Business Center, P.O. Box EA, Agaña, GU 96910
Tel.: (671) 475-8772 • Fax: (671) 472-3381

Architecture
Planning
Interior Design

BID DOCUMENTS

REGISTERED ARCHITECT
MICHAEL W. MAKIO
No. 246
EXP. 4/30/11
GUAM

I HEREBY CERTIFY THAT THIS PLAN WAS PREPARED BY ME OR UNDER MY DIRECT SUPERVISION
DATE: _____

Project:
GUAM COMMUNITY COLLEGE
FORENSIC DNA LAB

Title:
COVERED WALKWAY

Designed: TRMA
Drawn: RM/TP
Checked: CTC
Supv: MAM
Scale: As indicated
Date: 12/17/12
Project No. 1026
Drawing No.

A7.3
Sheet No. of

ROOM FINISH SCHEDULE																			
RMNO	LOCATION	FLOOR		WAINSCOT		WALLS								CEILING		CASEWORK		REMARKS	
		FIN	BASE	FIN	HT	A		B		C		D		FIN	HT	BASE	TOP		
						MAT'L	FIN	MAT'L	FIN	MAT'L	FIN	MAT'L	FIN						
100	COVERED WALKWAY	GT	-	-	-	CONC	PT	CONC	PT	CONC	PT	CONC	PT	PT		-	-		
100b	COVERED WALKWAY	GT	-	-	-	-	-	-	-	-	-	-	-	-		-	-		
100c	OUTDOOR CORRIDOR	GT	-	-	-	-	-	-	-	-	-	-	-	-		-	-		
101	GCC CLASSROOM	VGT	RB	-	-	CONC	PT	CONC	PT	CONC	PT	CONC	PT	ACT	11' - 6"	-	-		
102	GCC CLASSROOM	VGT	RB	-	-	CONC	PT	CONC	PT	CONC	PT	CONC	PT	ACT	11' - 6"	-	-		
103	GCC OFFICE	VGT	RB	-	-	CONC	PT	CONC	PT	CONC	PT	CONC	PT	ACT	8' - 0"	-	-		
104	GCC OFFICE	VGT	RB	-	-	CONC	PT	CONC	PT	CONC	PT	CONC	PT	ACT	8' - 0"	-	-		
104b	SERVER	VGT	RB	-	-	CONC	PT	CONC	PT	CONC	PT	CONC	PT	ACT	8' - 0"	-	-		
105	MEN	GT	GT	-	-	CONC	GT	CONC	GT	CONC	GT	CONC	GT	PT	8' - 0"	-	-		
106	WOMEN	GT	GT	-	-	CONC	GT	CONC	GT	CONC	GT	CONC	GT	PT	8' - 0"	-	-		
107	SECURE ENTRY	VGT	RB	-	-	CONC	PT	CONC	PT	CONC	PT	CONC	PT	PT	8' - 6"	-	-		
108	COR	VGT	RB	-	-	CONC	PT	CONC	PT	CONC	PT	GWB	PT	PT	8' - 6"	-	-		
109	ADMIN	VGT	RB	-	-	CONC	PT	CONC	PT	CONC	PT	CONC	PT	ACT	9' - 6"	-	-		
109a	OFFICE	VGT	RB	-	-	CONC	PT	GWB	PT	GWB	PT	CONC	PT	ACT	9' - 6"	-	-		
109b	RECEPT	VGT	RB	-	-	CONC	PT	GWB	PT	CONC	PT	CONC	PT	ACT	8' - 6"	-	-		
109c	ADMIN (2)	VGT	RB	-	-	CONC	PT	CONC	PT	CONC	PT	GWB	PT	ACT	8' - 6"	-	-		
109d	OFFICE	VGT	RB	-	-	CONC	PT	CONC	PT	CONC	PT	GWB	PT	ACT	8' - 6"	-	-		
110	OFFICE	VGT	RB	-	-	CONC	PT	GWB	PT	GWB	PT	GWB	PT	ACT	8' - 6"	-	-		
111	CODIS	VGT	RB	-	-	CONC	PT	GWB	PT	CONC	PT	GWB	PT	ACT	8' - 6"	-	-		
112	LIBRARY	VGT	RB	-	-	CONC	PT	CONC	PT	CONC	PT	GWB	PT	ACT	9' - 6"	-	-		
113	CASE RM	VGT	RB	-	-	CONC	PT	CONC	PT	CONC	PT	GWB	PT	ACT	8' - 6"	-	-		
114	RESEARCH AND DEVELOPMENT	VGT	RB	-	-	CONC	PT	GWB	PT	CONC	PT	CONC	PT	ACT	8' - 6"	-	-		
115	BREAK RM	VGT	RB	-	-	CONC	PT	CONC	PT	CONC	PT	GWB	PT	ACT	8' - 6"	-	-		
116	SERVER	VGT	RB	-	-	CONC	PT	CONC	PT	CONC	PT	CONC	PT	ACT	8' - 6"	-	-		
117	ELEG.	SC	-	-	-	CONC	PT	CONC	PT	CONC	PT	CONC	PT	ACT	8' - 6"	-	-		
118	LAUNDRY	VGT	RB	-	-	CONC	PT	GWB	PT	CONC	PT	CONC	PT	ACT	8' - 6"	-	-		
119	SECURE ENTRY	VGT	RB	-	-	CONC	PT	CONC	PT	CONC	PT	CONC	PT	ACT	8' - 6"	-	-		
120	MENS	GT	GT	-	-	GWB	PT	GWB	PT	CONC	PT	CONC	PT	PT	8' - 0"	-	-		
121	WOMENS	GT	GT	-	-	CONC	PT	GWB	PT	GWB	PT	CONC	PT	PT	8' - 0"	-	-		
122	EVIDENCE STORAGE	VGT	RB	-	-	CONC	PT	CONC	PT	CONC	PT	CONC	PT	ACT	8' - 6"	-	-		
123	REFRIGERATOR STORAGE ROOM	GT	GT	-	-	CONC	PT	CONC	PT	CONC	PT	CONC	PT	ACT	8' - 6"	-	-		
124	CLEAN CORRIDOR	VGT	RB	-	-	CONC	PT	CONC	PT	CONC	PT	CONC	PT	PT	8' - 6"	-	-		
125	SECURE RECEIVING	VGT	RB	-	-	CONC	PT	CONC	PT	CONC	PT	CONC	PT	PT	8' - 6"	-	-		
126	ALS	VGT	RB	-	-	CONC	PT	CONC	PT	CONC	PT	CONC	PT	PT	8' - 6"	-	-		
127	BIOLOGY EXAM LAB	VGT	RB	-	-	CONC	PT	CONC	PT	CONC	PT	CONC	PT	ACT	12' - 0"	-	-		
128	POST AMP LAB	VGT	RB	-	-	CONC	PT	CONC	PT	CONC	PT	CONC	PT	ACT	10' - 6"	-	-		
129	PRE-AMP	VGT	RB	-	-	CONC	PT	CONC	PT	CONC	PT	CONC	PT	ACT	12' - 0"	-	-		
130	BIOVESTIBULE	VGT	RB	-	-	CONC	PT	CONC	PT	GWB	PT	CONC	PT	ACT	8' - 6"	-	-		
131	LAB STORAGE	VGT	RB	-	-	CONC	PT	CONC	PT	CONC	PT	CONC	PT	ACT	8' - 6"	-	-		
132	REAGENT ROOM	VGT	RB	-	-	CONC	PT	CONC	PT	CONC	PT	CONC	PT	ACT	12' - 0"	-	-		
133	ELECTRICAL	SC	-	-	-	CONC	PT	CONC	PT	CONC	PT	CONC	PT	-		-	-		
134	BACKUP GENERATOR	SC	-	-	-	CONC	PT	CONC	PT	CONC	PT	CONC	PT	-		-	-		
135	R.O SYSTEM	VGT	RB	-	-	CONC	PT	CONC	PT	CONC	PT	CONC	PT	-	8' - 6"	-	-		
136	WATER PUMP/TANKS	SC	-	-	-	CONC	PT	CONC	PT	CONC	PT	CONC	PT	-		-	-		
137	STAIR # 2	SC	-	-	-	CONC	PT	CONC	PT	CONC	PT	CONC	PT	-		-	-		

REVISIONS

No.	Description	Date

TRMA

Taniguchi Ruth Makio Architects
100 Cliff Business Center, P.O. Box 6A, Agaña, GU 96910
Tel.: (671) 475-8772 • Fax.: (671) 472-3381

Architecture
Planning
Interior Design

BID DOCUMENTS

MICHAEL W. MAKIO
CERTIFICATE
No. 246
★
EXP. 4/30/11
GUAM
REGISTERED ARCHITECT

I HEREBY CERTIFY THAT THIS PLAN WAS PREPARED
BY ME OR UNDER MY DIRECT SUPERVISION
DATE: _____

Project:

GUAM COMMUNITY COLLEGE

FORENSIC DNA LAB

Title:

ROOM FINISH SCHEDULE

Designed: TRMA

Drawn: RM/TP

Checked: CTC

Supv: MM

Scale:

Date: 12/17/12

Project No. 1026File

Drawing No.


A8.1

Sheet No. _____ of _____

DOOR SCHEDULE

DOOR NO.	LOCATION	DOOR										GLASS TYPE	FIRE RATED	DETAILS (A10.1)			HW SET	REMARKS
		SIZE	THK	TYPE	MAT'L	FIN	TYPE	MAT'L	FIN	TYPE	HEAD	JAMB	SILL					
D100a	COVERED WALKWAY	3'-0" x 7'-0"	1 3/4"	C	ALUM	ANOD	C	ALUM	ANOD	TG	5	5	3					
D100b	COVERED WALKWAY	3'-0" x 7'-0"	1 3/4"	C	ALUM	ANOD	C	ALUM	ANOD	TG	5	5	3					
D100c	OUTDOOR CORRIDOR	3'-0" x 7'-0"	1 3/4"	C	ALUM	ANOD	C	ALUM	ANOD	TG	5	5	3					
D101	GCC CLASSROOM	3'-0" x 7'-0"	1 3/4"	D	ALUM	ANOD	D	ALUM	ANOD	TG	4	4	4					
D102	GCC CLASSROOM	3'-0" x 7'-0"	1 3/4"	D	ALUM	ANOD	D	ALUM	ANOD	TG	4	4	4					
D103	GCC OFFICE	3'-0" x 7'-0"	1 3/4"	C	ALUM	ANOD	C	ALUM	ANOD	TG	5	5	6					
D104a	GCC OFFICE	3'-0" x 7'-0"	1 3/4"	C	ALUM	ANOD	C	ALUM	ANOD	TG	5	5	6					
D104b	SERVER	3'-0" x 7'-0" HM	1 3/4"	A	WD	PT	A	HM	PT	-	1	1	3					
D105	MEN	3'-0" x 7'-0" ALUM	1 3/4"	E	ALUM	ANOD	E	ALUM	ANOD	-	5	5	6					
D106	WOMEN	3'-0" x 7'-0" ALUM	1 3/4"	E	ALUM	ANOD	E	ALUM	ANOD	-	5	5	6					
D107	SECURE ENTRY	3'-0" x 7'-0" (G)	1 3/4"	G	ALUM	ANOD	G	ALUM	ANOD	TG	5	5	6					
D108a	COR	3'-0" x 7'-0" (G)	1 3/4"	G	ALUM	ANOD	G	ALUM	ANOD	TG	5	5	3					
D108b	COR	3'-0" x 7'-0" HM	1 3/4"	A	WD	PT	A	HM	PT	-	1	1	3					
D108c	COR	3'-0" x 7'-0" (G)	1 3/4"	G	ALUM	ANOD	G	ALUM	ANOD	TG	5	5	3					
D109	ADMIN	3'-0" x 7'-0"	1 3/4"	C	ALUM	ANOD	C	ALUM	ANOD	TG	5	5	3					
D109d	OFFICE	3'-0" x 7'-0" HM	1 3/4"	A	WD	PT	A	HM	PT	-	1	1	3					
D110	OFFICE	3'-0" x 7'-0"	1 3/4"	D	ALUM	ANOD	D	ALUM	ANOD	TG	5	5	3					
D111	CODIS	3'-0" x 7'-0"	1 3/4"	D	ALUM	ANOD	D	ALUM	ANOD	TG	5	5	3					
D112	LIBRARY	3'-0" x 7'-0" ALUM	1 3/4"	A	ALUM	ANOD	A	ALUM	ANOD	-	5	5	6					
D113	CASE RM	3'-0" x 7'-0" HM	1 3/4"	A	WD	PT	A	HM	PT	-	1	1	3					
D114	RESEARCH AND DEVELOPMENT	3'-0" x 7'-0" ALUM	1 3/4"	A	WD	PT	A	HM	PT	-	1	1	3					
D115a	BREAK RM	3'-0" x 7'-0" HM	1 3/4"	A	WD	PT	A	HM	PT	-	1	1	3					
D115b	BREAK RM	72" x 80"	1 1/2"	J	WD	PT	J	WD	PT	-	7	7	3					
D116	SERVER	3'-0" x 7'-0"	1 3/4"	C	ALUM	ANOD	C	ALUM	ANOD	TG	5	5	3					
D117	ELEC.	3'-0" x 7'-0" ALUM	1 3/4"	A	ALUM	ANOD	A	ALUM	ANOD	-	5	5	6					
D118	LAUNDRY	3'-0" x 7'-0" HM	1 3/4"	A	WD	PT	A	HM	PT	-	1	1	3					
D119	SECURE ENTRY	3'-0" x 7'-0" (G)	1 3/4"	G	ALUM	ANOD	G	ALUM	ANOD	TG	5	5	6					
D120	COR	3'-0" x 7'-0" HM	1 3/4"	A	WD	PT	A	HM	PT	-	1	1	3					
D121	WOMENS	3'-0" x 7'-0" HM	1 3/4"	A	WD	PT	A	HM	PT	-	1	1	3					
D122	EVIDENCE STORAGE	3'-0" x 7'-0" HM	1 3/4"	K	HM	PT	K	HM	PT	-	1	1	3					
D123	REFRIGERATOR STORAGE ROOM	6'-0" x 7'-0"	1 3/4"	M	ALUM	ANOD	M	ALUM	ANOD	TG	4	4	4					
D124a	CLEAN CORRIDOR	6'-0" x 7'-0"	1 3/4"	B	ALUM	ANOD	B	ALUM	ANOD	TG	5	5	3					
D124b	CLEAN CORRIDOR	6'-0" x 7'-0"	1 3/4"	B	ALUM	PT	B	HM	PT	TG	5	1	3					
D125	SECURE RECEIVING	6'-0" x 7'-0"	1 3/4"	B	ALUM	ANOD	B	ALUM	ANOD	TG	5	5	3					
D126	BIOLOGY EXAM LAB	3'-0" x 7'-0" HM	1 3/4"	K	HM	PT	K	HM	PT	-	1	1	3					
D127	CLEAN CORRIDOR	6'-0" x 7'-0"	1 3/4"	M	ALUM	PT	M	HM	PT	TG	1	1	3					
D128	BIOVESTIBULE	3'-0" x 7'-0"	1 3/4"	D	ALUM	ANOD	D	ALUM	ANOD	TG	5	5	3					
D129	BIOVESTIBULE	3'-0" x 7'-0"	1 3/4"	C	ALUM	ANOD	C	ALUM	ANOD	TG	5	5	3					
D130	BIOVESTIBULE	3'-0" x 7'-0"	1 3/4"	D	ALUM	PT	D	HM	PT	TG	1	1	3					
D131	CLEAN CORRIDOR	54" x 84"	2"	H	HM	PT	H	HM	PT	-	1	1	3					
D132	BIOVESTIBULE	3'-0" x 7'-0"	1 3/4"	D	ALUM	ANOD	D	ALUM	ANOD	TG	5	5	3					
D133	ELECTRICAL	3'-0" x 7'-0" ALUM	1 3/4"	A	ALUM	ANOD	A	ALUM	ANOD	-	5	5	6					
D134a	BACKUP GENERATOR	7'-0" x 10'-0" ALUM	1 3/4"	L	ALUM	ANOD	L	ALUM	ANOD	-	5	5	6					
D134c	BACKUP GENERATOR	3'-0" x 7'-0" ALUM	1 3/4"	A	ALUM	ANOD	A	ALUM	ANOD	-	5	5	6					
D135	R.O SYSTEM	3'-0" x 7'-0" ALUM	1 3/4"	A	ALUM	ANOD	A	ALUM	ANOD	-	5	5	6					
D136	WATER PUMP/TANKS	7'-0" x 8'-0" ALUM	1 3/4"	L	ALUM	ANOD	L	ALUM	ANOD	-	5	5	6					
D137a	STAIR # 2	3'-0" x 7'-0" ALUM	1 3/4"	A	ALUM	ANOD	A	ALUM	ANOD	-	5	5	6					
D137b	STAIR # 2	3'-0" x 7'-0" ALUM	1 3/4"	A	ALUM	ANOD	A	ALUM	ANOD	-	5	5	6					


DOOR TYPES

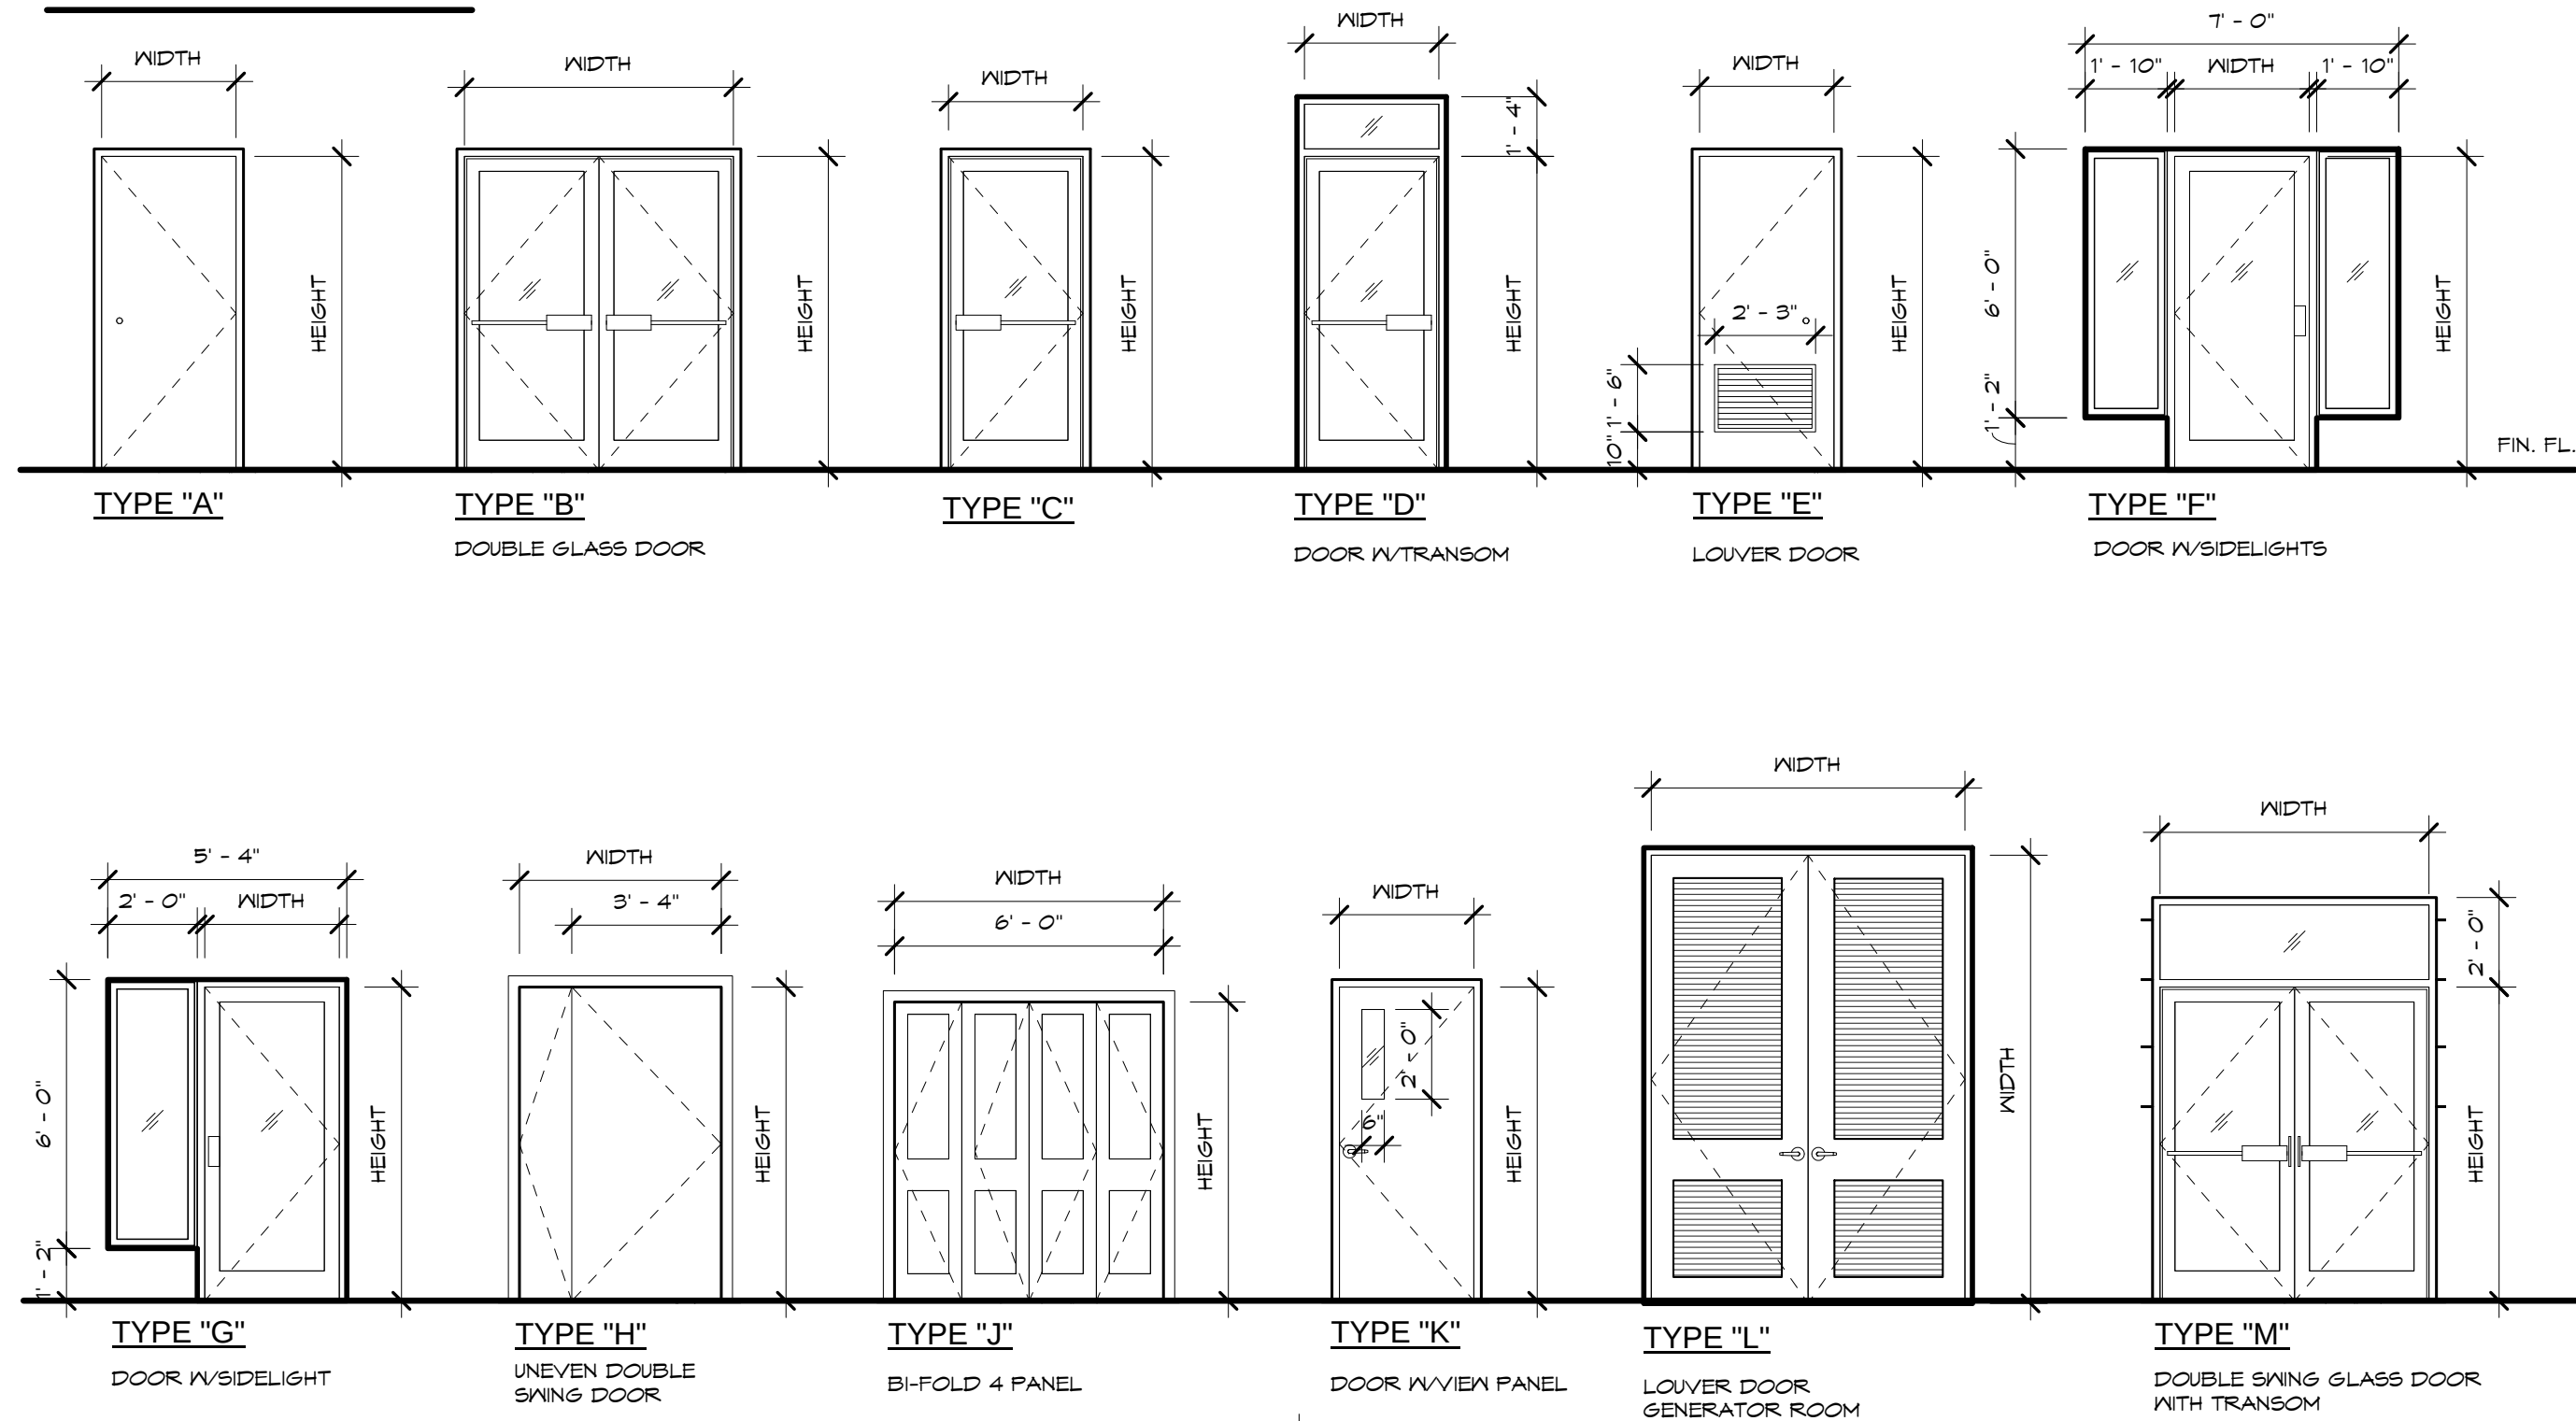

WINDOW SCHEDULE

NO	WINDOW SIZE (W X H)	TYPE	FRAME		GLASS TYPE	SILL HT	DETAILS (A10.2)			FIRE RATED	TYPHOON SHUTTER	REMARKS
			MAT'L	FIN			HEAD	JAMB	SILL			
L1	5'-0" X 8'-0"	H	ALUM	ANOD	-	6"	10	10	10	-	NO	GENERATOR LOUVER
W1	6'-9" X 5'-0"	A	ALUM	ANOD	TG	3'-0"	5	5	6	-	YES	
W3	6'-7" X 7'-10"	A	ALUM	ANOD	TG	12"	5	5	6	-	YES	
W4	12'-0" X 6'-0"	B	ALUM	ANOD	TG	3'-0"	5	5	6	-	YES	
W5	6'-0" X 4'-0"	C	ALUM	ANOD	TG	3'-0"	5	5	6	-	YES	
W6	15'-0" X 6'-0"	D	ALUM	ANOD	TG	3'-0"	5	5	6	-	YES	
W7	12'-0" X 5'-6"	B	ALUM	ANOD	TG	3'-6"	5	5	6	-	YES	
W8	5'-0" X 4'-0"	C	ALUM	ANOD	TG	3'-0"	5	5	6	-	YES	
W9	8'-0" X 5'-0"	G	ALUM	ANOD	TG	3'-6"	5	5	6	-	YES	
W10	15'-0" X 6'-0" (P)	E	ALUM	ANOD	TG	3'-6"	5	5	6	-	YES	PASS-THRU
W11	8'-0" X 7'-0"	D	ALUM	ANOD	TG	6"	5	5	6	-	NO	
W12	6'-0" X 7'-0"	H	ALUM	ANOD	TG	6"	5	5	6	-	NO	
W13	4'-0" X 4'-0"	A	ALUM	ANOD	TG	6"	5	5	6	-	NO	
W14	3'-0" X 4'-0"	K	ALUM	ANOD	TG	3'-0"	7	7	3	-	NO	SERVICE WINDOW
W15	14'-6" X 8'-6"	F	ALUM	ANOD	TG	3'-6"	1	1	2	-	NO	
W16	24" X 24"	C	ALUM	ANOD	TG	9'-8"	5	5	6	-	YES	
W17	8'-0" X 2'-0"	B	ALUM	ANOD	TG	13'-0"	5	5	6	-	YES	
W18	4'-0" X 2'-0"	A	ALUM	ANOD	TG	13'-0"	5	5	6	-	YES	
W19	20" X 30"	L	ALUM	ANOD	TG	4'-0"	7	7	3	-	NO	PASS-THRU
W20	16'-0" X 8'-4"	B	ALUM	ANOD	TG	-	5	5	6	-	NO	

WINDOW TYPES

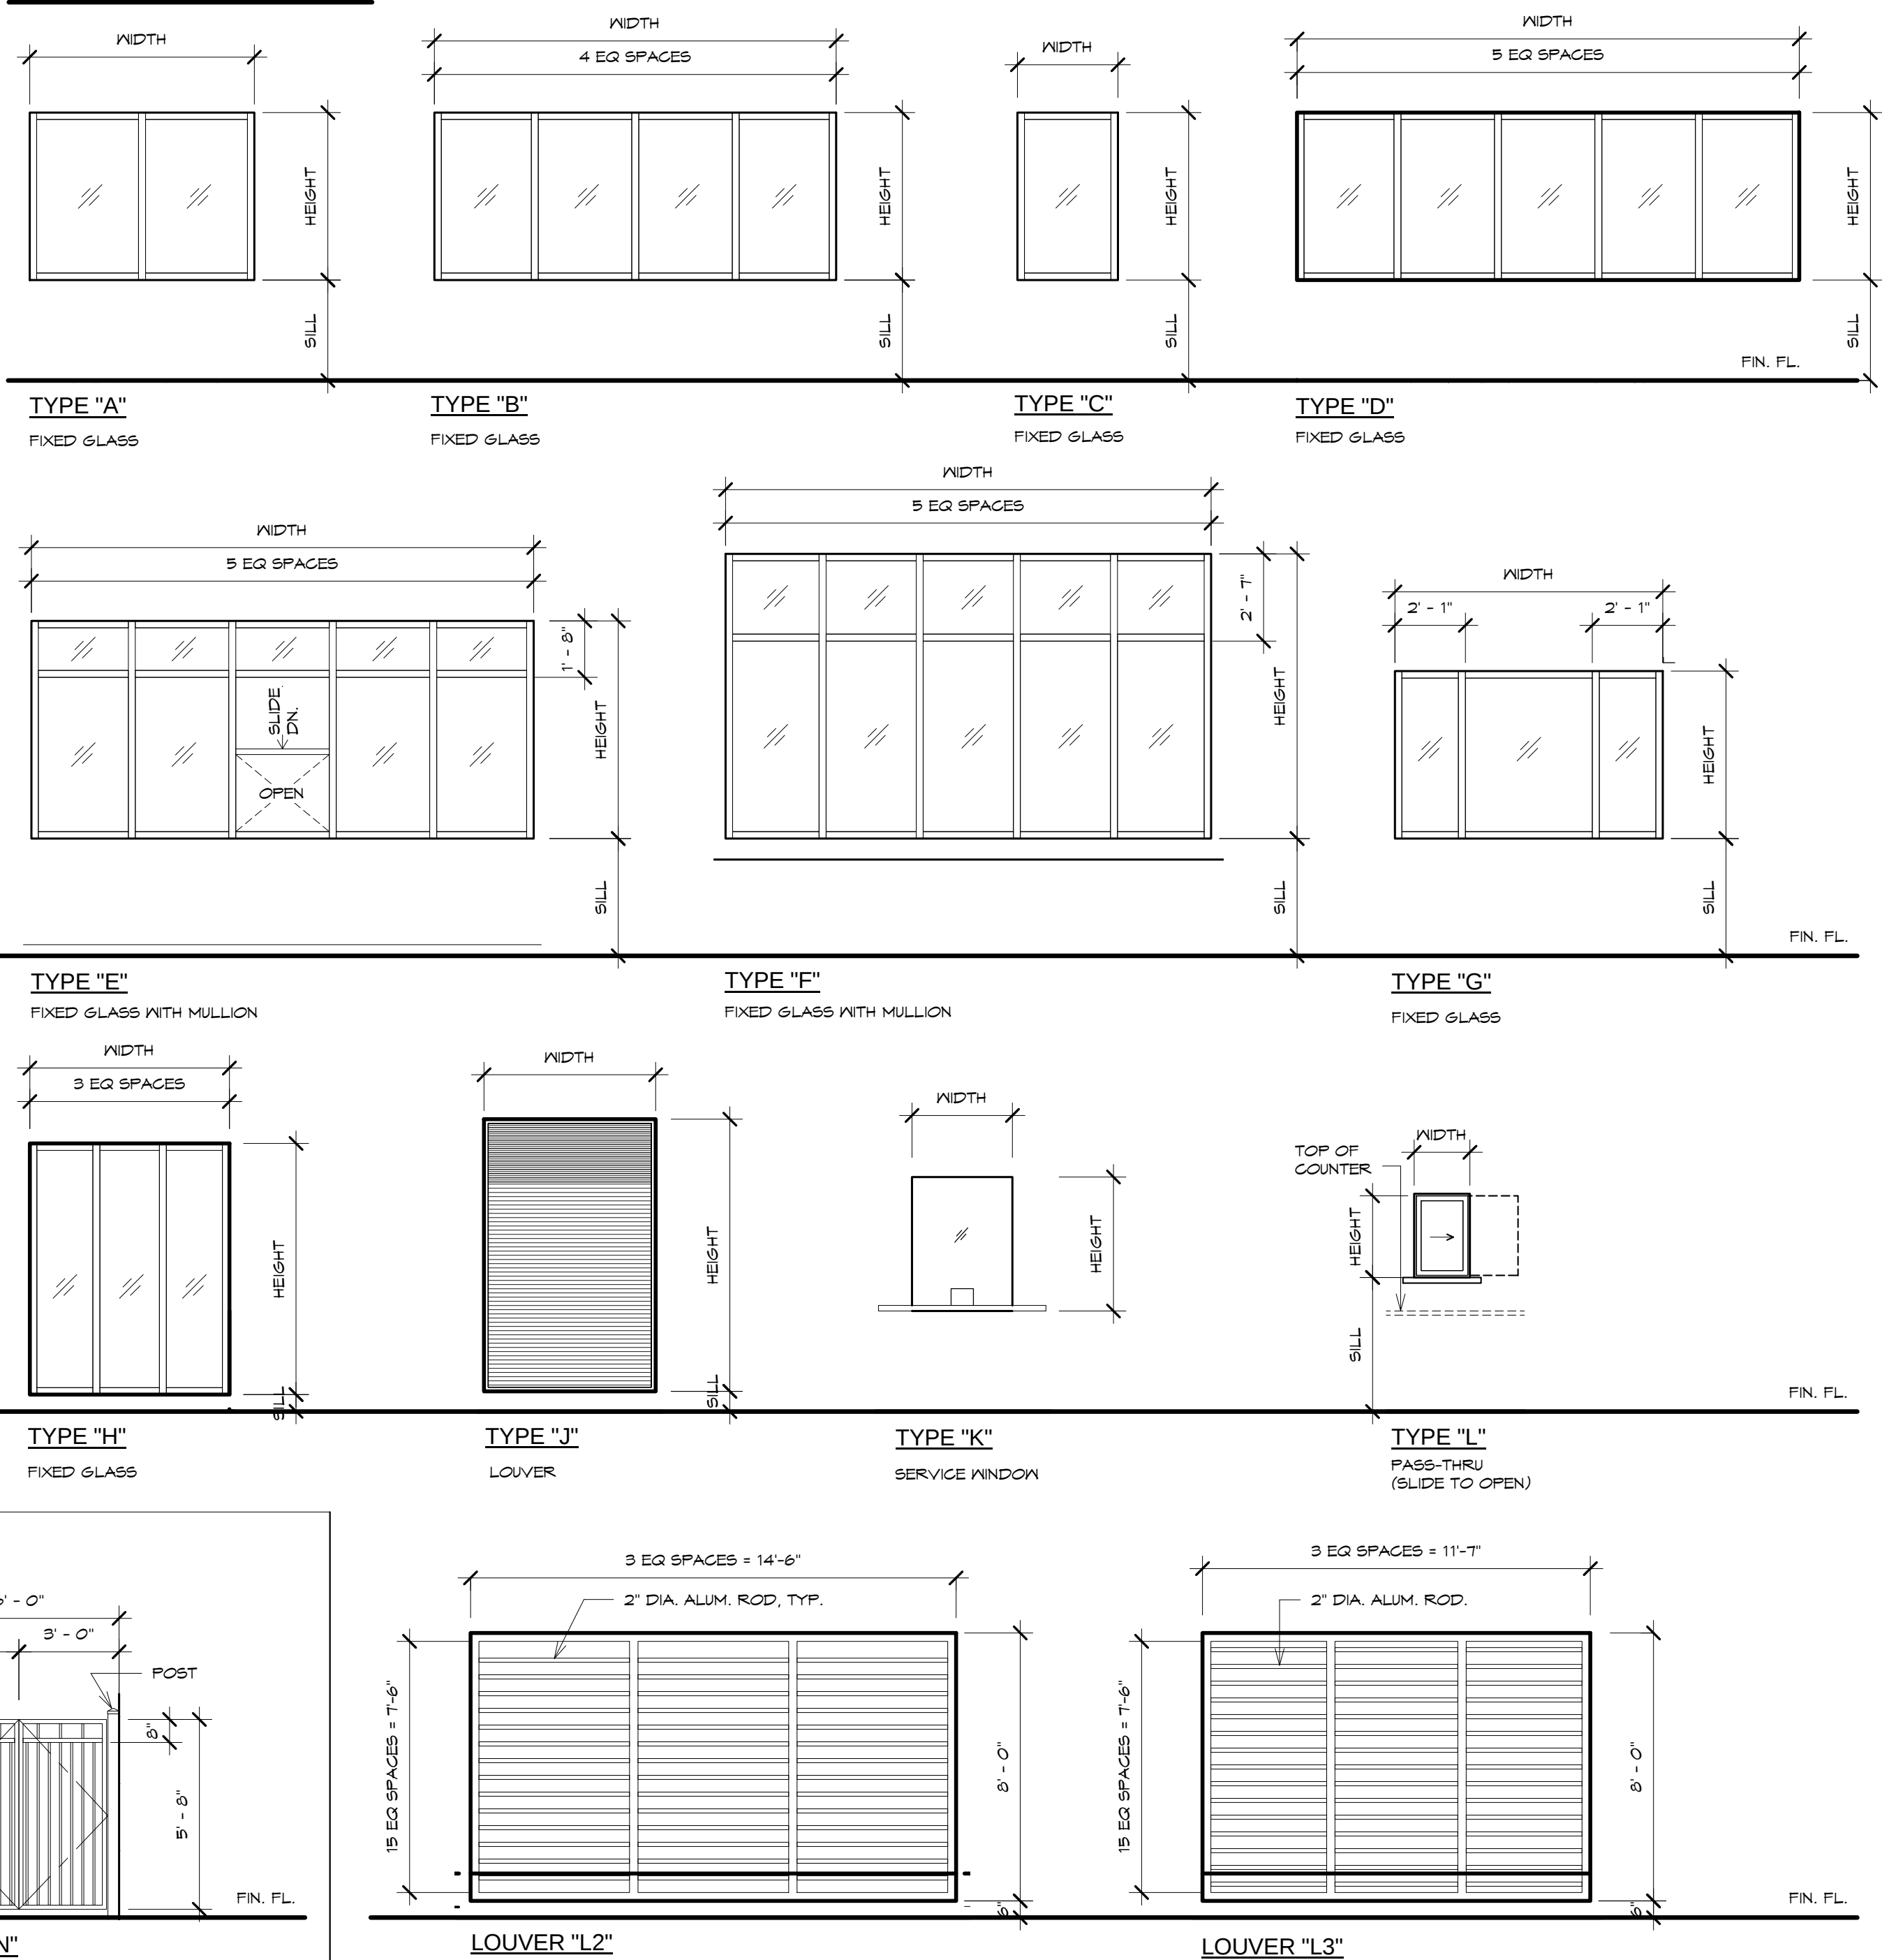

REVISIONS

No.	Description	Date

TRMA
Taniguchi Ruth Makio Architects
100 Cliff Business Center, P.O. Box 6A, Agaña, GU 96910
Tel.: (671) 475-8772 • Fax: (671) 472-3381

Architecture
Planning
Interior Design

BID
DOCUMENTS

I HEREBY CERTIFY THAT THIS PLAN WAS PREPARED BY ME OR UNDER MY DIRECT SUPERVISION.


DATE: _____

Project:
GUAM COMMUNITY COLLEGE
FORENSIC DNA LAB


Title:
DOOR AND WINDOW SCHEDULES

Designed: TRMA
Drawn: RM/TP
Checked: CTC
Supv: MM
Scale: 1/4" = 1'-0"
Date: 12/17/12
Project No. 1026
Drawing No.


A8.2
Sheet No. _____ of _____

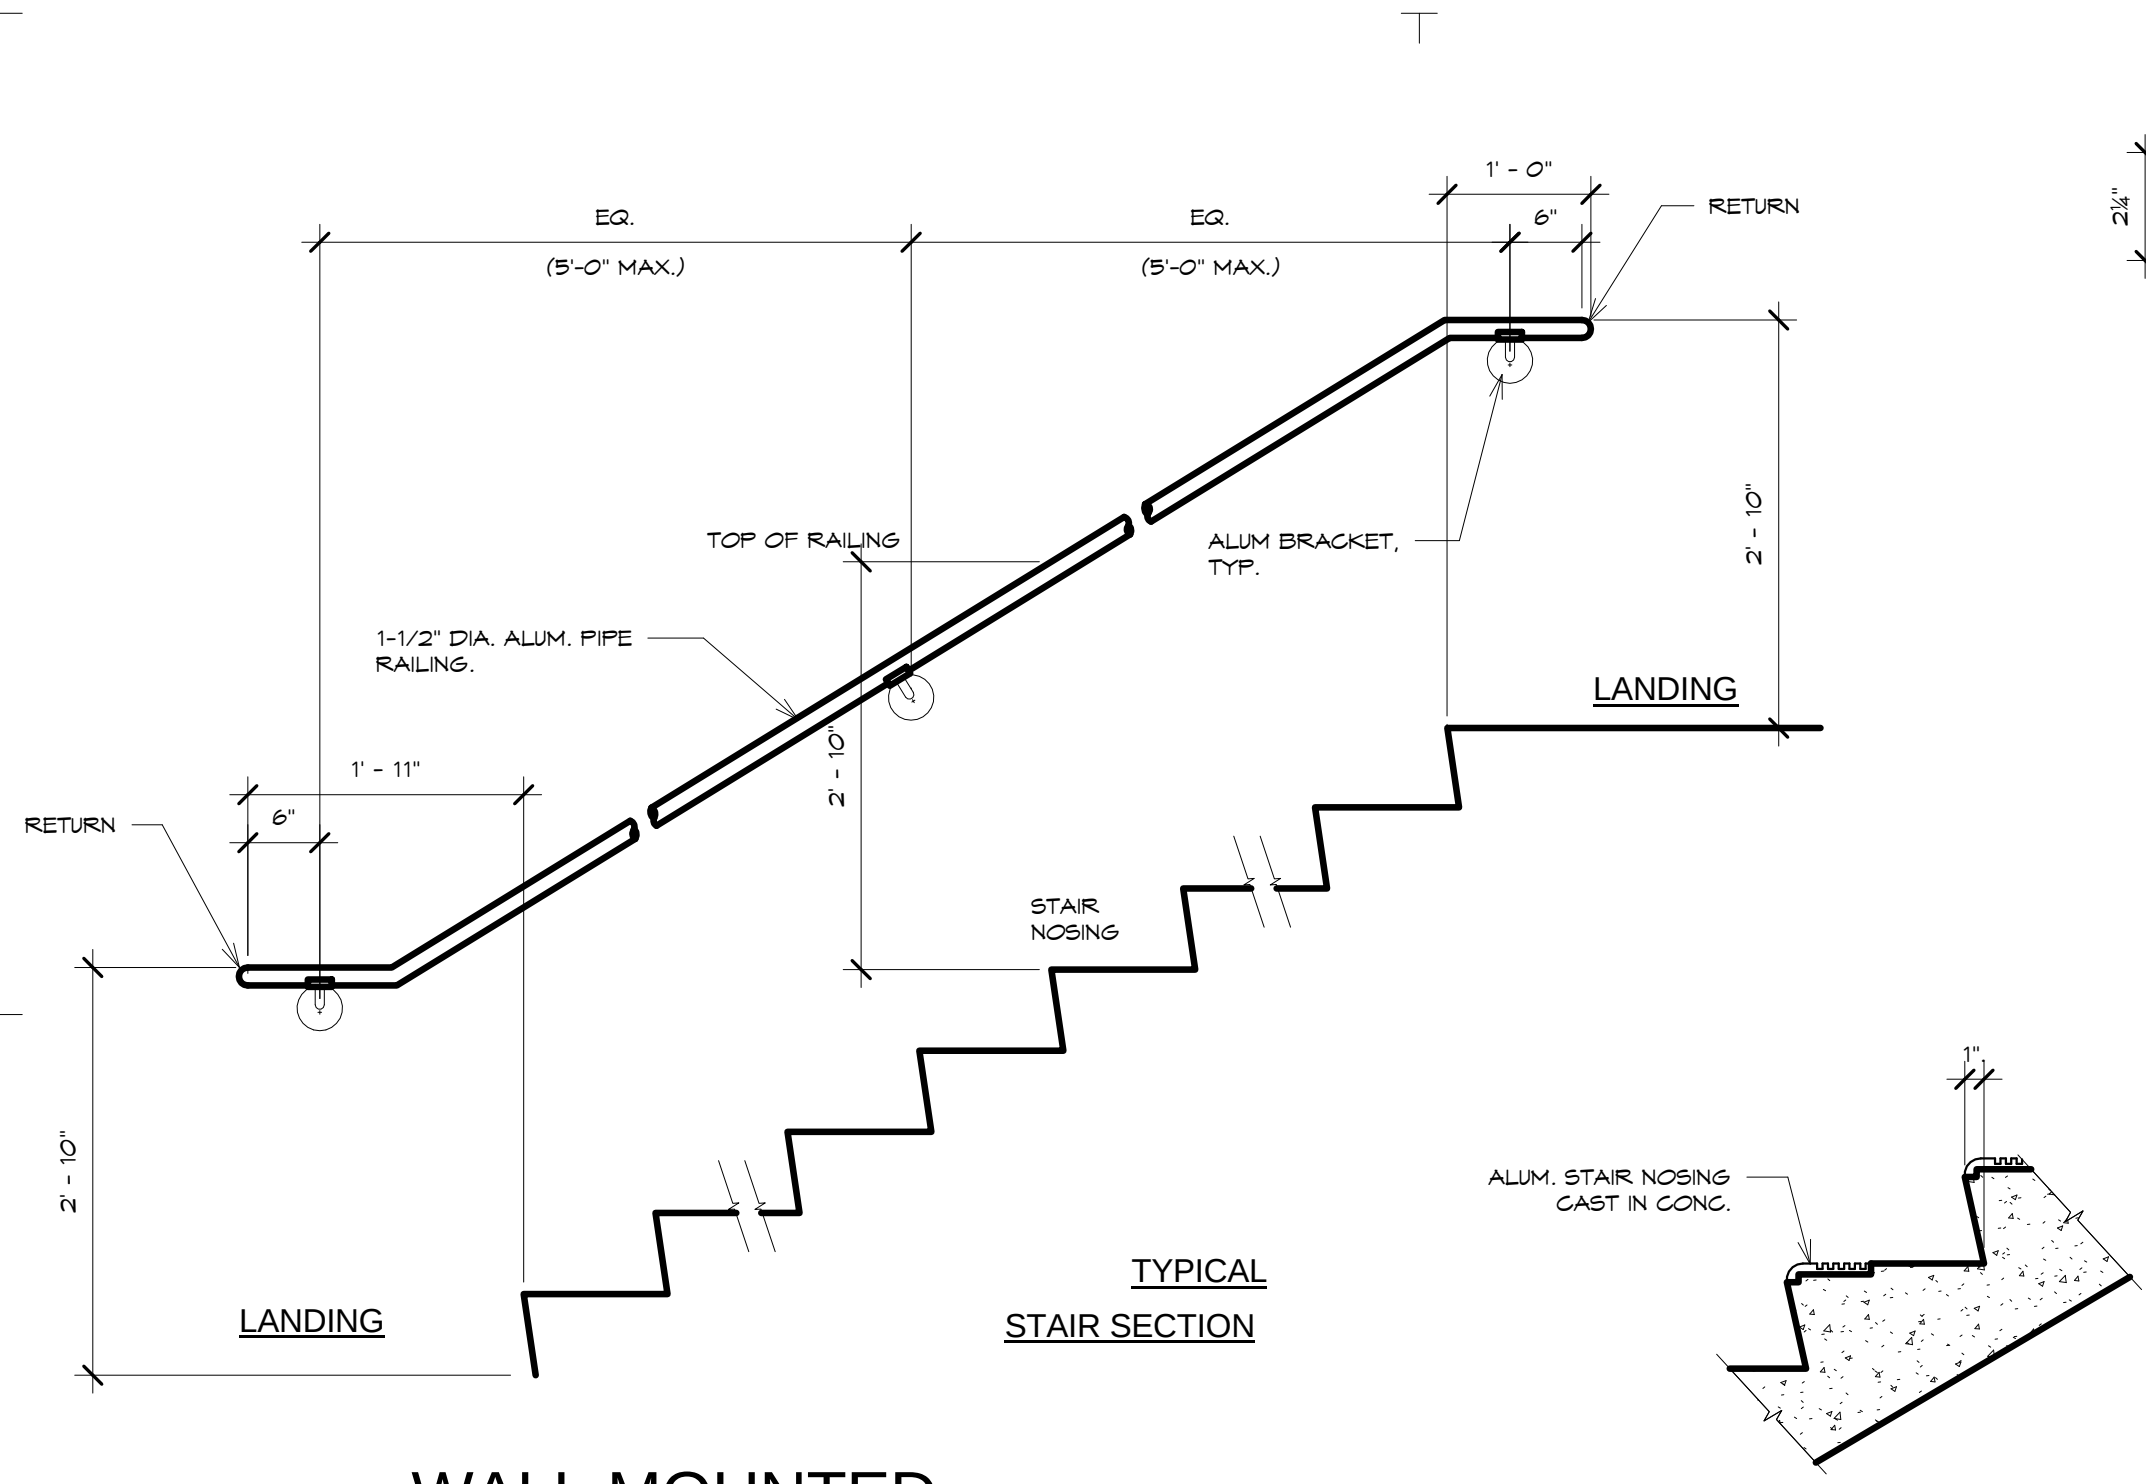


1 WALL MOUNTED HAND RAIL
SCALE: 3/4" = 1'-0"

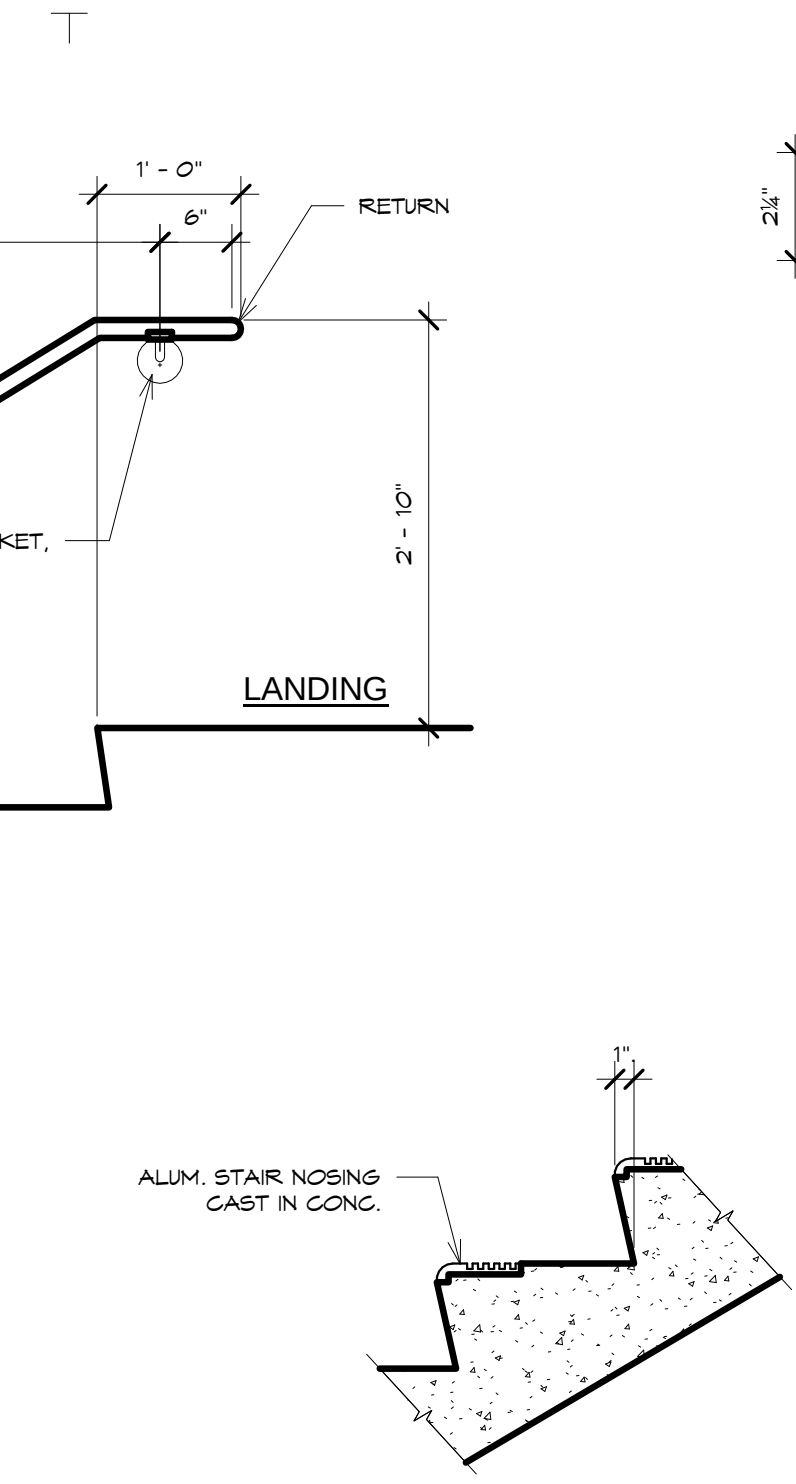


2 STAIR NOSING
SCALE: 1" = 1'-0"

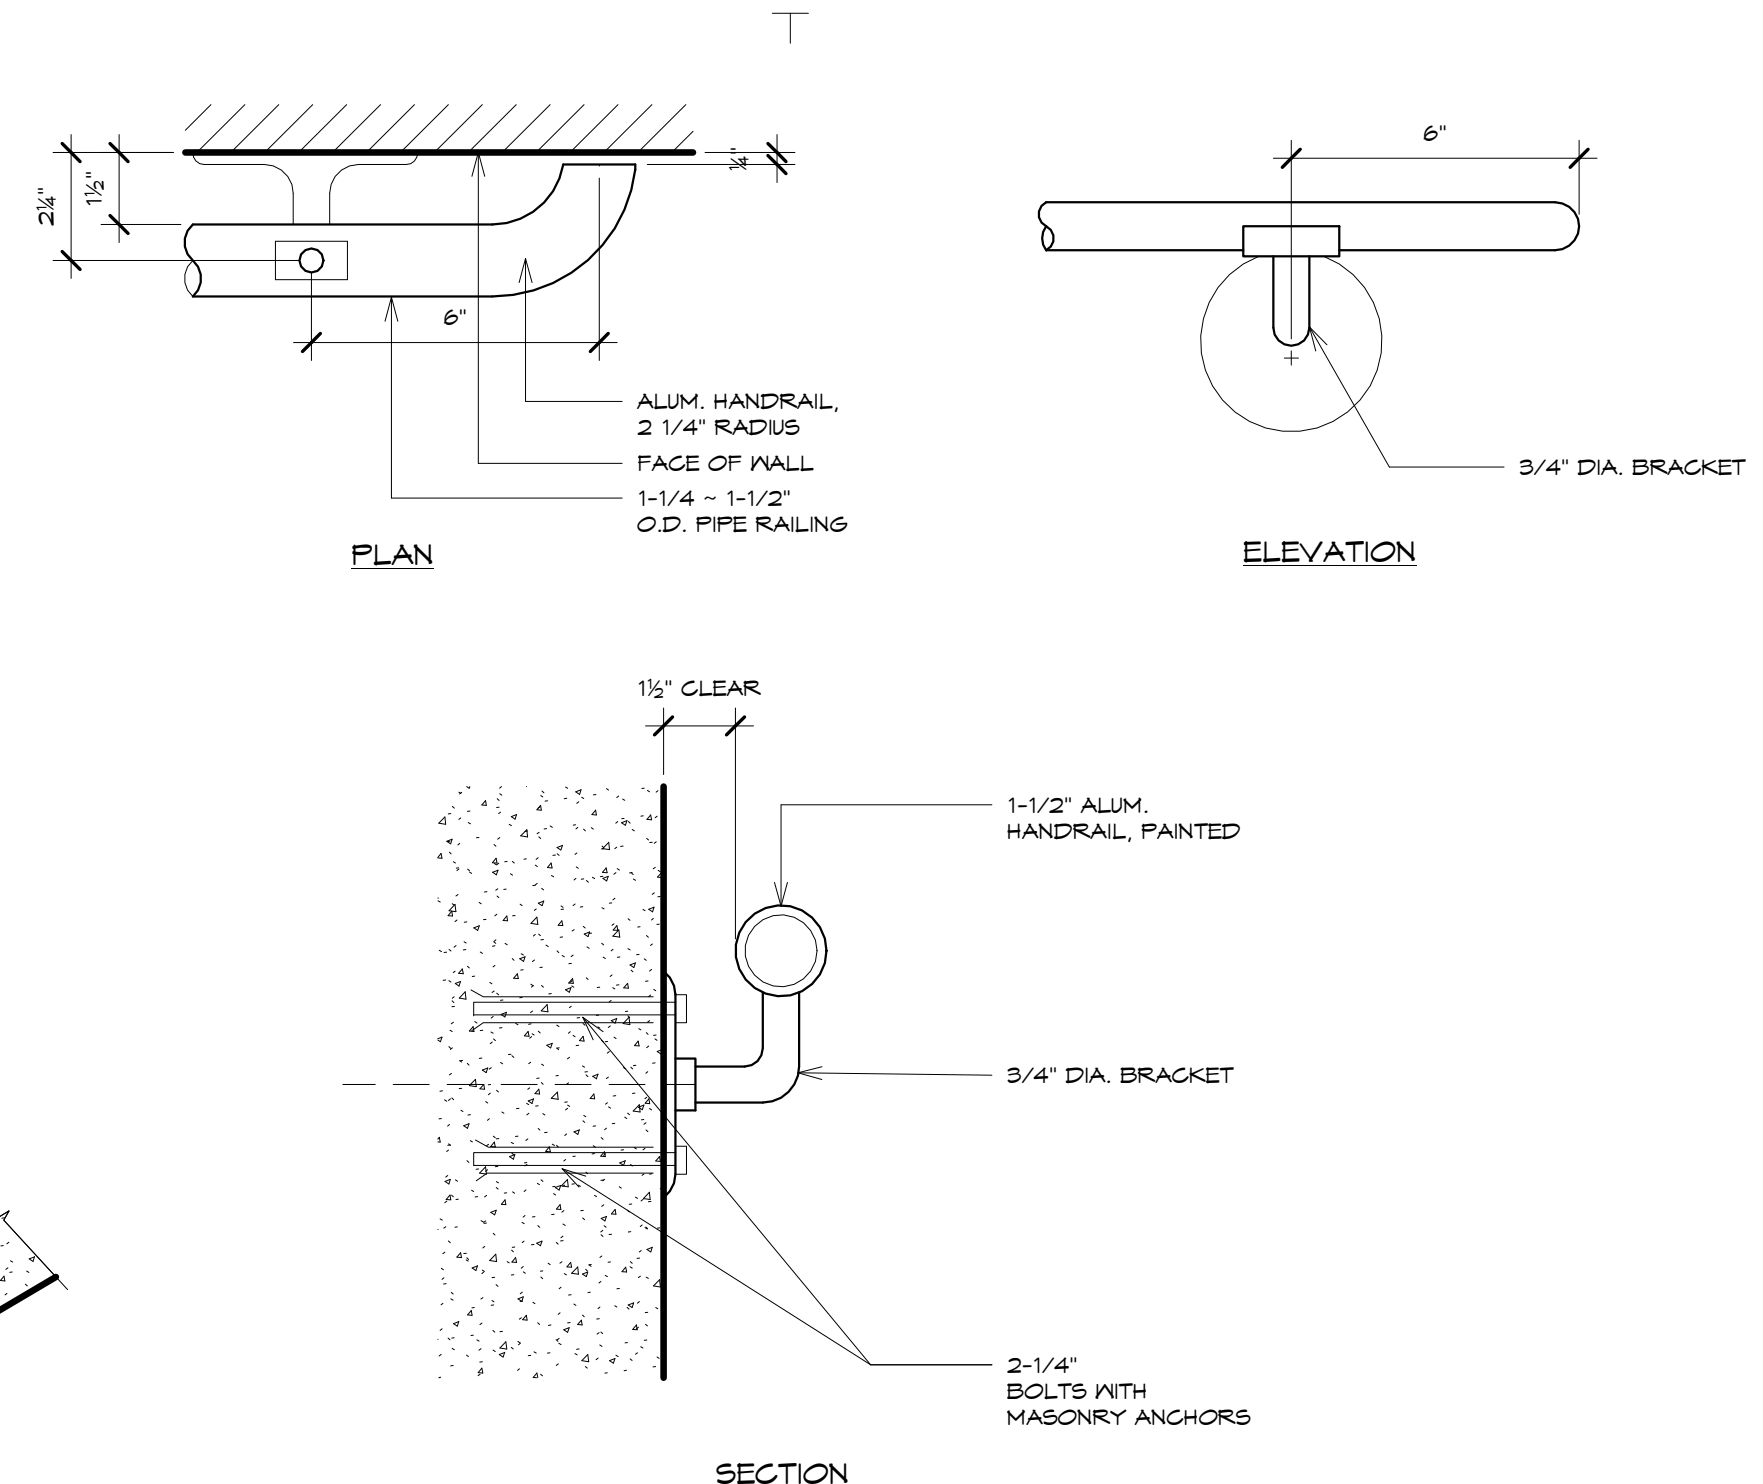

3 HANDRAIL DETAIL
SCALE: 3" = 1'-0"

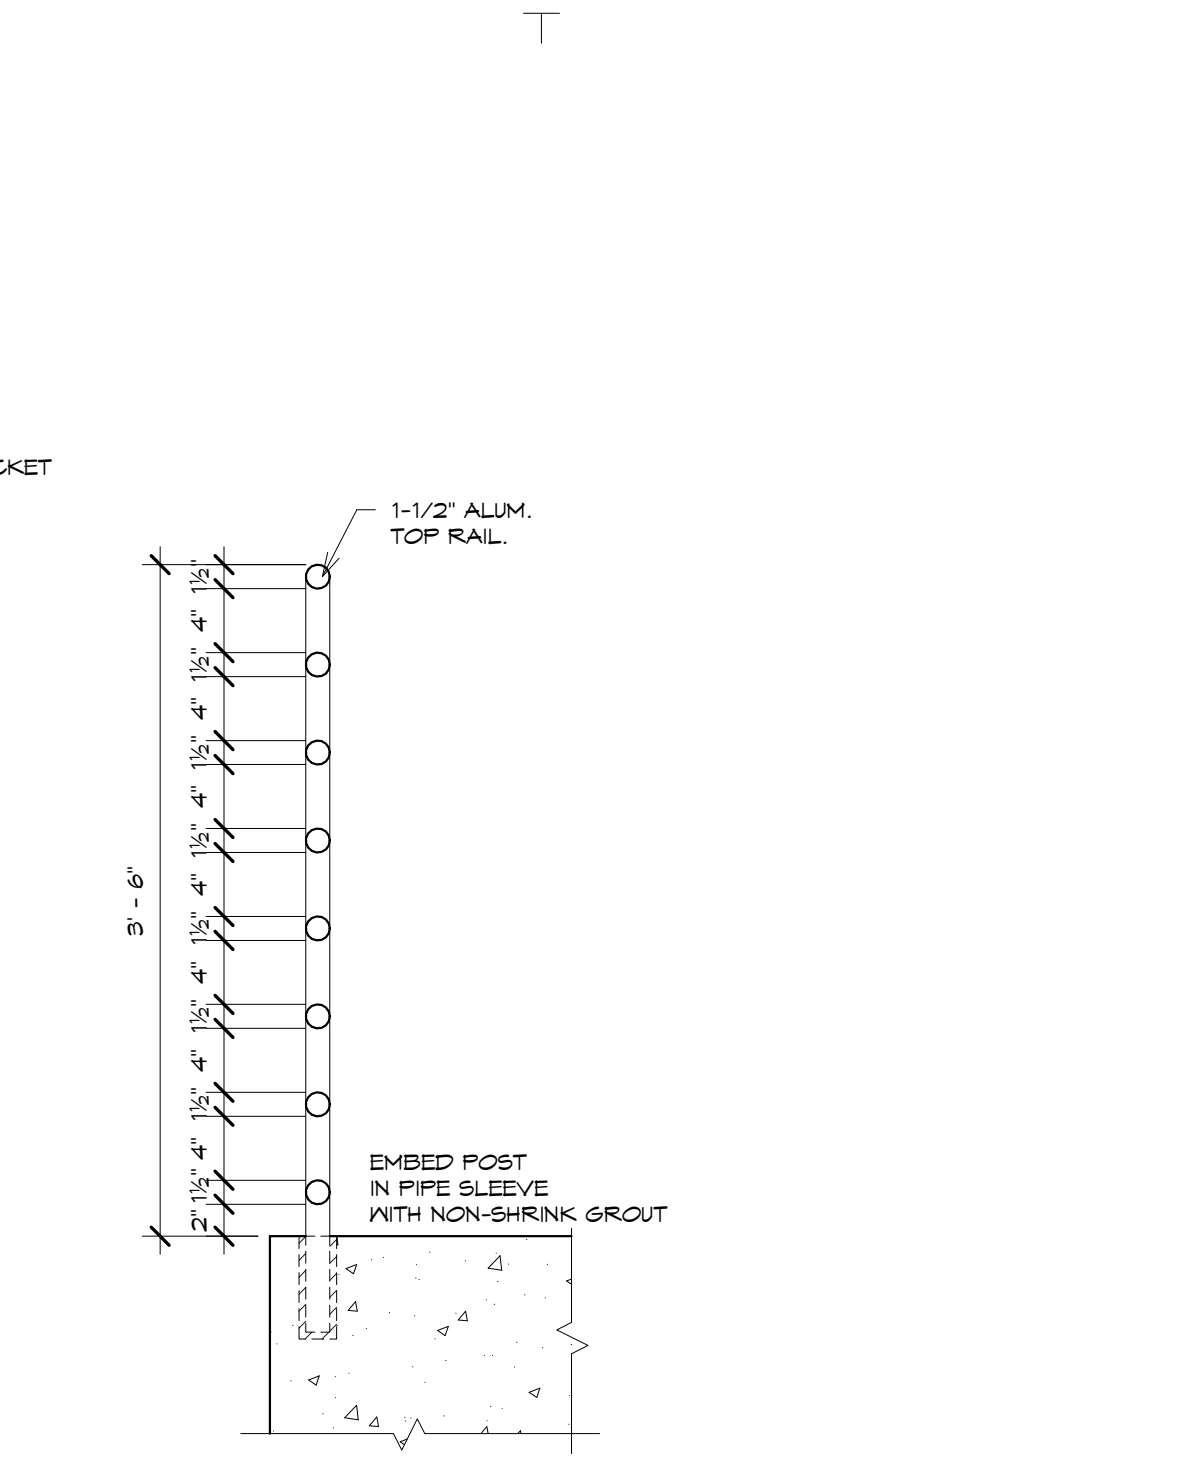


4 GUARDRAIL SECTION
SCALE: 1" = 1'-0"

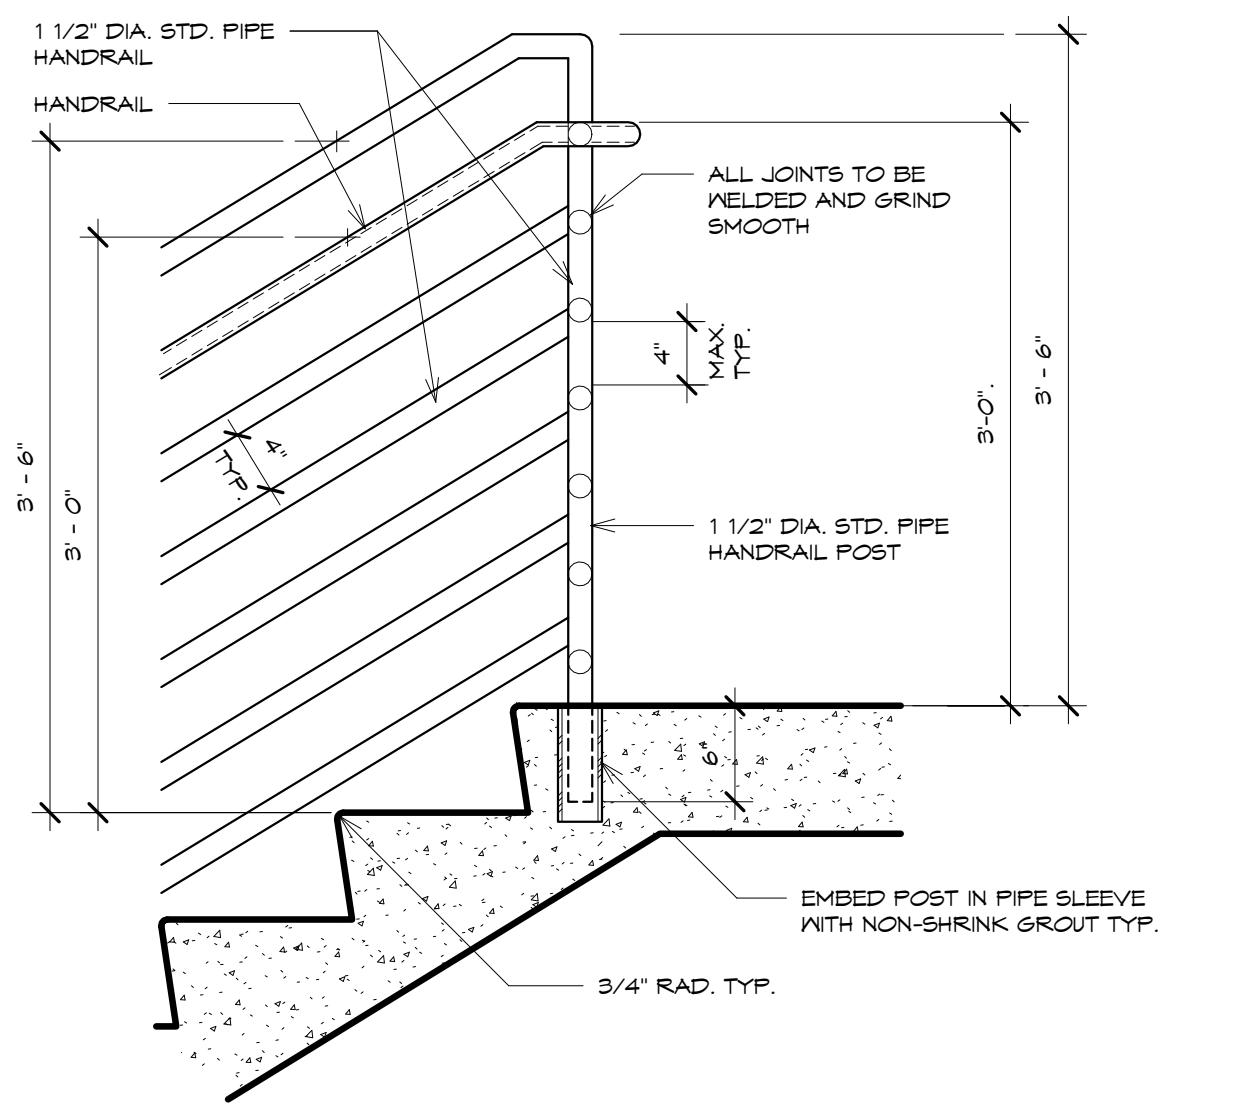


5 GUARDRAIL DET "C"
SCALE: 1" = 1'-0"

REVISIONS		
No.	Description	Date
TRMA Taniguchi Ruth Makio Architects 100 Cliff Business Center, P.O. Box EA, Agaña, GU 96910 Tel.: (671) 475-8772 • Fax: (671) 472-3381 Architecture Planning Interior Design		
BID DOCUMENTS		
MICHAEL W. MAKIO CERTIFICATE No. 246 ★ EXP. 4/30/11 GUAM REGISTERED ARCHITECT I HEREBY CERTIFY THAT THIS PLAN WAS PREPARED BY ME OR UNDER MY DIRECT SUPERVISION. DATE: _____		
Project: GUAM COMMUNITY COLLEGE FORENSIC DNA LAB		
Title: RAILING DETAILS		
Designed: TRMA		
Drawn: RM/TP		
Checked: CTC		
Supv: MAM		
Scale: As indicated		
Date: 12/17/12		
Project No. 1026 File		
Drawing No.		
A9.1		
Sheet No. _____ of _____		



IF SHEET IS LESS THAN 24" X 36"
REDUCED PRINT - USE GRAPHIC SCALES

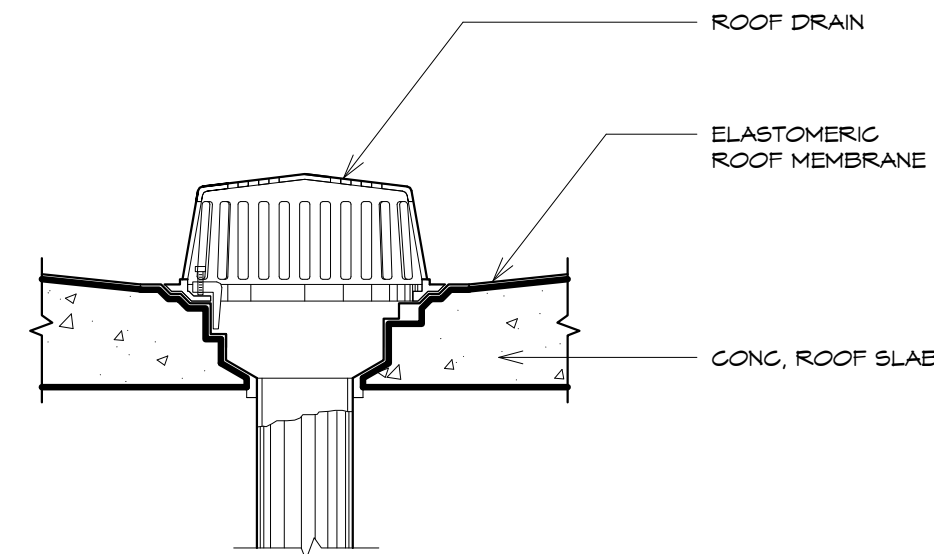



1 ROOF DRAIN
SCALE: 1 1/2" = 1'-0"

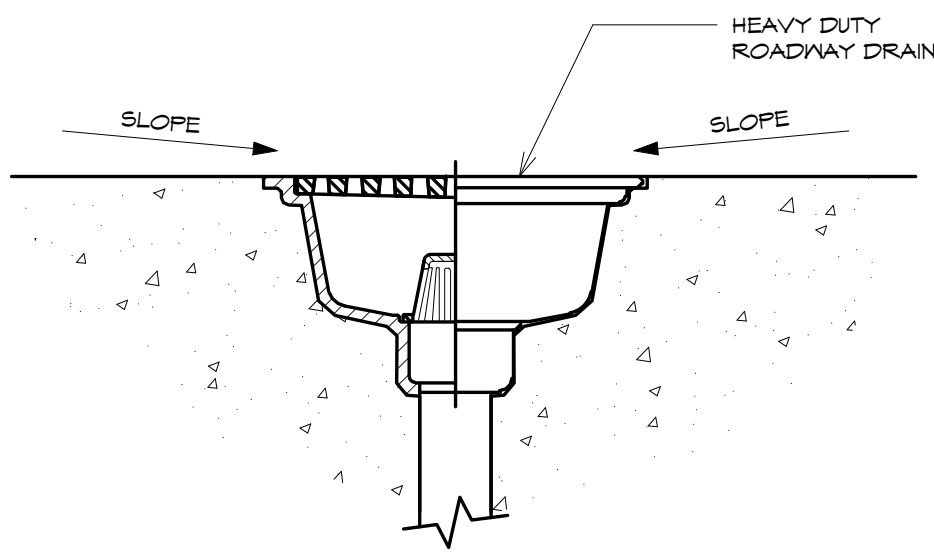


2 GARAGE FLOOR DRAIN
SCALE: 3" = 1'-0"

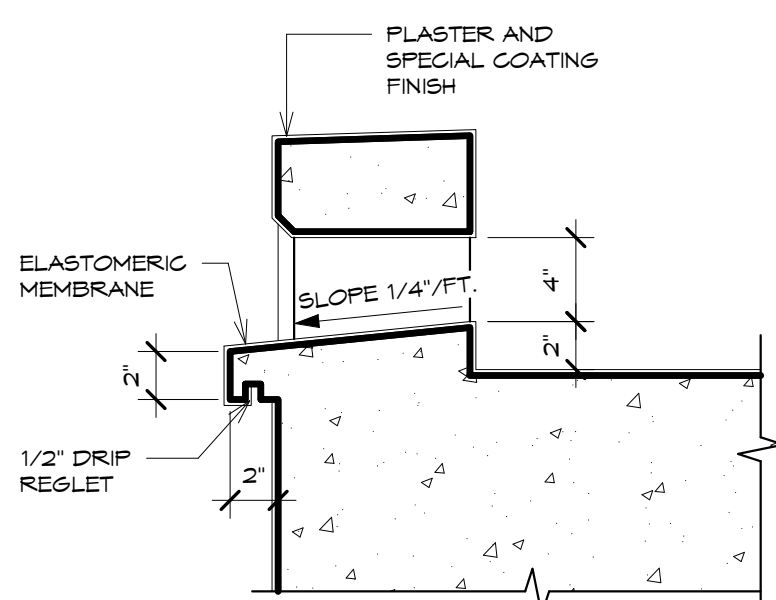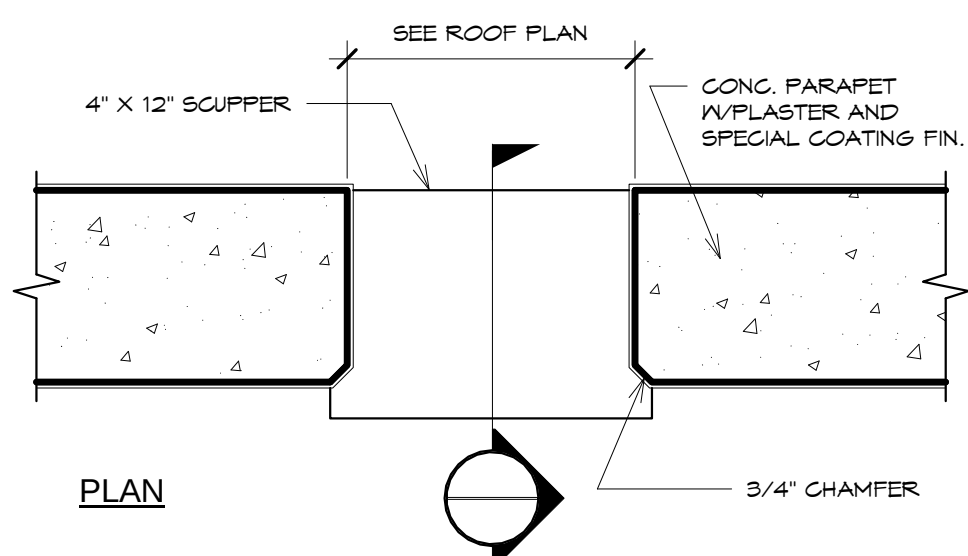


3 SCUPPER DRAIN
SCALE: 1 1/2" = 1'-0"

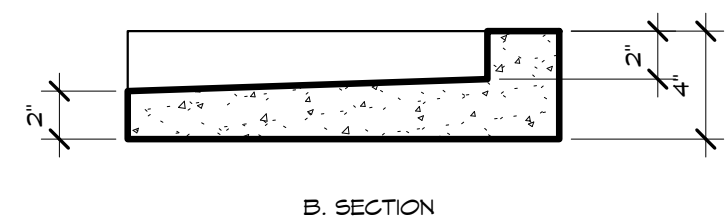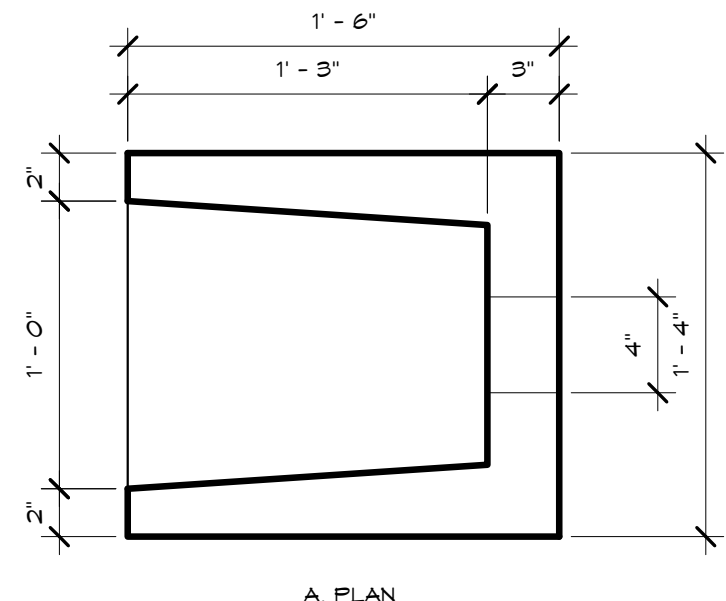

4 CONCRETE SPLASH BLOCK DETAIL
SCALE: 1 1/2" = 1'-0"

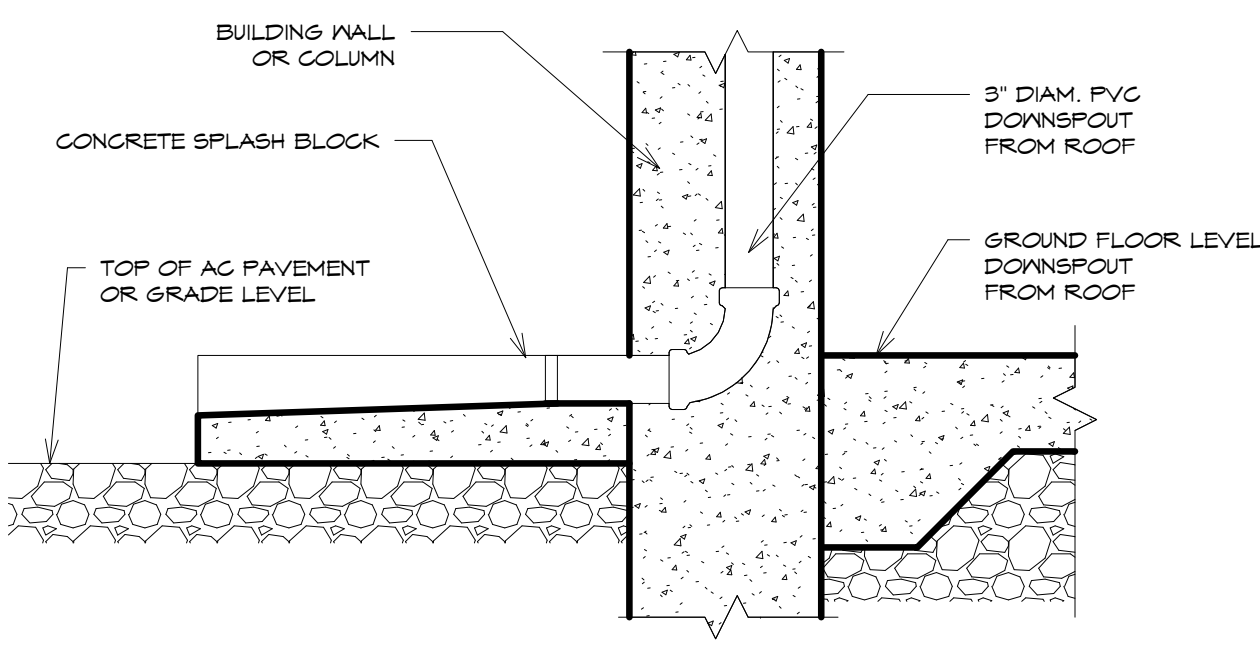

5 DOWNSPOUT DETAIL
SCALE: 1 1/2" = 1'-0"

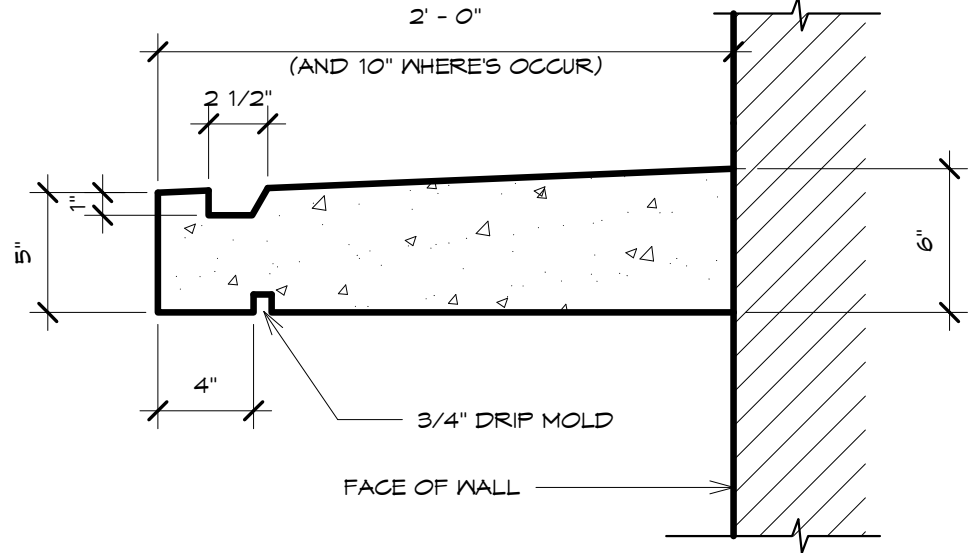

6 CONC. EYEBROW
SCALE: 1 1/2" = 1'-0"

REVISIONS		
No.	Description	Date

TRMA

Taniguchi Ruth Makio Architects
100 Cliff Business Center, P.O. Box EA, Agaña, GU 96910
Tel.: (671) 475-8772 • Fax: (671) 472-3381

Architecture
Planning
Interior Design

BID DOCUMENTS

MICHAEL W. MAKIO
CERTIFICATE
No. 246
EXP. 4/30/11
GUAM
REGISTERED ARCHITECT

I HEREBY CERTIFY THAT THIS PLAN WAS PREPARED
BY ME OR UNDER MY DIRECT SUPERVISION
DATE: _____


Project:
GUAM COMMUNITY COLLEGE
FORENSIC DNA LAB

Title:
ROOF DETAILS


Designed:	TRMA
Drawn:	RM/TP
Checked:	CTC
Supv:	MMM
Scale:	As indicated
Date:	12/17/12
Project No.	1026
File	
Drawing No.	

A9.2
Sheet No. _____ of _____


IF SHEET IS LESS THAN 24" X 36"
REDUCED PRINT - USE GRAPHIC SCALES

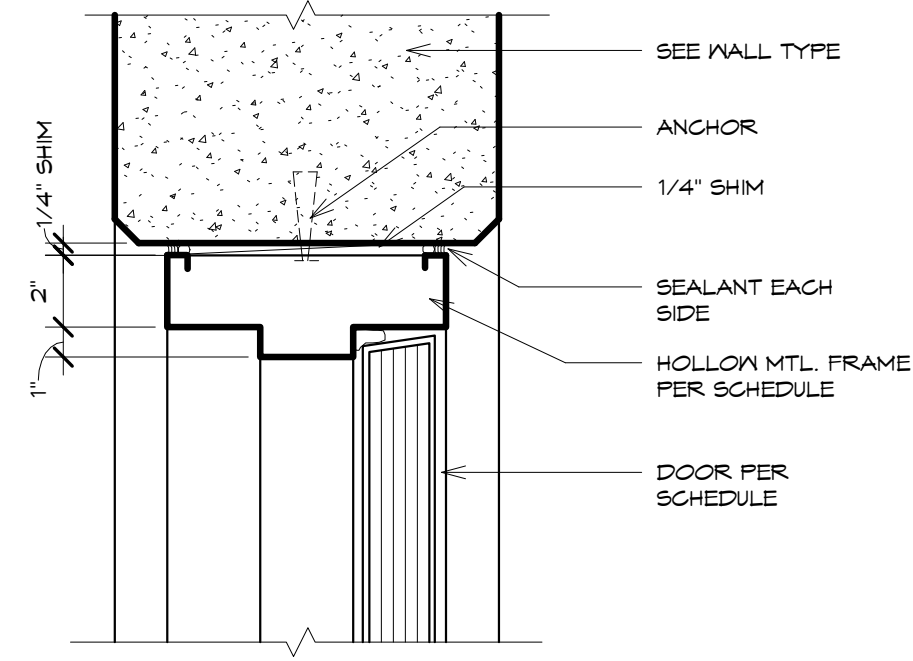


1 HM DOOR HEAD/JAMB
SCALE: 3" = 1'-0"

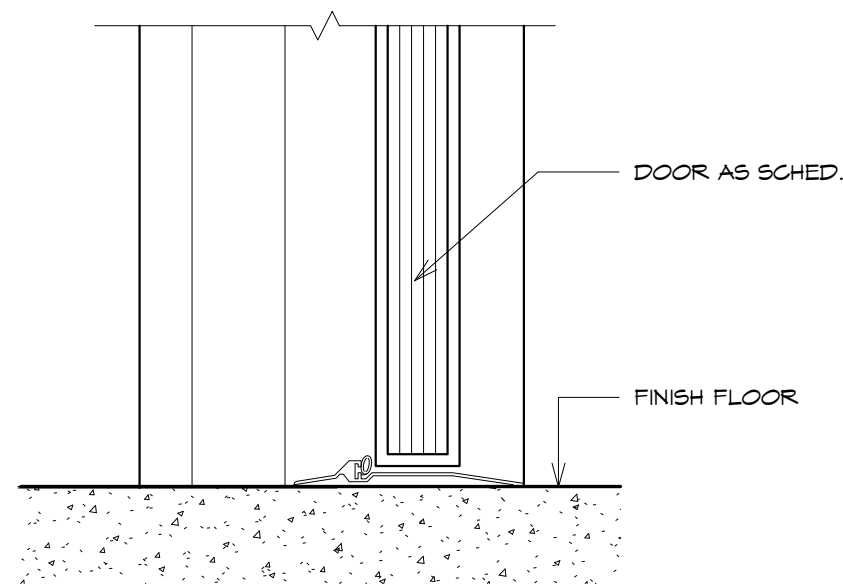


2 HM DOOR SILL
SCALE: 3" = 1'-0"

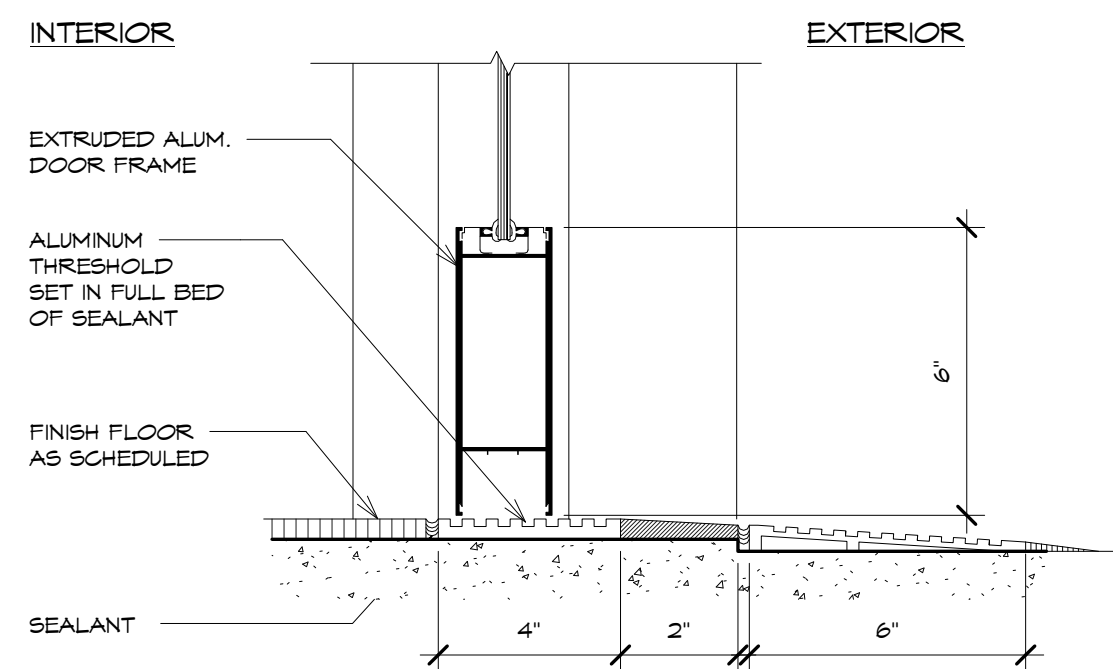


3 ALUM DOOR THRESHOLD
SCALE: 3" = 1'-0"

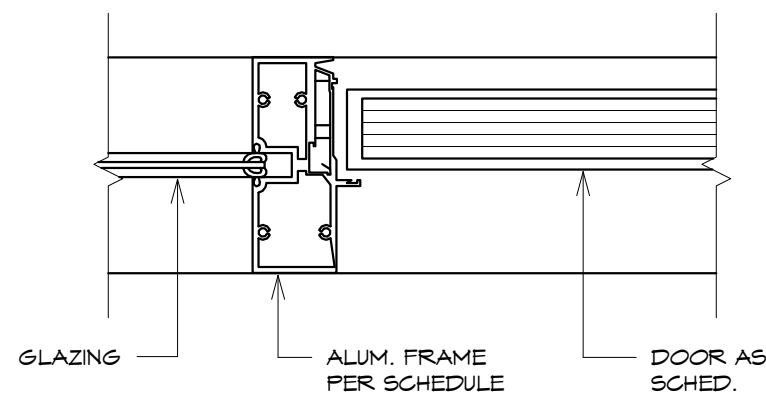


4 ALUM. DOOR/SIDELITE/TRANSOM JAMB
SCALE: 3" = 1'-0"

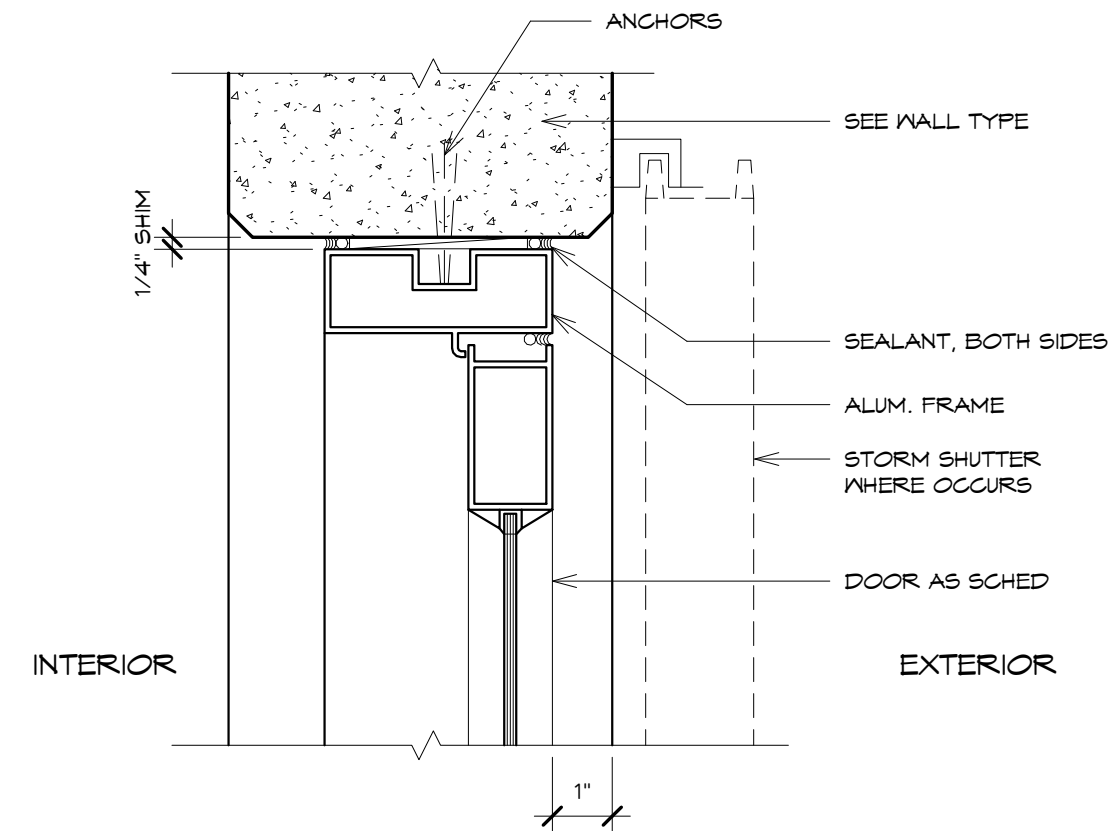


5 ALUM. DOOR HEAD/JAMB
SCALE: 3" = 1'-0"

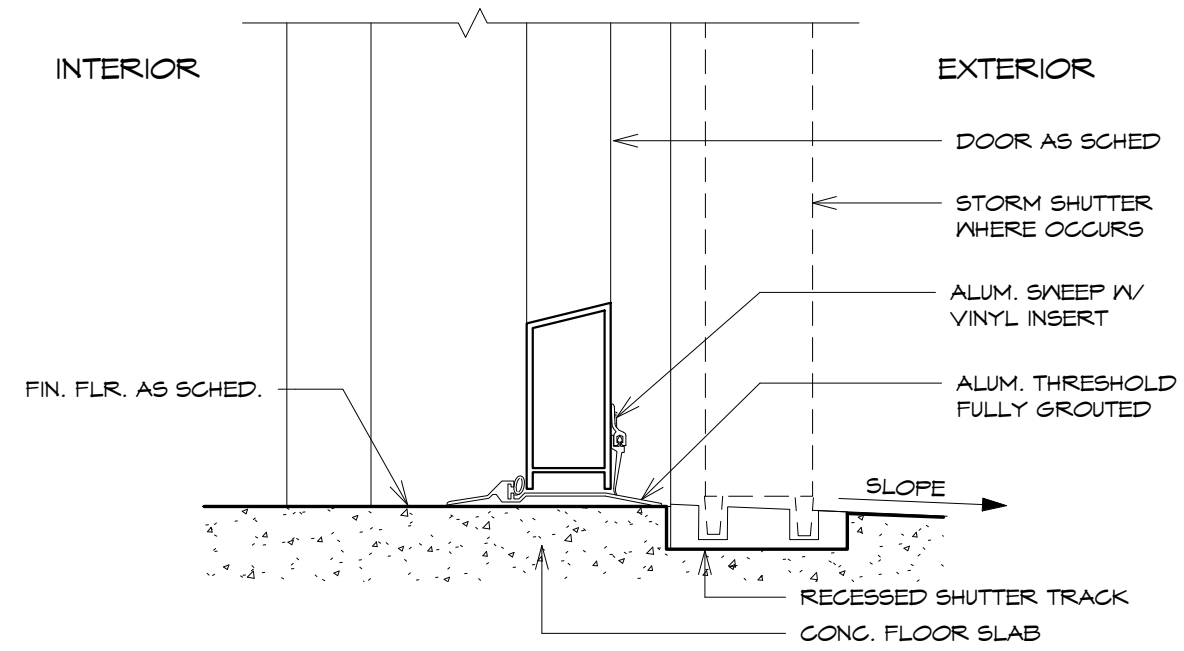


6 ALUM. DOOR THRESHOLD
SCALE: 3" = 1'-0"

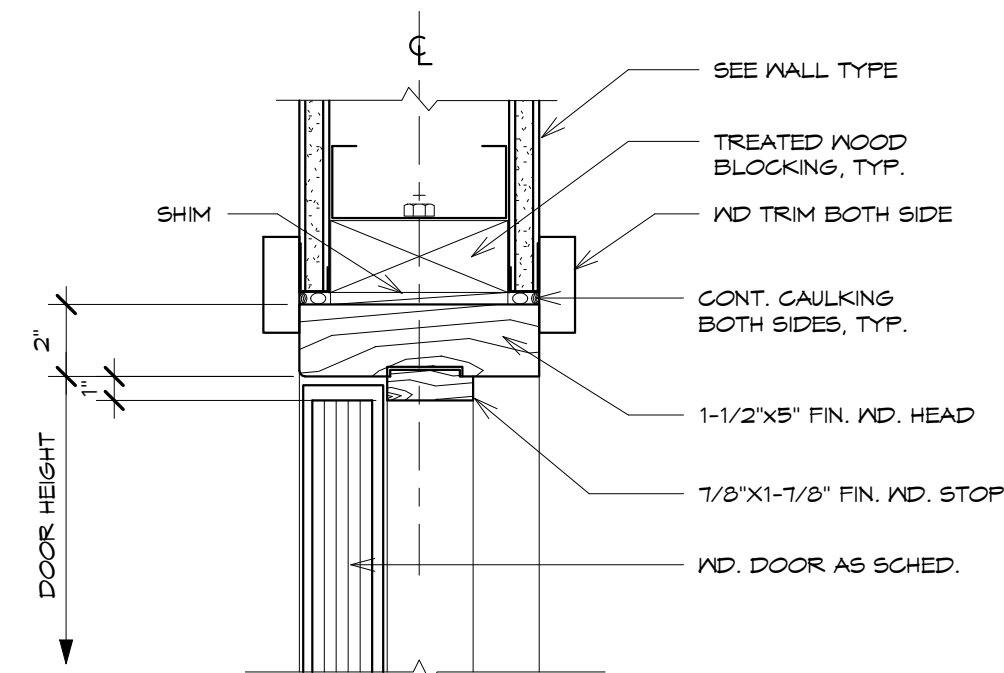

7 WOOD DOOR HEAD, JAMB (SIM.)
SCALE: 3" = 1'-0"

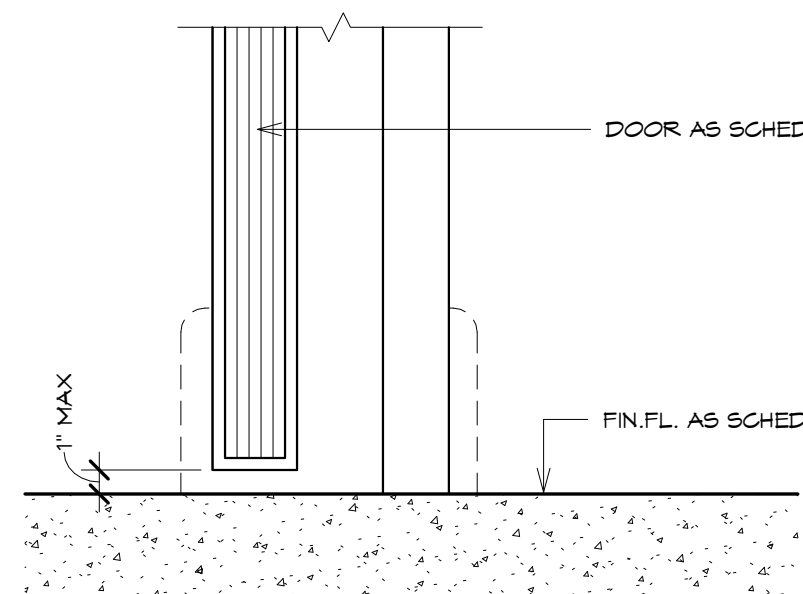

8 SILL
SCALE: 3" = 1'-0"

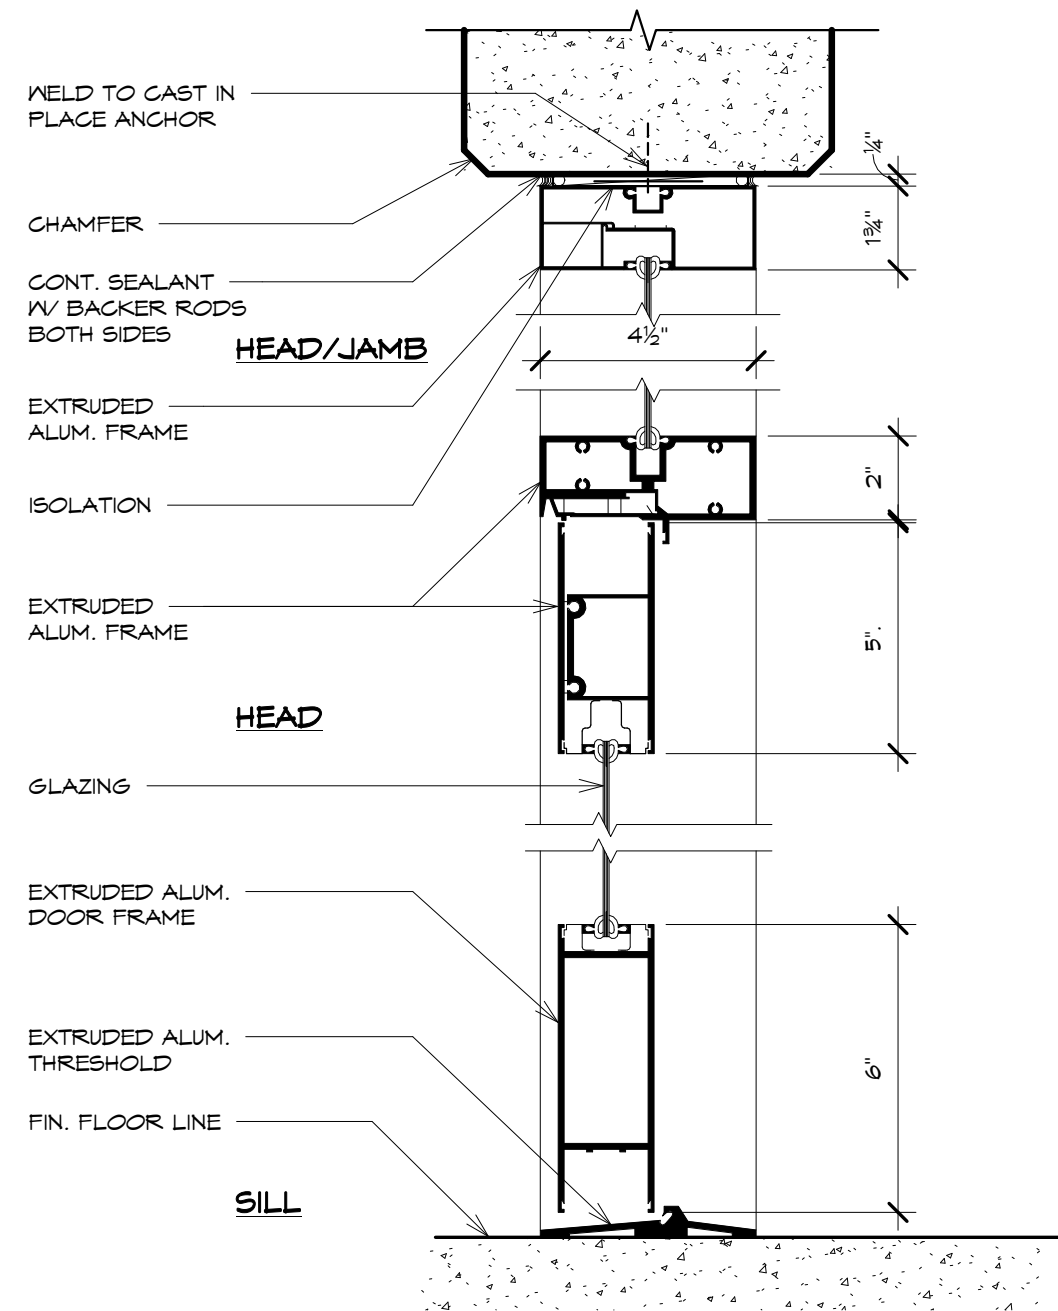

9 DOOR HEAD/JAMB/THRESHOLD GLAZING W/TRANSOM
SCALE: 3" = 1'-0"

REVISIONS		
No.	Description	Date

TRMA
Taniguchi Ruth Makio Architects
100 Cliff Business Center, P.O. Box EA, Agaña, GU 96910
Tel.: (671) 475-8772 • Fax: (671) 472-3381

Architecture
Planning
Interior Design

BID
DOCUMENTS



I HEREBY CERTIFY THAT THIS PLAN WAS PREPARED
BY ME OR UNDER MY DIRECT SUPERVISION
DATE: _____


Project:
GUAM COMMUNITY
COLLEGE
FORENSIC DNA LAB

Title:
DOOR DETAILS

Designed: TRMA
Drawn: RM/TP
Checked: CTC
Supv: MM
Scale: 3" = 1'-0"
Date: 12/17/12
Project No. 1026
Drawing No.


A10.1
Sheet No. _____ of _____

IF SHEET IS LESS THAN 24" X 36"
REDUCED PRINT - USE GRAPHIC SCALES

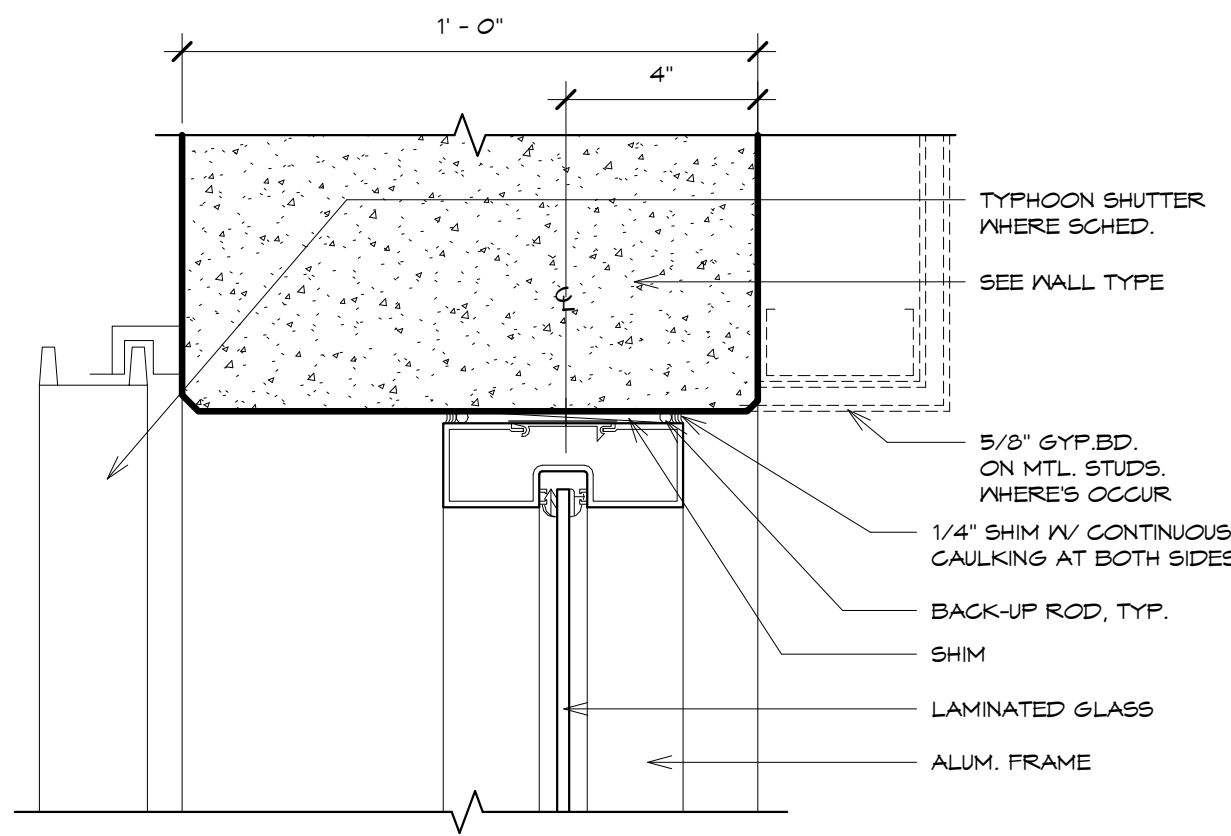


1 WINDOW HEAD/JAMB (FIXED)

SCALE: 3" = 1'-0"

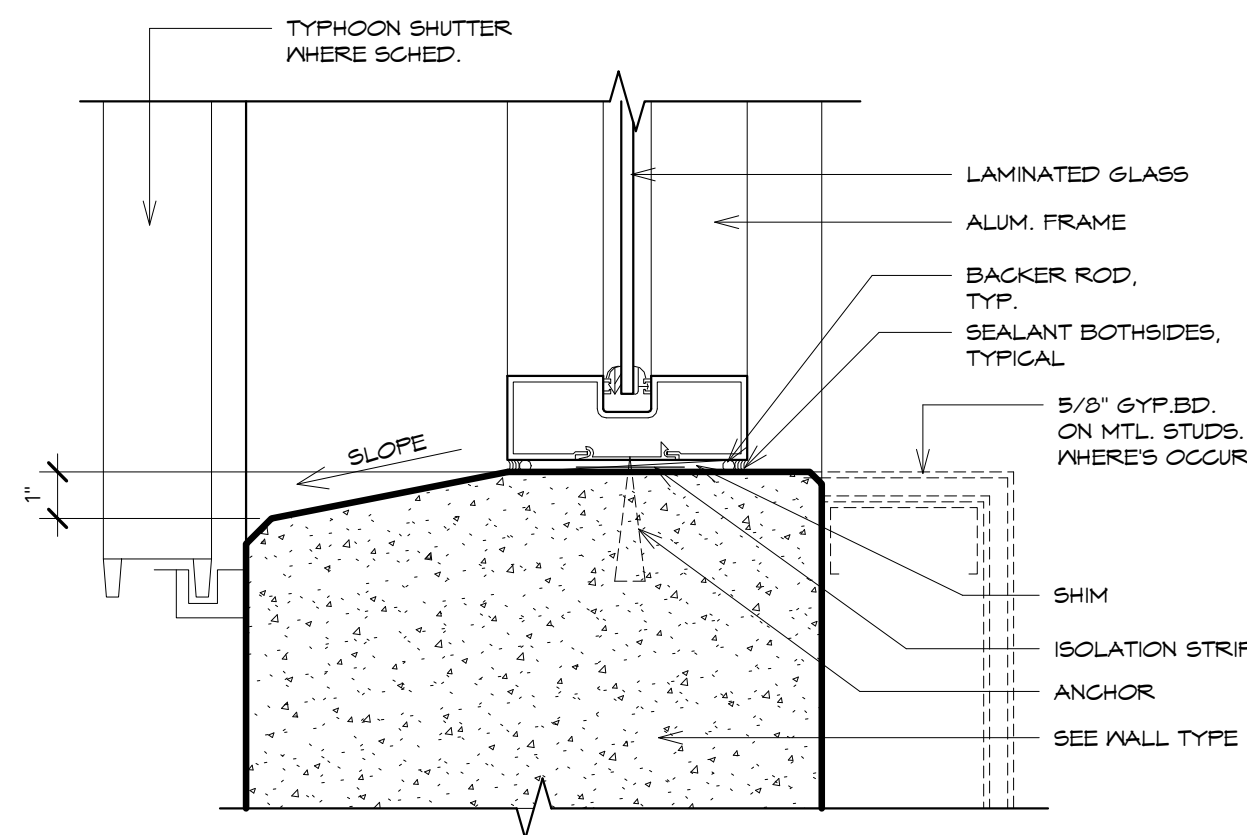


2 WINDOW SILL (FIXED)

SCALE: 3" = 1'-0"

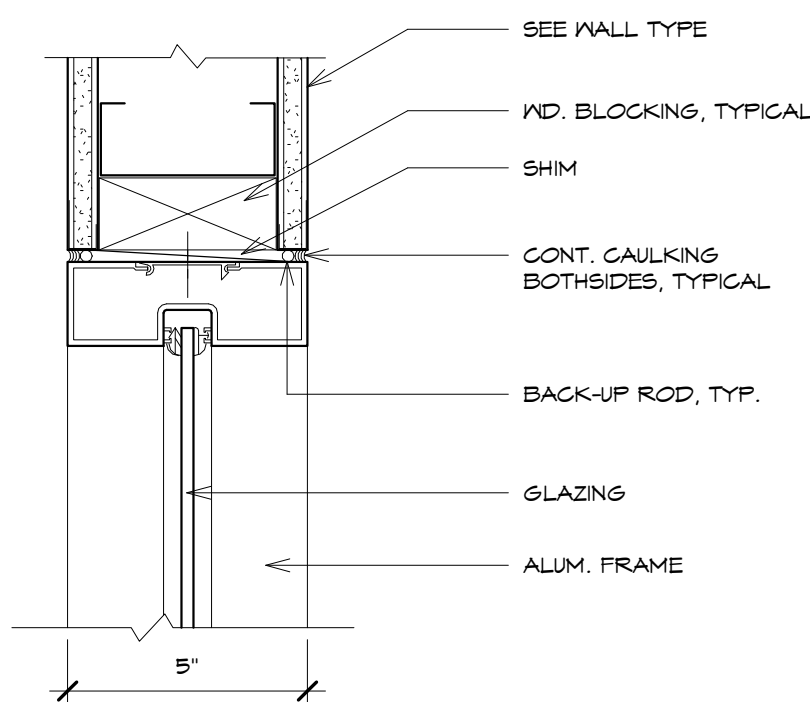


3 WINDOW HEAD GYP

SCALE: 3" = 1'-0"

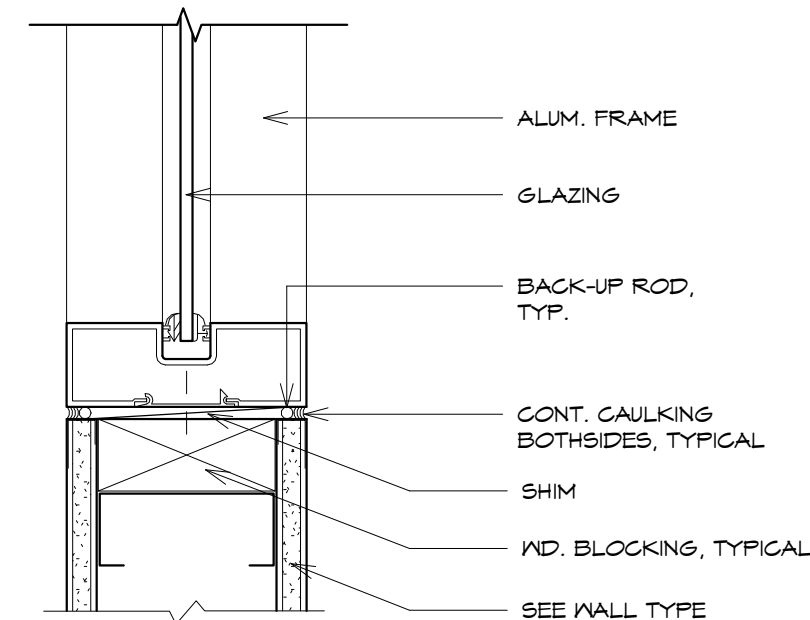


4 WINDOW SILL GYP

SCALE: 3" = 1'-0"

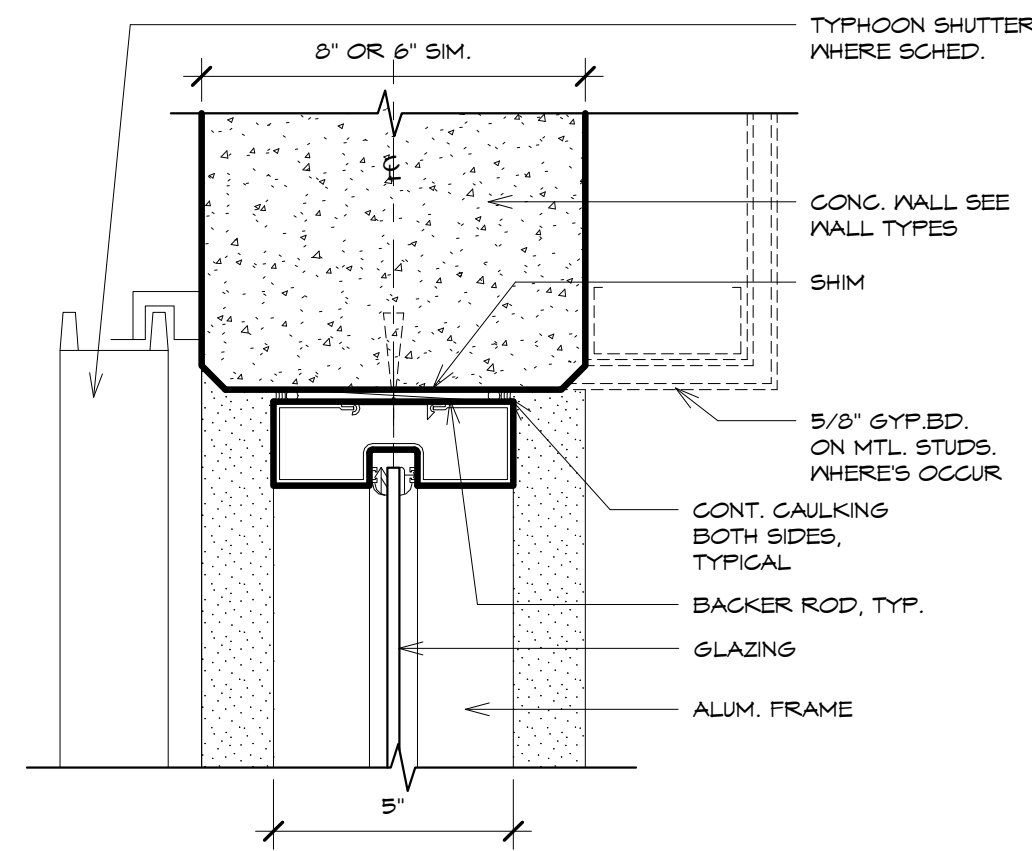


5 WINDOW HEAD/JAMB SIM.

SCALE: 3" = 1'-0"

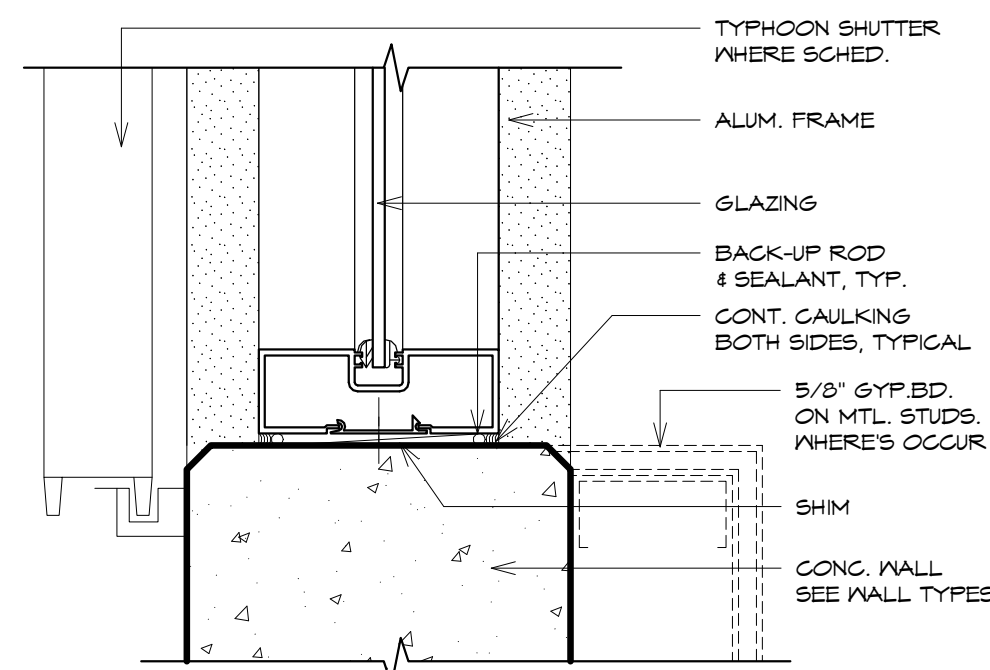


6 WINDOW SILL

SCALE: 3" = 1'-0"

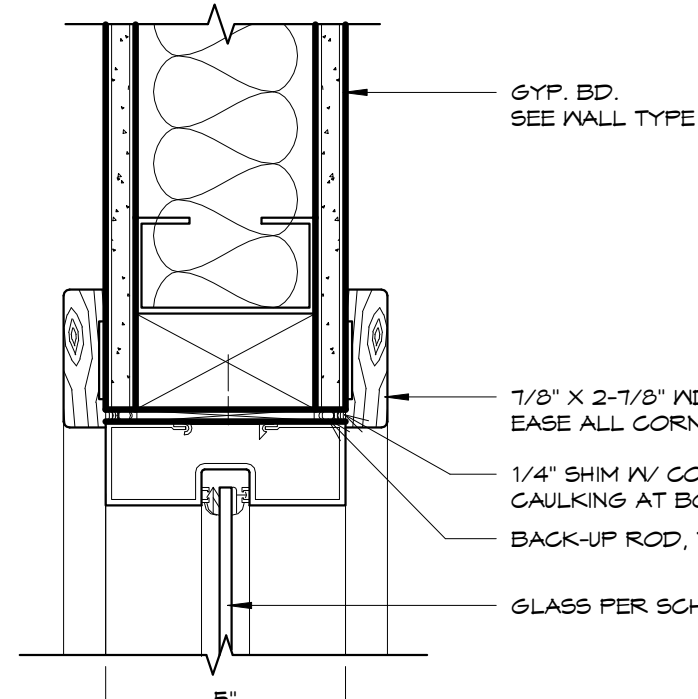


7 WINDOW HEAD/JAMB SIM.(service)

SCALE: 3" = 1'-0"

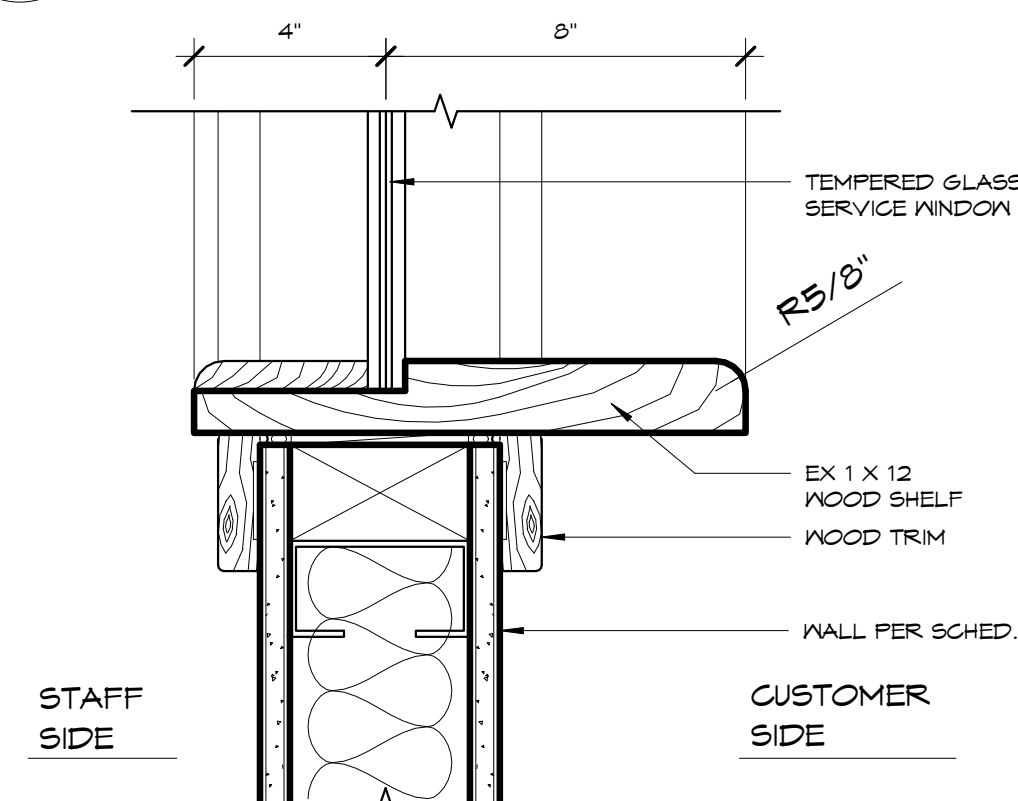


8 WINDOW SILL (service)

SCALE: 3" = 1'-0"

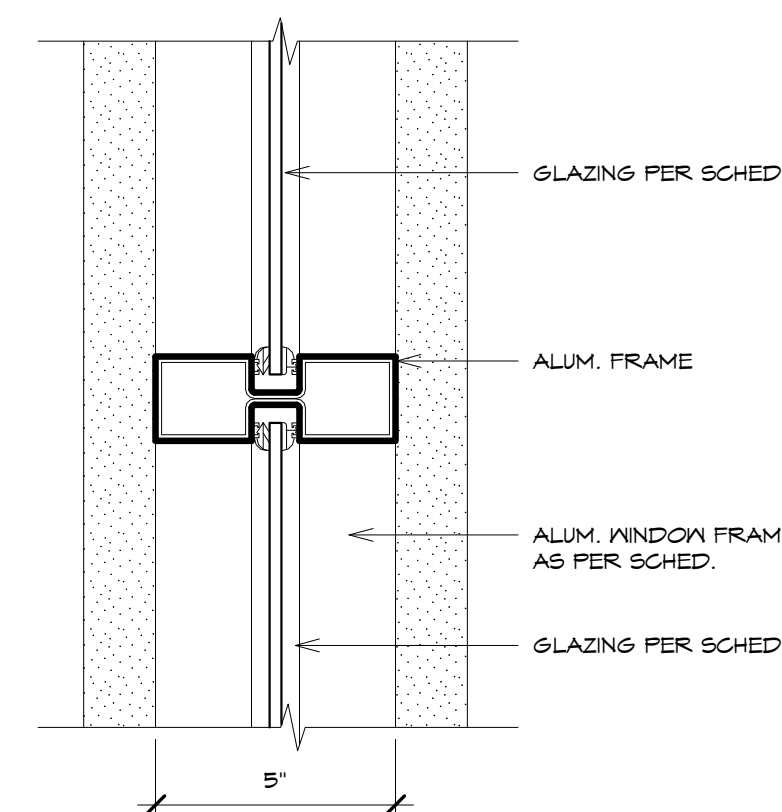


9 INTERMEDIATE MULLION/MUNTIN

SCALE: 3" = 1'-0"

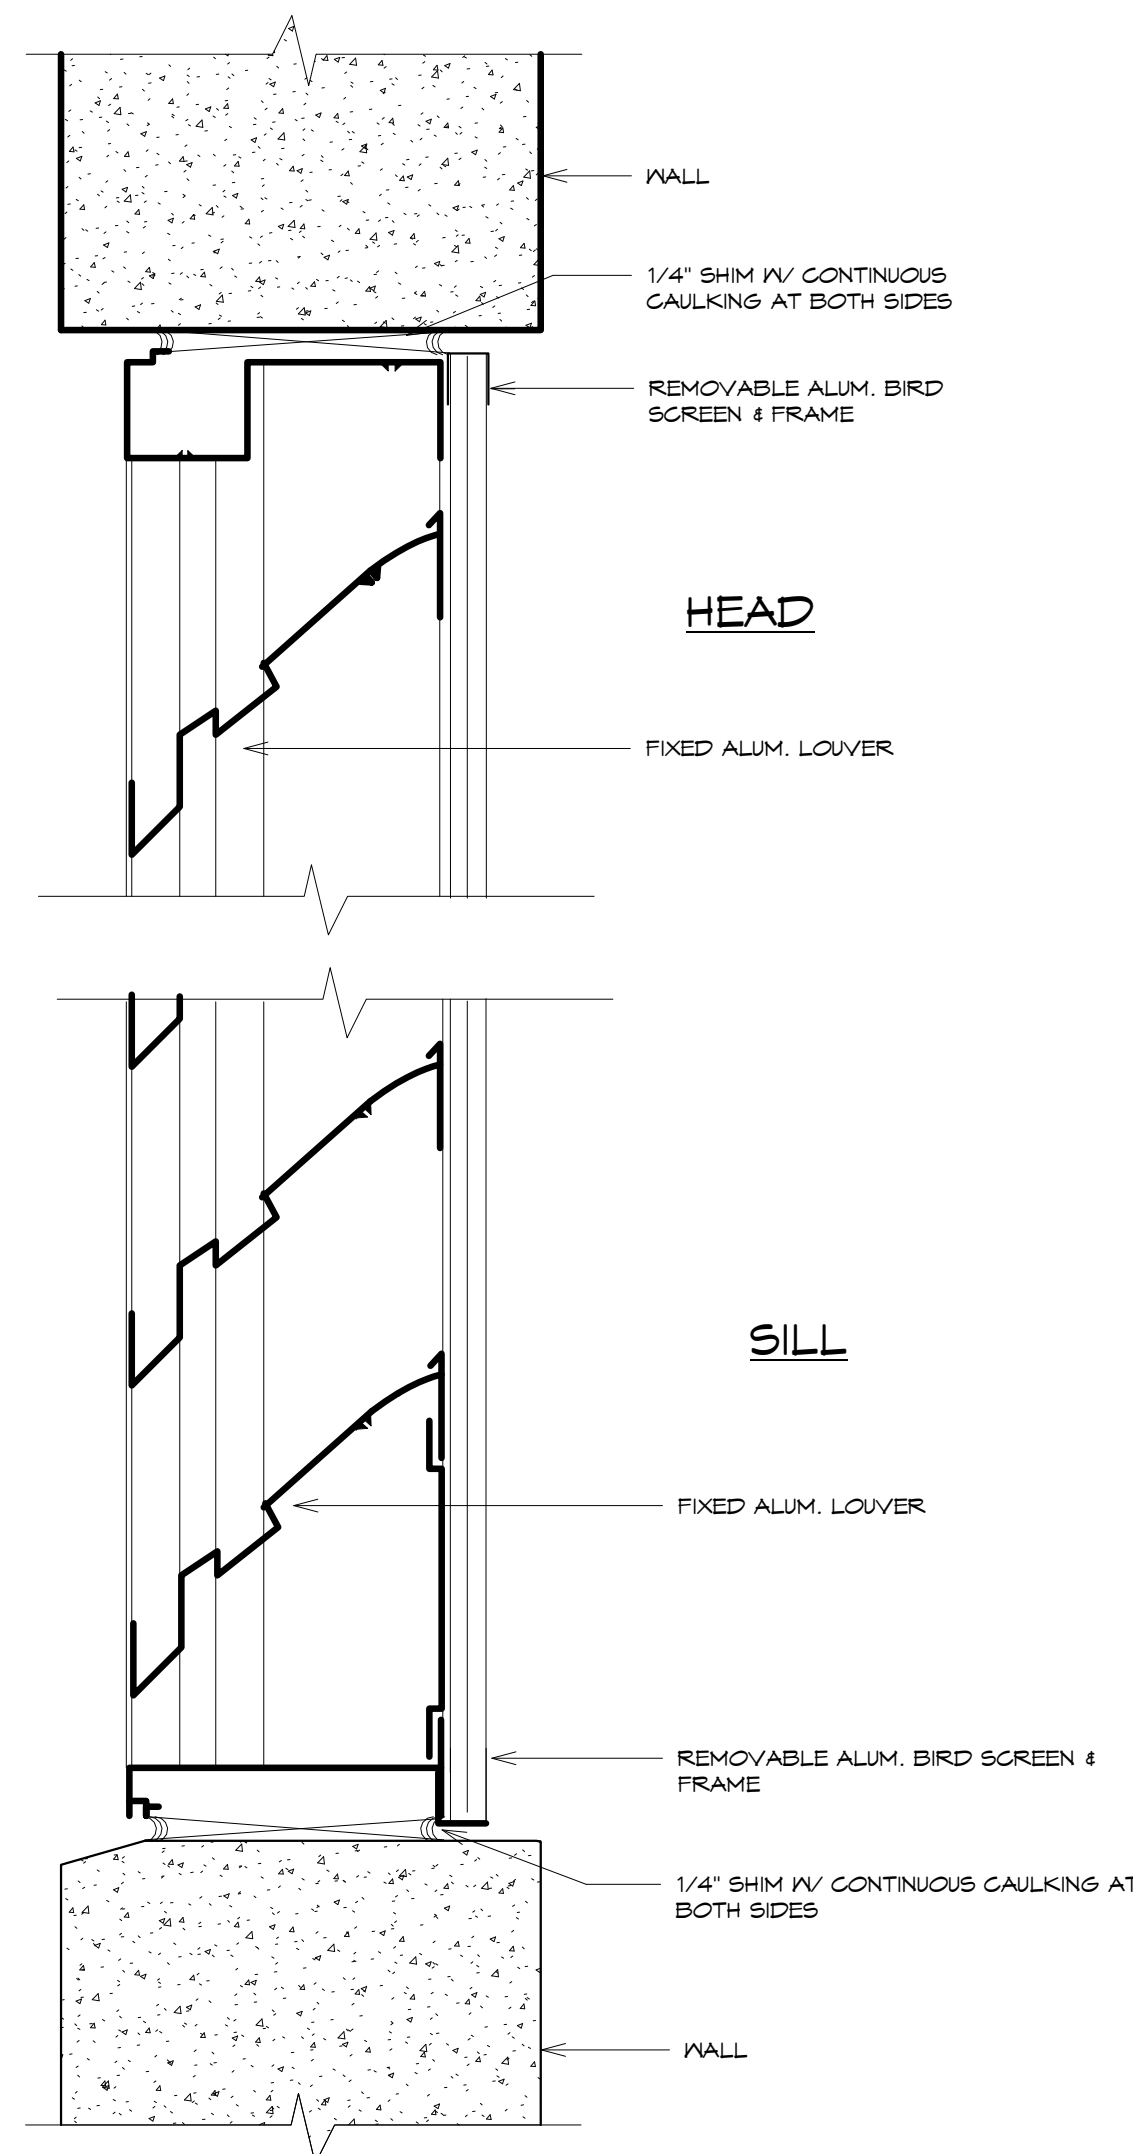


10 LOUVER DETAIL

SCALE: 3" = 1'-0"

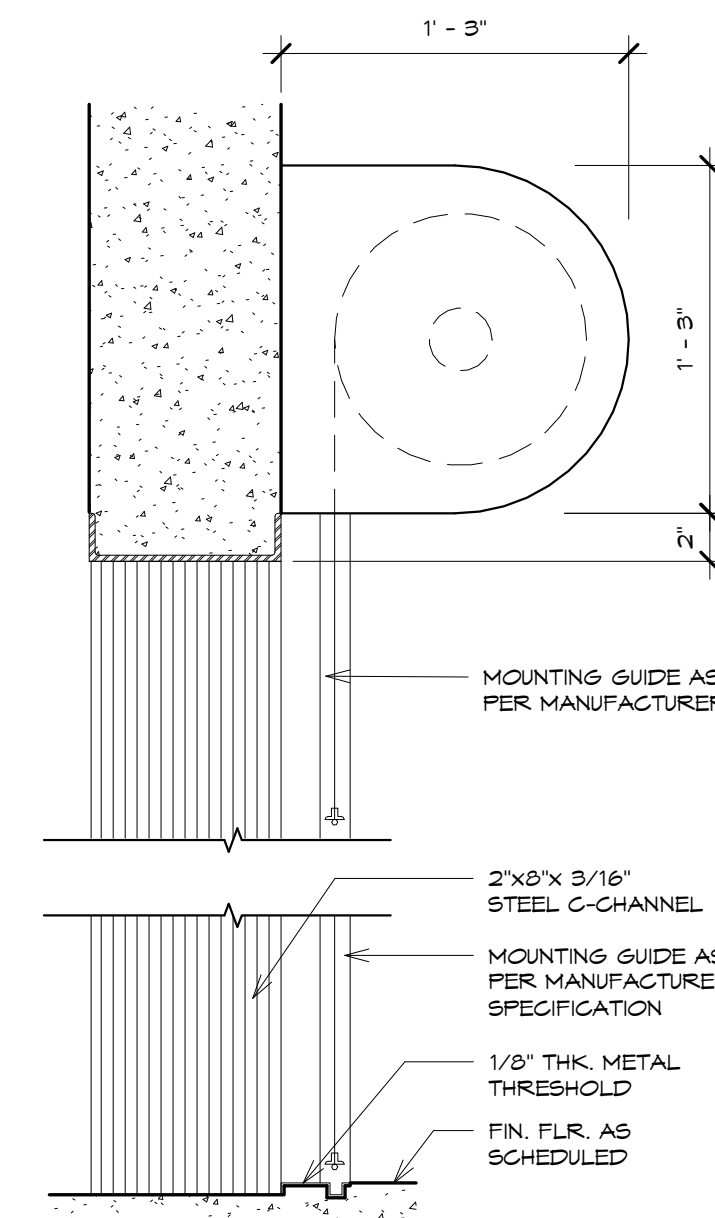

11 ROLL UP GRILL HEAD/SILL

SCALE: 1 1/2" = 1'-0"

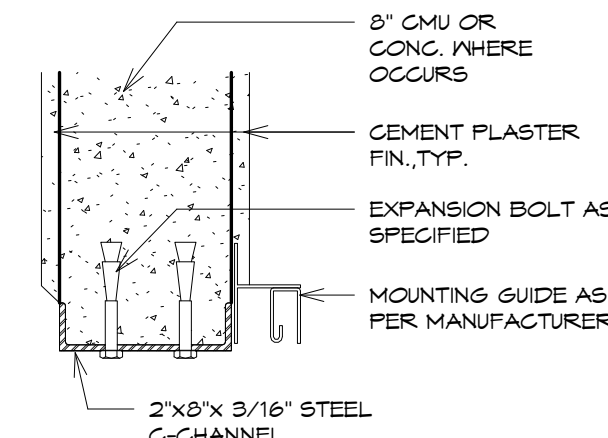


12 ROLL UP GRILL JAMB

SCALE: 1 1/2" = 1'-0"


REVISIONS		
No.	Description	Date
TRMA Taniguchi Ruth Makio Architects 100 Cliff Business Center, P.O. Box EA, Agaña, GU 96910 Tel.: (671) 475-8772 • Fax: (671) 472-3381		
Architecture Planning Interior Design		
BID DOCUMENTS		
 I HEREBY CERTIFY THAT THIS PLAN WAS PREPARED BY ME OR UNDER MY DIRECT SUPERVISION DATE:		
Project: GUAM COMMUNITY COLLEGE FORENSIC DNA LAB		
Title: WINDOW DETAILS		
Designed: TRMA		
Drawn: RM/TP		
Checked: CTC		
Supv: MAM		
Scale: As indicated		
Date: 12/17/12		
Project No. 1026		
Drawing No.		
A10.2		
Sheet No. of		

CEILING DETAILS

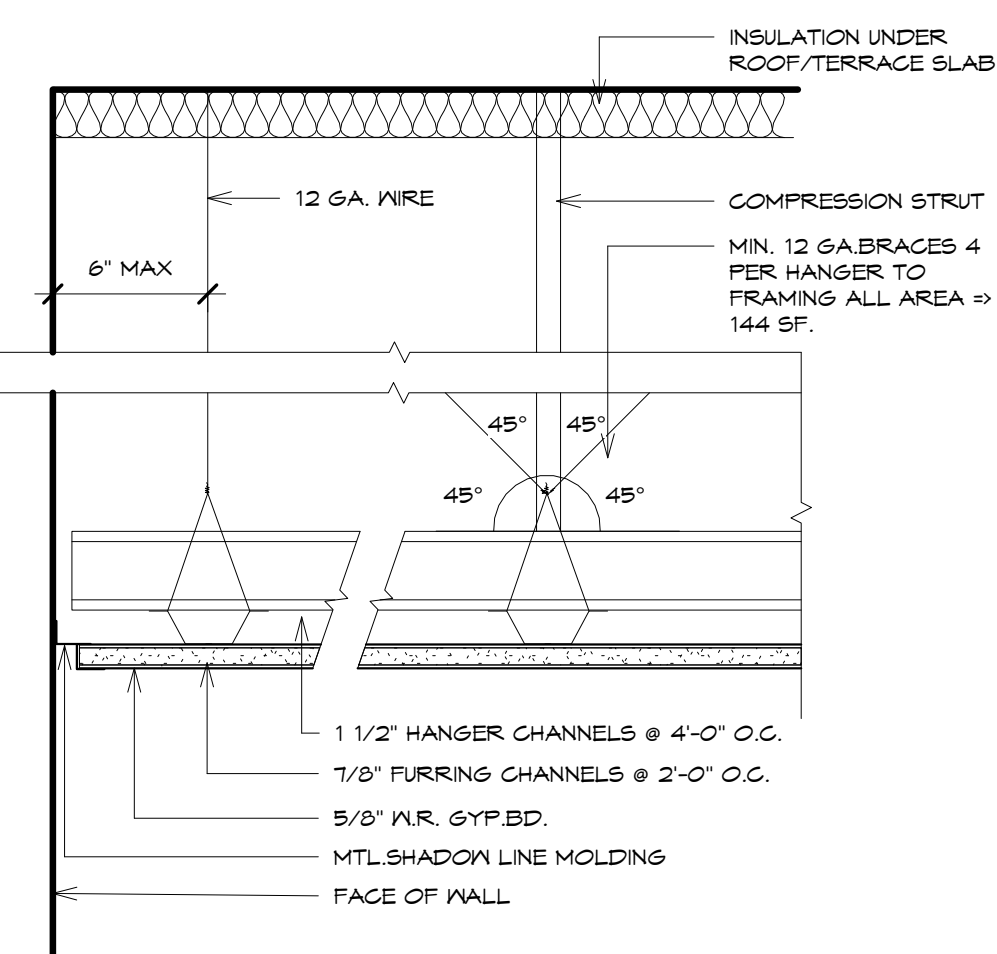


SEISMIC BRACING FOR
SUSPENDED CEILING

1 SCALE: 3" = 1'-0"

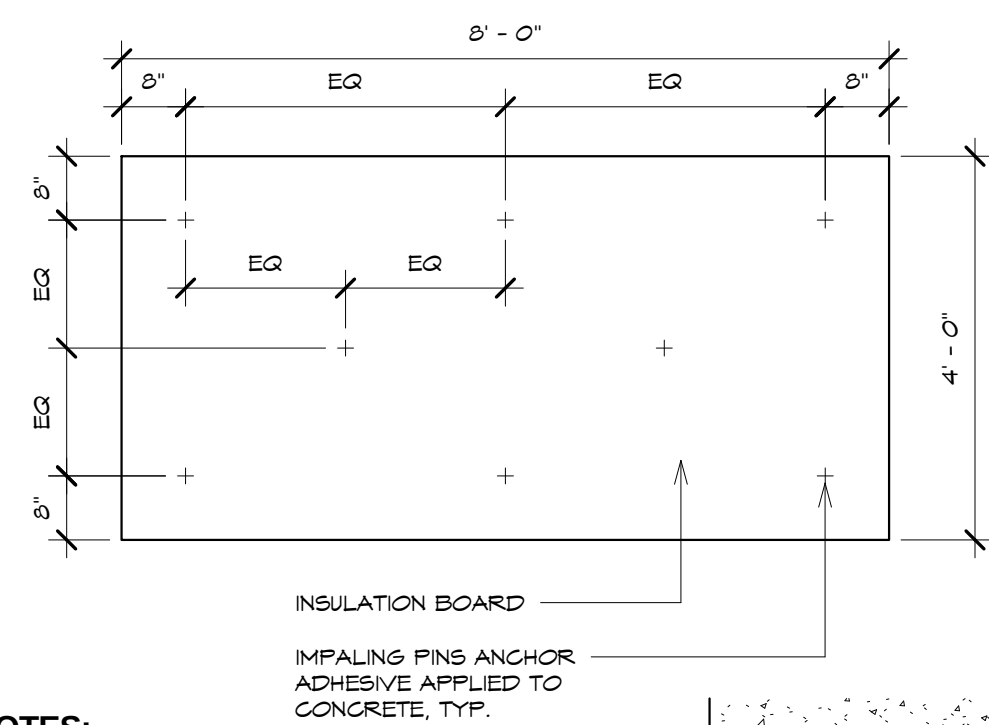


NOTES:

1. FOR ALL SUSPENDED CEILINGS GREATER THAN 144SF, PROVIDE SEISMIC BRACING-DIAGONAL SWAY BRACING AND COMPRESSION BRACING AT APPROXIMATELY 12' O.C. AND 6' FROM WALLS OR EQUIVALENT TO RESIST SEISMIC MOVEMENT. PROVIDE SOFFIT LATERAL BRACING-ALTERNATING AT 4' O.C.
2. METAL FRAMING AT WALLS AND CEILINGS-22 GA.

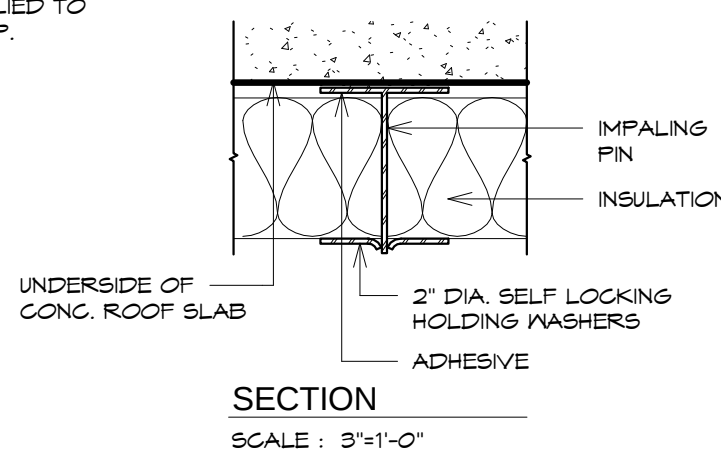


INSULATION

2 SCALE: 1/2" = 1'-0"

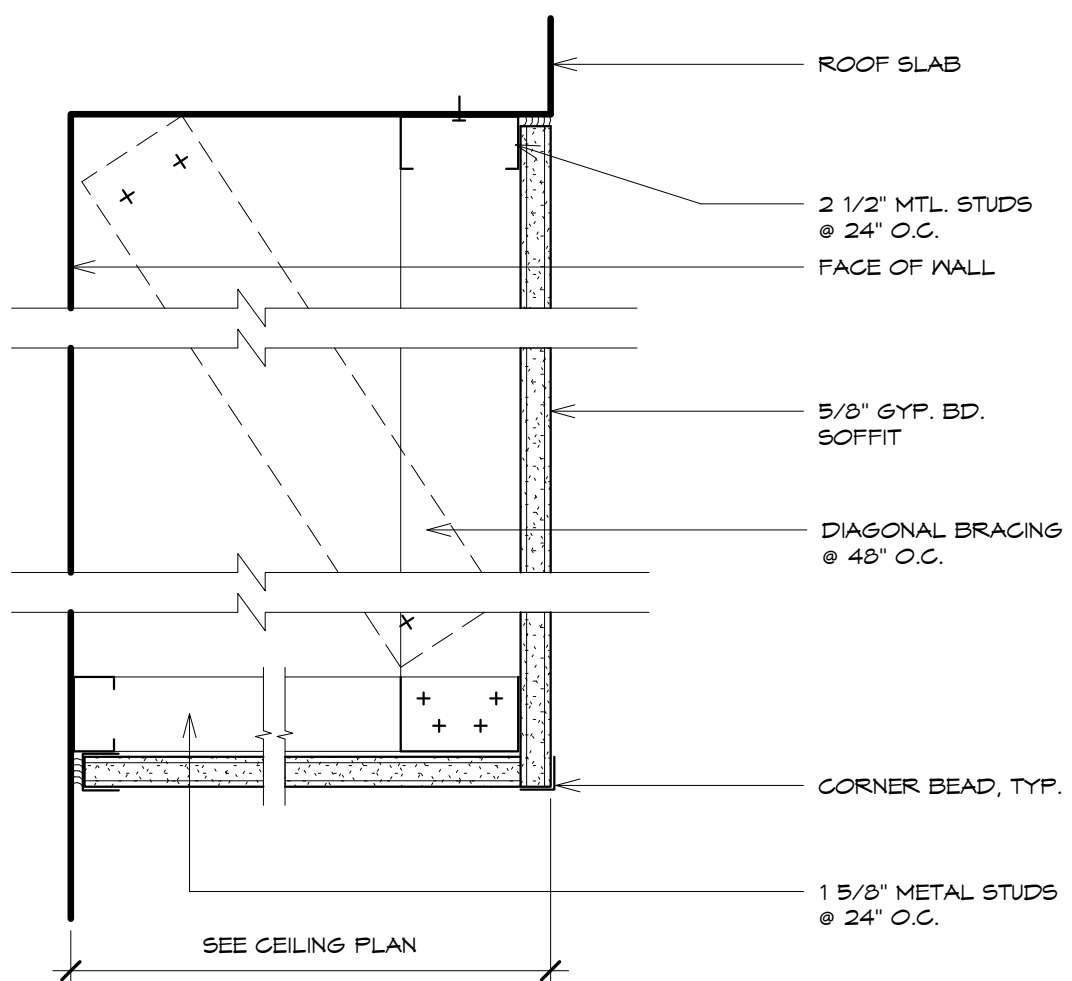


SOFFIT DETAIL

3 SCALE: 3" = 1'-0"

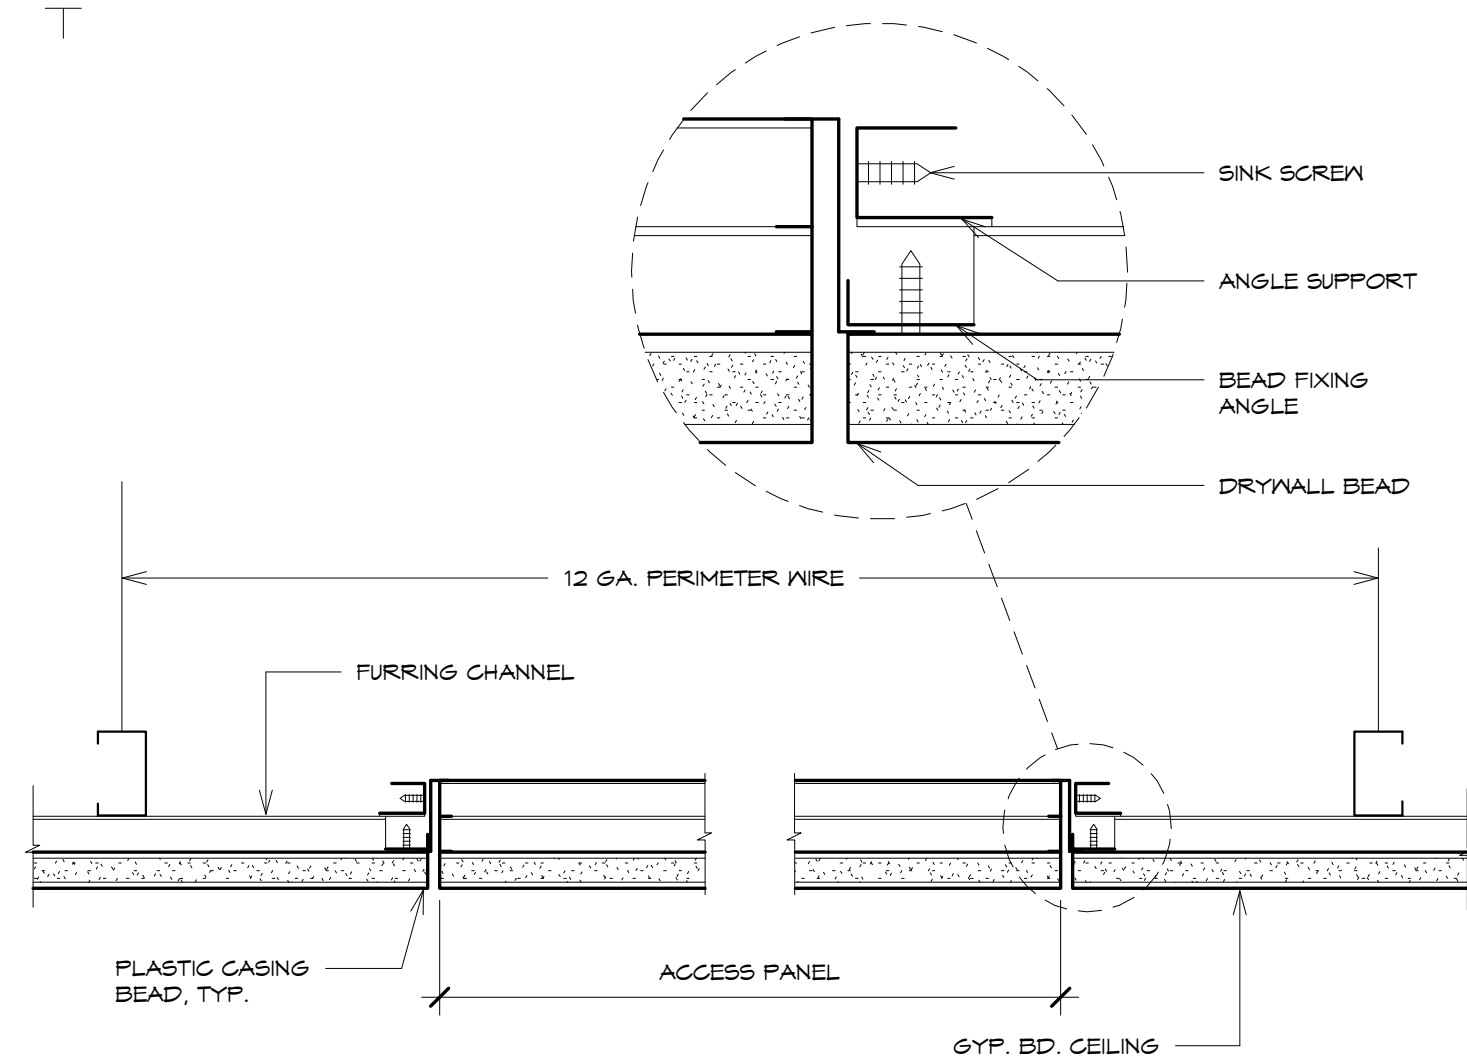


ACCESS PANEL DETAIL

4 SCALE: 3" = 1'-0"

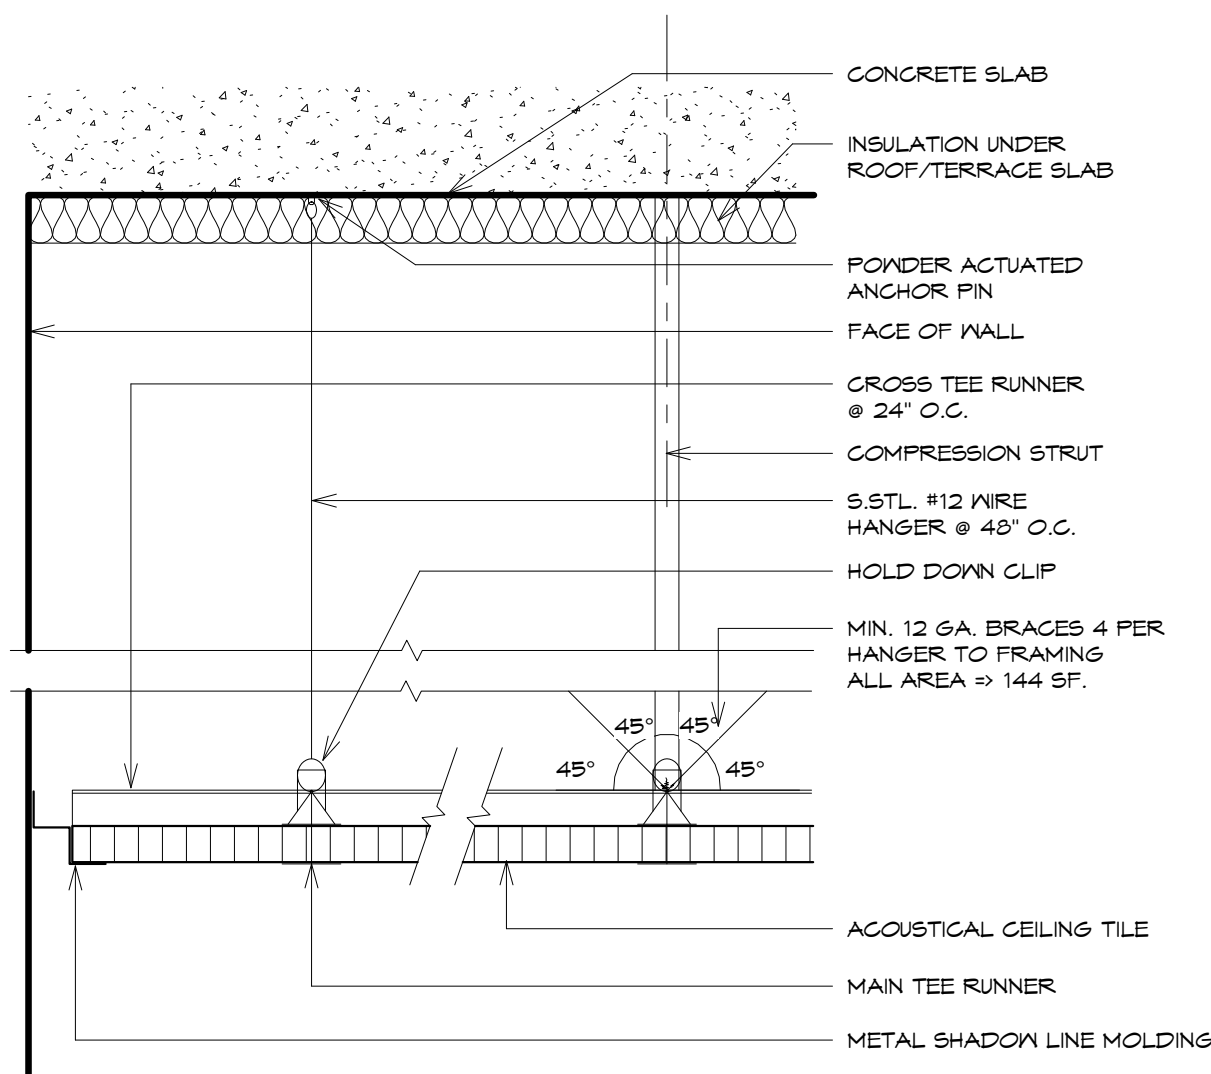


SUSPENDED ACOUSTICAL
CEILING DETAIL

5 SCALE: 3" = 1'-0"

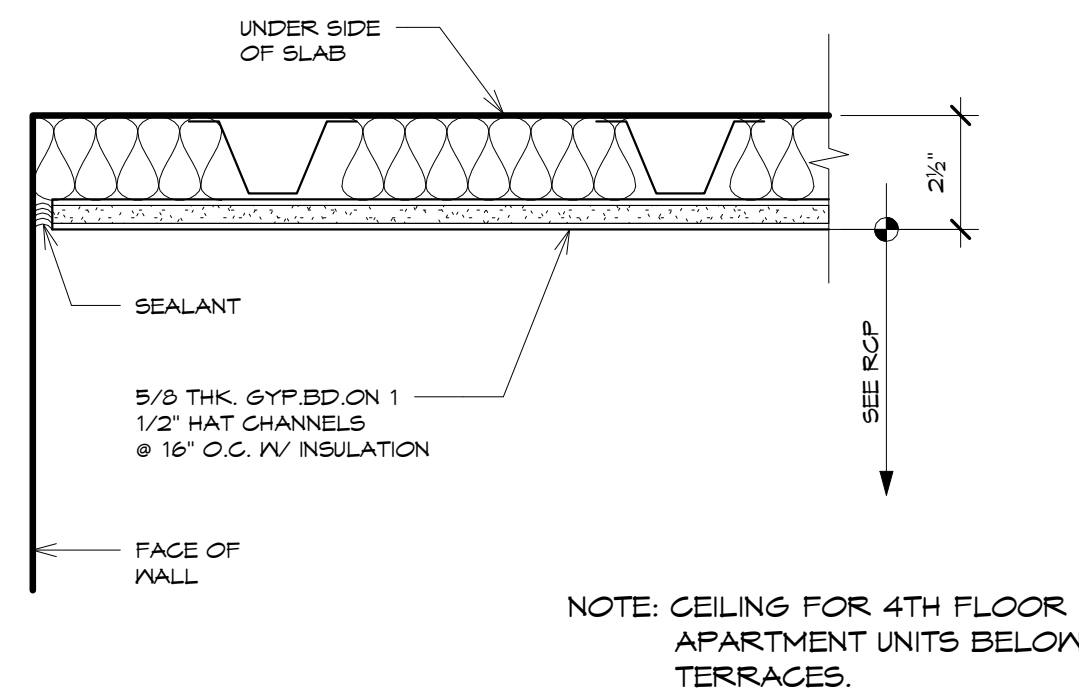


CEILING FURRING DETAIL

6 SCALE: 3" = 1'-0"

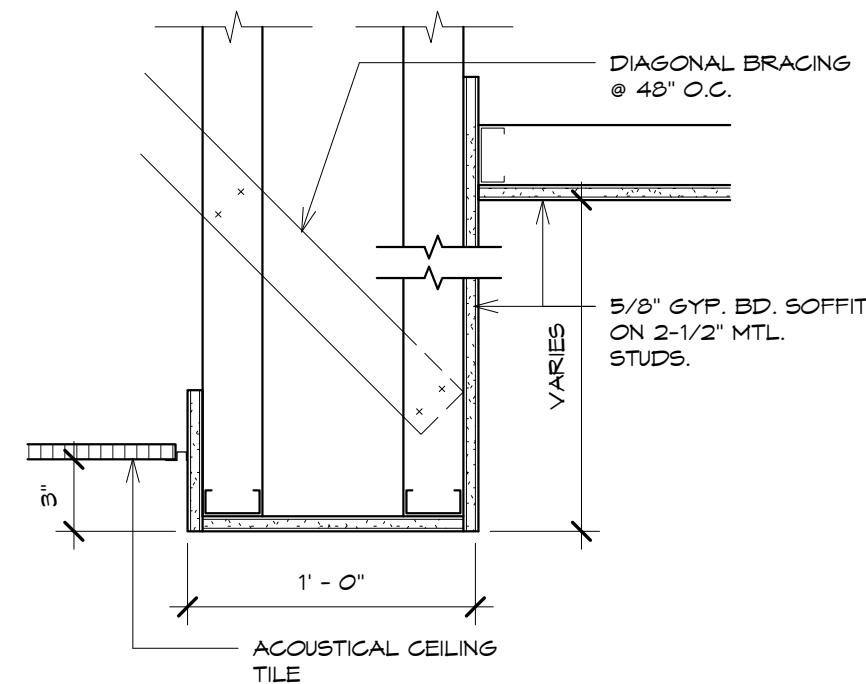

SOFFIT DETAIL

8 SCALE: 1 1/2" = 1'-0"

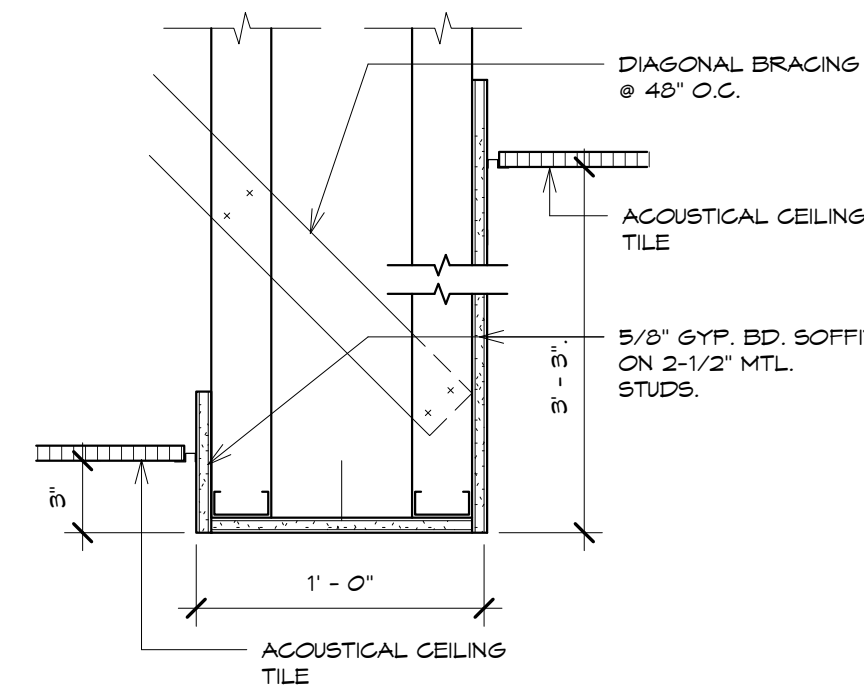

SOFFIT DETAIL

7 SCALE: 1 1/2" = 1'-0"

REVISIONS		
No.	Description	Date
TRMA Taniguchi Ruth Makio Architects 100 Cliff Business Center, P.O. Box EA, Agaña, GU 96910 Tel.: (671) 475-8772 • Fax: (671) 472-3381		
Architecture Planning Interior Design		
BID DOCUMENTS		
 I HEREBY CERTIFY THAT THIS PLAN WAS PREPARED BY ME OR UNDER MY DIRECT SUPERVISION DATE: _____		
Project: GUAM COMMUNITY COLLEGE FORENSIC DNA LAB		
Title: CEILING DETAILS		
Designed: TRMA Drawn: RM/TP Checked: CTC Supv: MAM Scale: As indicated Date: 12/17/12 Project No. 1026 Drawing No.		
A10.3 Sheet No. _____ of _____		

IF SHEET IS LESS THAN 24" X 36"
REDUCED PRINT - USE GRAPHIC SCALES

REVISIONS		
No.	Description	Date

TRMA

Taniguchi Ruth Makio Architects
 100 Cliff Business Center, P.O. Box EA, Agaña, GU 96910
 Tel.: (671) 475-8772 • Fax: (671) 472-3381

Architecture
 Planning
 Interior Design

BID
 DOCUMENTS



I HEREBY CERTIFY THAT THIS PLAN WAS PREPARED
 BY ME OR UNDER MY DIRECT SUPERVISION







Project:
 GUAM COMMUNITY
 COLLEGE
 FORENSIC DNA LAB

Title:
 WALL DETAILS


Designed: **TRMA**
 Drawn: **RM/TP**
 Checked: **CTC**
 Supv: **MM**
 Scale: **3" = 1'-0"**
 Date: **12/17/12**
 Project No. **1026** File
 Drawing No.

A11.1


Sheet No. _____ of _____

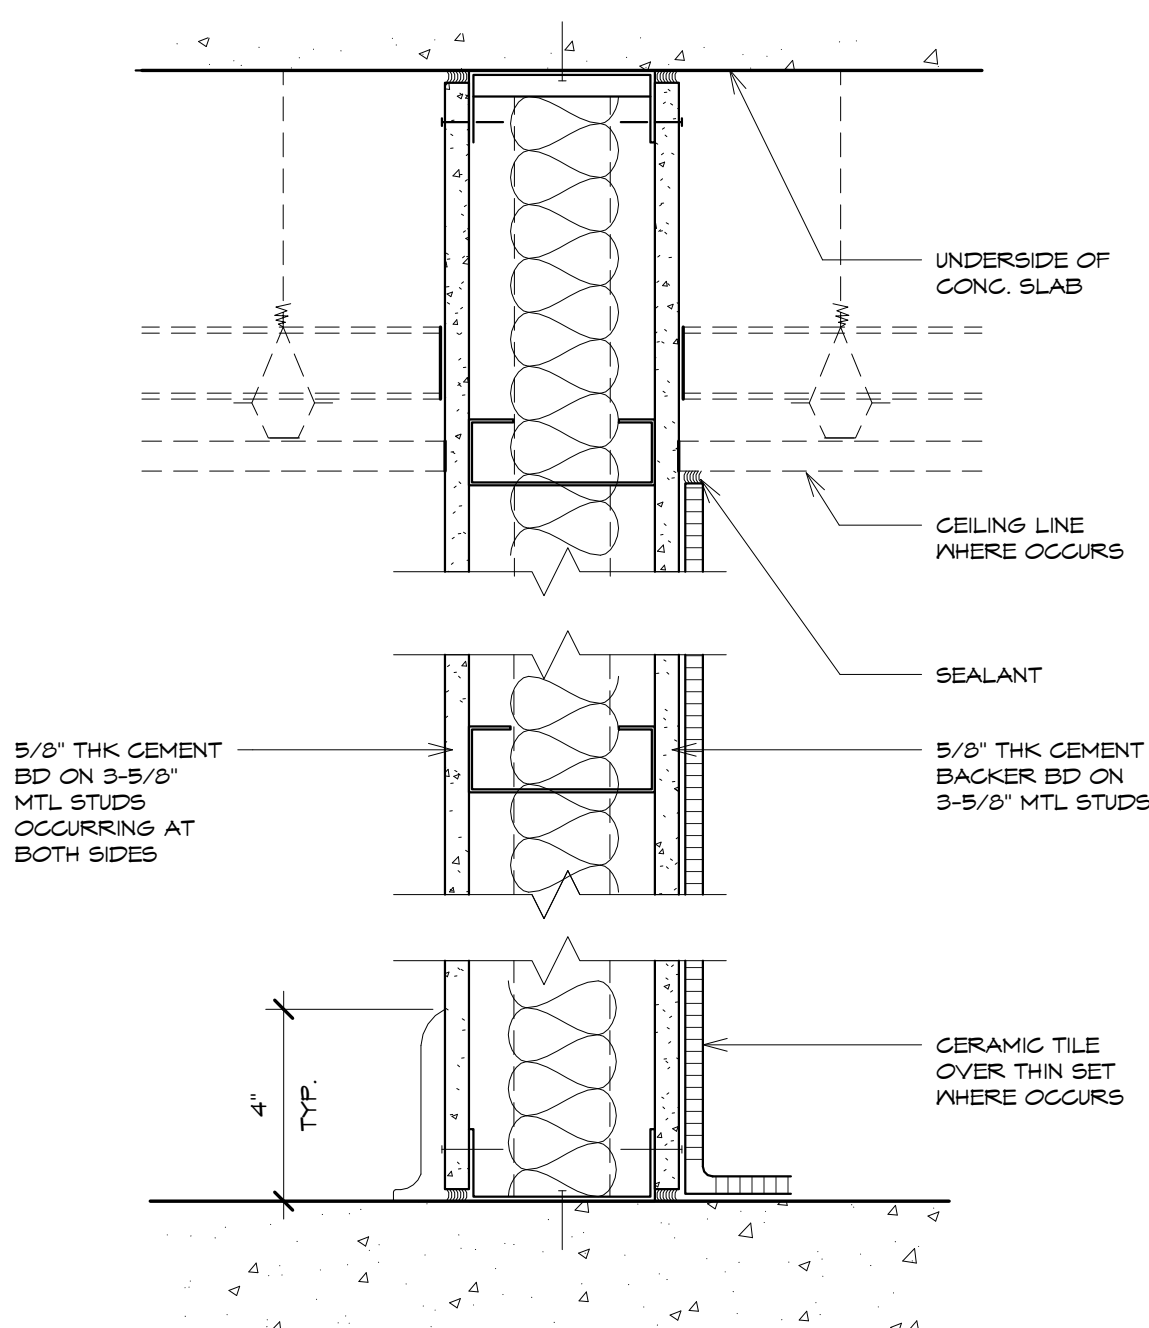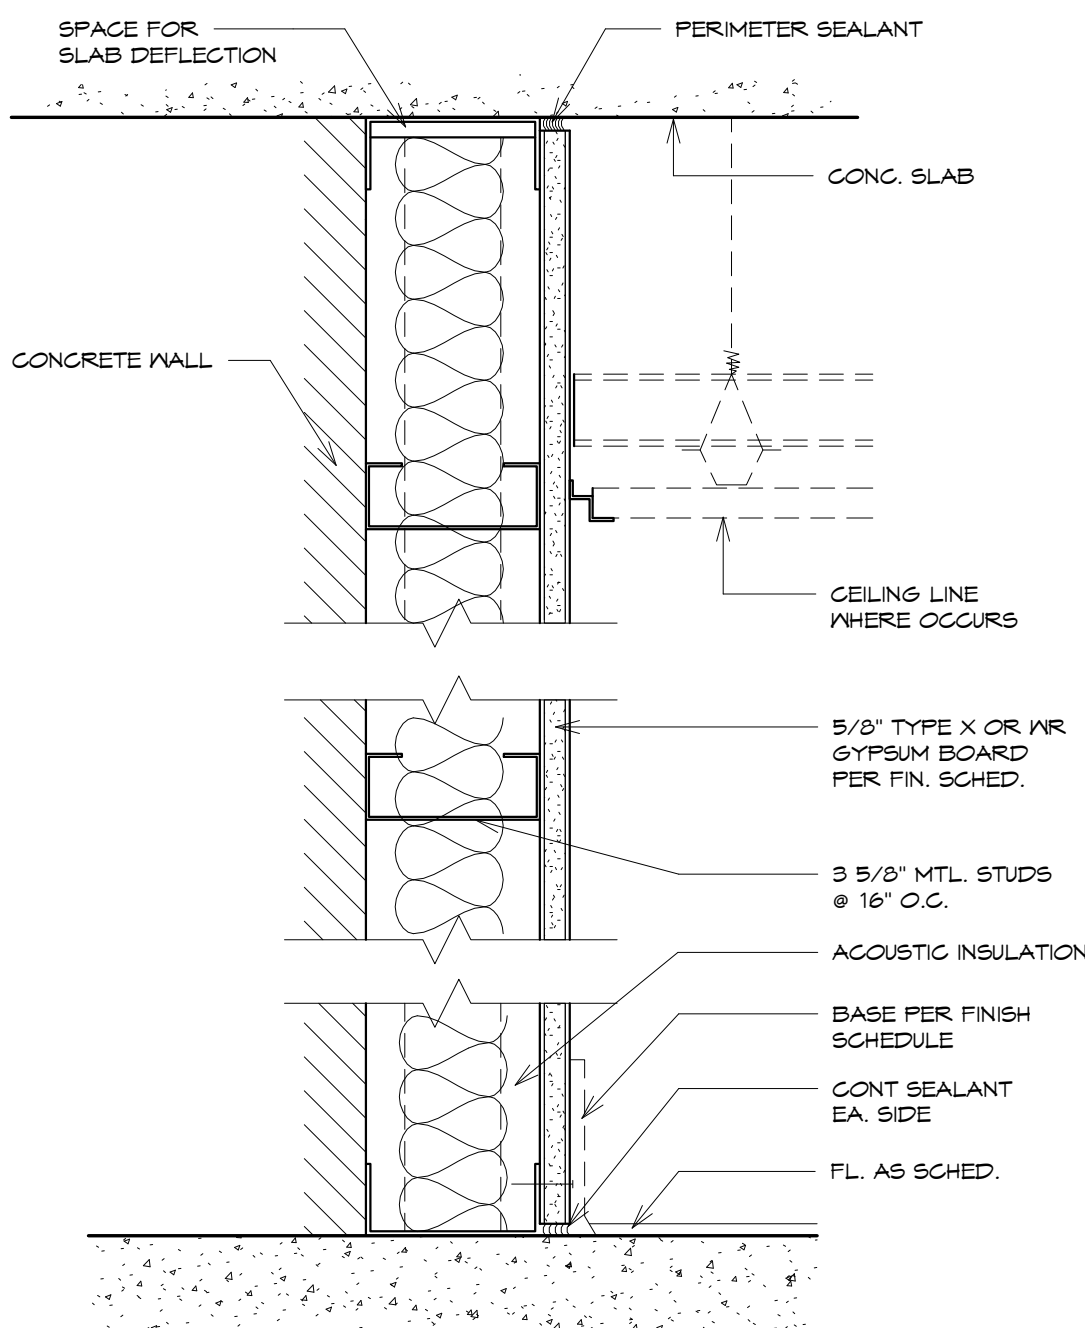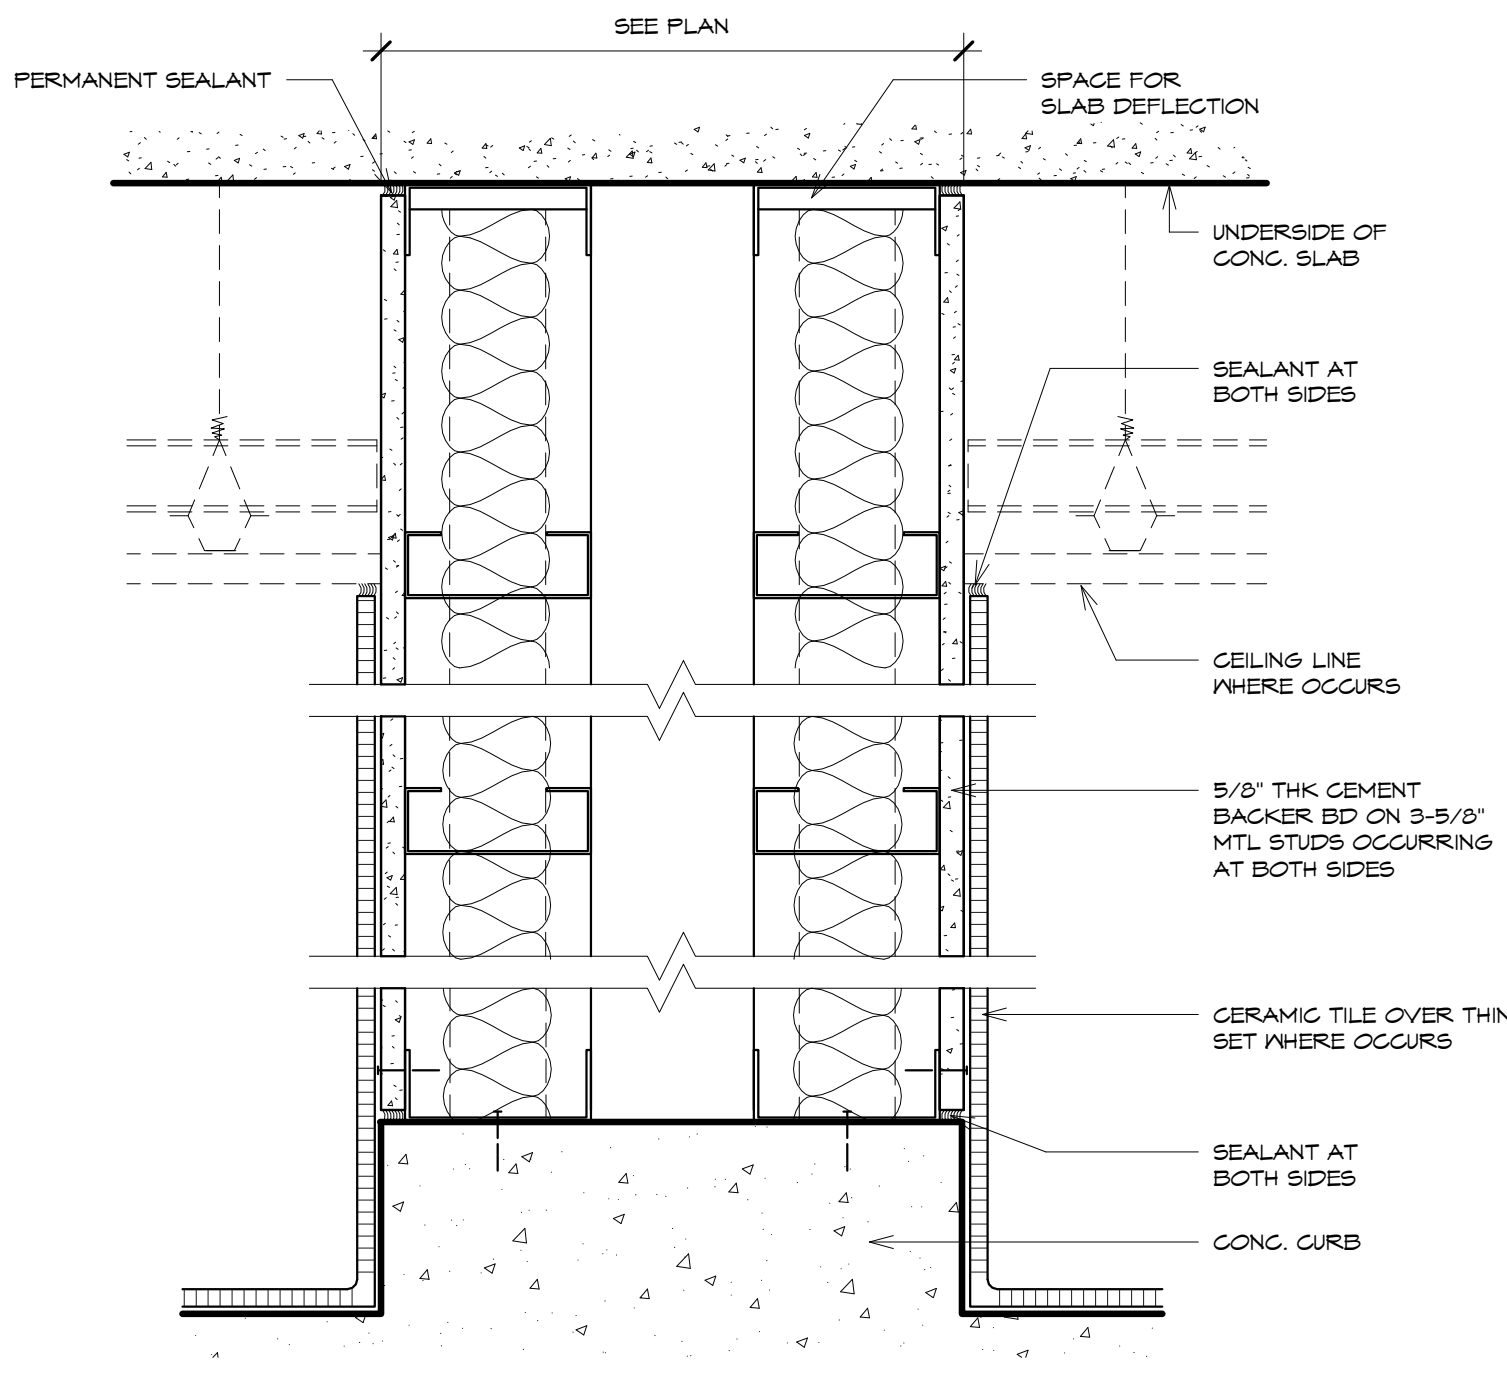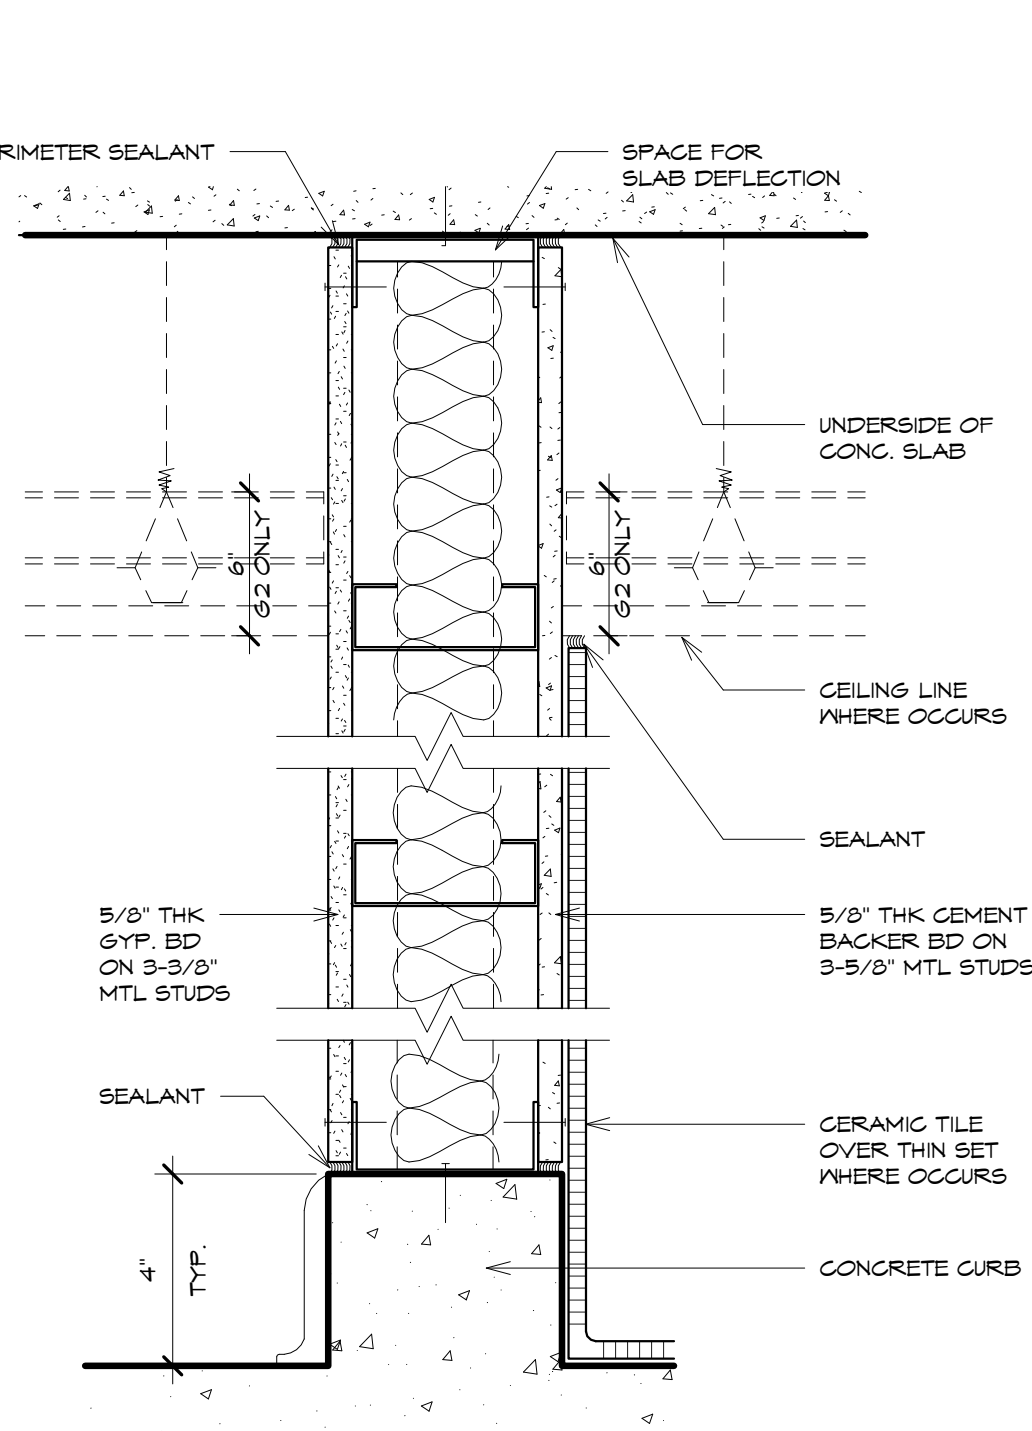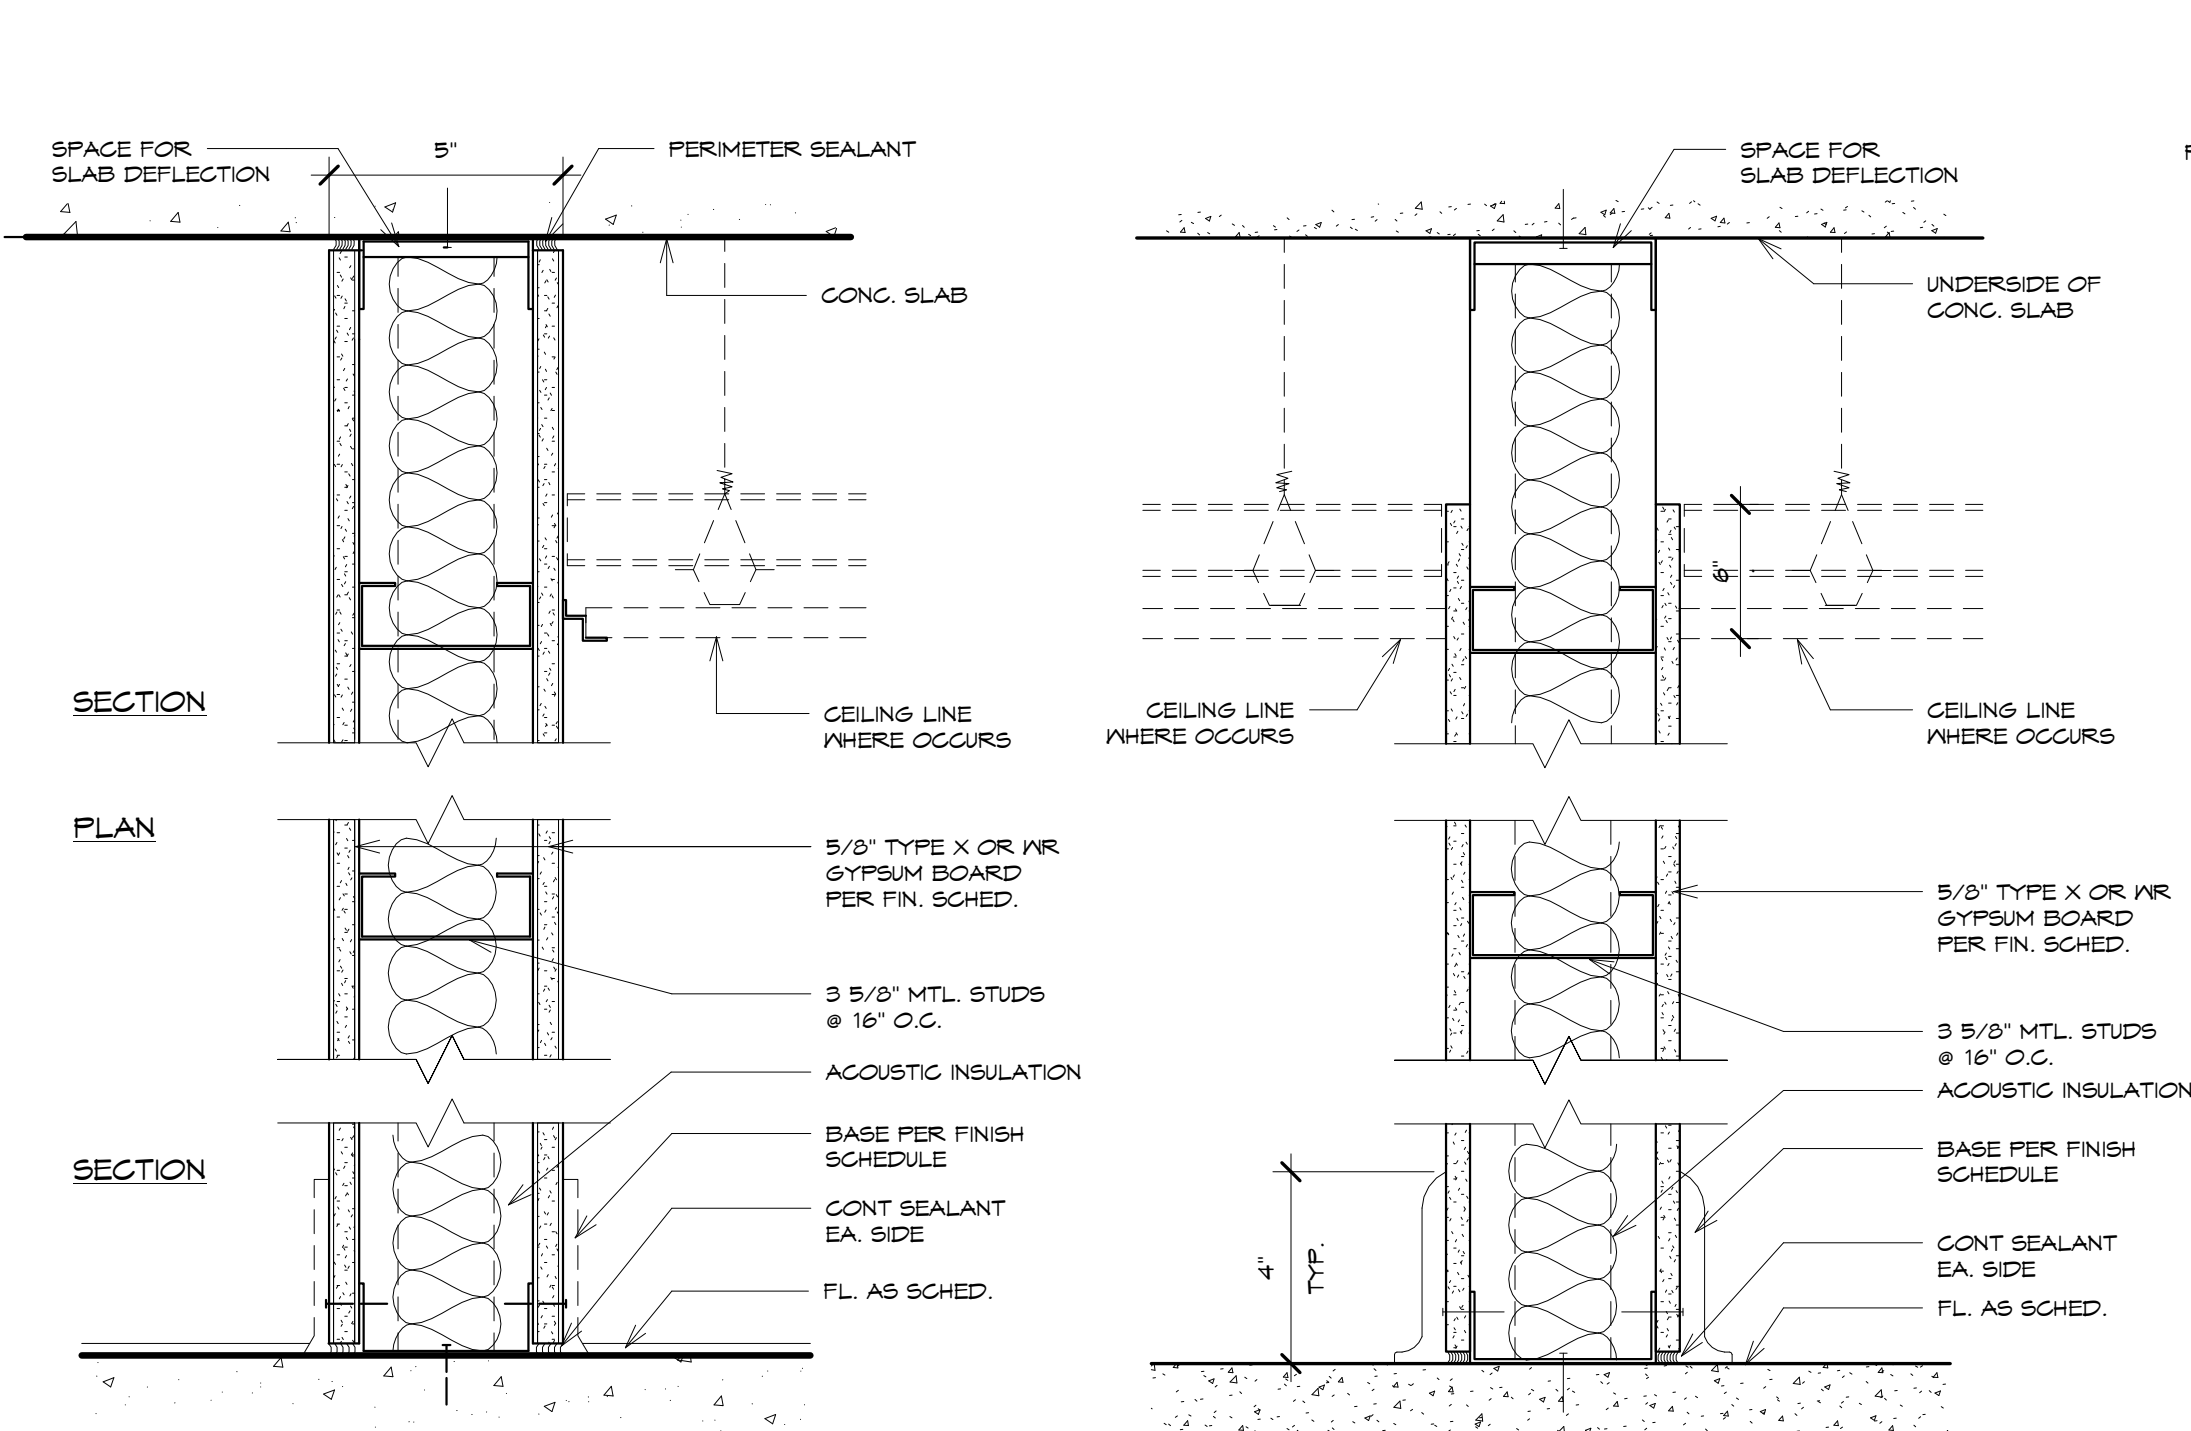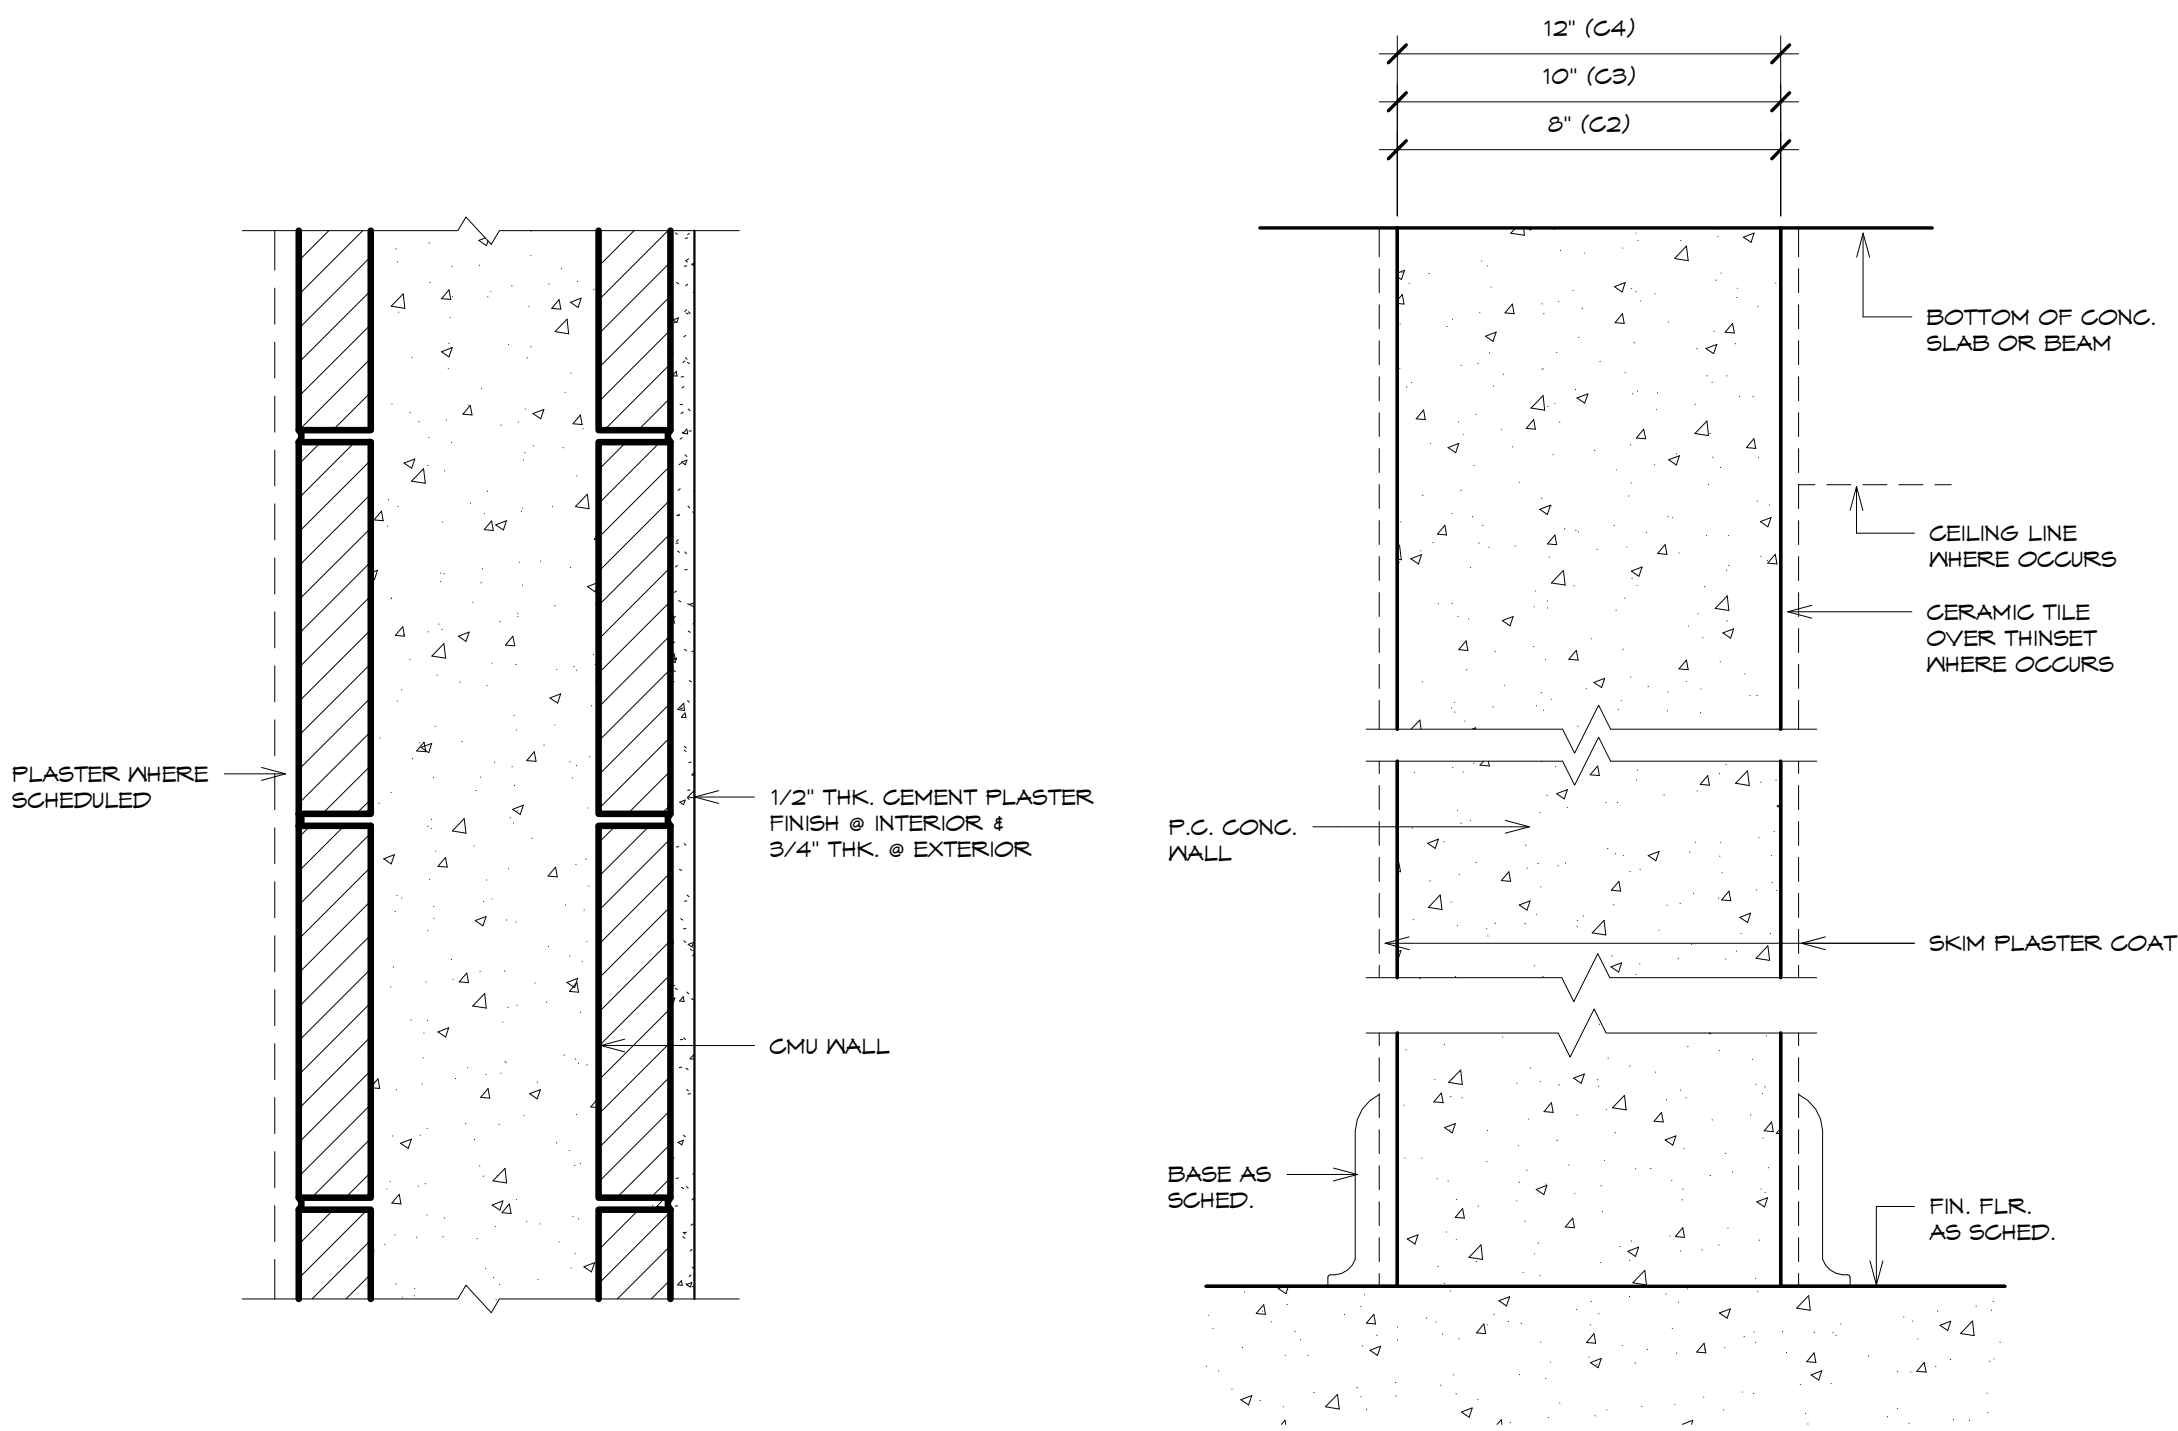


IF SHEET IS LESS THAN 24" X 36"
 REDUCED PRINT - USE GRAPHIC SCALES

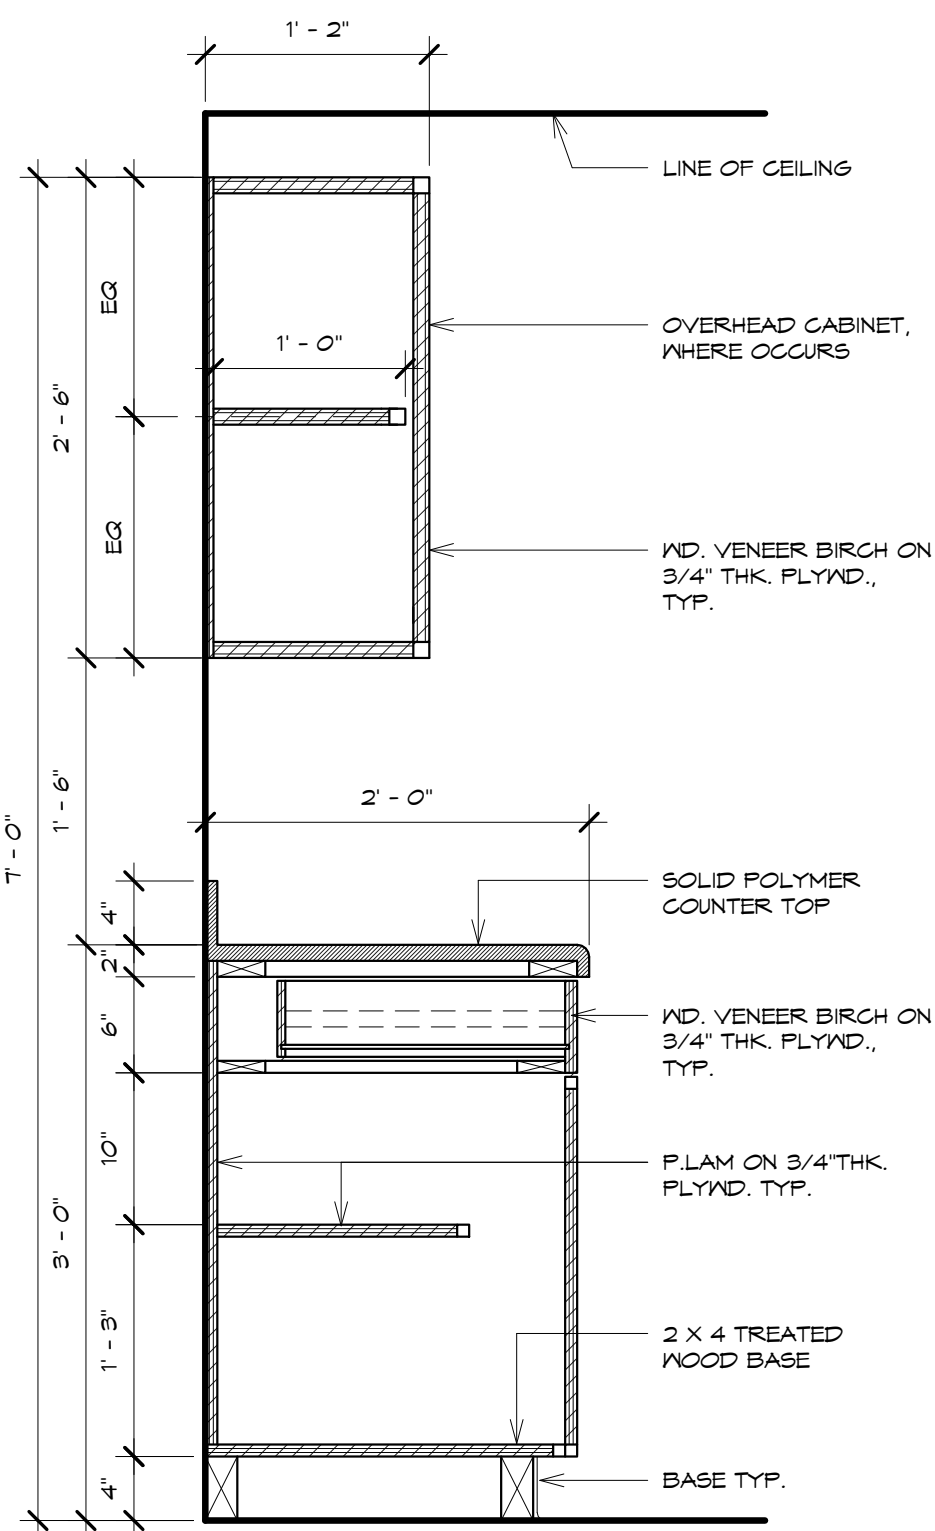


1 CABINET DETAIL
SCALE: 1" = 1'-0"

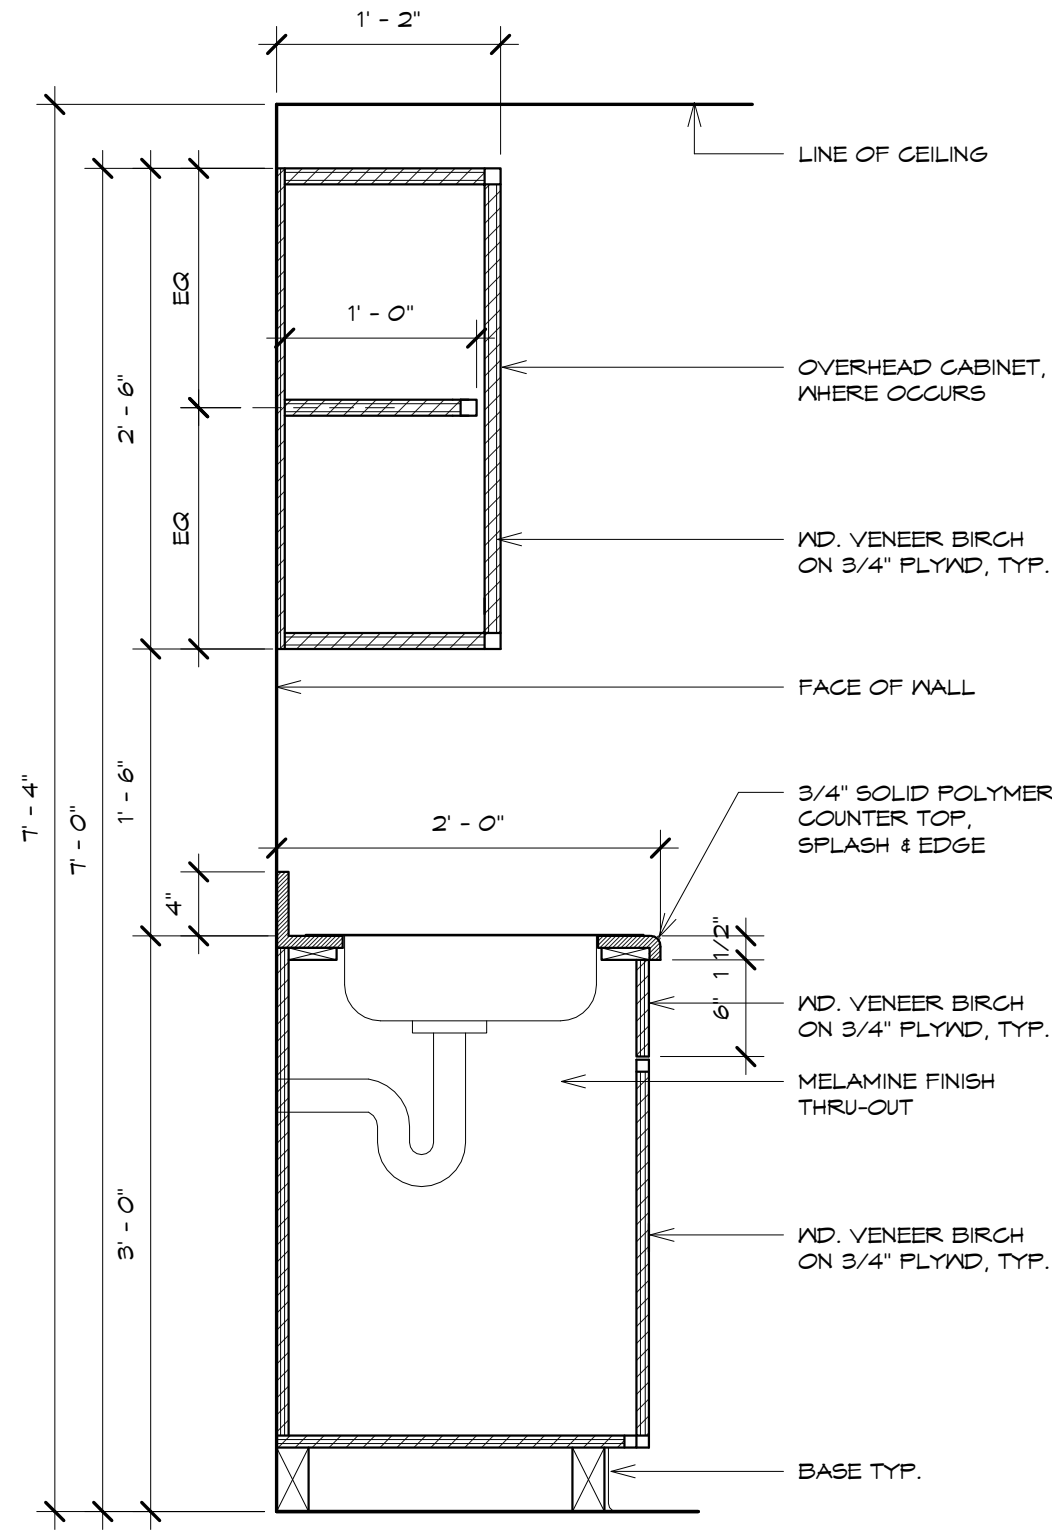


2 CABINET DETAIL
SCALE: 1" = 1'-0"

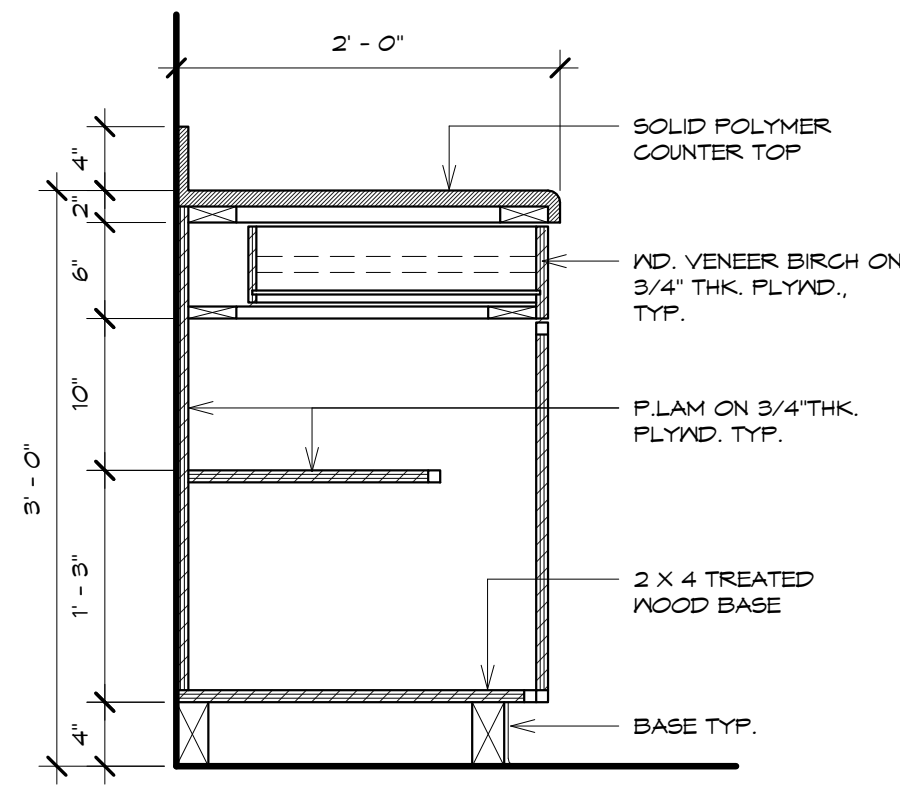

3 CABINET DETAIL
SCALE: 1" = 1'-0"

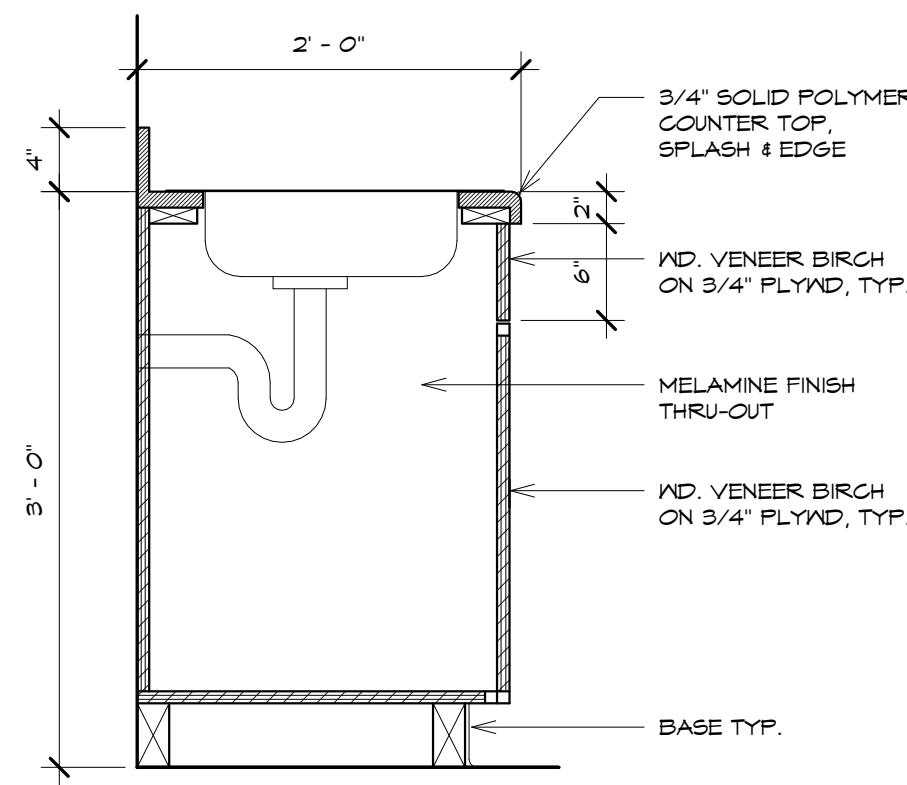

4 CABINET DETAIL
SCALE: 1" = 1'-0"

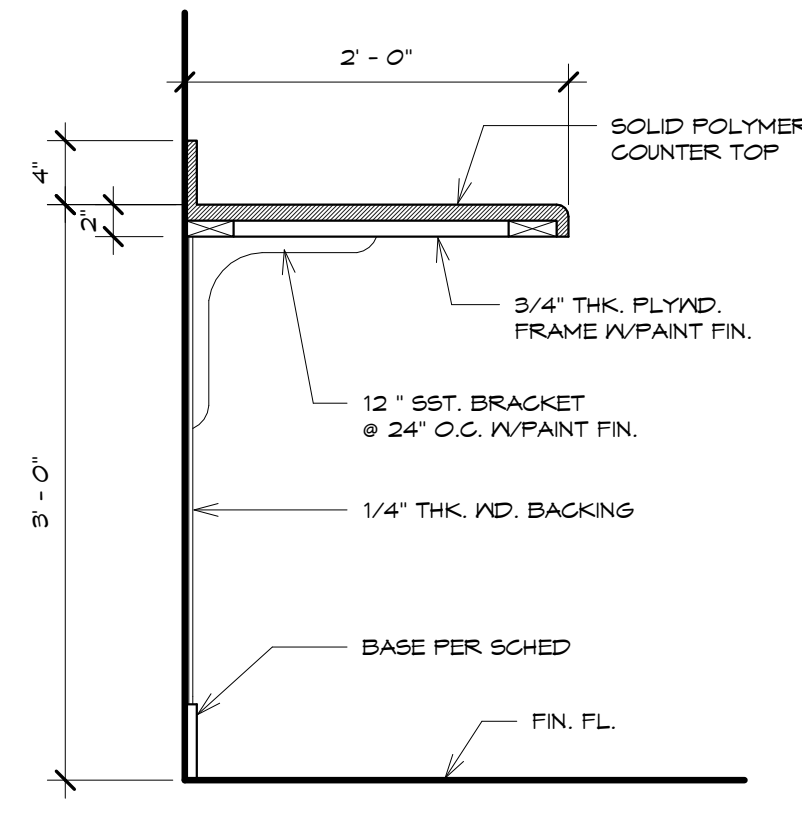

5 CABINET DETAIL
SCALE: 1" = 1'-0"

REVISIONS		
No.	Description	Date

TRMA
Taniguchi Ruth Makio Architects
100 Cliff Business Center, P.O. Box EA, Agaña, GU 96910
Tel.: (671) 475-8772 • Fax: (671) 472-3381

Architecture
Planning
Interior Design

**BID
DOCUMENTS**



I HEREBY CERTIFY THAT THIS PLAN WAS PREPARED
BY ME OR UNDER MY DIRECT SUPERVISION
DATE: _____


Project:
**GUAM COMMUNITY
COLLEGE
FORENSIC DNA LAB**

Title:
CASEWORK DETAILS


Designed: **TRMA**
Drawn: **RM/TP**
Checked: **CTC**
Supv: **MMM**
Scale: **1" = 1'-0"**
Date: **12/17/12**
Project No. **1026** File
Drawing No.

A12.1
Sheet No. _____ of _____


IF SHEET IS LESS THAN 24" X 36"
REDUCED PRINT - USE GRAPHIC SCALES

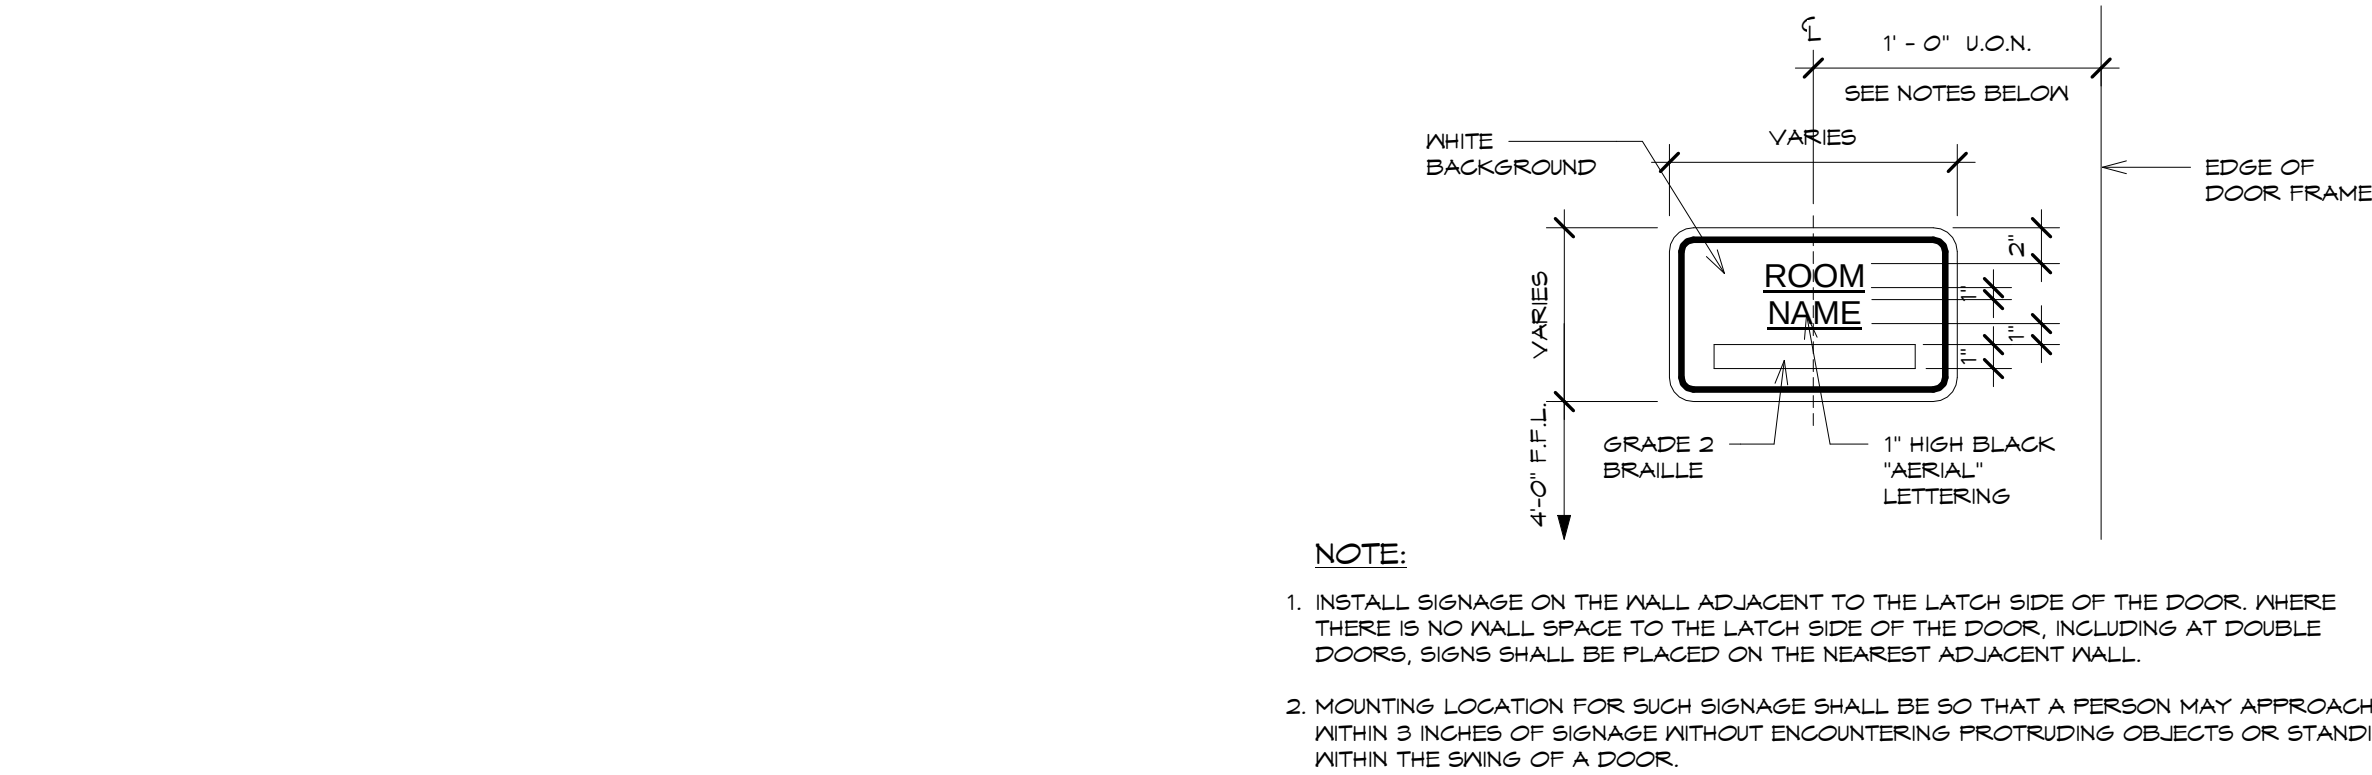


F ROOM IDENTIFICATION
SCALE: 1 1/2" = 1'-0"

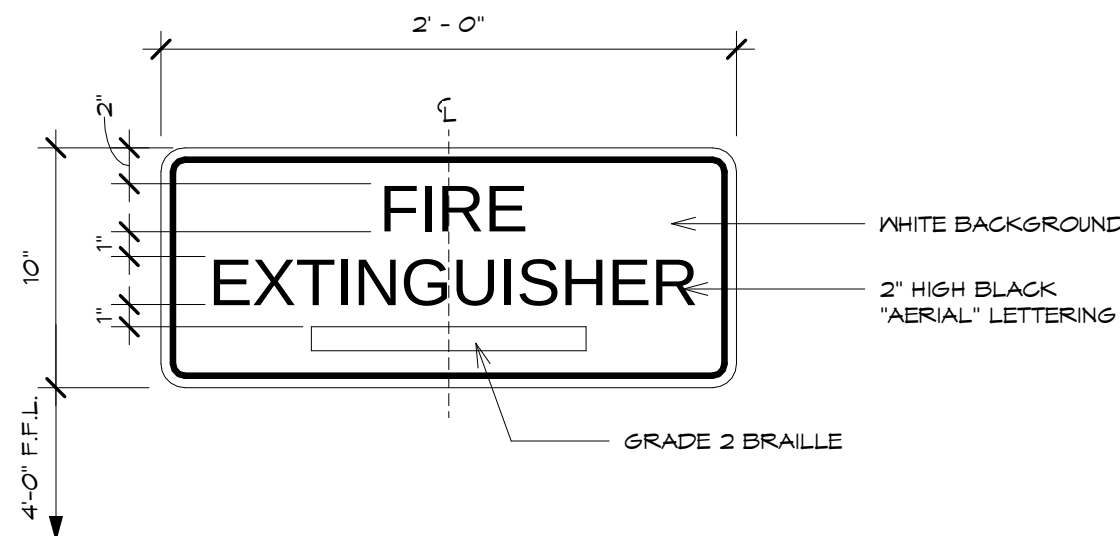


B FIRE EQUIPMENT IDENTIFICATION
SCALE: 1 1/2" = 1'-0"

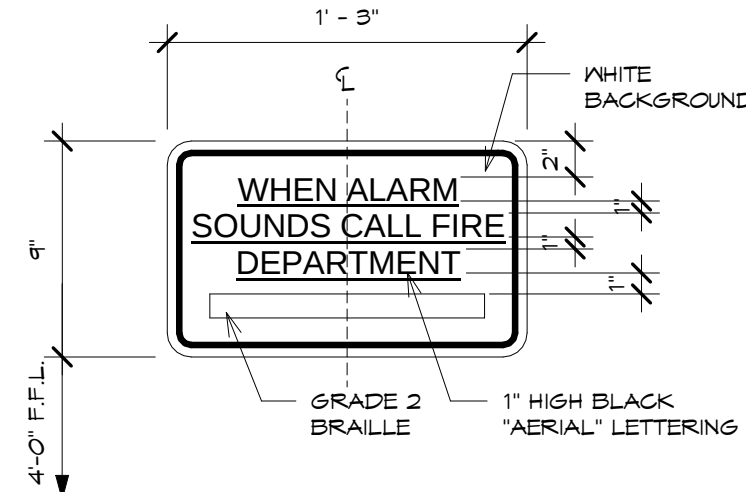


C MANUAL FIRE ALARM BOXES
SCALE: 1 1/2" = 1'-0"

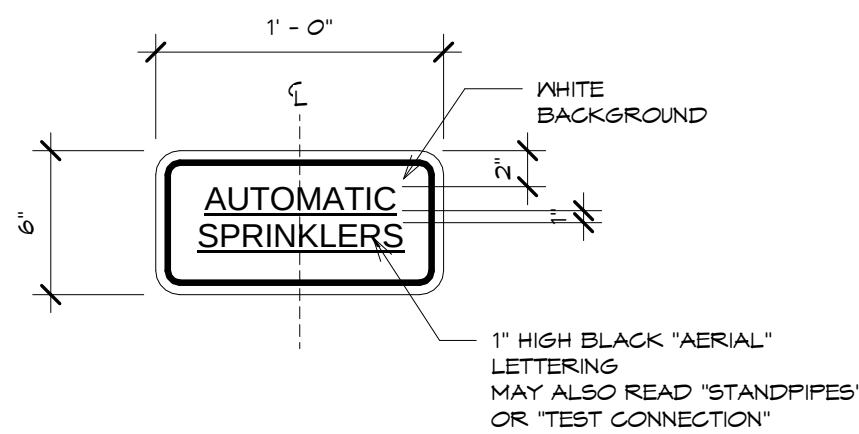


D FIRE DEPARTMENT CONNECTION
SCALE: 1 1/2" = 1'-0"

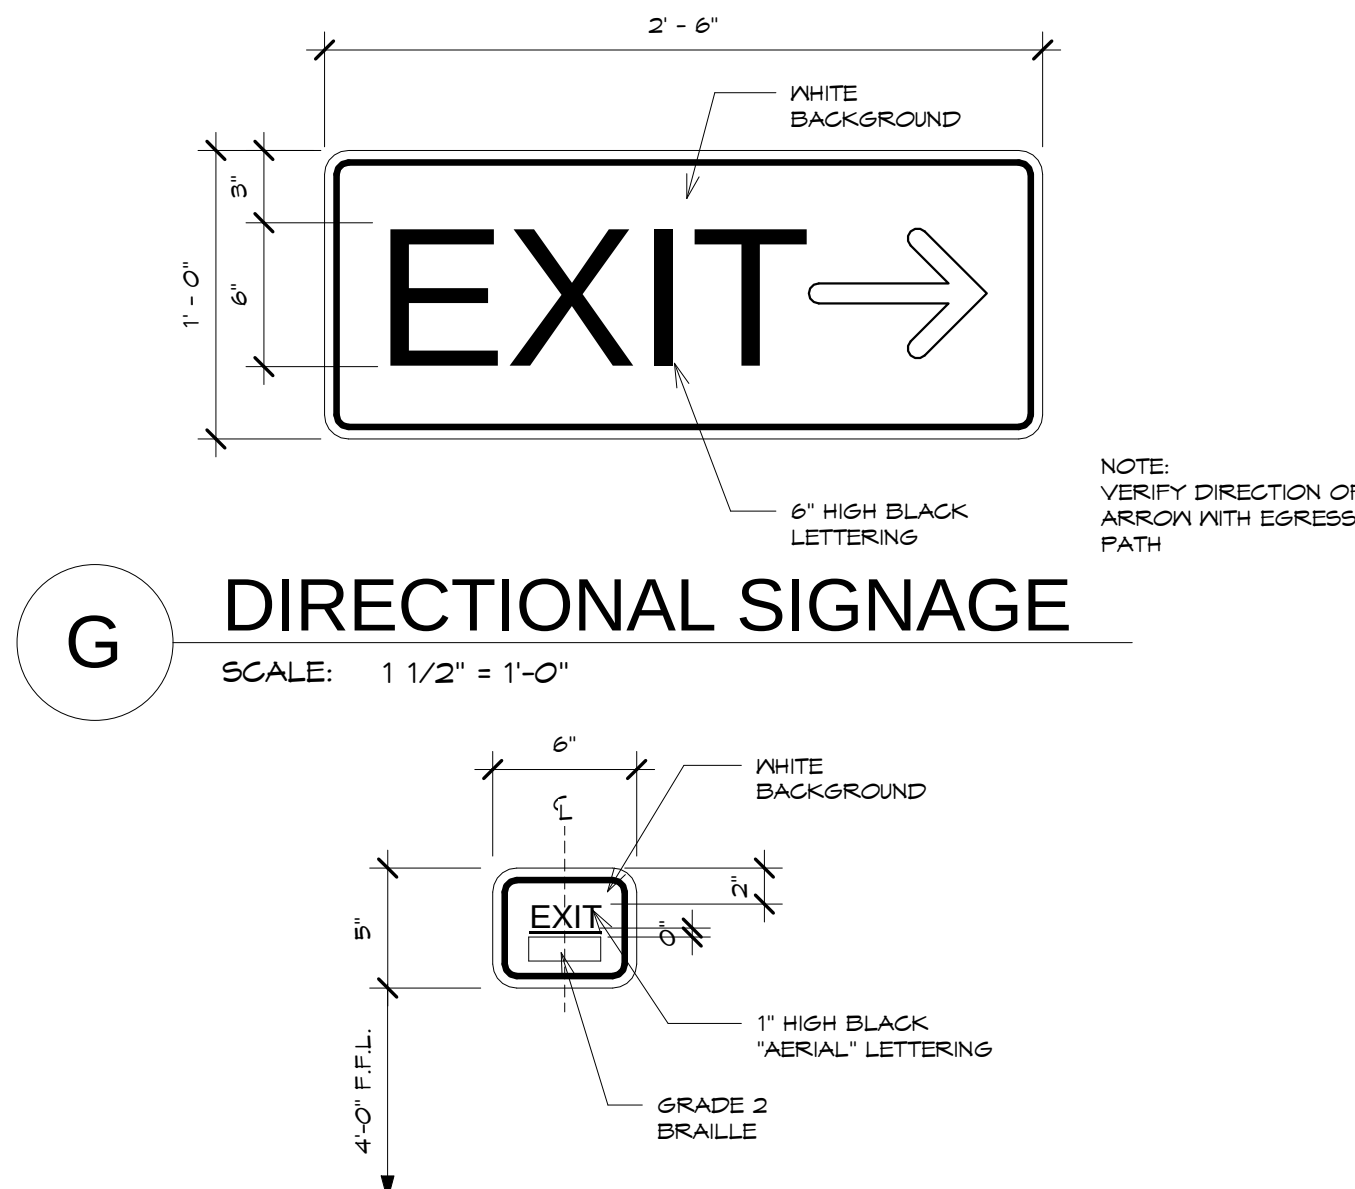


G DIRECTIONAL SIGNAGE
SCALE: 1 1/2" = 1'-0"

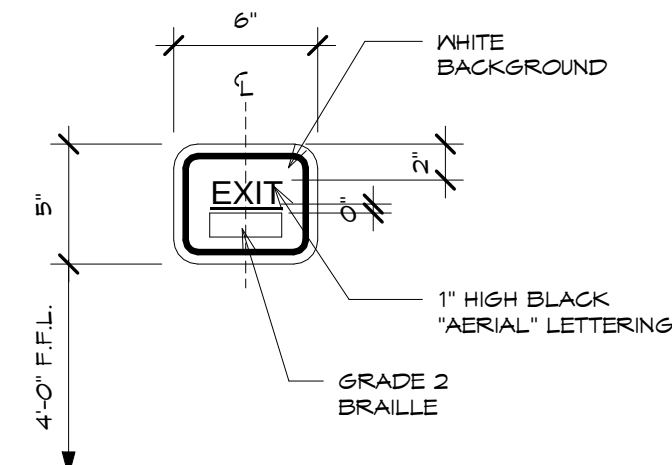


H TACTILE EXIT SIGNS
SCALE: 1 1/2" = 1'-0"

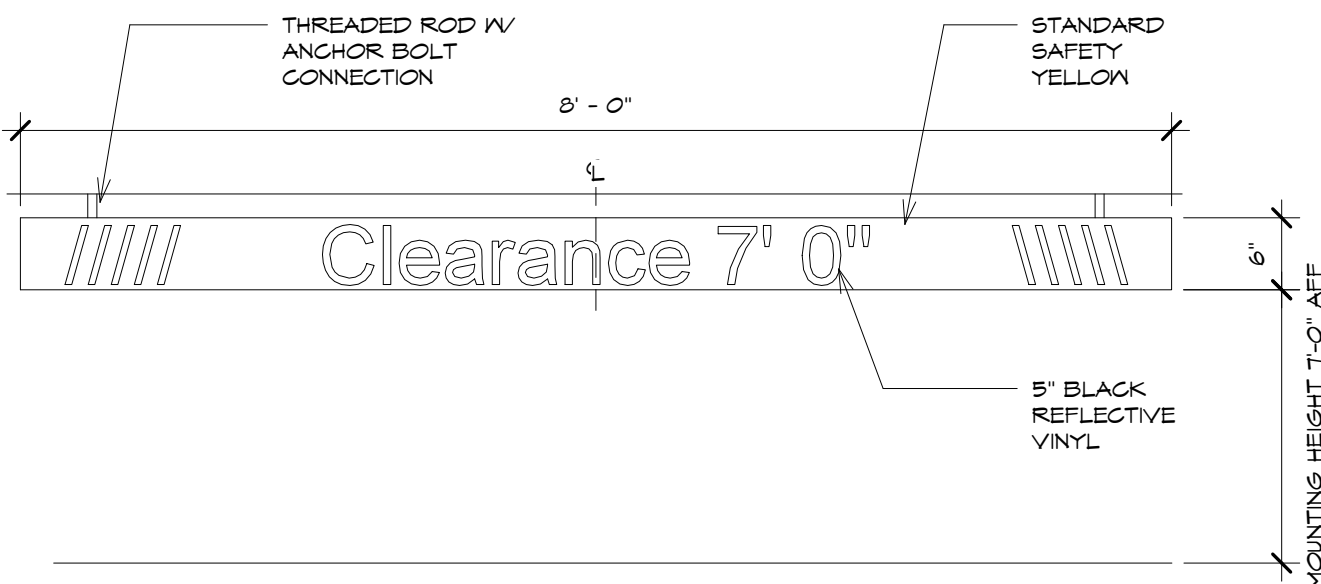


I CLEARANCE
SCALE: 3/4" = 1'-0"

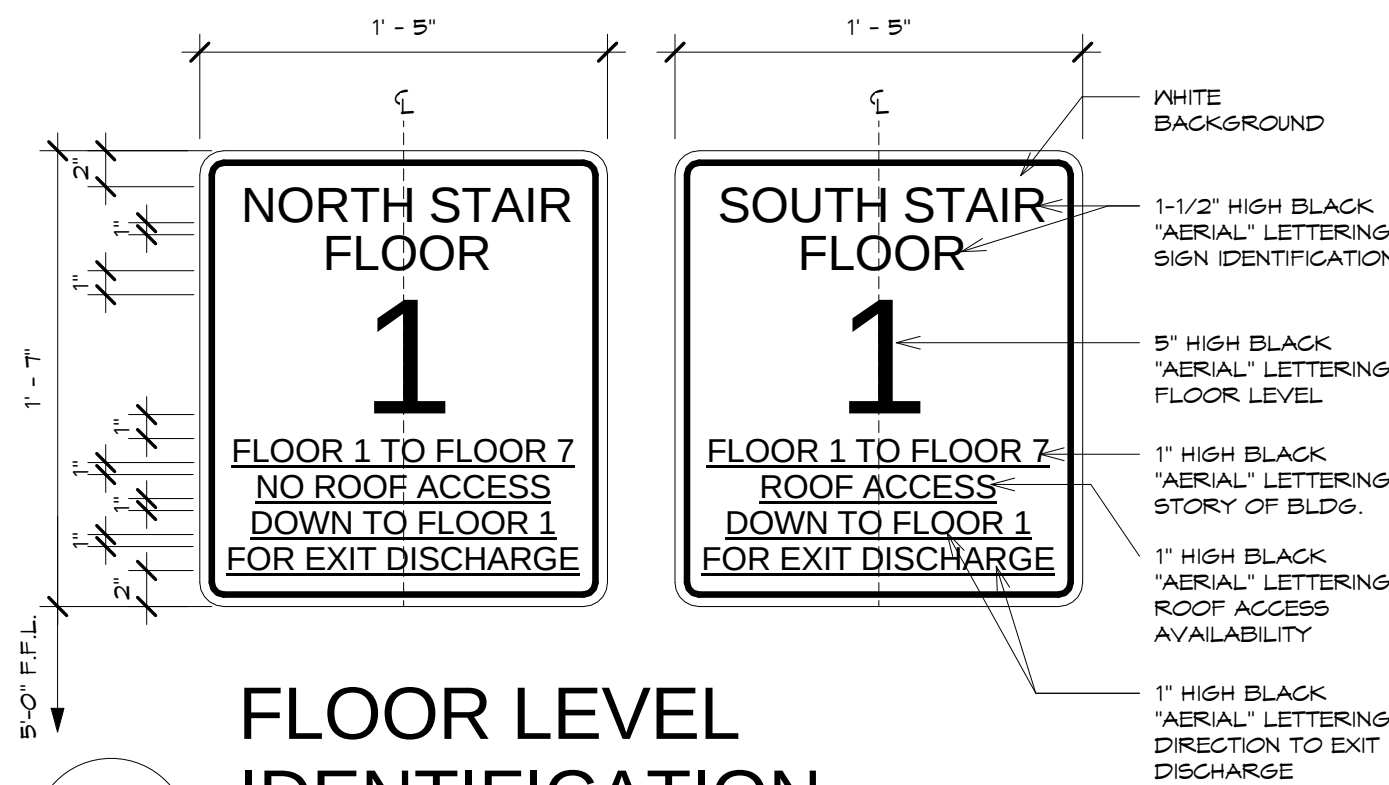


J FLOOR LEVEL IDENTIFICATION
SCALE: 1 1/2" = 1'-0"

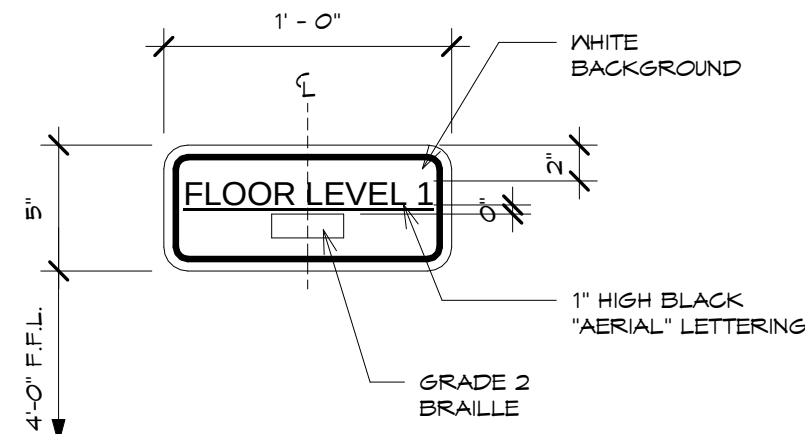


K FLOOR LEVEL TACTILE SIGN
SCALE: 1 1/2" = 1'-0"

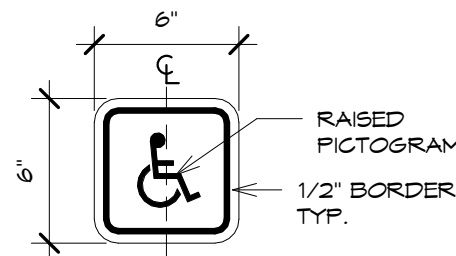

L INTERNATIONAL SYMBOL OF ACCESSIBILITY
SCALE: 1 1/2" = 1'-0"

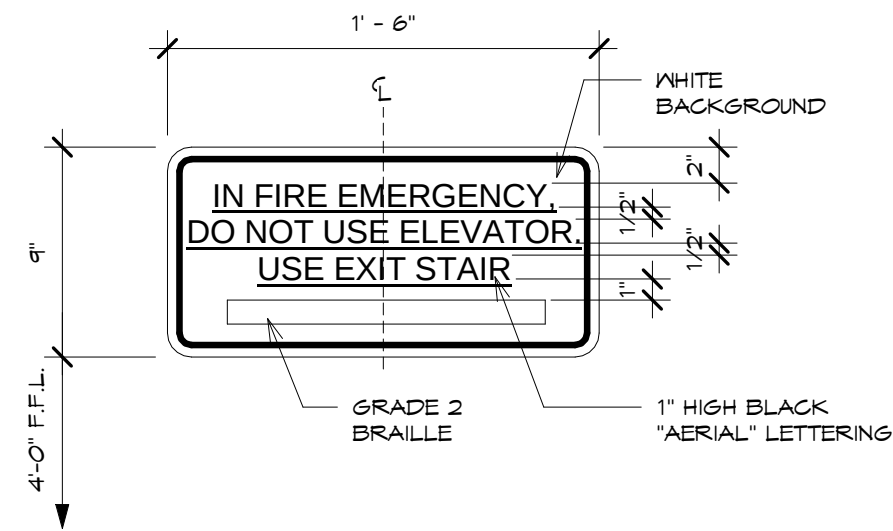

M EMERGENCY SIGN
SCALE: 1 1/2" = 1'-0"

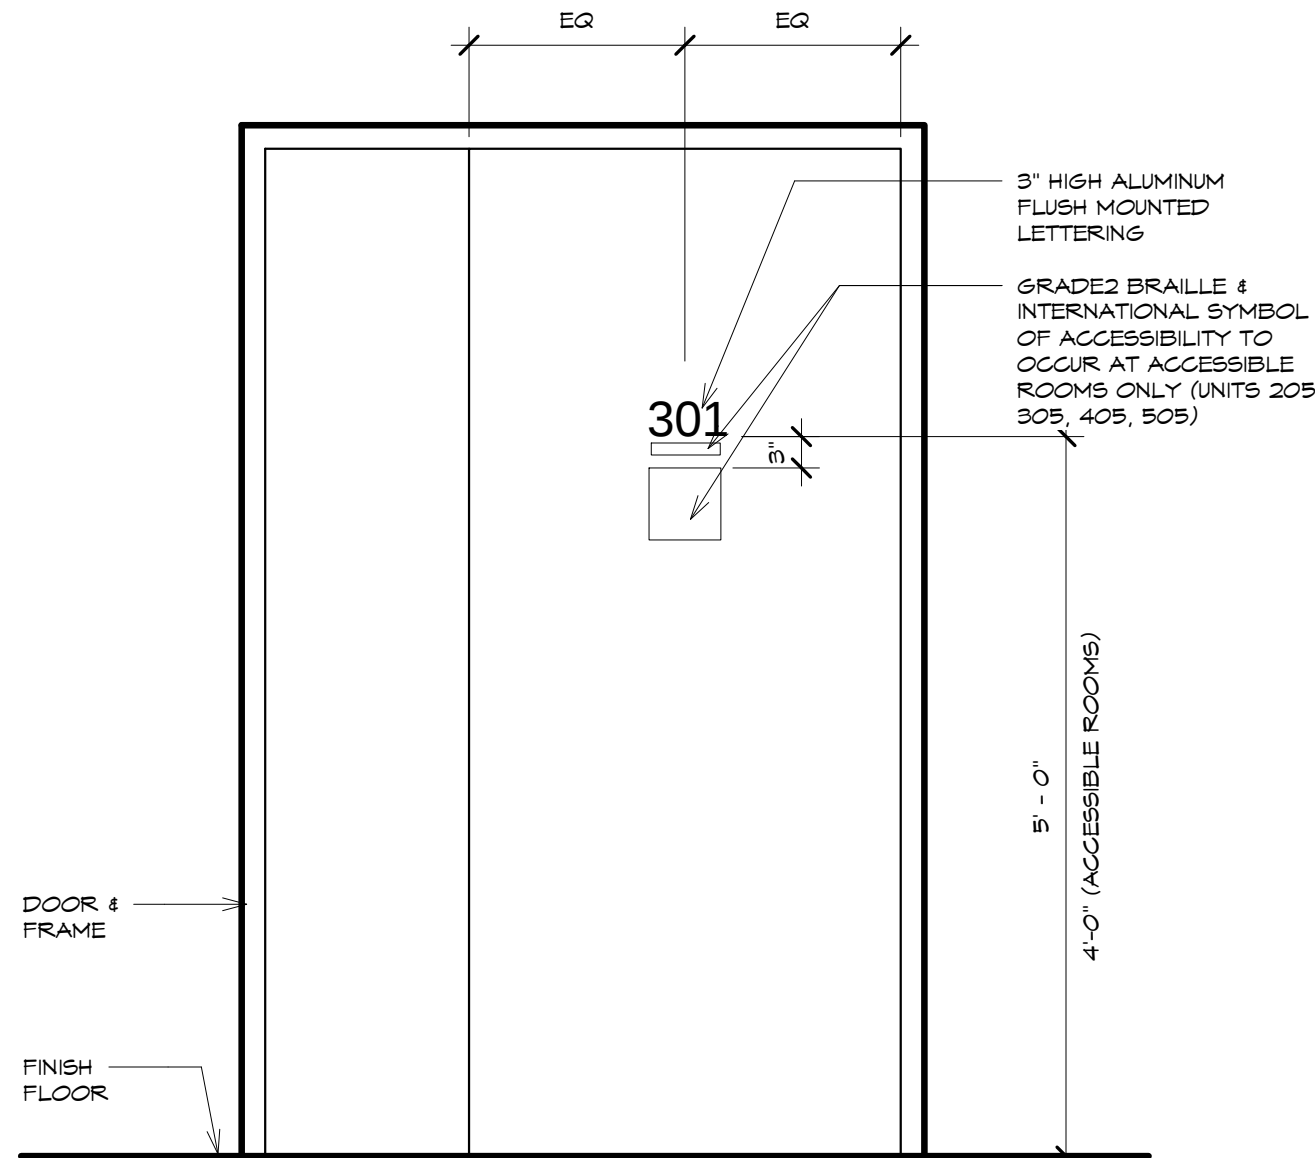

N TYP. APT. NUMBER
SCALE: 3/4" = 1'-0"

GENERAL NOTES:

- LETTERS AND NUMBERS SHALL BE RAISED " UPPER CASE TEXT AND ACCOMPANIED WITH GRADE 2 BRAILLE STYLE OF ITS EQUIVALENT VERBIAGE/BRAILLE PERMANENT ROOM AND SPACE DESIGNATION. AT DOUBLE DOORS THAT SWING OUT, MOUNT SIGNAGE BEYOND THE SWING OF THE DOOR.
- THE CHARACTERS & BACKGROUND OF SIGNS SHALL BE EGGSHELL, MATTE, OR NON-GLARE FINISH AND SHALL CONTRAST WITH THEIR BACKGROUND AS SELECTED.
- SIGNAGE SHALL BE PROVIDED IN CONFORMANCE TO ROOM NAME INDICATED ON ROOM FINISH SCHEDULE

REVISIONS		
No.	Description	Date

TRMA
Taniguchi Ruth Makio Architects
100 Cliff Business Center, P.O. Box EA, Agaña, GU 96910
Tel.: (671) 475-8772 • Fax: (671) 472-3381

Architecture
Planning
Interior Design

**BID
DOCUMENTS**




Project:
GUAM COMMUNITY
COLLEGE
FORENSIC DNA LAB


Title:
SIGNAGE DETAILS

Designed: **TRMA**
Drawn: **RM/TP**
Checked: **CTC**
Supv: **MM**
Scale: **As indicated**
Date: **11/28/12**
Project No. **1026**
Drawing No.


A13.1
Sheet No. _____ of _____

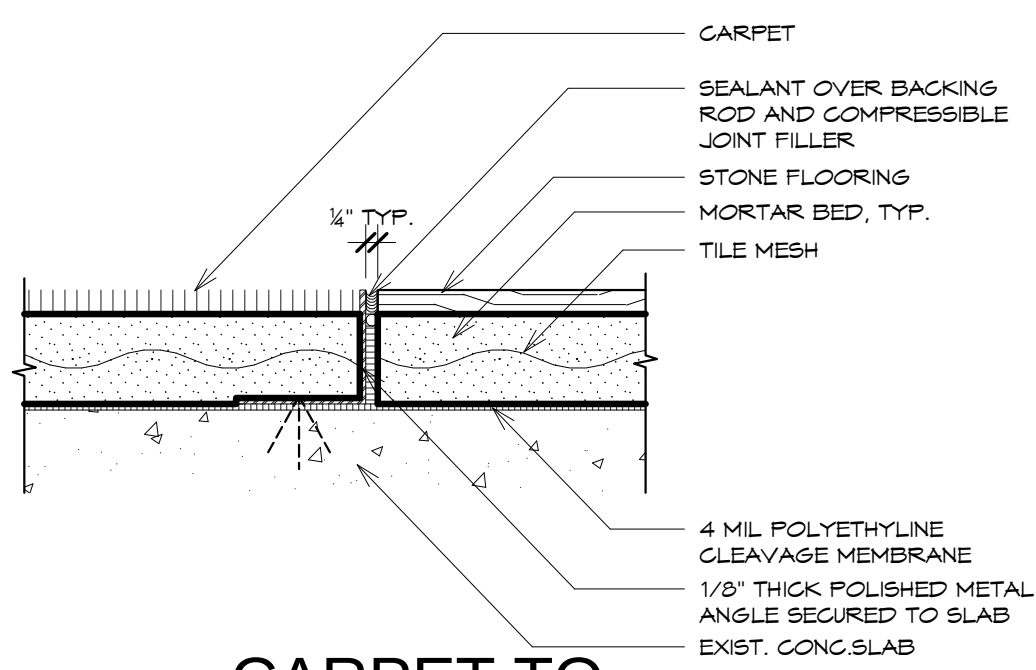


1 CARPET TO STONE
SCALE: 3" = 1'-0"

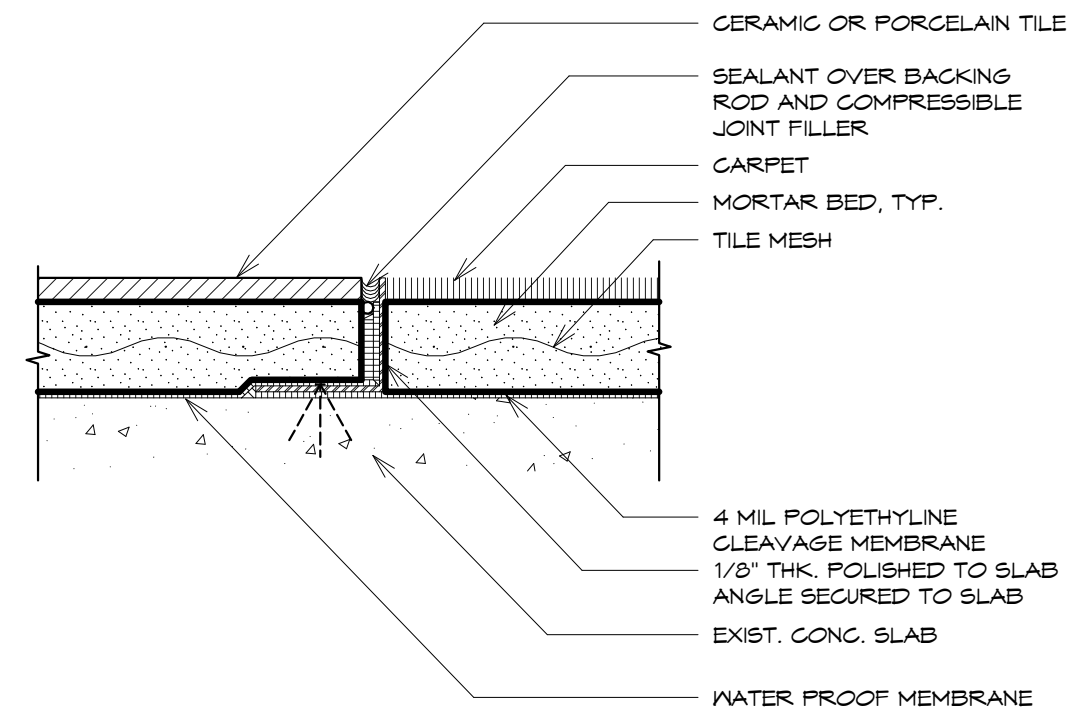


2 TILE TO CARPET
SCALE: 3" = 1'-0"

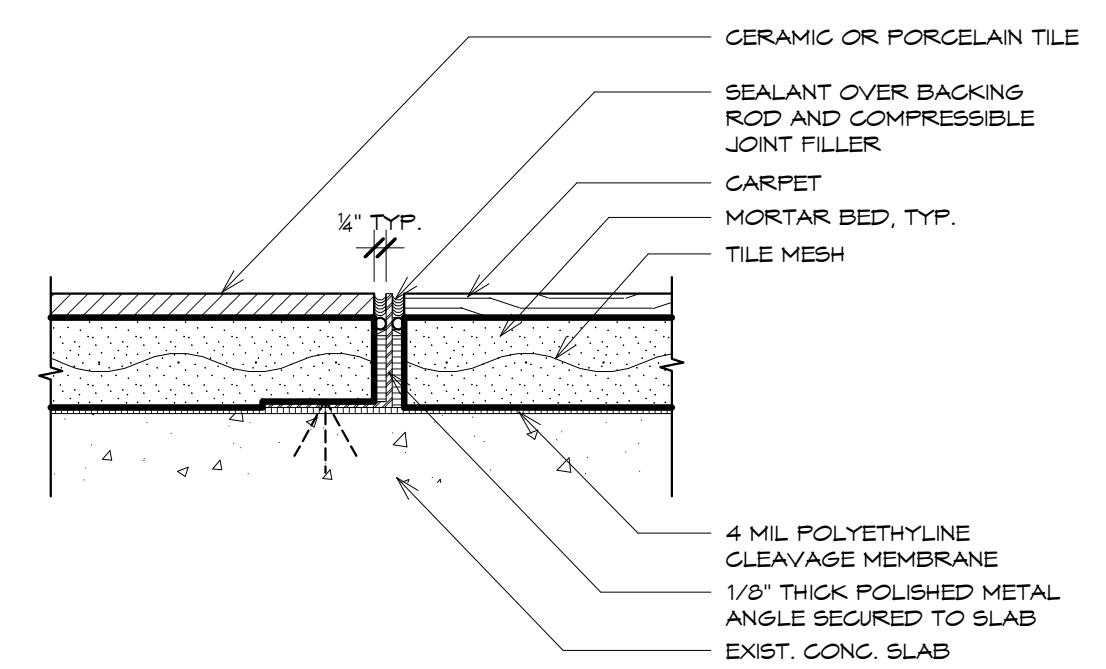



3 TILE TO STONE
SCALE: 3" = 1'-0"

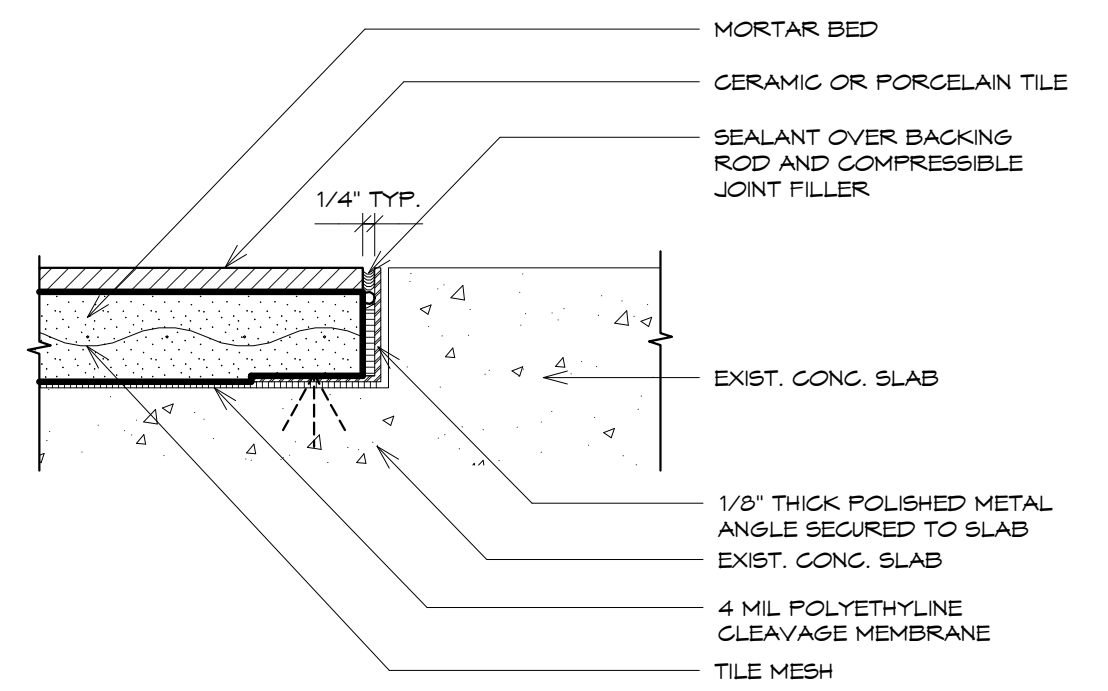

4 TILE TO TENANT SPACE
SCALE: 3" = 1'-0"

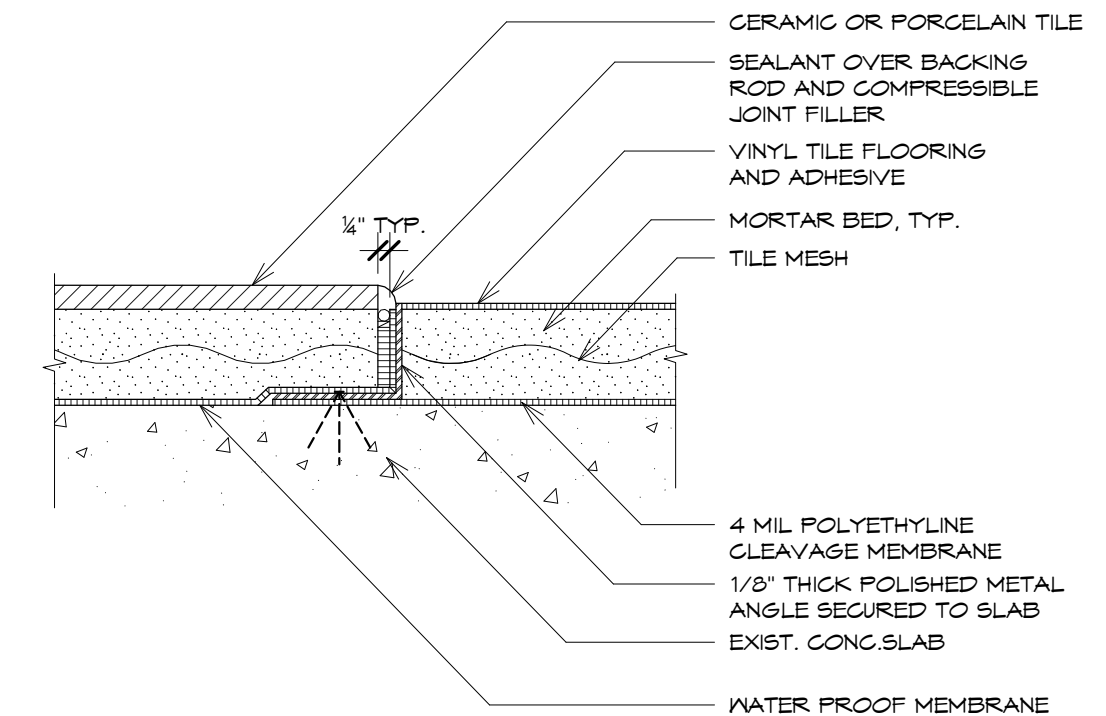

5 TILE TO VINYL
SCALE: 3" = 1'-0"

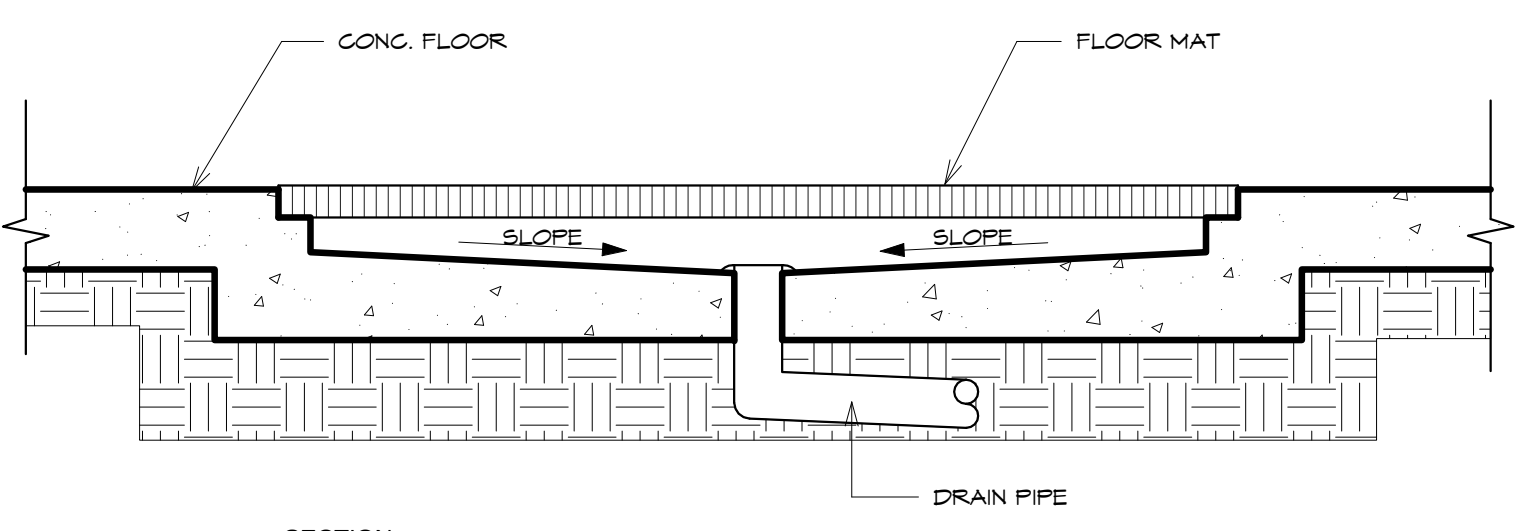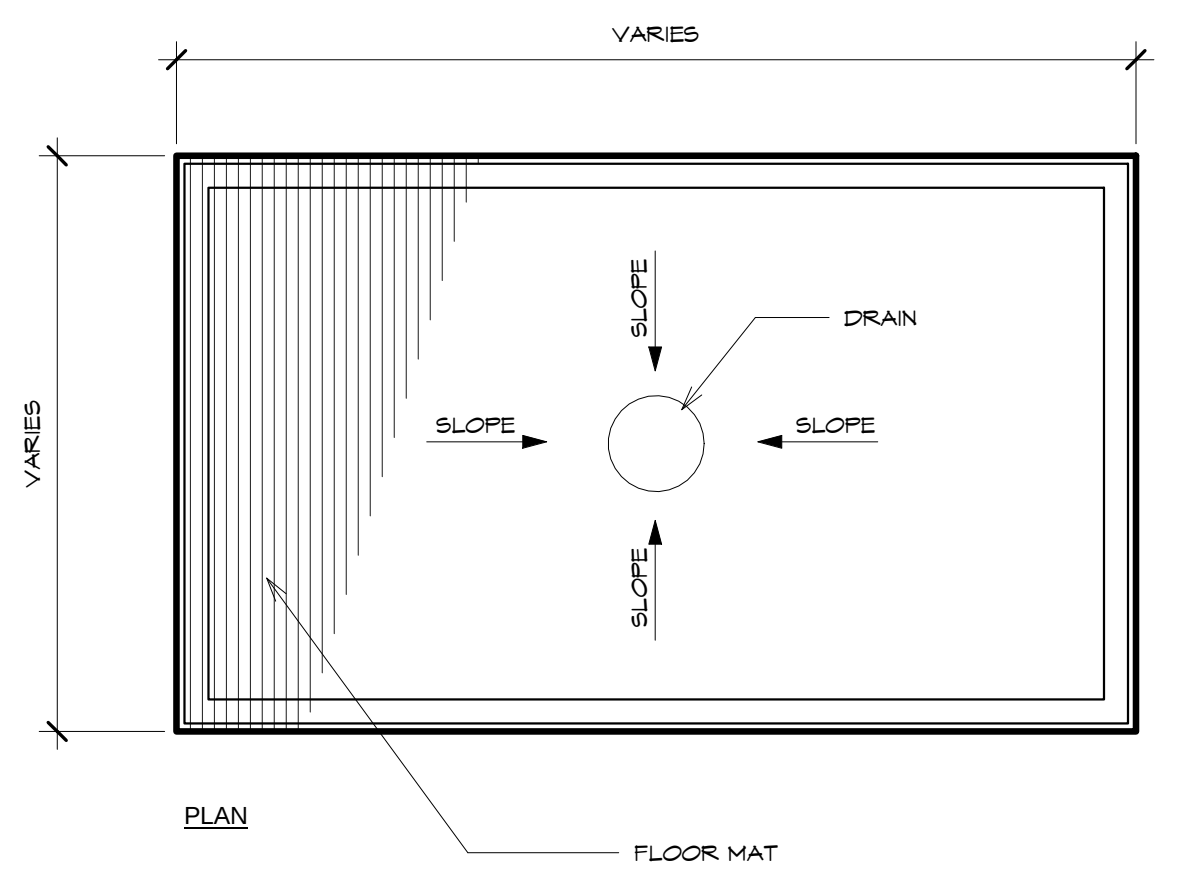

6 FLOOR MAT & DRAIN
SCALE: 1" = 1'-0"

REVISIONS		
No.	Description	Date

TRMA
Taniguchi Ruth Makio Architects
100 Cliff Business Center, P.O. Box 6A, Agaña, GU 96910
Tel.: (671) 475-8772 • Fax: (671) 472-3381

Architecture
Planning
Interior Design

BID DOCUMENTS

I HEREBY CERTIFY THAT THIS PLAN WAS PREPARED BY ME OR UNDER MY DIRECT SUPERVISION.
DATE: _____


Project:
**GUAM COMMUNITY COLLEGE
FORENSIC DNA LAB**

Title:
FLOOR DETAILS

Designed: **Designer**
Drawn: **Author**
Checked: **Checker**
Supv: **Approver**
Scale: **As indicated**
Date: **01/22/10**
Project No. **1026** File
Drawing No.


A14.1
Sheet No. _____ of _____

IF SHEET IS LESS THAN 24" X 36"
REDUCED PRINT - USE GRAPHIC SCALES

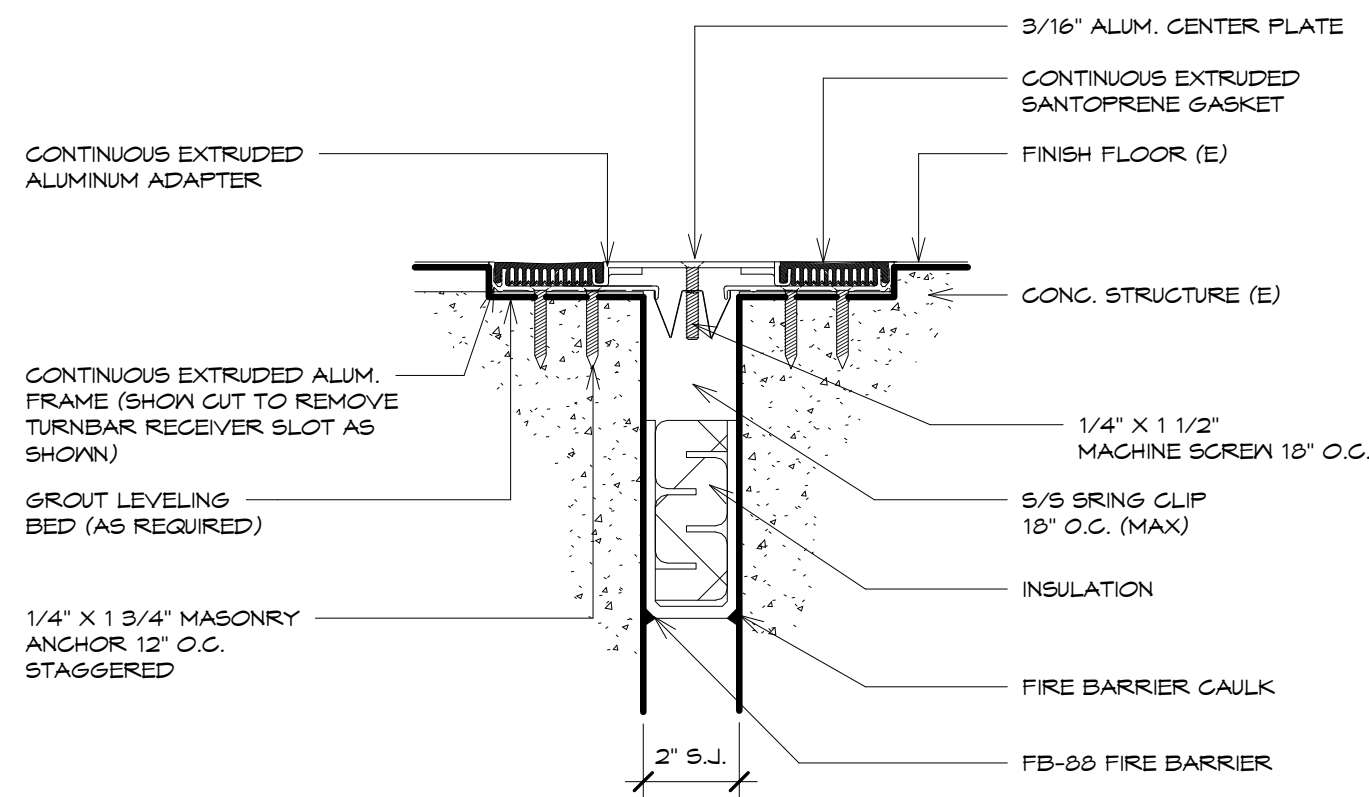


1 FLOOR TO FLOOR COVER

SCALE: 3" = 1'-0"

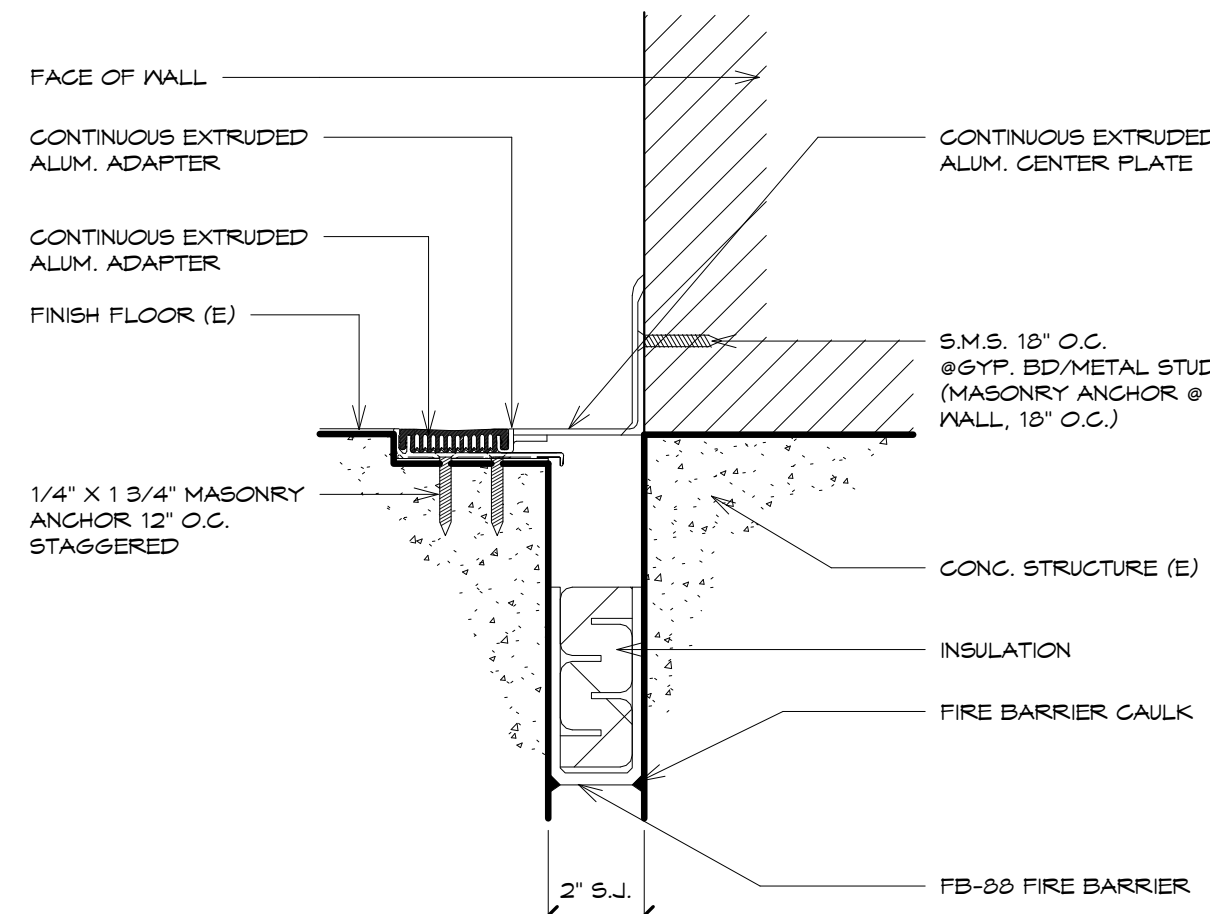


2 FLOOR TO WALL COVER 2

SCALE: 3" = 1'-0"

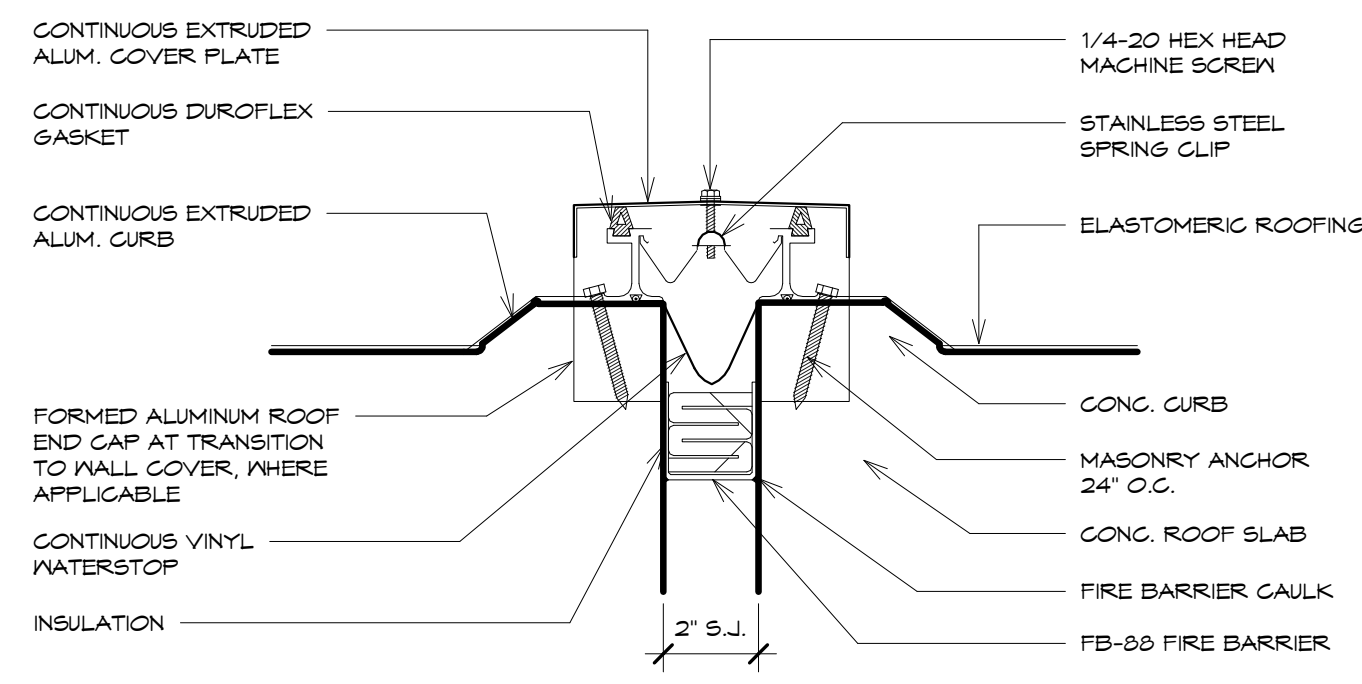


3 ROOF COVERED

SCALE: 3" = 1'-0"

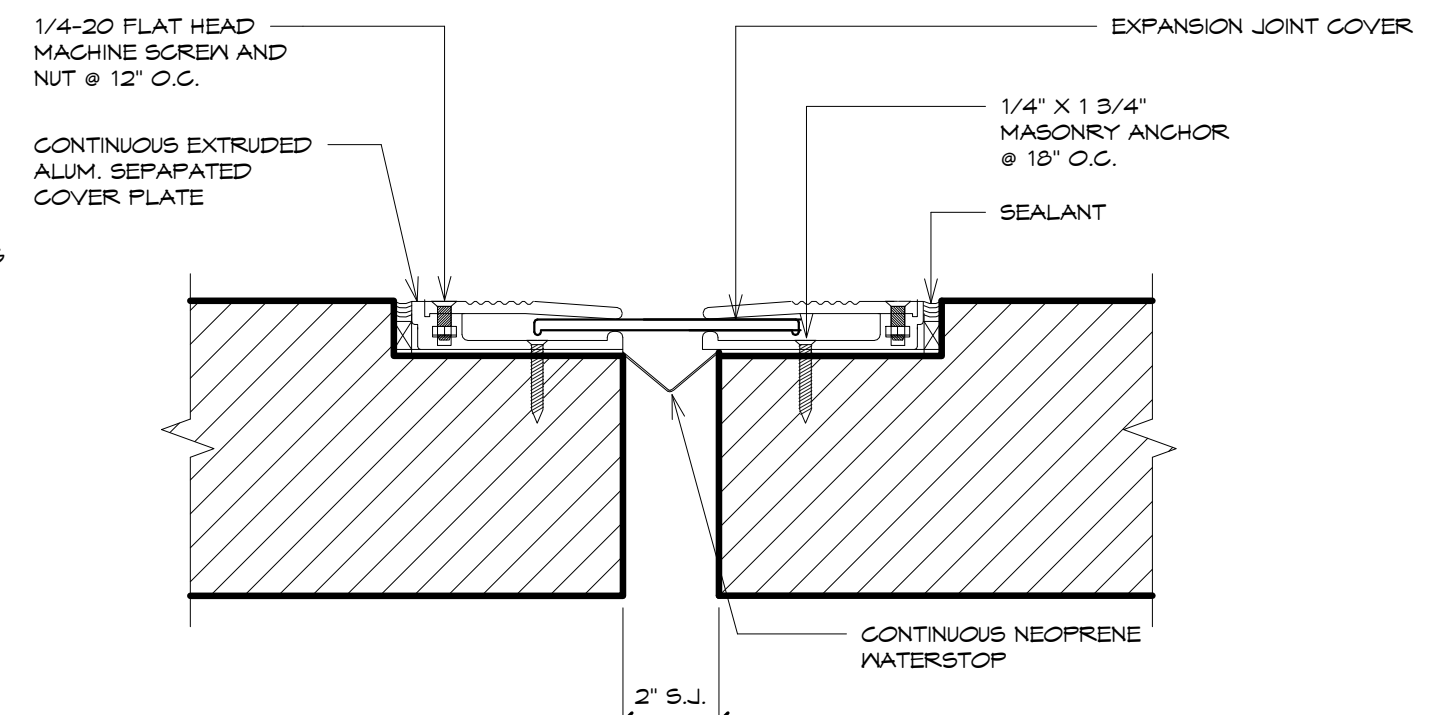


4 FLOOR TO FLOOR COVER 2

SCALE: 3" = 1'-0"

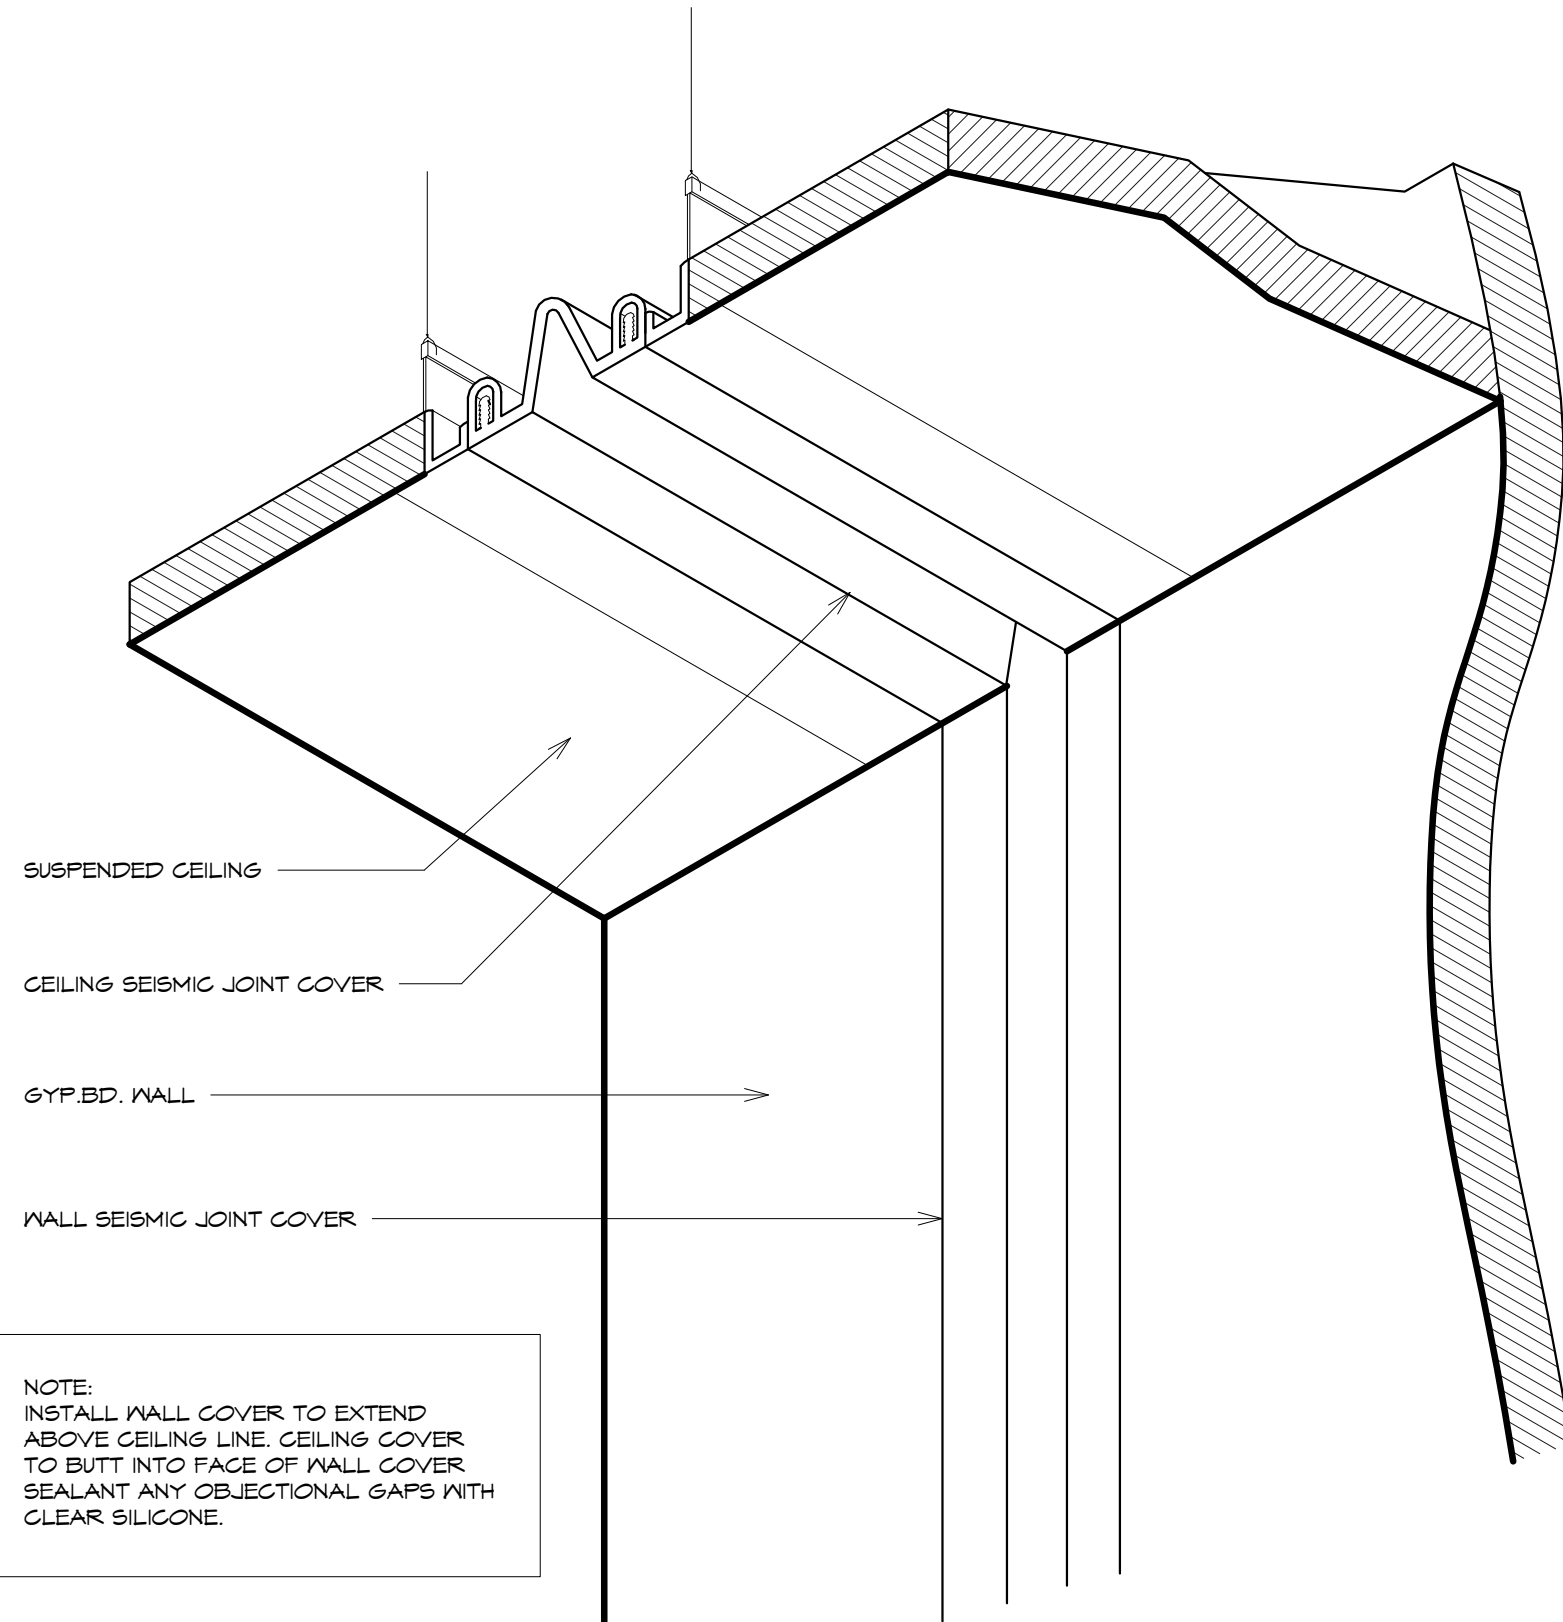


5 WALL TO CEILING COVER

SCALE: 3" = 1'-0"

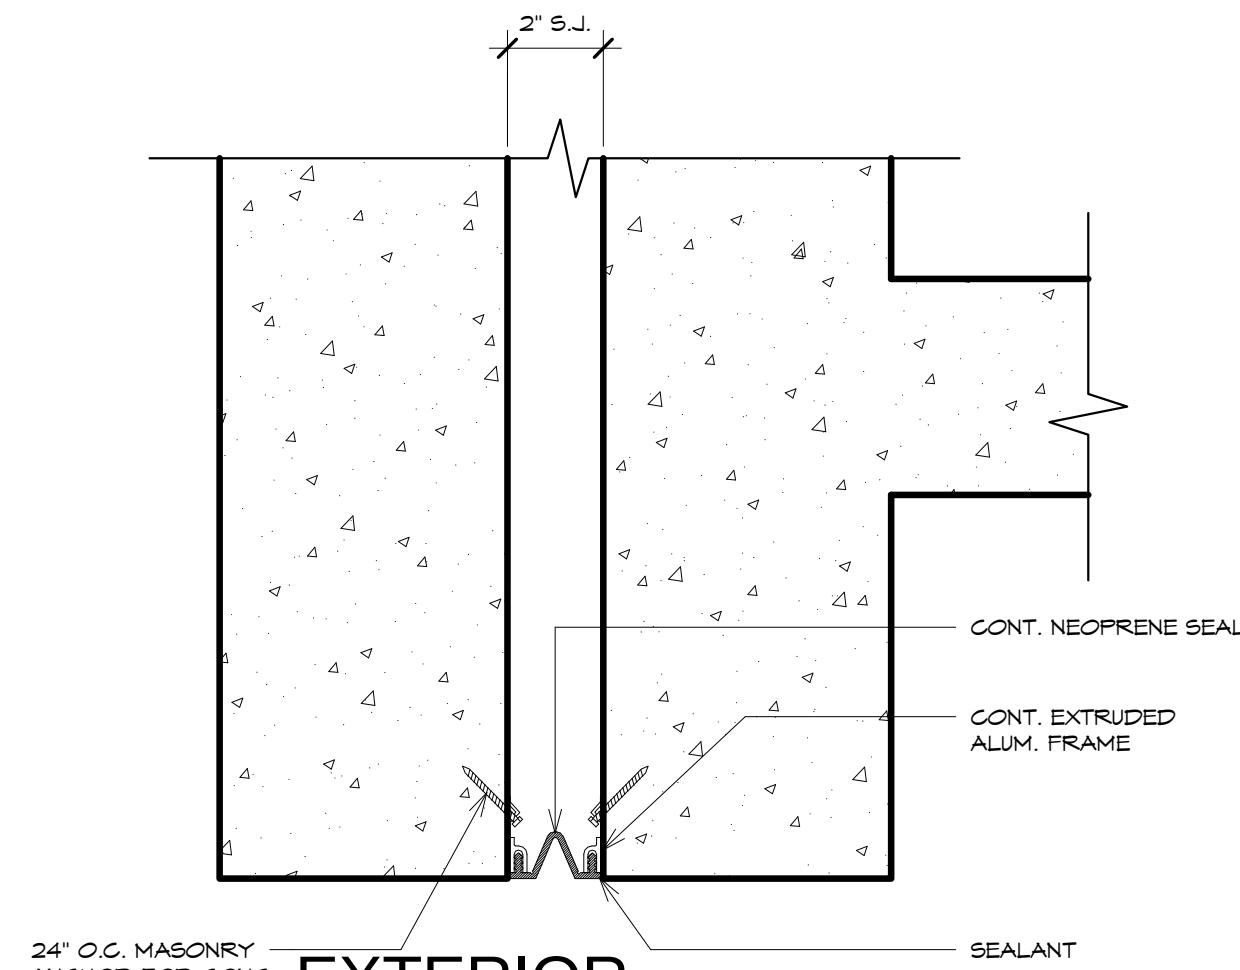


6 EXTERIOR CEILING

SCALE: 3" = 1'-0"

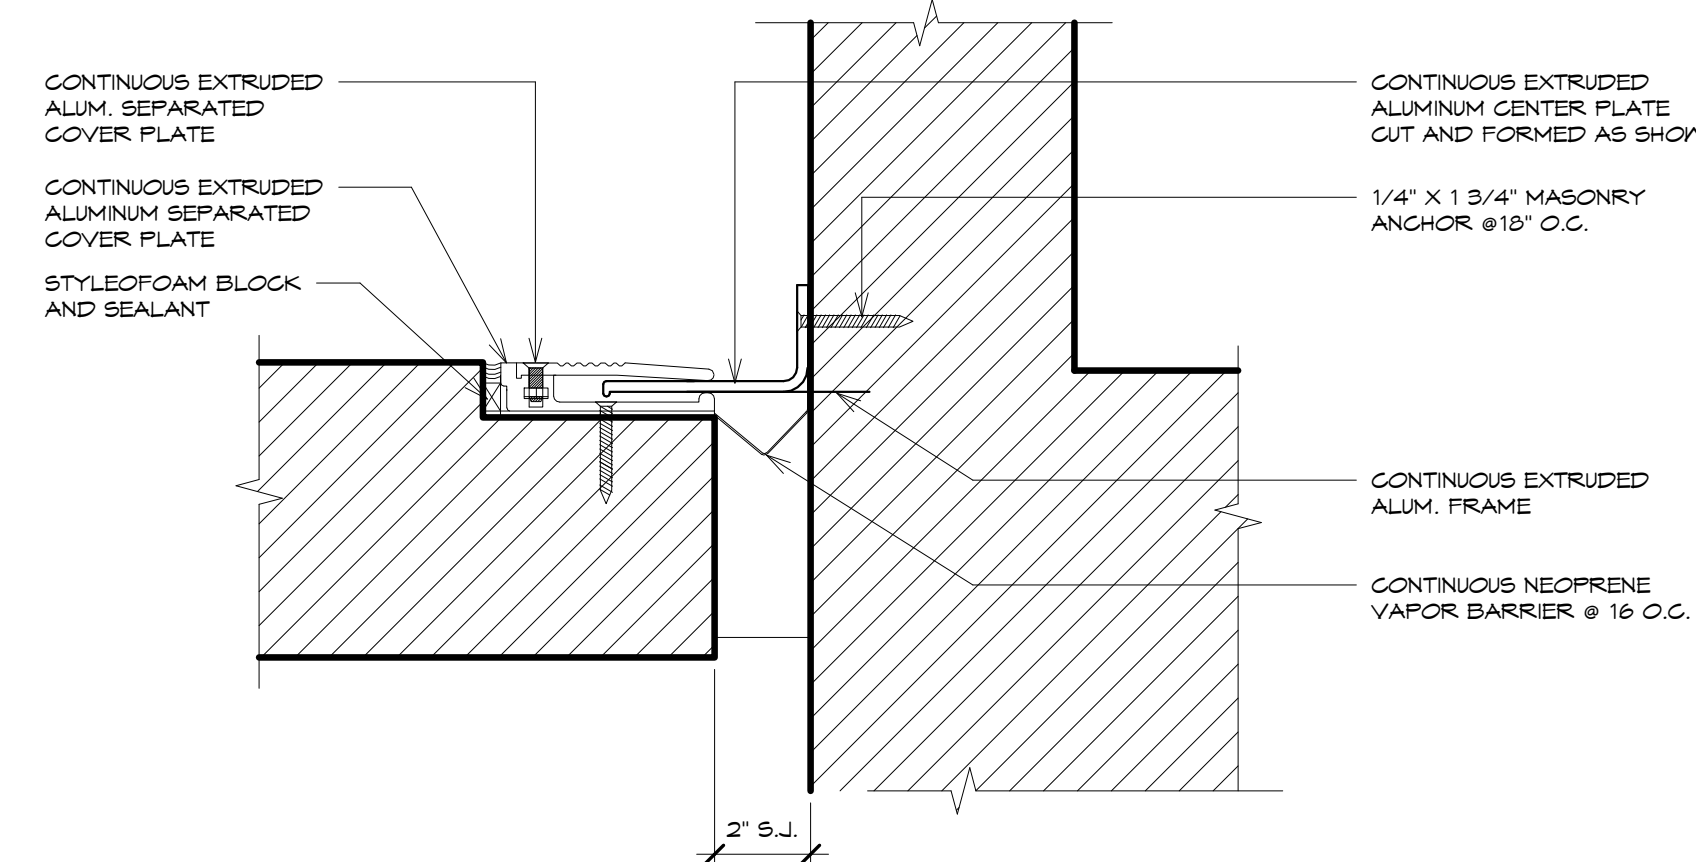

8 FLOOR TO WALL COVER

SCALE: 3" = 1'-0"

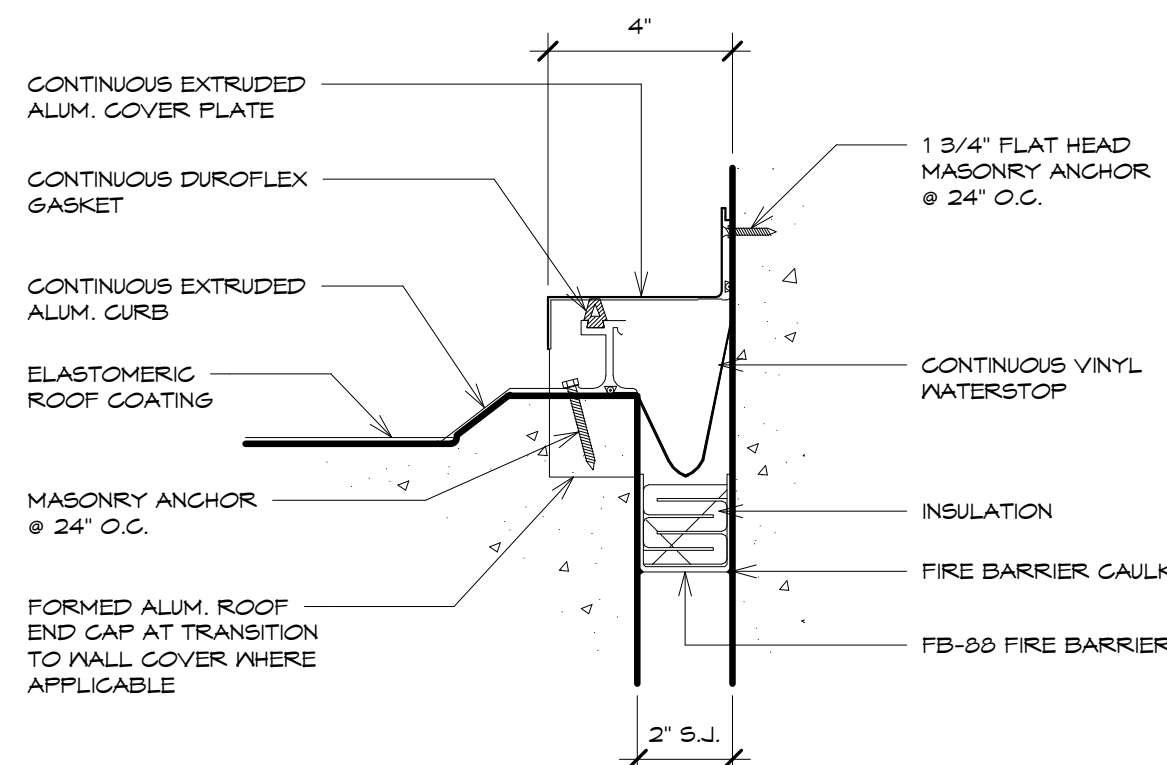

7 ROOF TO WALL COVER

SCALE: 3" = 1'-0"

REVISIONS		
No.	Description	Date

TRMA
Taniguchi Ruth Makio Architects
 100 Cliff Business Center, P.O. Box 6A, Agaña, GU 96910
 Tel.: (671) 475-8772 • Fax: (671) 472-3381

Architecture
 Planning
 Interior Design

BID DOCUMENTS

I HEREBY CERTIFY THAT THIS PLAN WAS PREPARED BY ME OR UNDER MY DIRECT SUPERVISION.

Project:
GUAM COMMUNITY COLLEGE
FORENSIC DNA LAB

Title:
EXPANSION DETAILS

Designed: **Designer**
 Drawn: **Author**
 Checked: **Checker**
 Supv: **Approver**
 Scale: **3" = 1'-0"**
 Date: **01/22/10**
 Project No. **1026** File
 Drawing No.

A15.1

Sheet No. _____ of _____

IF SHEET IS LESS THAN 24" X 36"
 REDUCED PRINT - USE GRAPHIC SCALES